


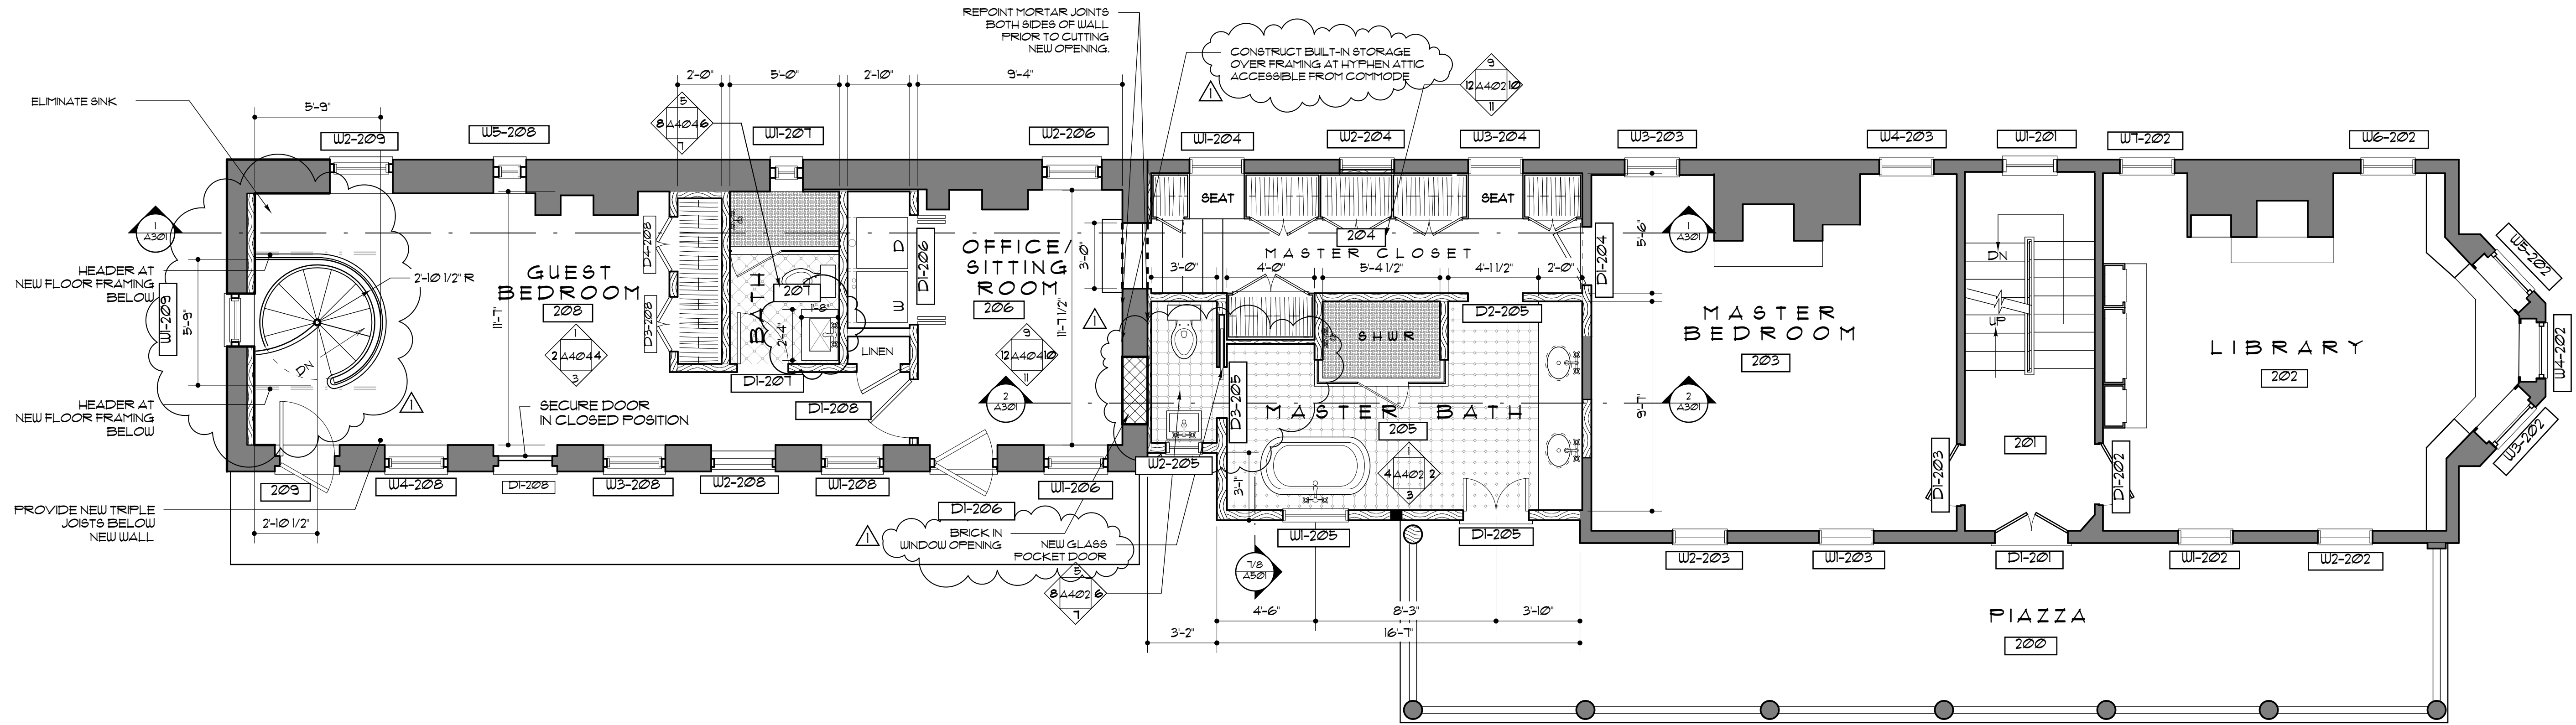


1
A102
SECOND FLOOR PLAN
SCALE: 1/8" = 1'-0"

REV.	DATE
2-15-17	
3-27-17	
5-10-17	
6-26-17	

PROJECT NUMBER 1414

DRAWING DATE 10/10/16

SHEET NUMBER
A102

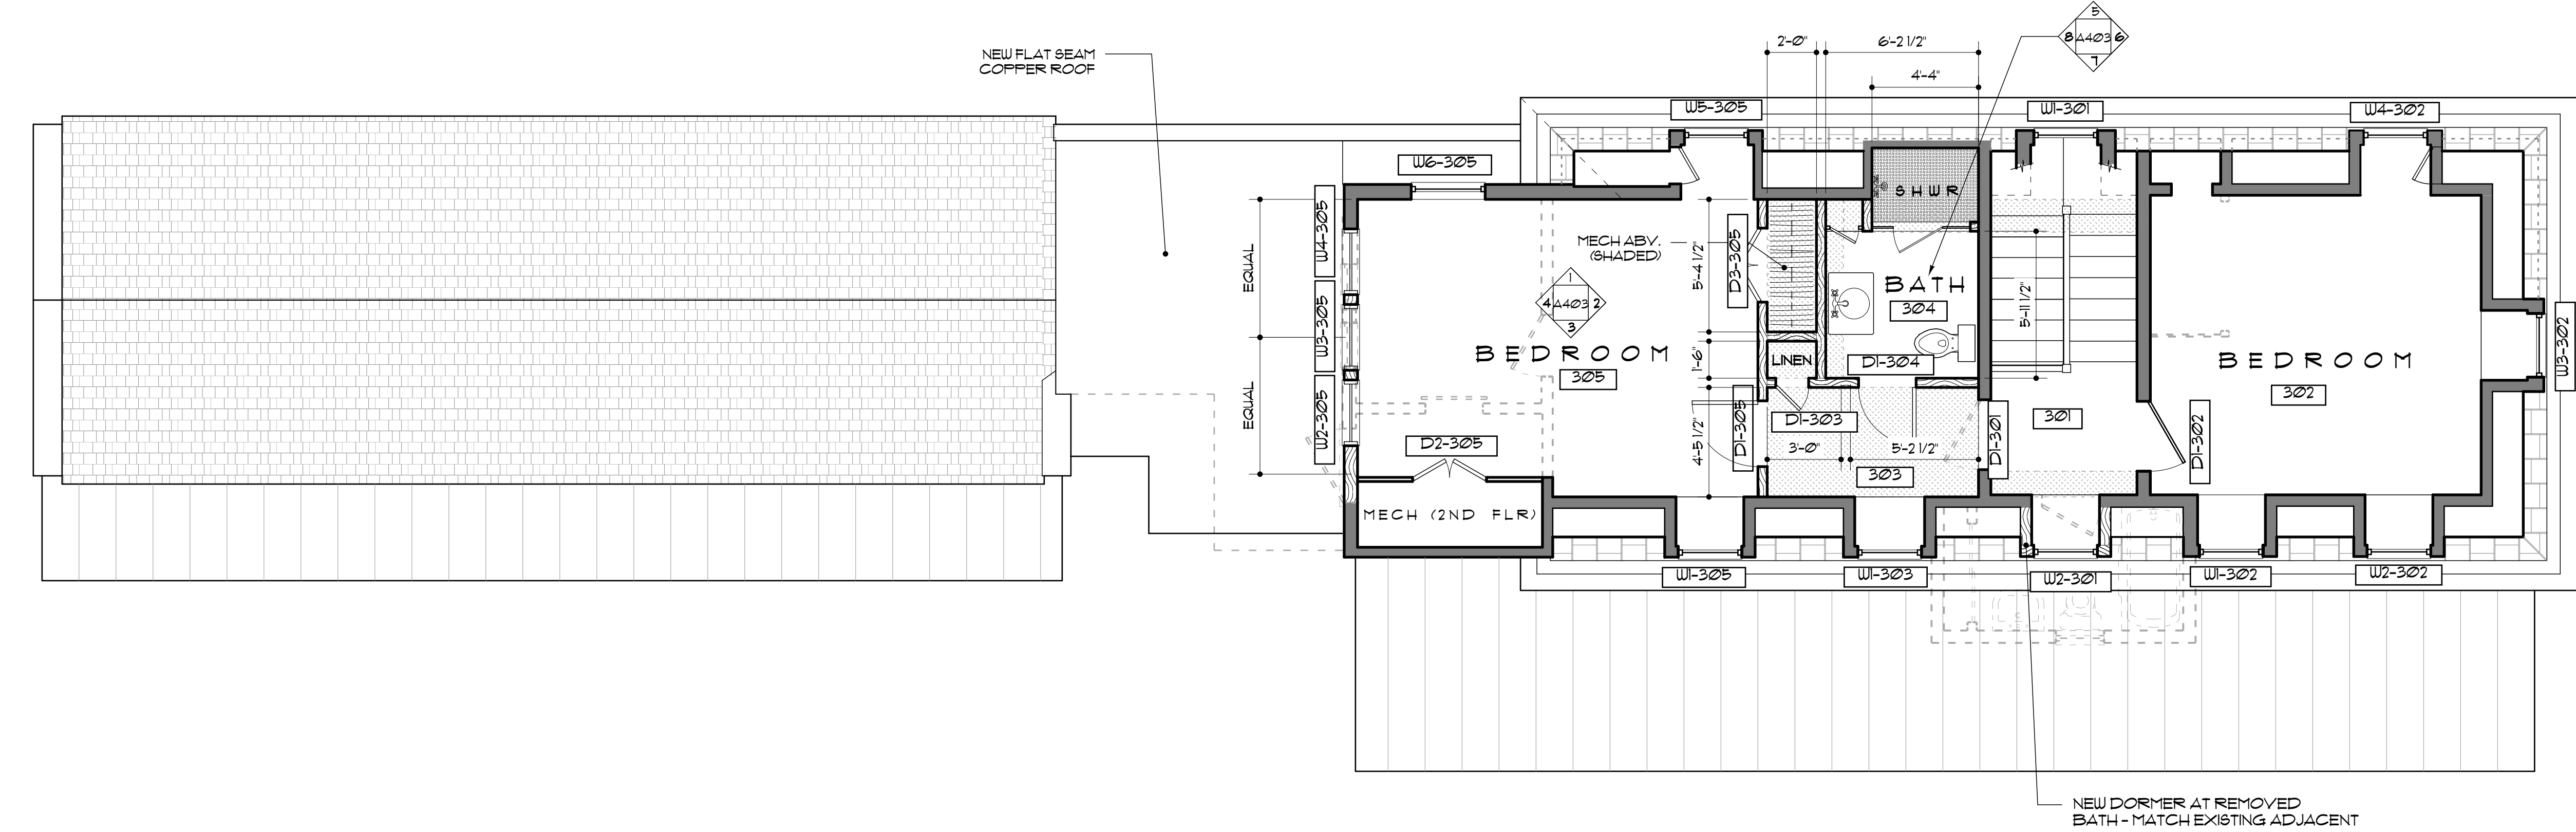

1 THIRD FLOOR PLAN
A103 SCALE: 1/8" = 1'-0"

THIRD FLOOR PLAN

A REHABILITATION OF
35 LEGARE STREET
THE ELIZABETH WILLIAMS HOUSE
C. 1790
CHARLESTON SC

REV.	DATE
△	2-15-17
△	3-27-17
△	5-10-17
△	6-26-17

PROJECT NUMBER 1414

DRAWING DATE 10/10/16

SHEET NUMBER
A103

Glenn Keyes
Architects

12 Vanderhorst Street
Charleston, SC 29403
(843) 722-4100
www.glennkeyesarchitects.com



1 EAST (FRONT) ELEVATION - PROPOSED
A201 SCALE: 1/4" = 1'-0"

Glenn Keyes
Architects

12 Vanderhorst Street
Charleston, SC 29403
(843) 722-4100
www.glennkeyesarchitects.com

A REHABILITATION OF
35 LEGARE STREET
THE ELIZABETH WILLIAMS HOUSE
C. 1790
CHARLESTON, SC

EAST (FRONT) ELEVATION

REV.	DATE

PROJECT NUMBER 1414

DRAWING DATE 10/10/16

SHEET NUMBER
A201






CHARLESTON, SC


REV.	DATE

DRAWING DATE 10/10/16

A2Ø3

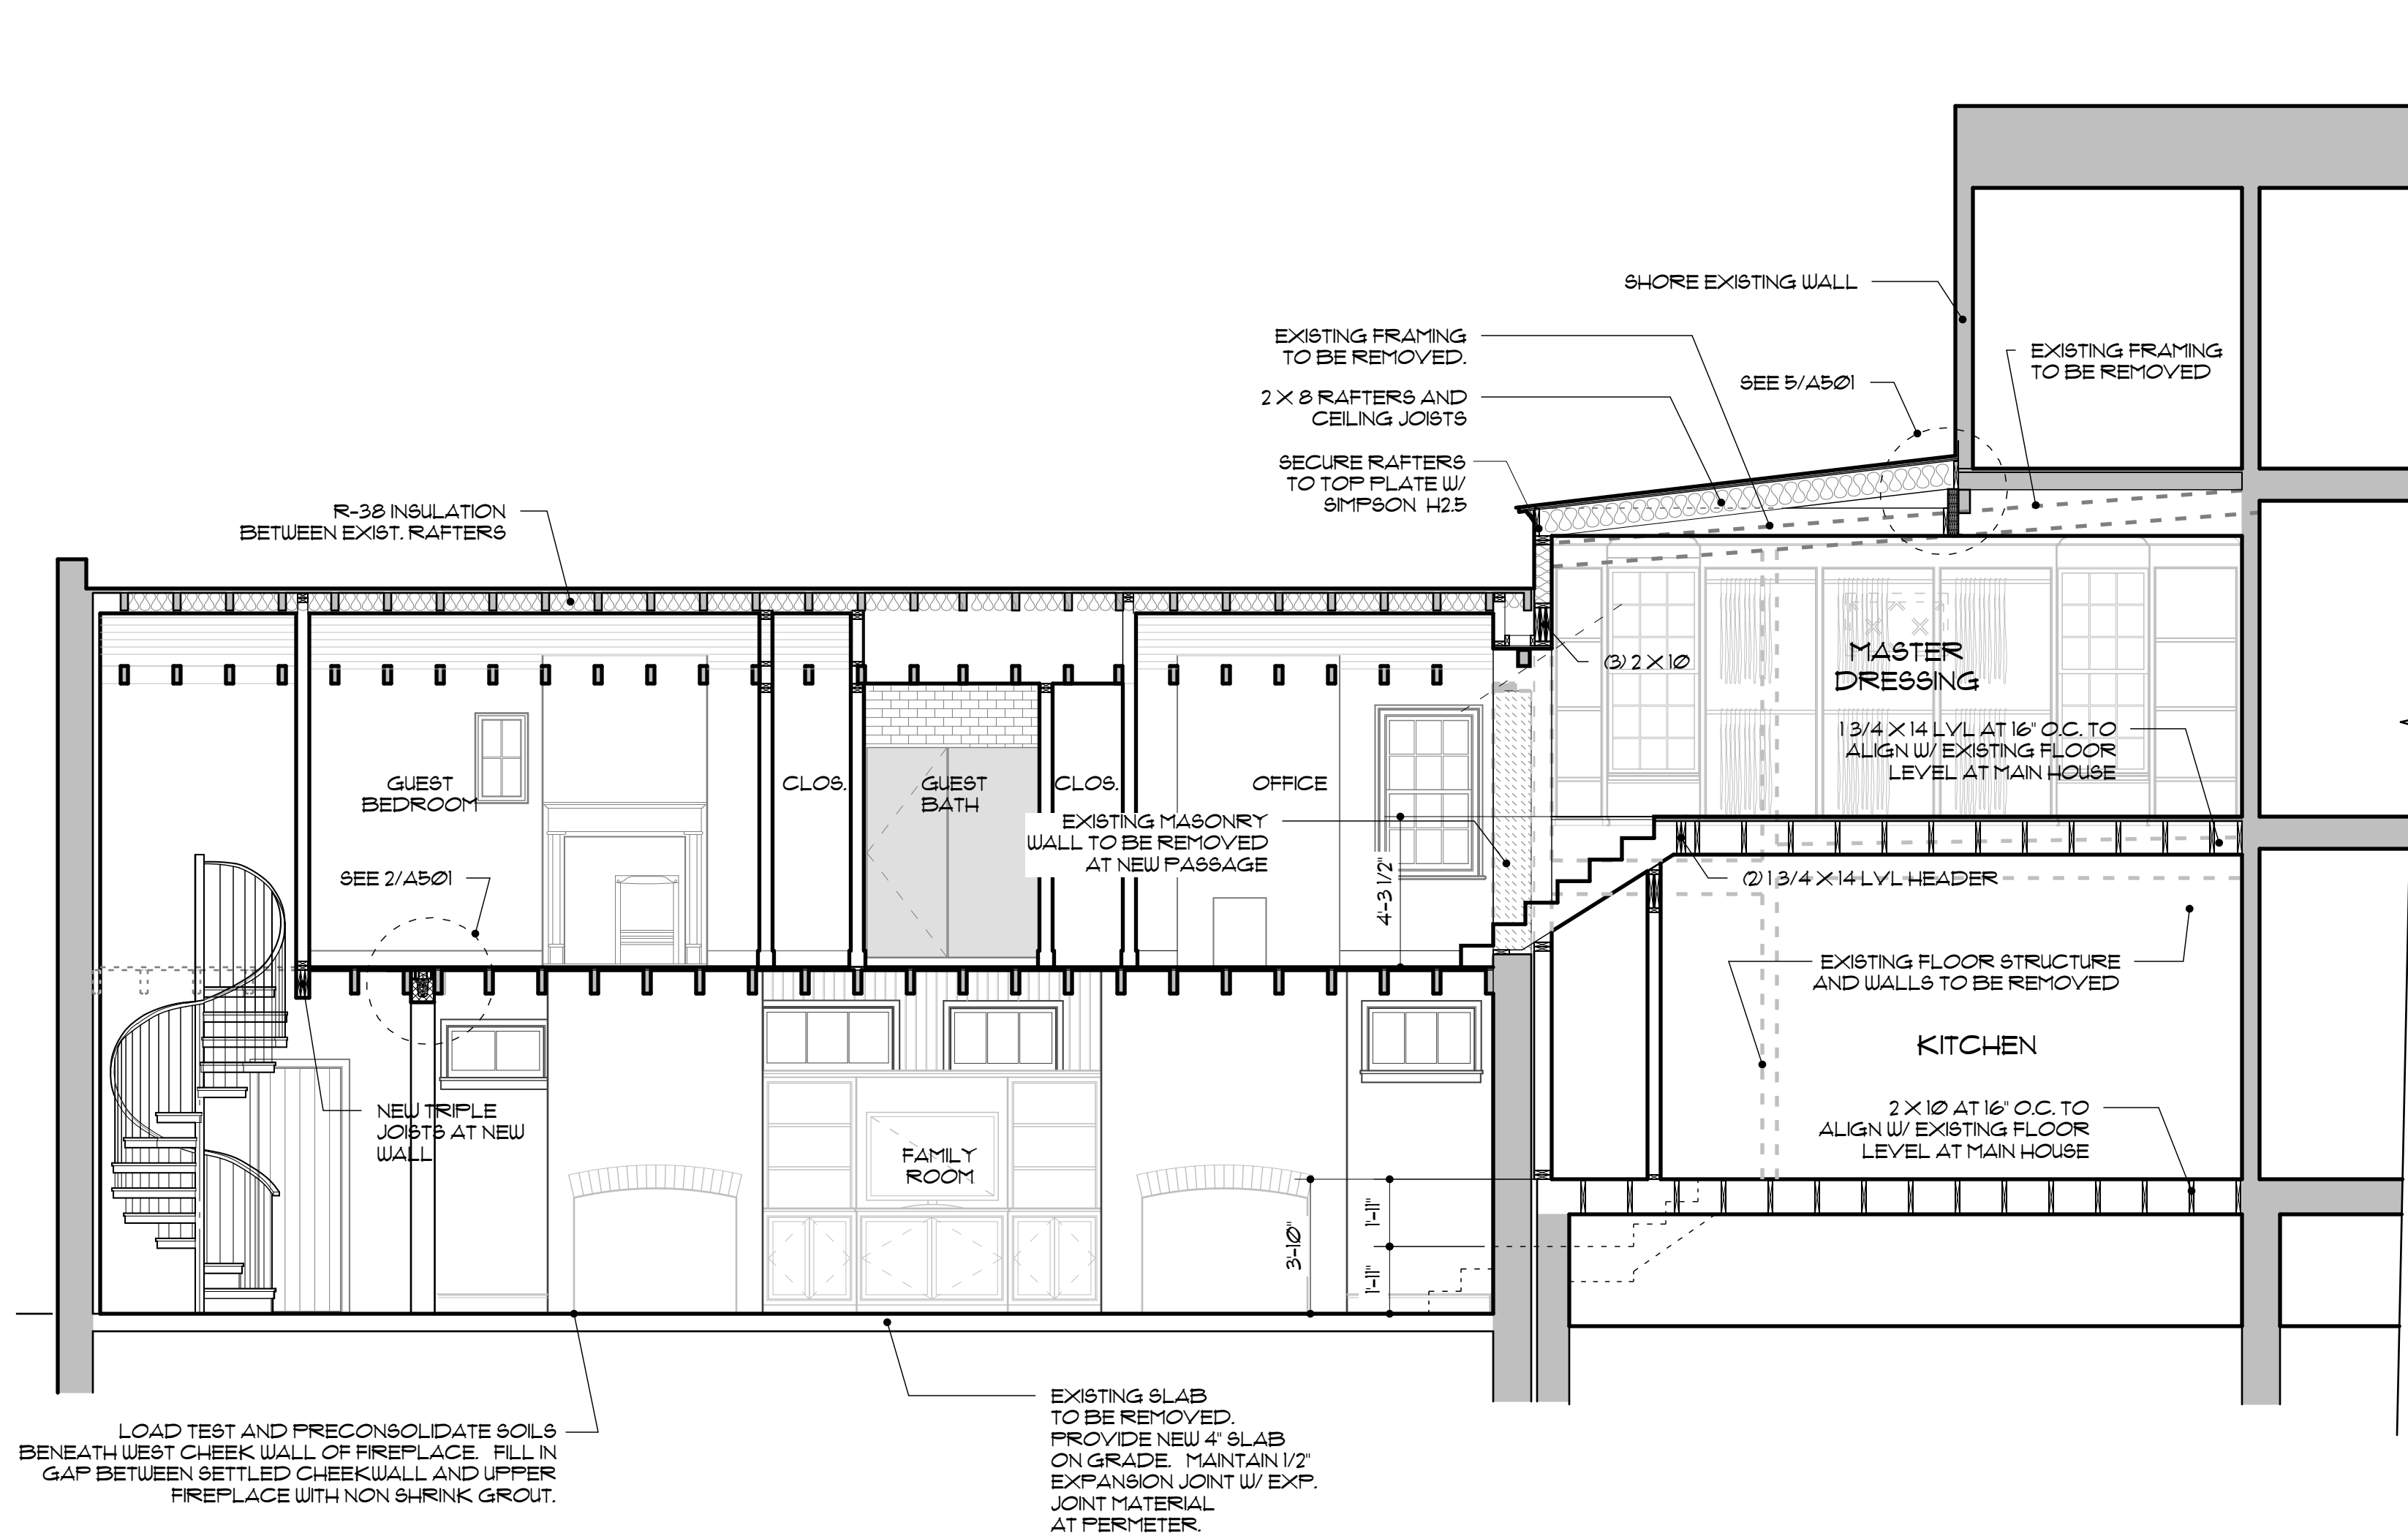


1
A301 BUILDING SECTION
SCALE: 1/4" = 1'-0"

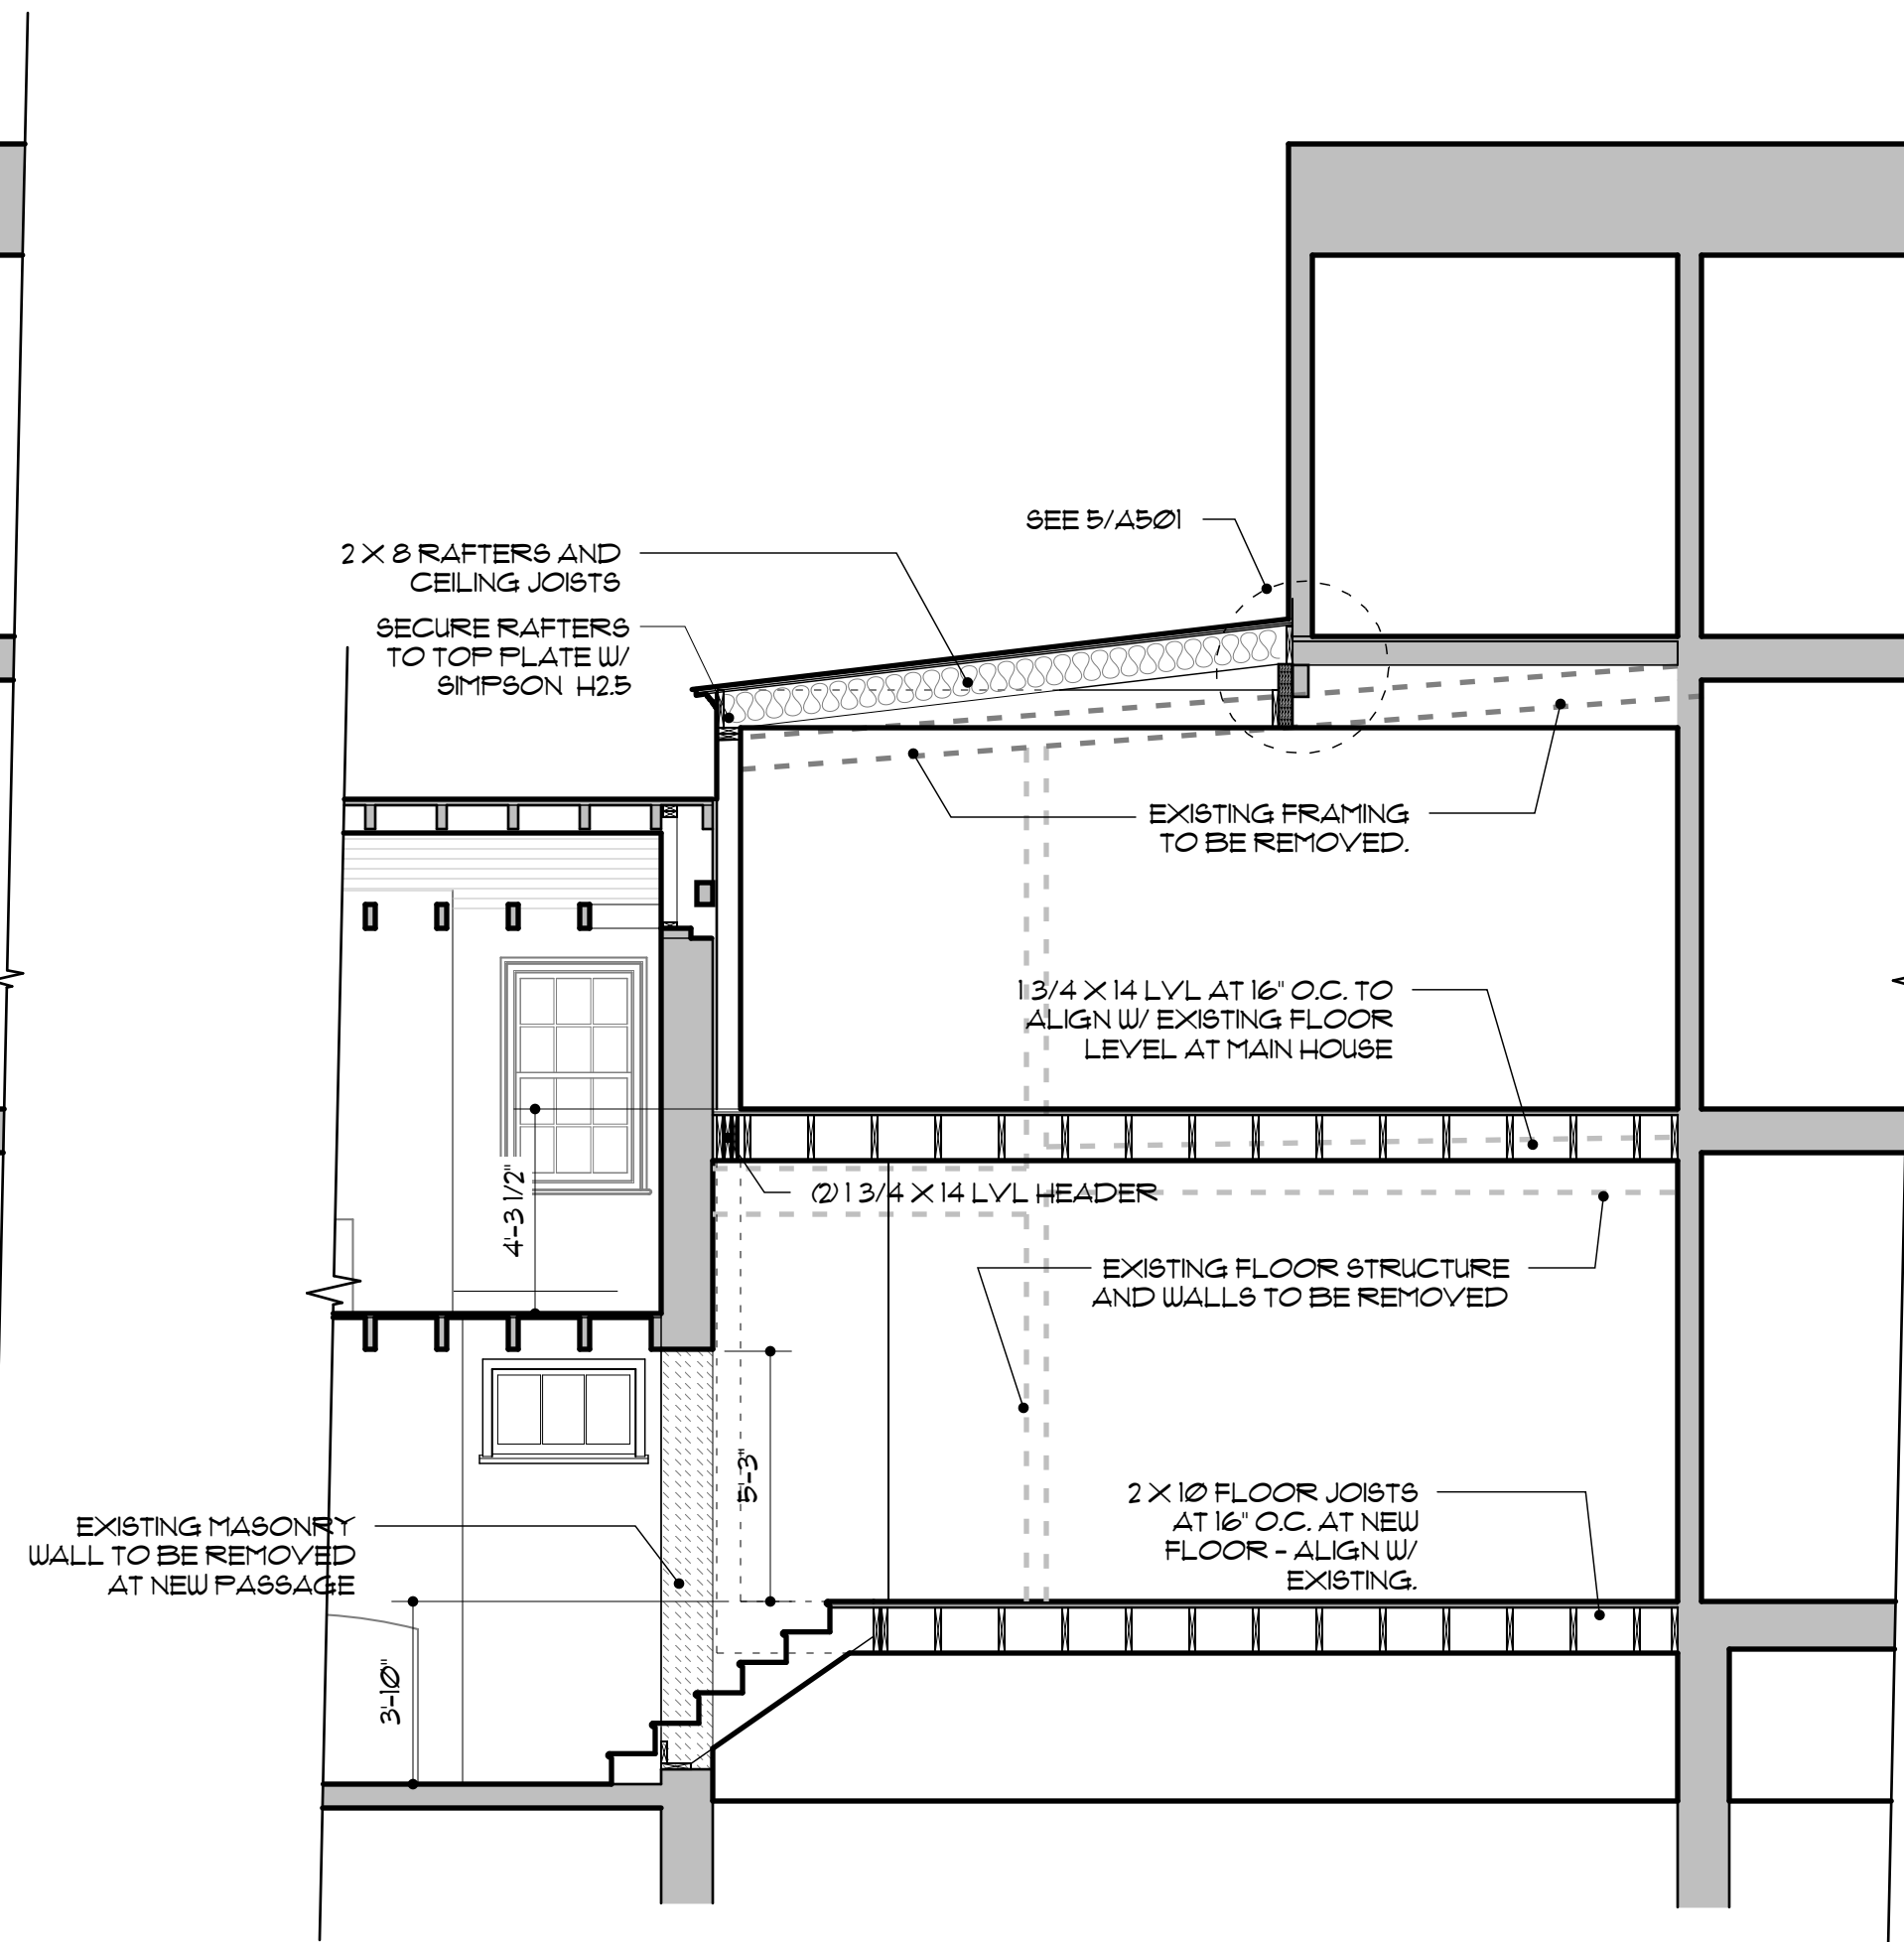

2
A301 BUILDING SECTION
SCALE: 1/4" = 1'-0"

Glenn Keyes
Architects


12 Vanderhorst Street
Charleston, SC 29403
(843) 722-4100
www.glennkeyesarchitects.com

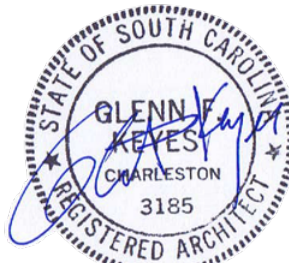


A REHABILITATION OF
35 LEGARE STREET
THE ELIZABETH WILLIAMS HOUSE
C. 1790
CHARLESTON, SC

BUILDING SECTION


REV.	DATE
PROJECT NUMBER	1414
DRAWING DATE	10/10/16
SHEET NUMBER	A301

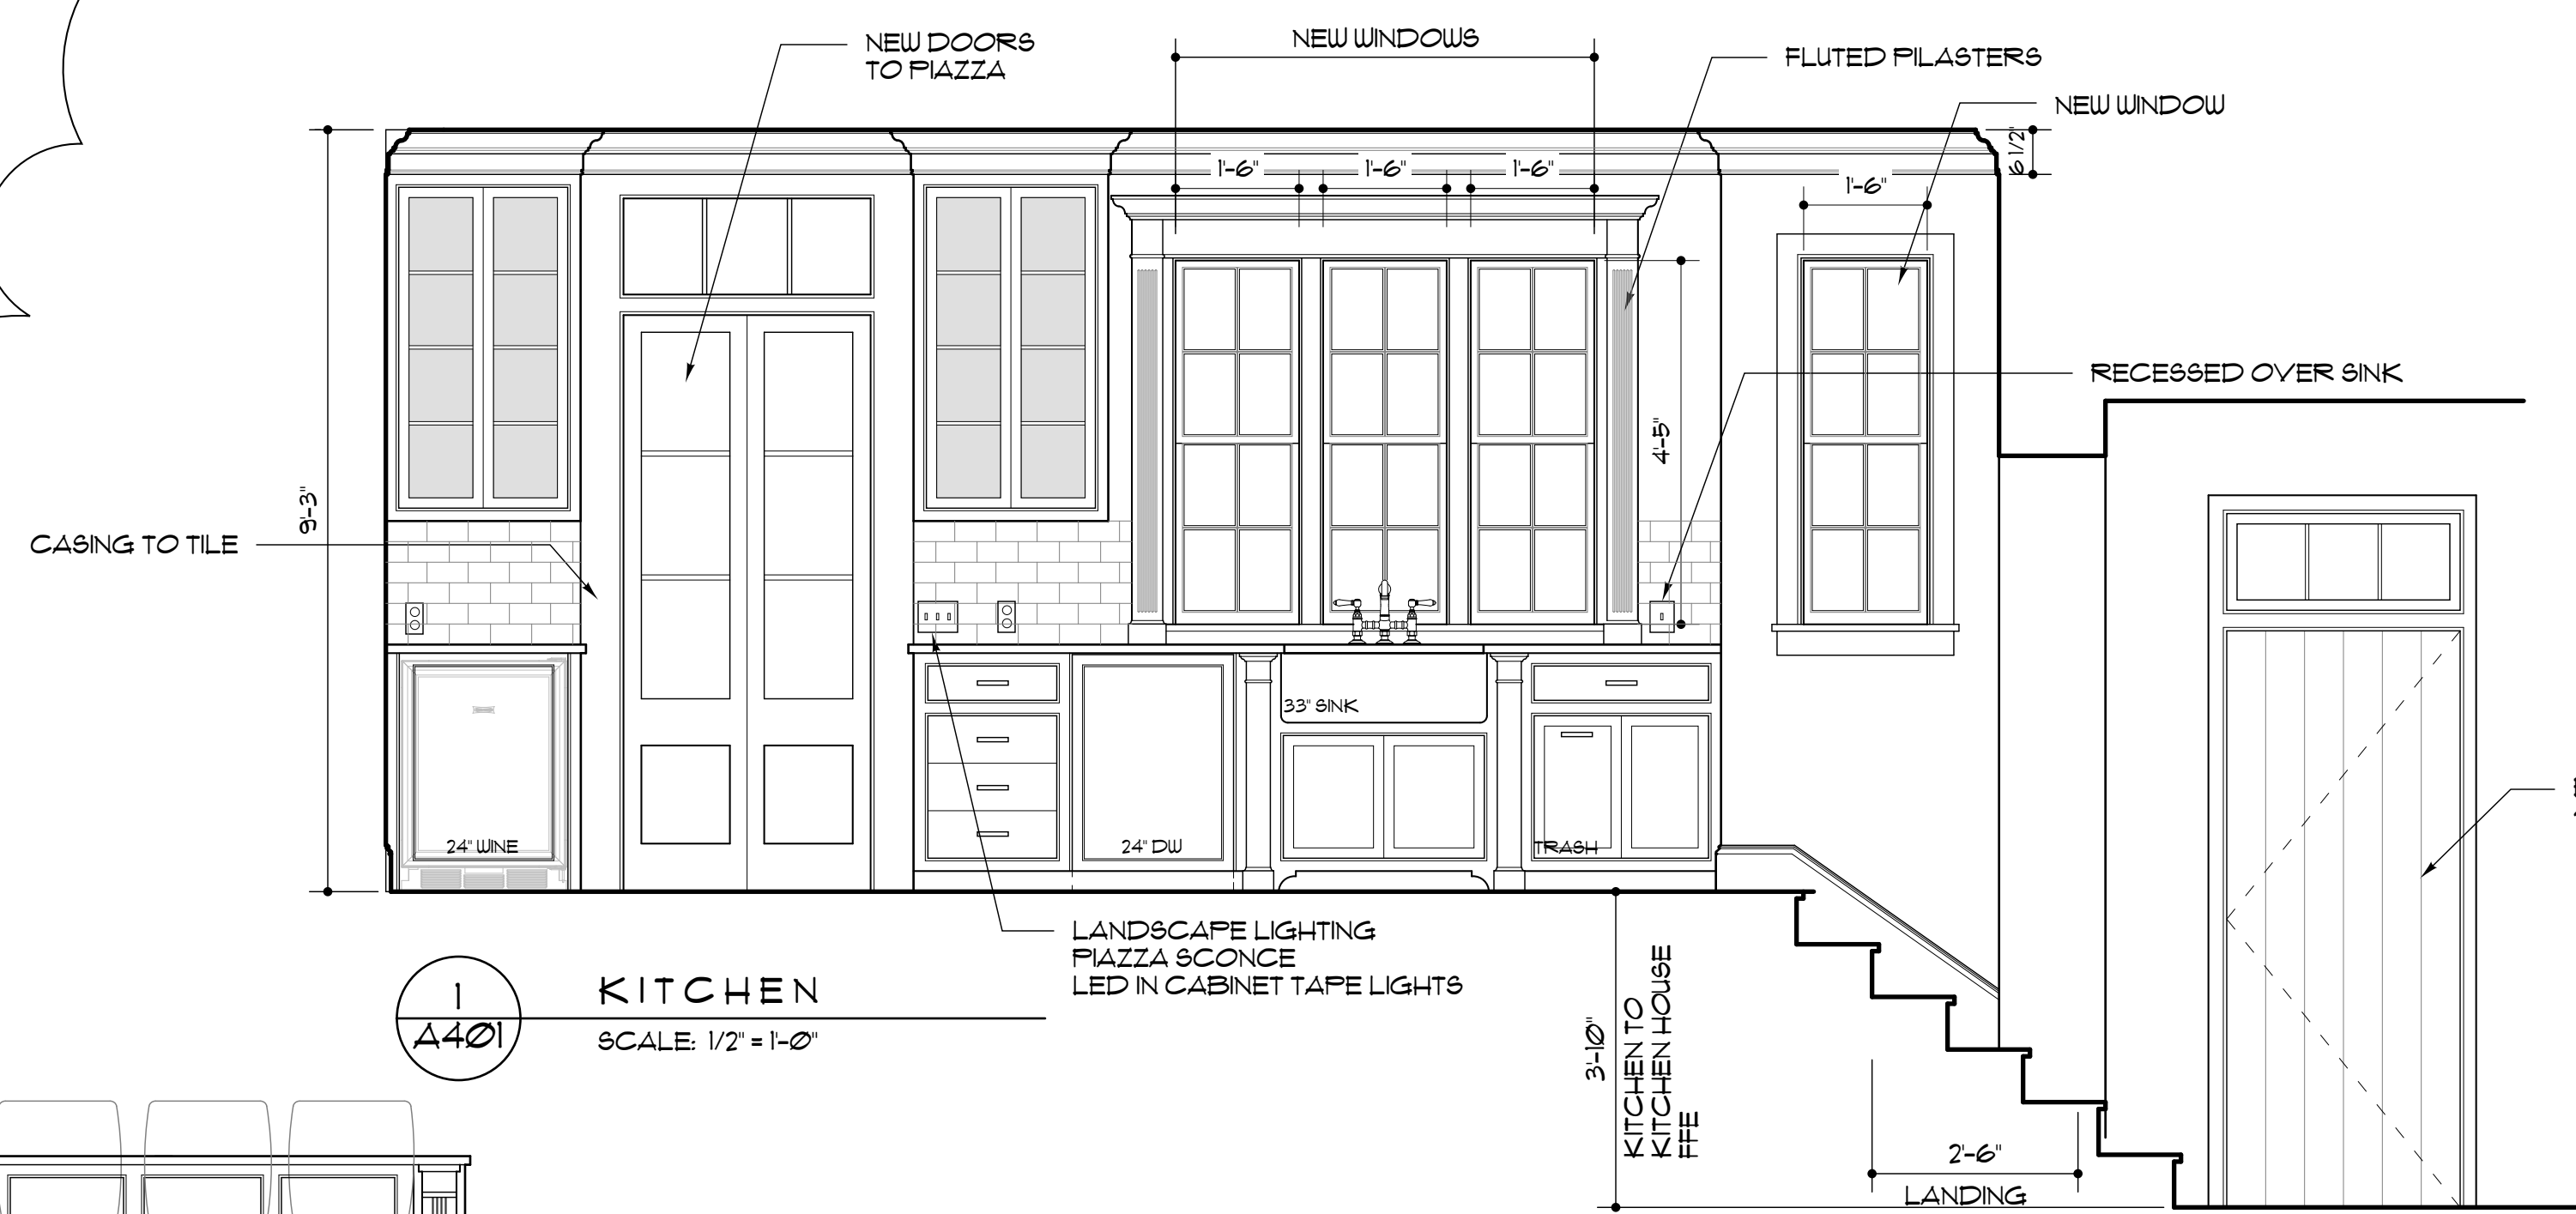


1
A401
KITCHEN
SCALE: 1/2" = 1'-0"

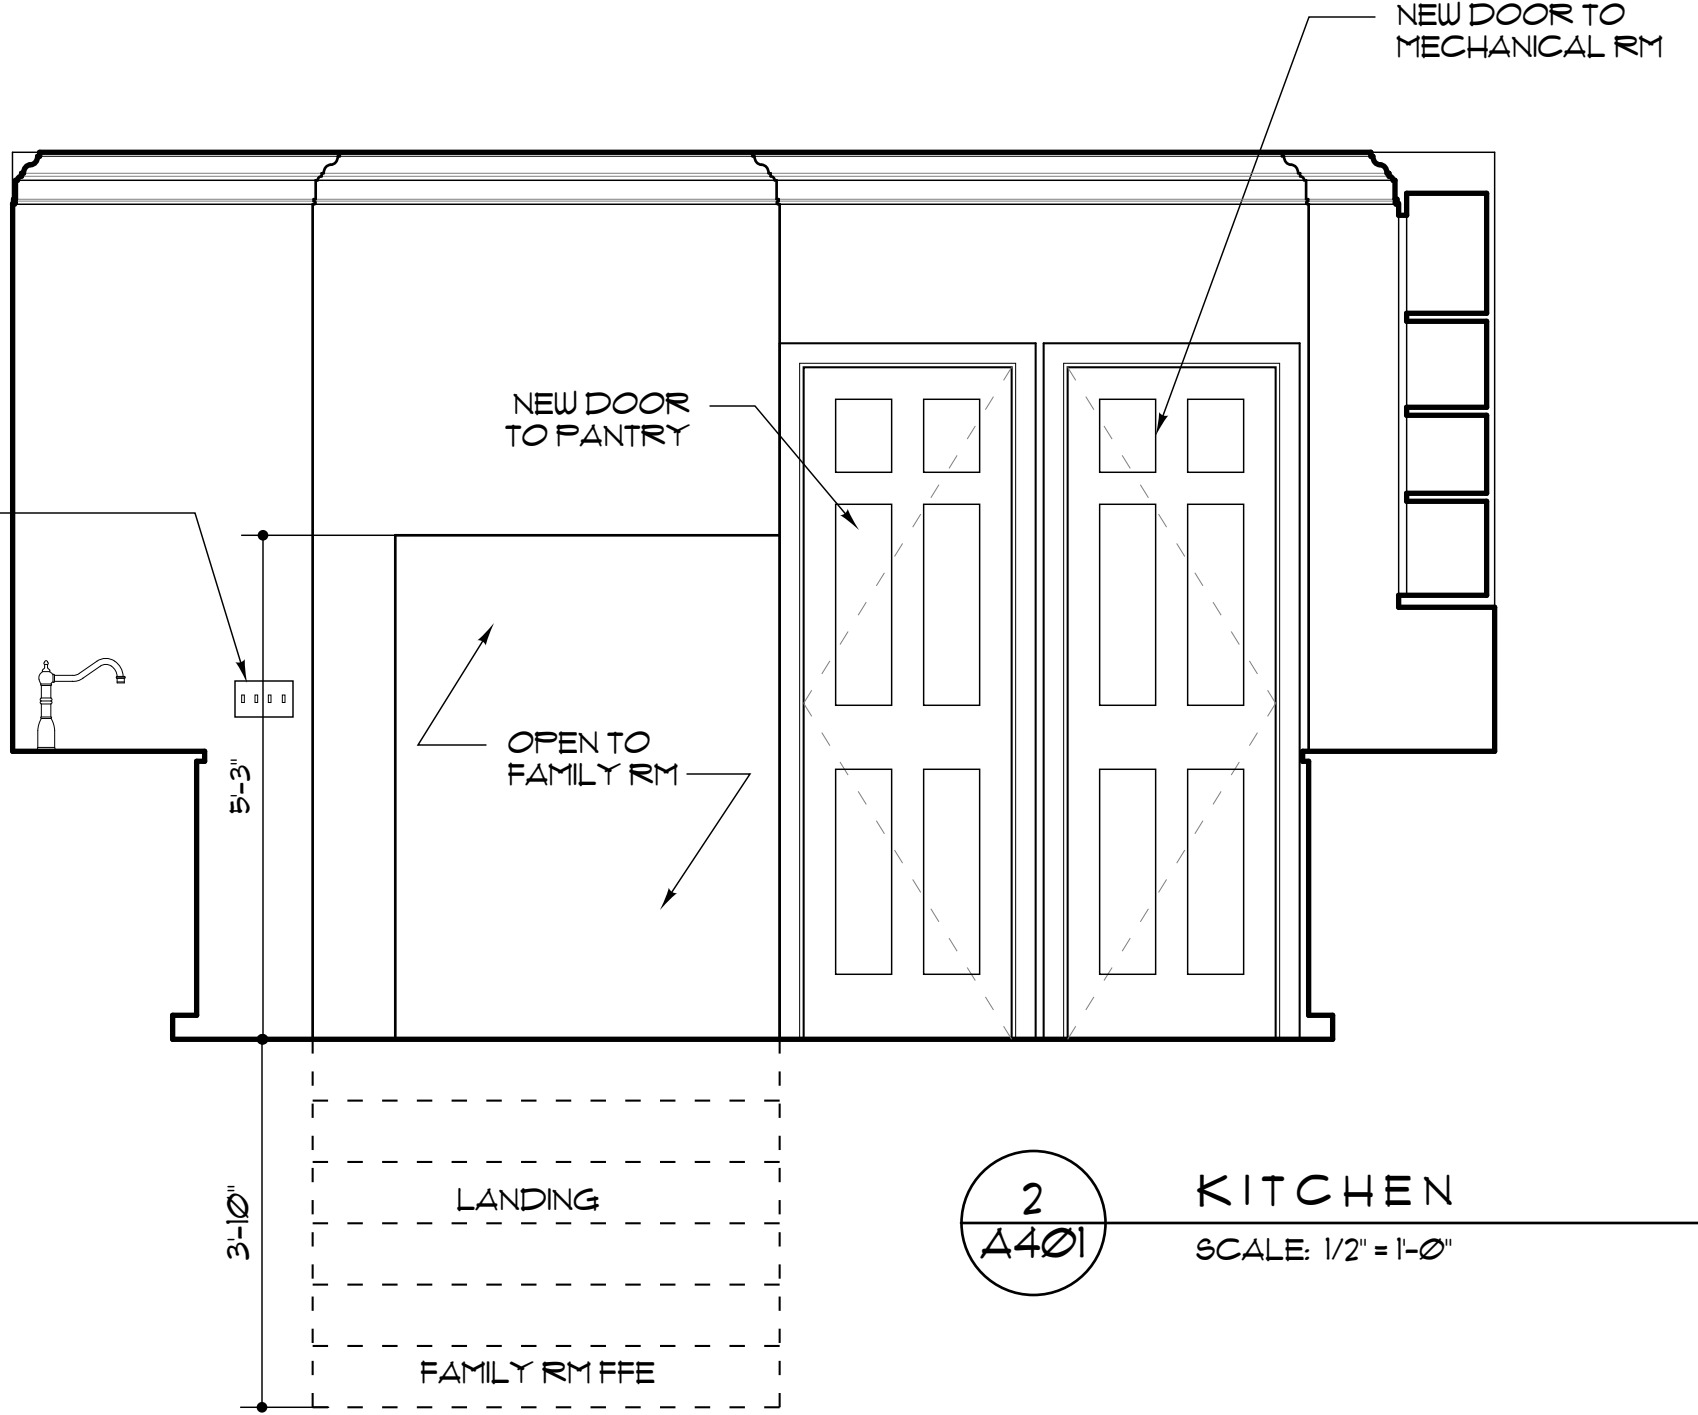


2
A401
KITCHEN
SCALE: 1/2" = 1'-0"

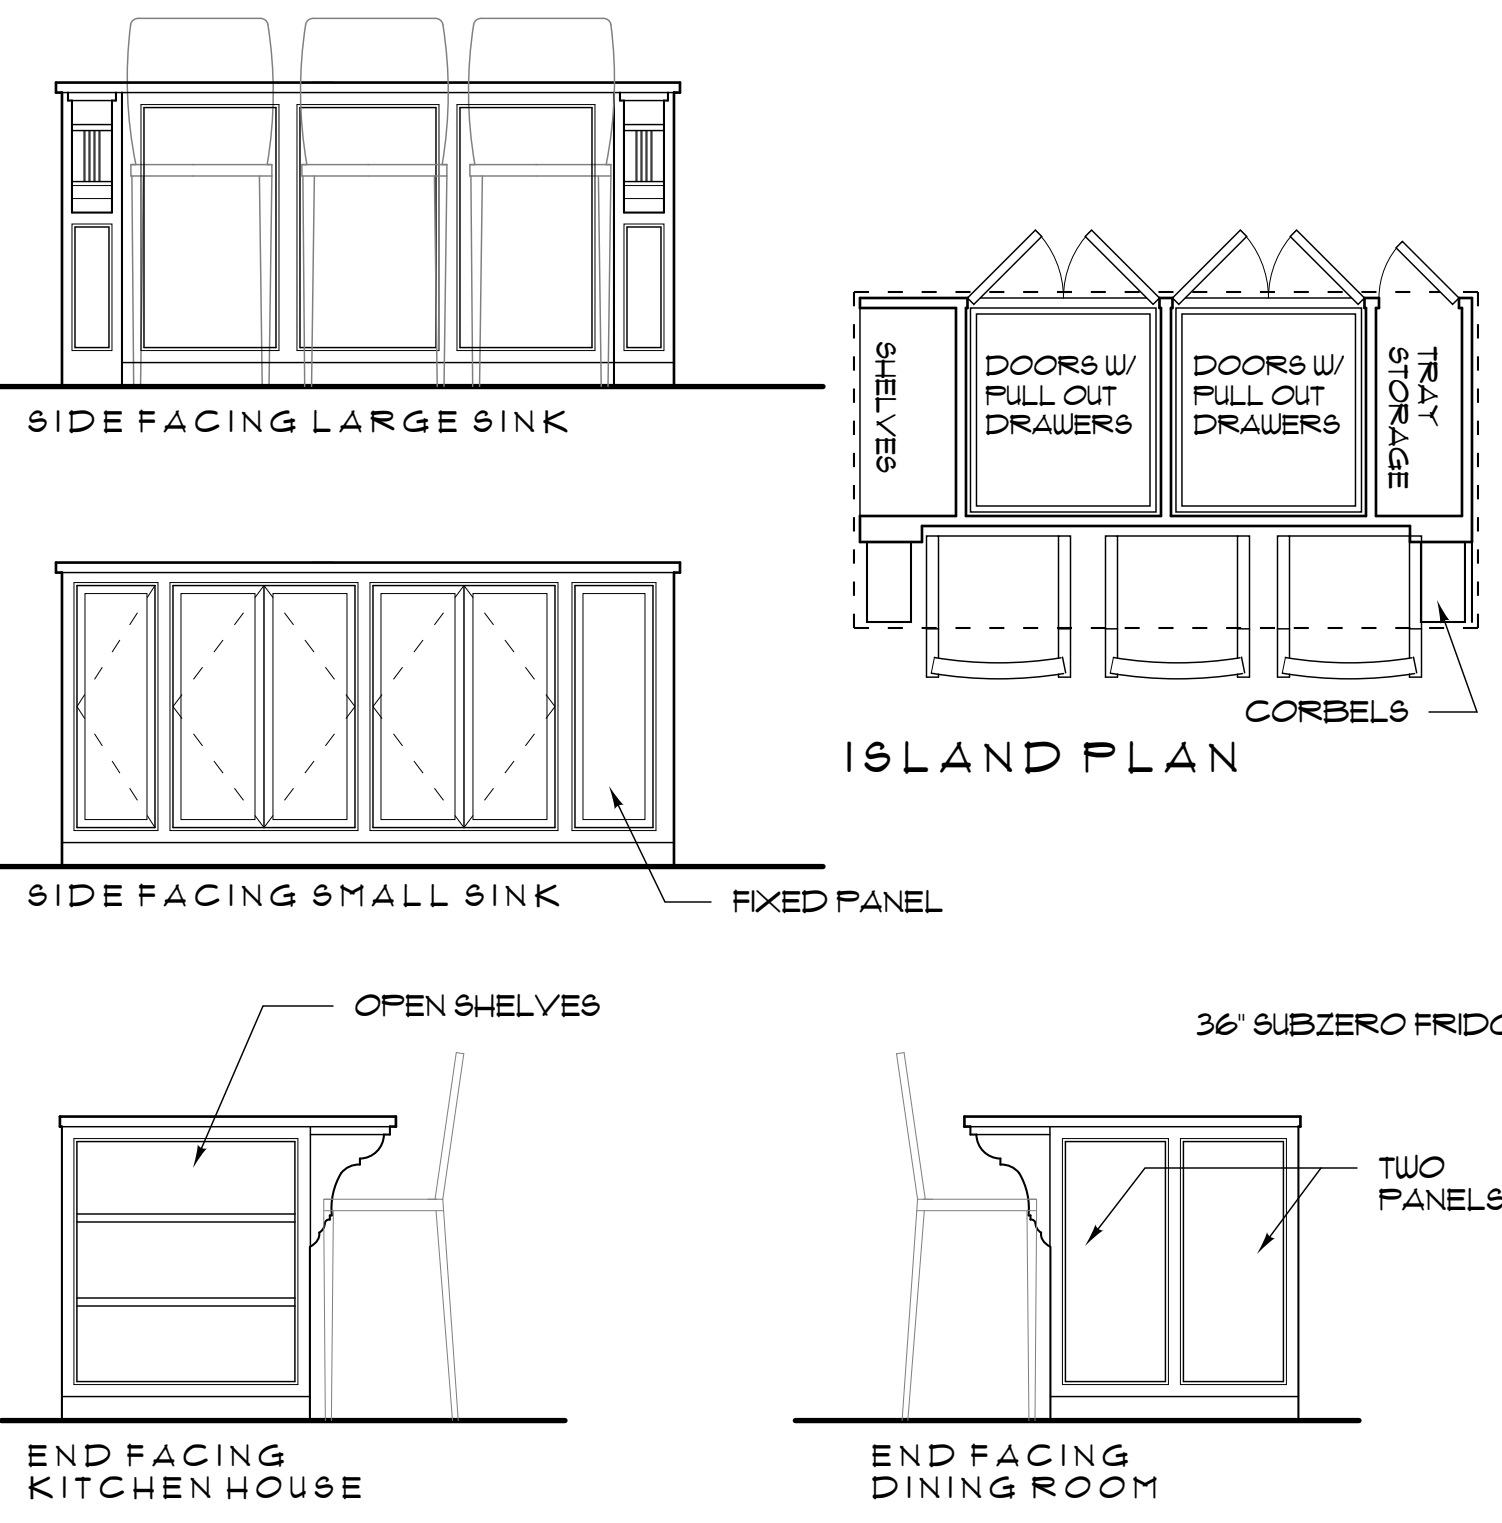

A401
KITCHEN ISLAND
SCALE: 1/2" = 1'-0"

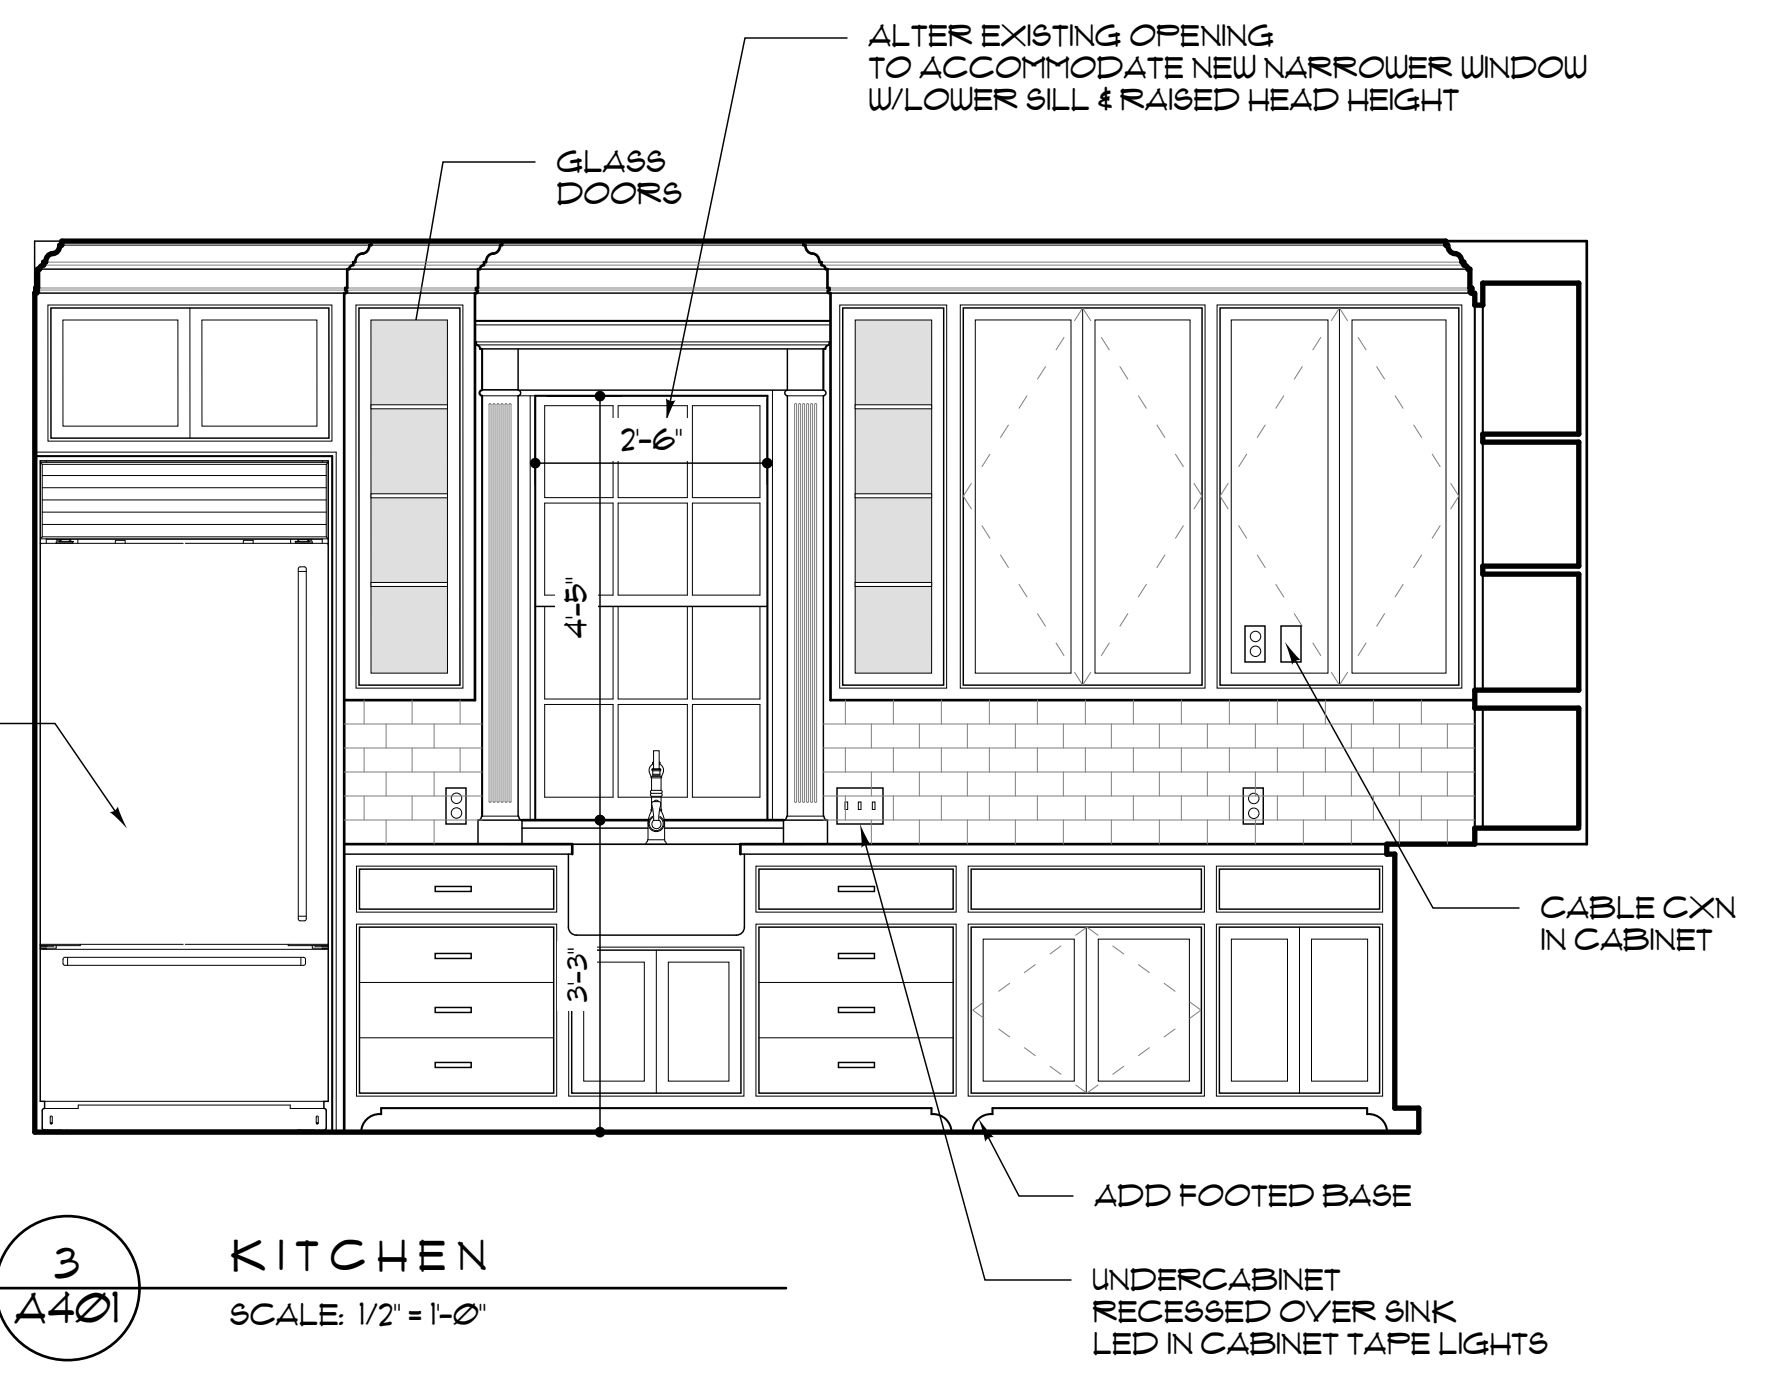


3
A401
KITCHEN
SCALE: 1/2" = 1'-0"

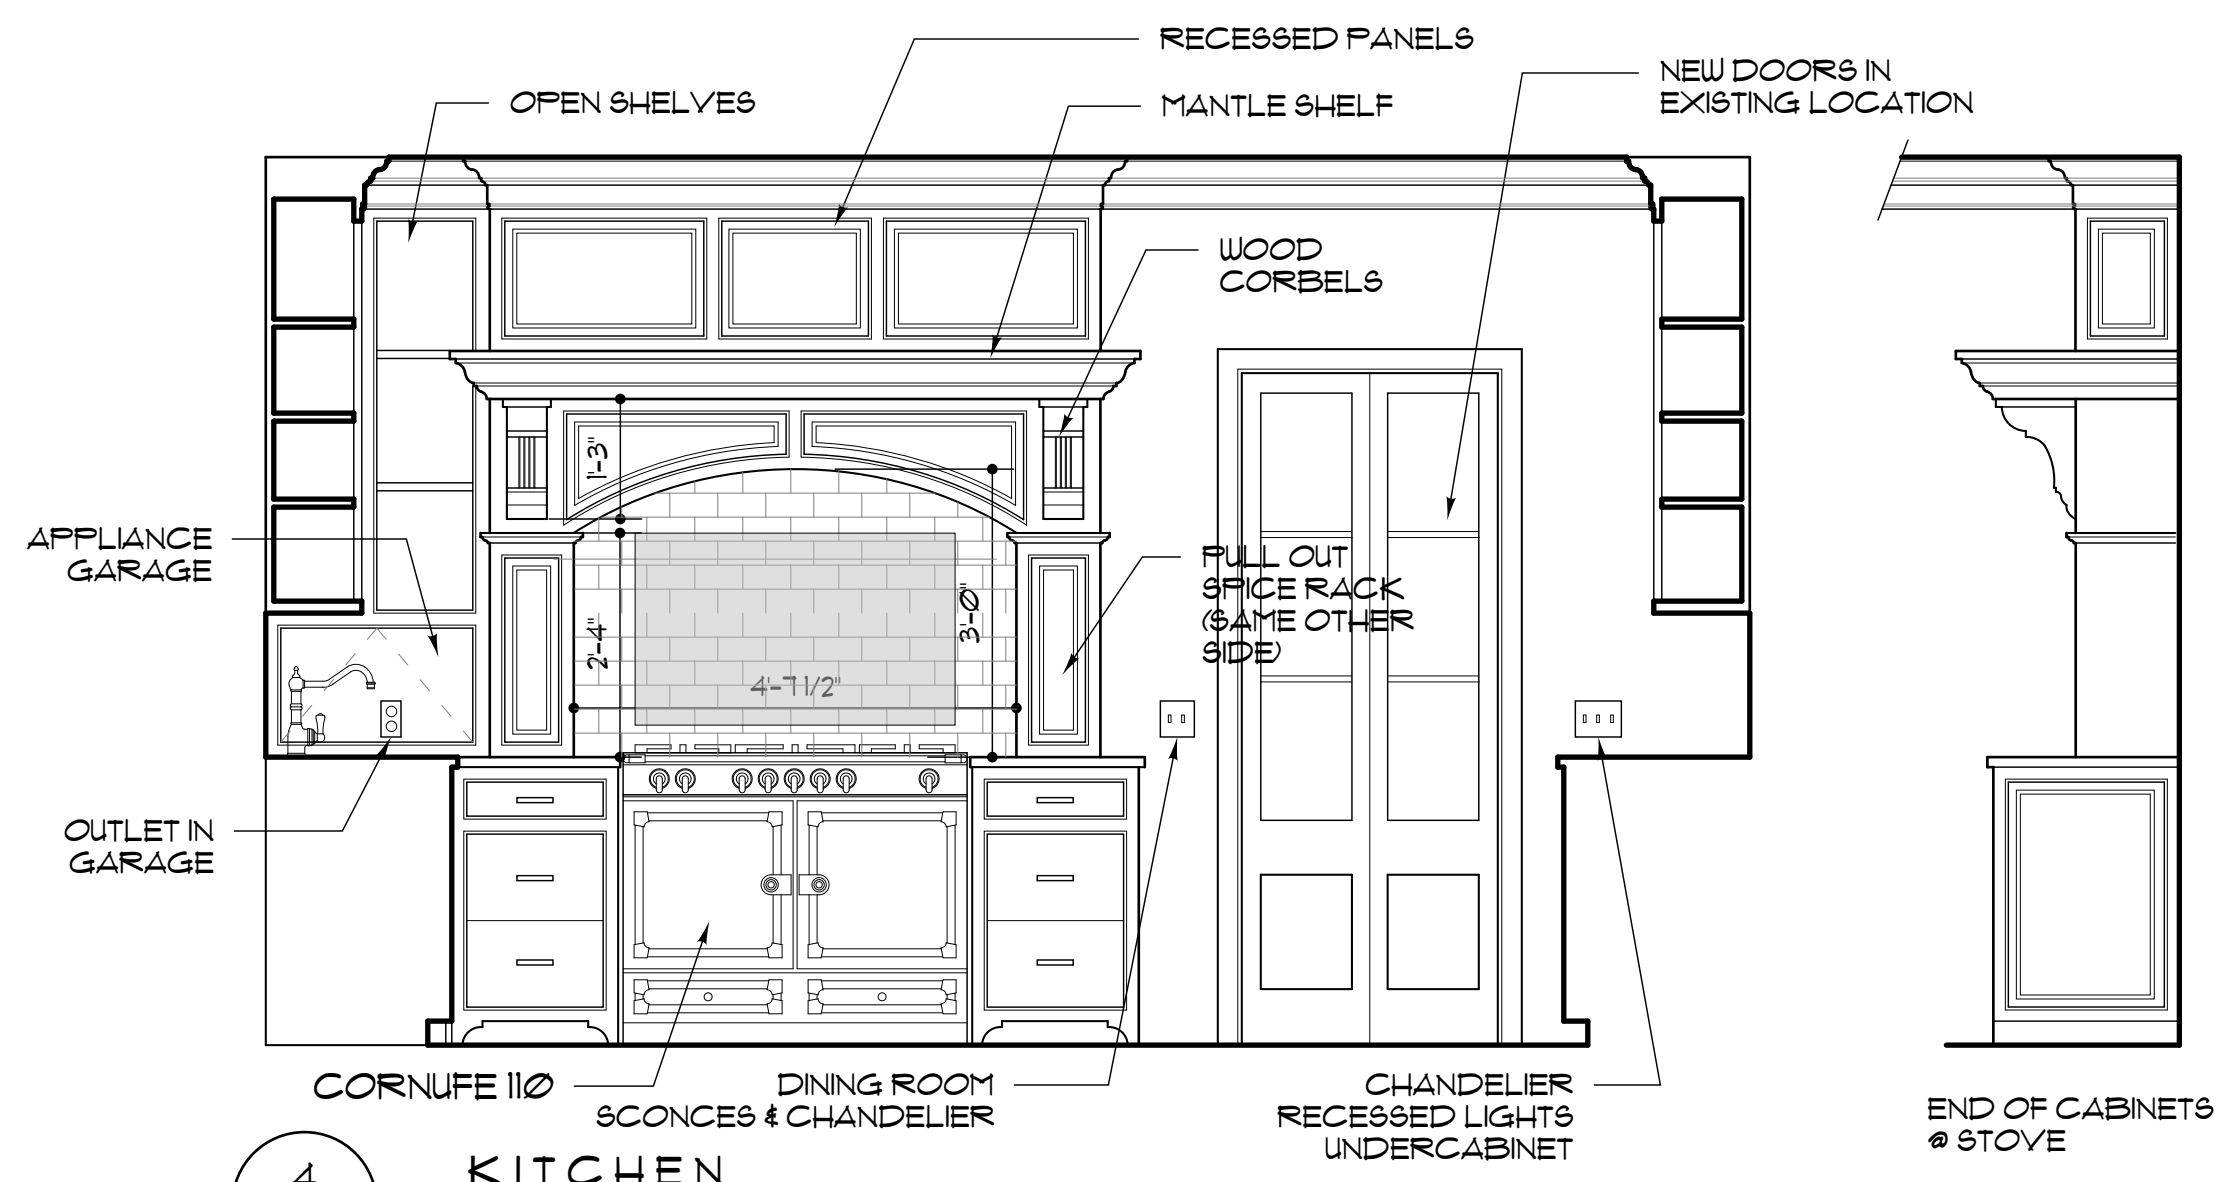


4
A401
KITCHEN
SCALE: 1/2" = 1'-0"




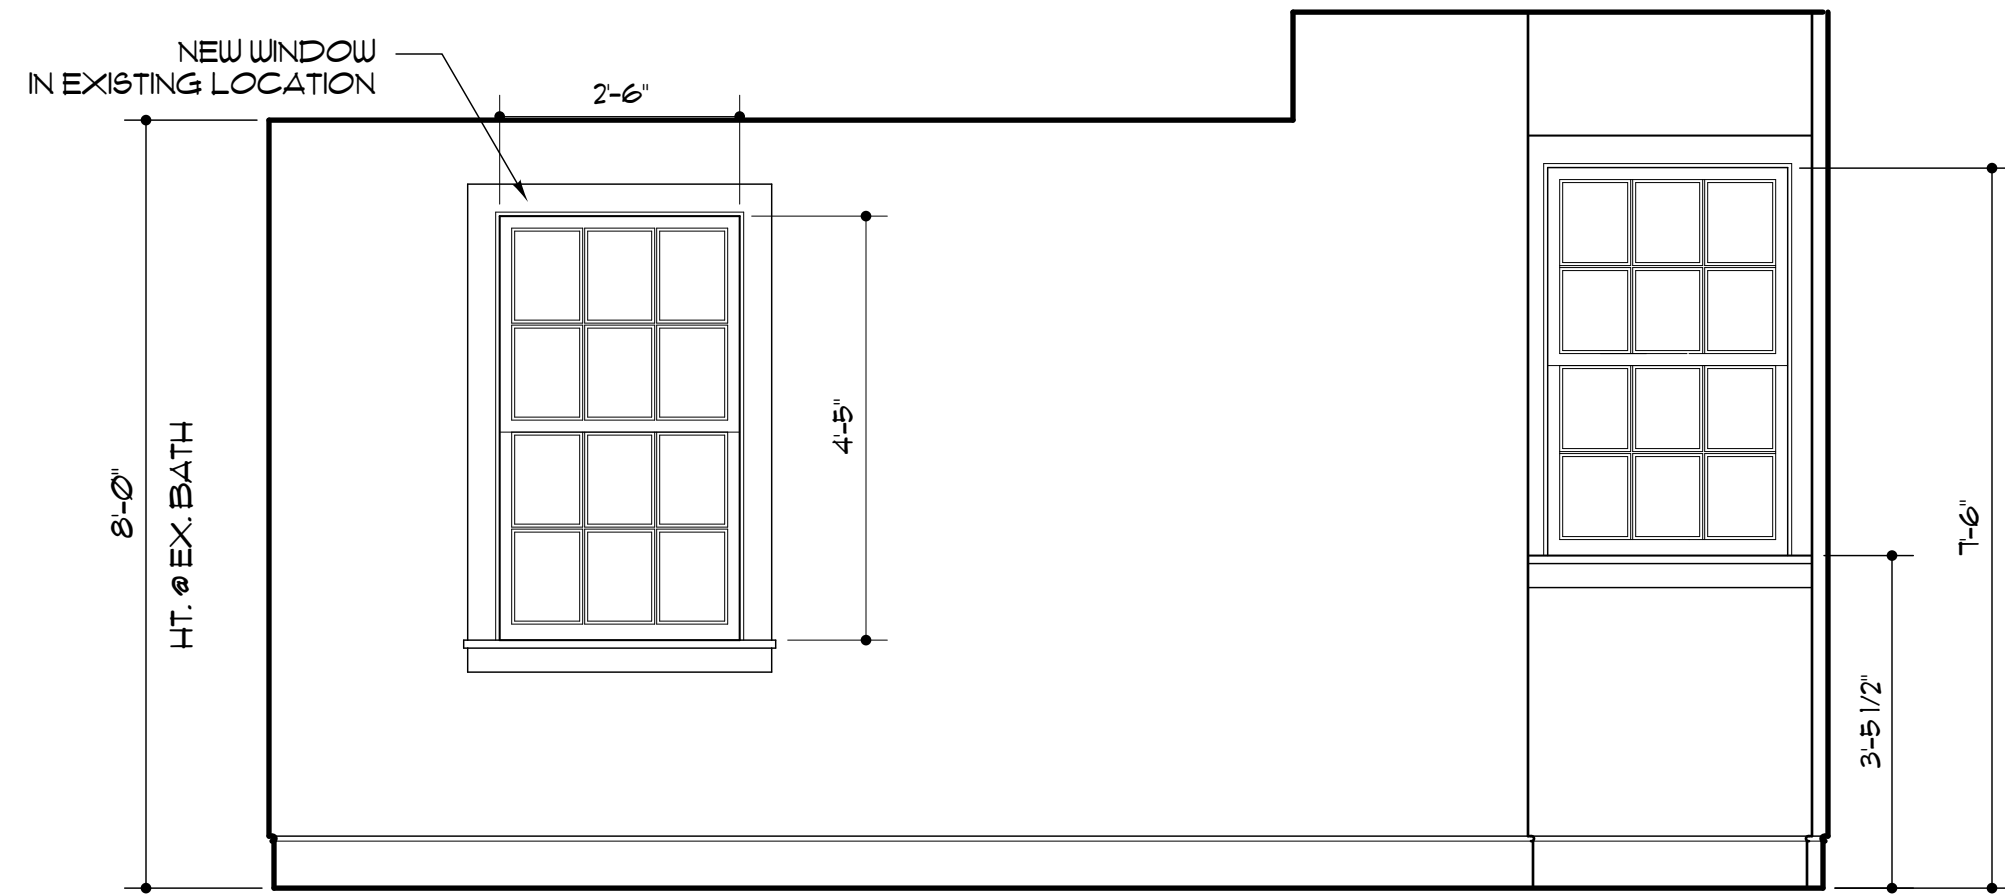


1
A403
GUEST BEDROOM #305
SCALE: 1/2" = 1'-0"

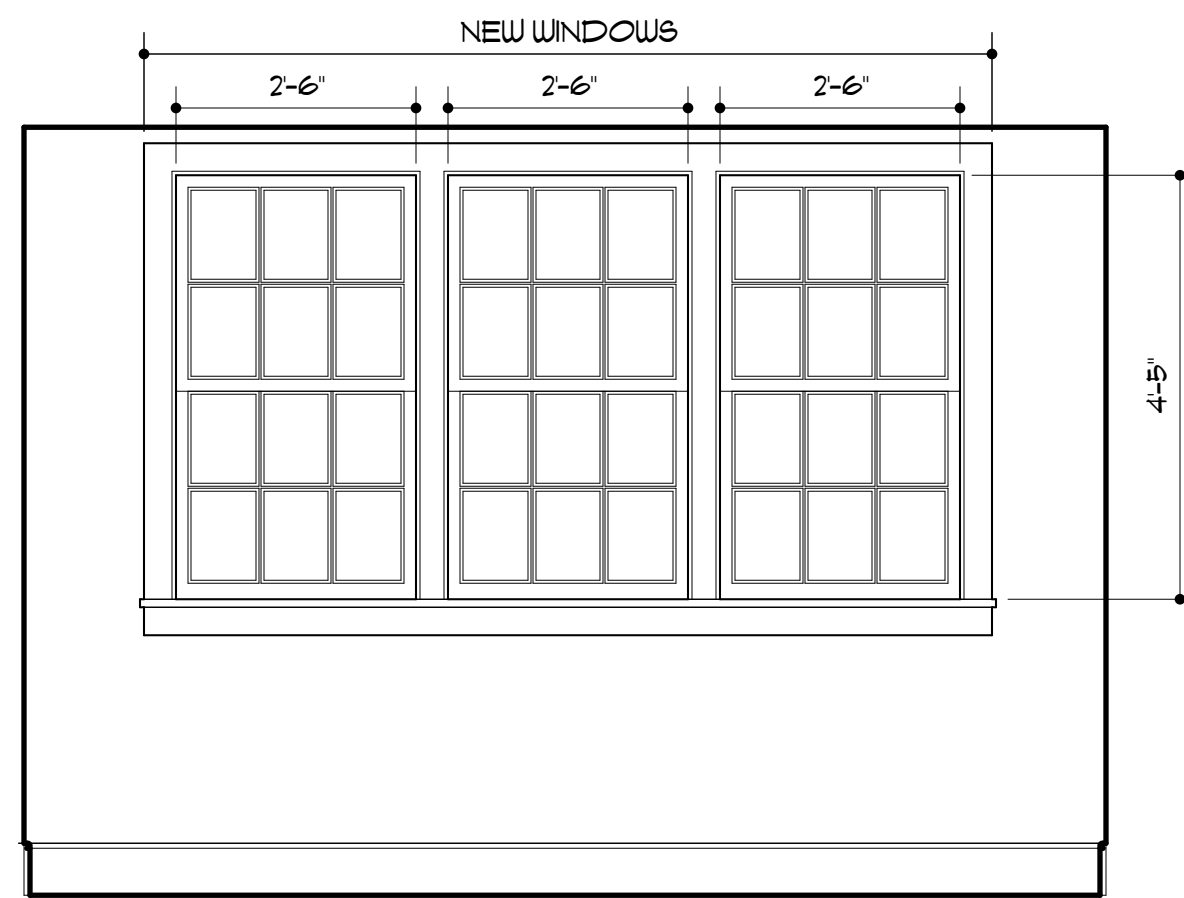

4
A403
GUEST BEDROOM #305
SCALE: 1/2" = 1'-0"

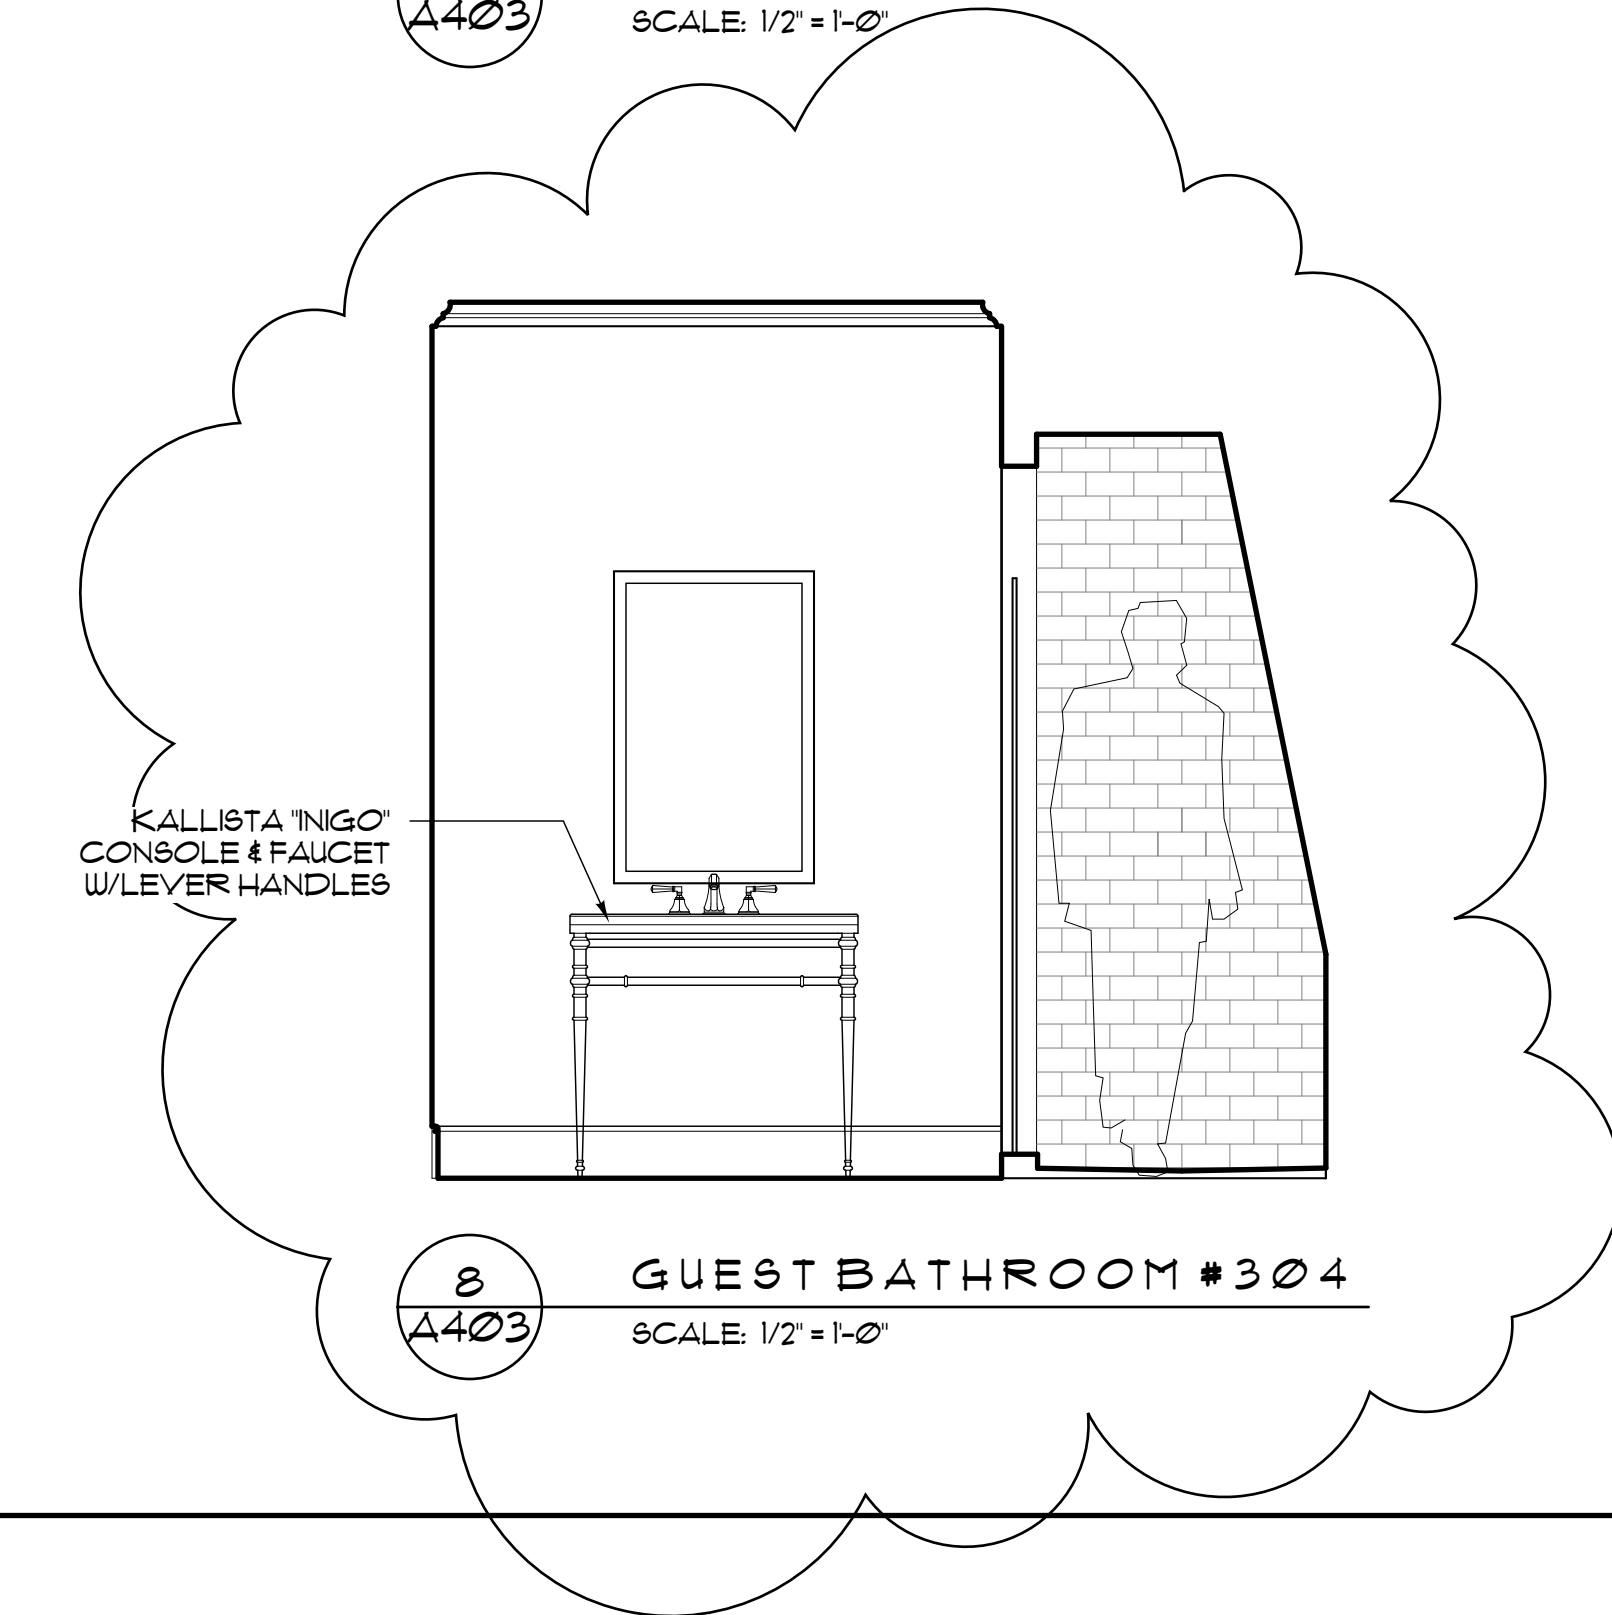


8
A403
GUEST BATHROOM #304
SCALE: 1/2" = 1'-0"

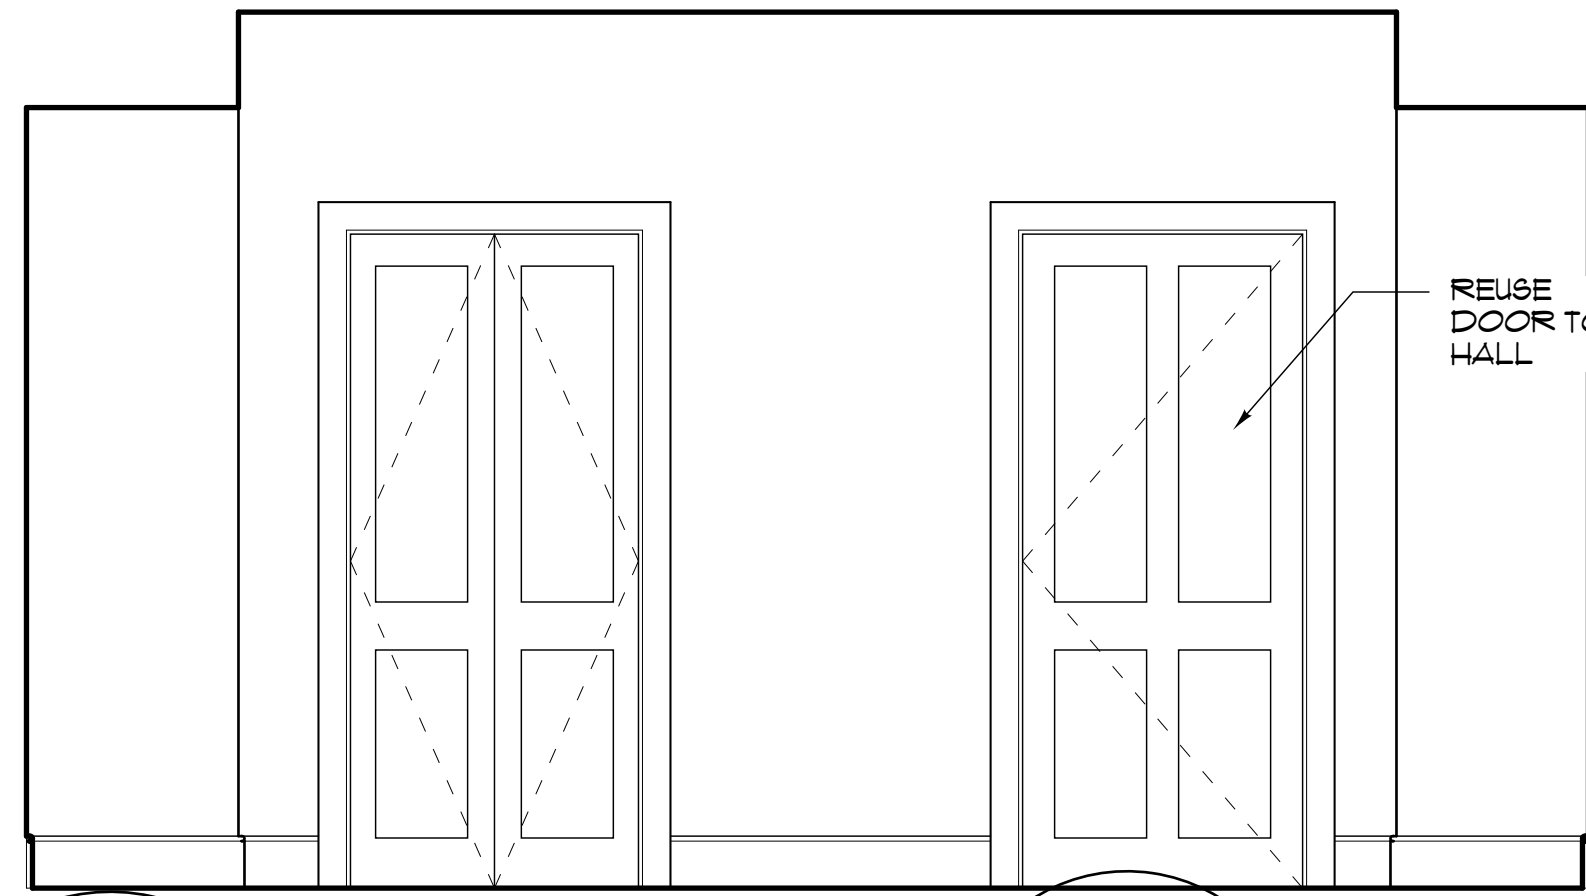


2
A403
GUEST BEDROOM #305
SCALE: 1/2" = 1'-0"




3
A403
GUEST BEDROOM #305
SCALE: 1/2" = 1'-0"

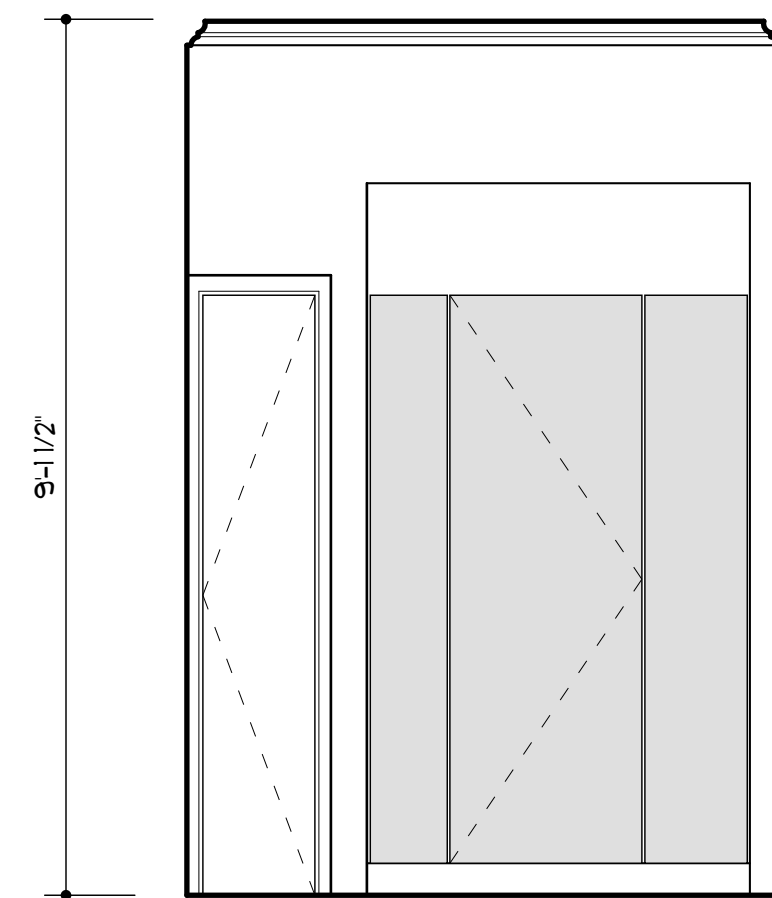

5
A403
GUEST BATHROOM #304
SCALE: 1/2" = 1'-0"

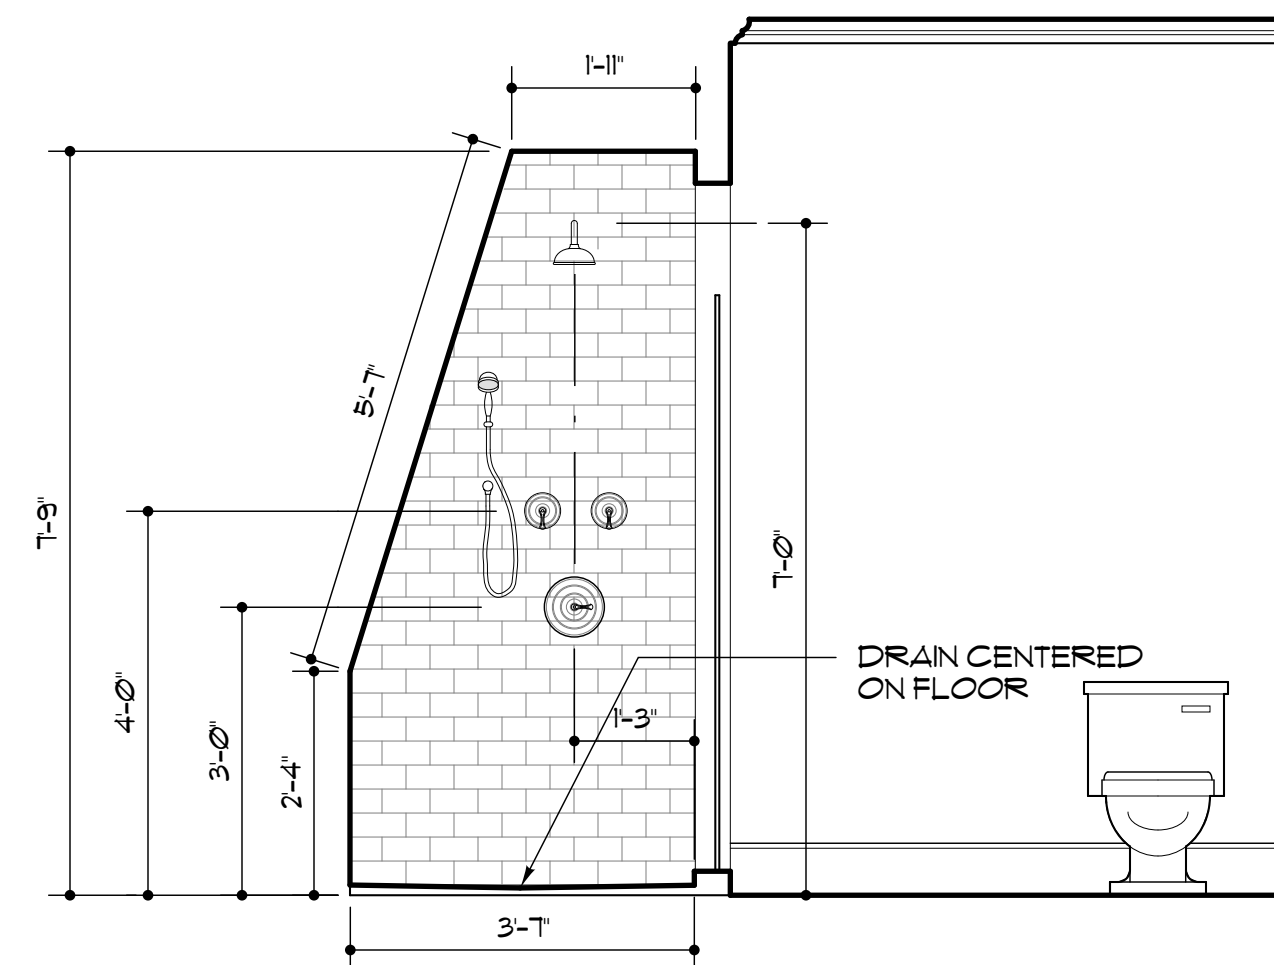

6
A403
GUEST BATHROOM #304
SCALE: 1/2" = 1'-0"

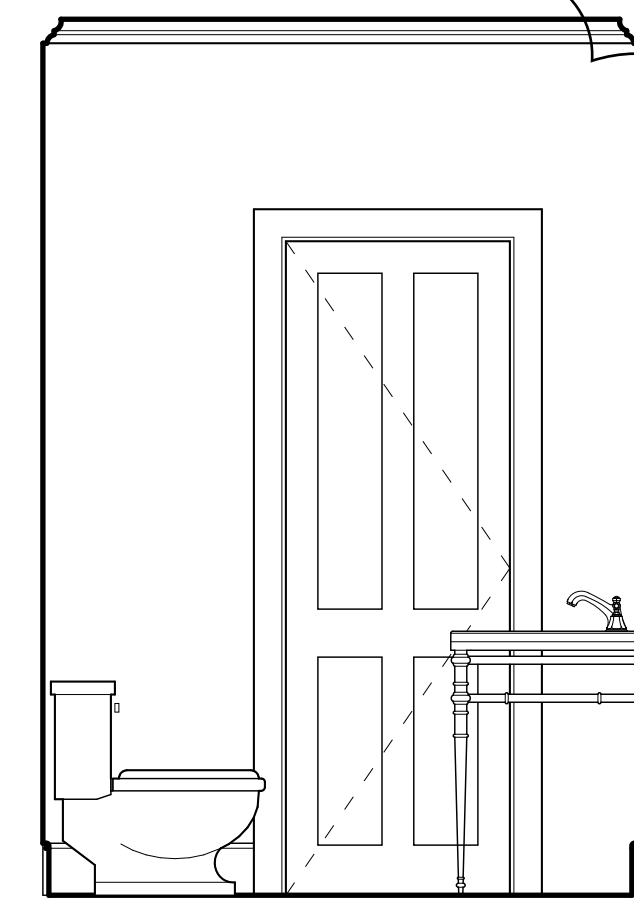

7
A403
GUEST BATHROOM #304
SCALE: 1/2" = 1'-0"

Glenn Keyes
Architects

12 Vanderhorst Street
Charleston, SC 29403
(843) 722-4100
www.glennkeyesarchitects.com

A REHABILITATION OF
35 LEGARE STREET
THE ELIZABETH WILLIAMS HOUSE
C. 1790
CHARLESTON SC

INTERIOR
ELEVATIONS

REV. DATE

PROJECT NUMBER 1414


DRAWING DATE 10/10/16

SHEET NUMBER


A403




1
A404 GUEST BEDROOM #208
SCALE: 1/2" = 1'-0"

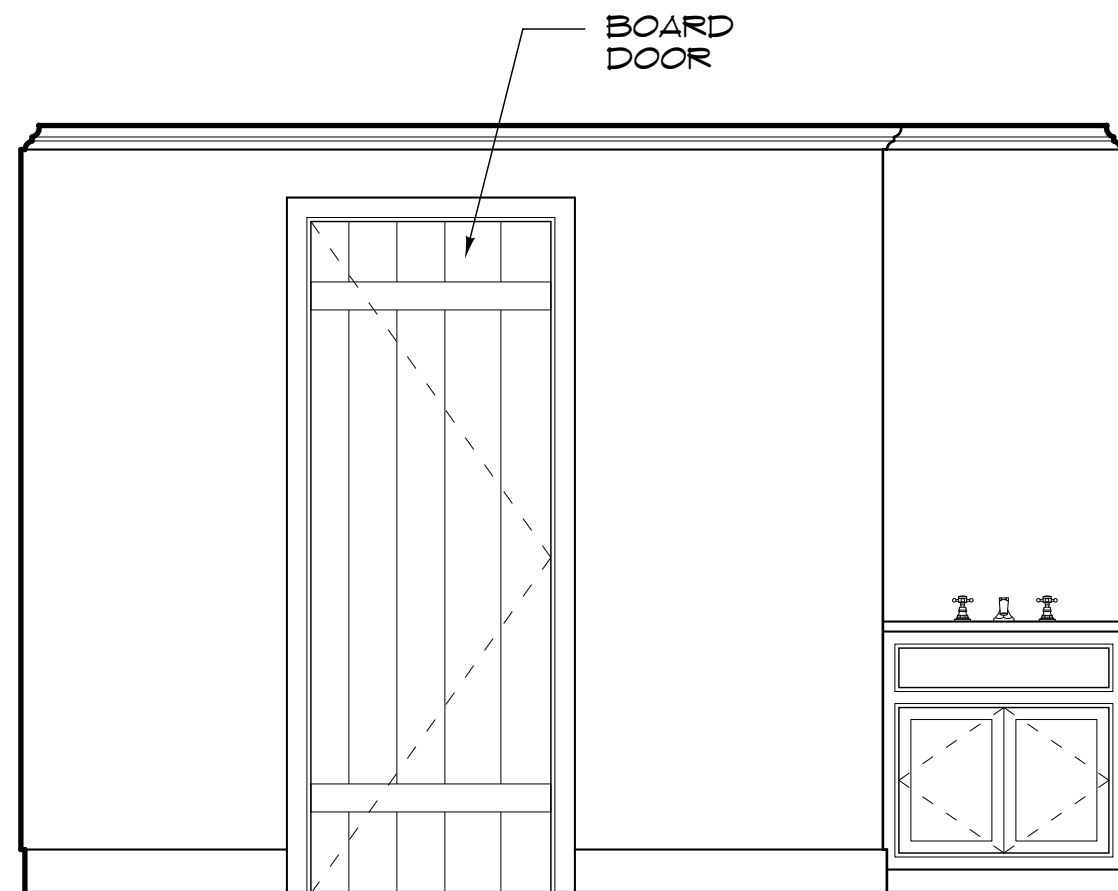


2
A404 GUEST BEDROOM #208
SCALE: 1/2" = 1'-0"

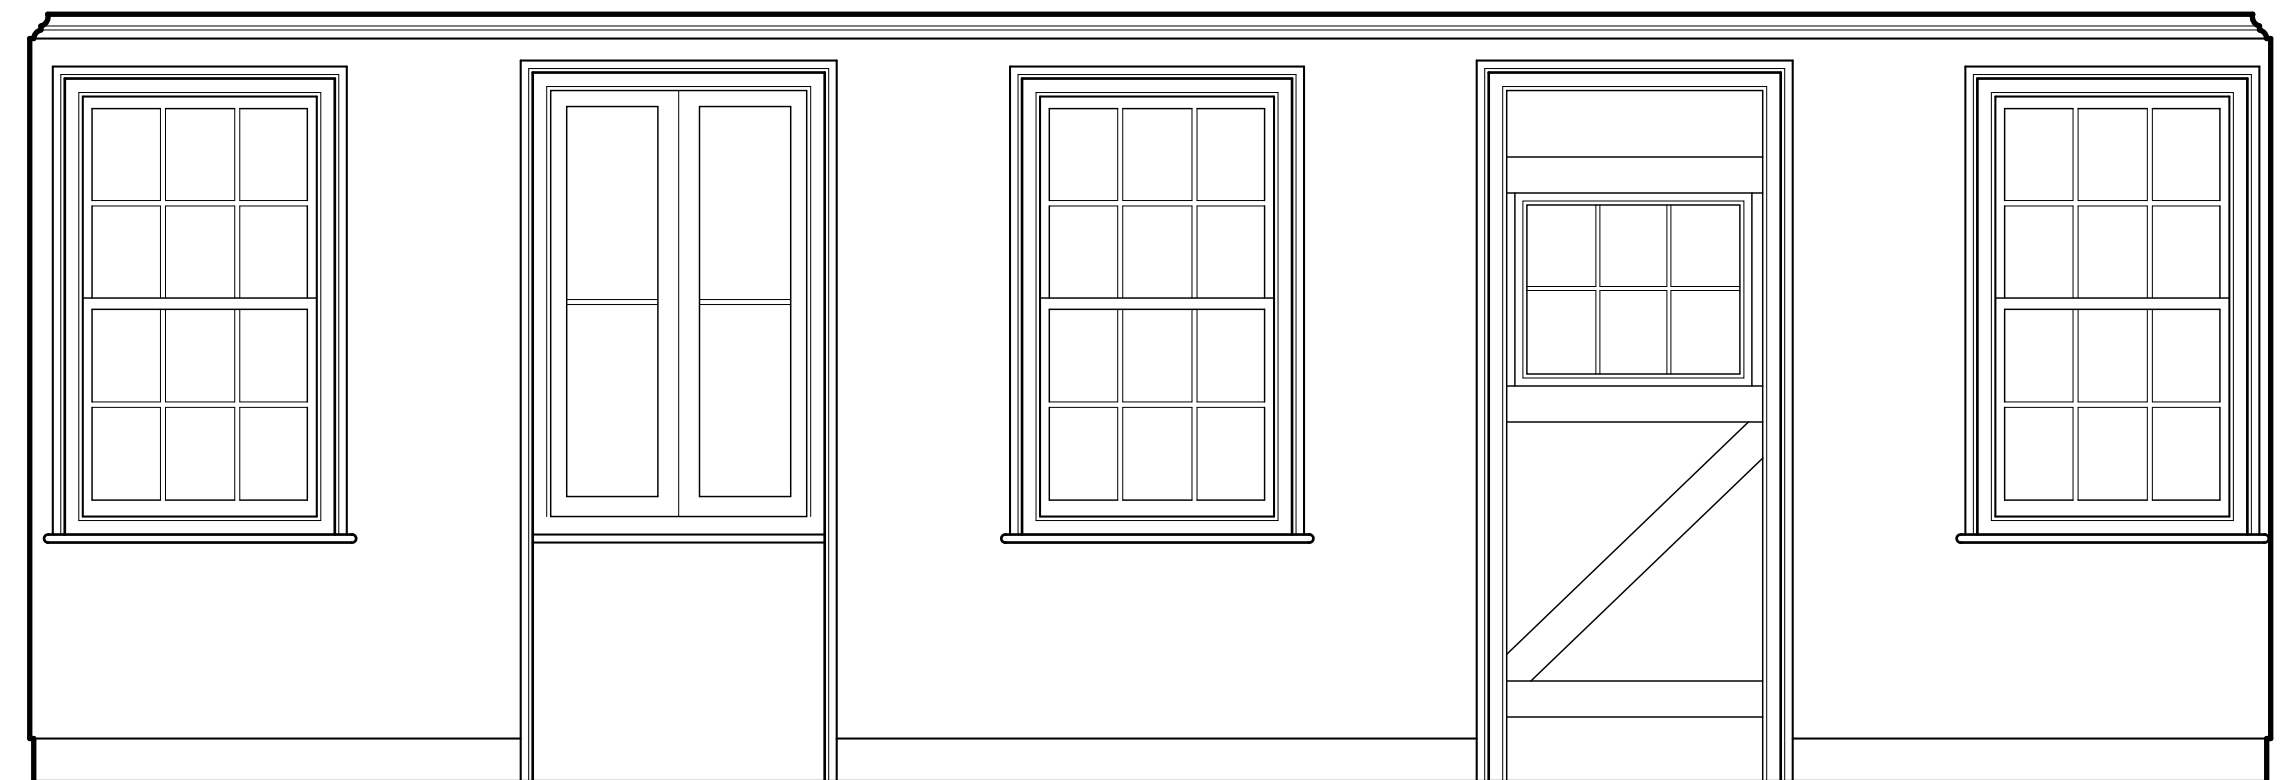


3
A404 GUEST BEDROOM #208
SCALE: 1/2" = 1'-0"

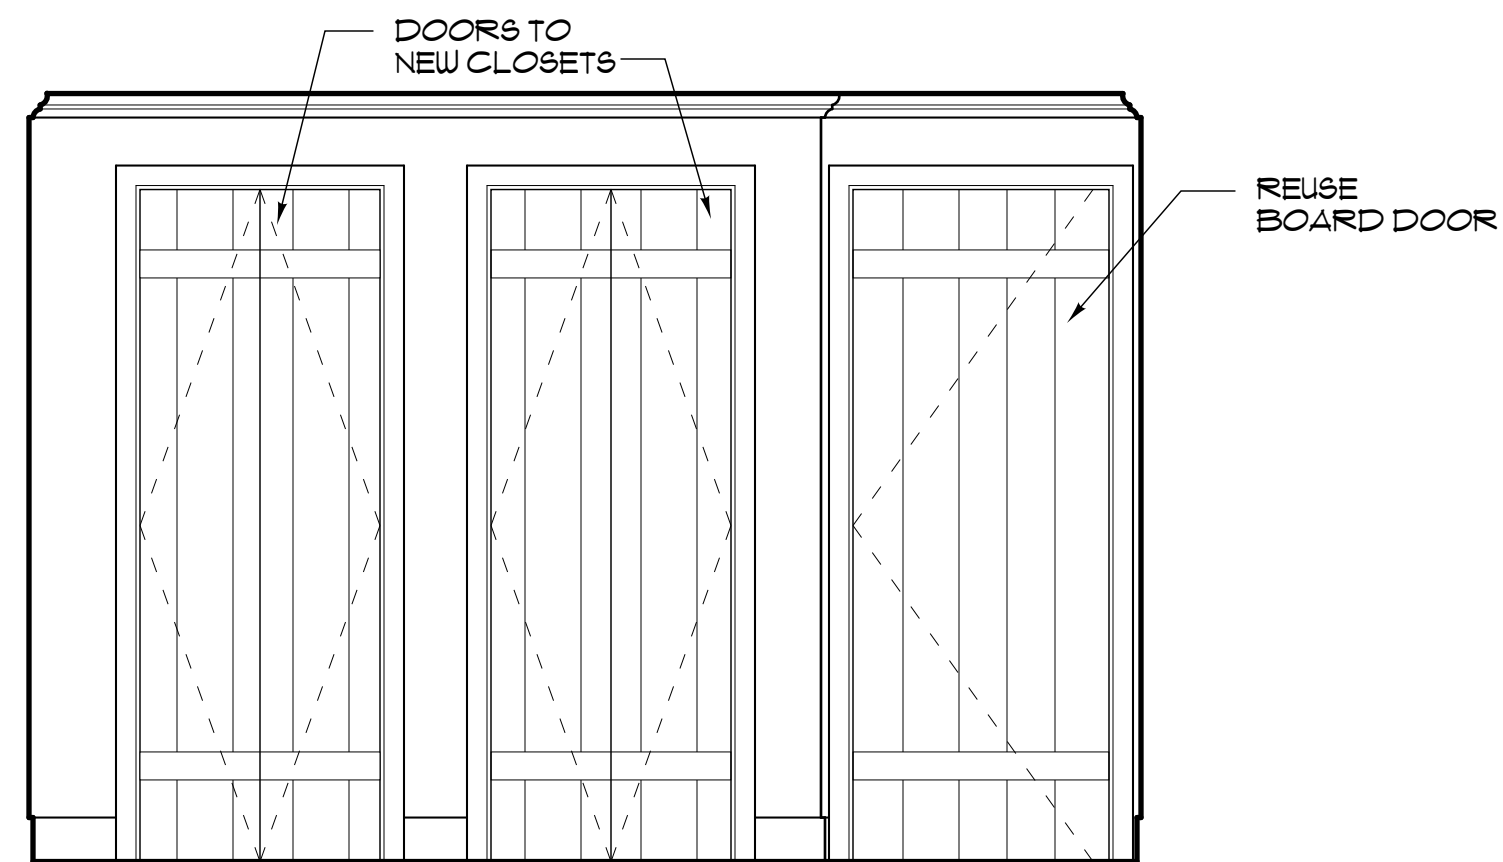

4
A404 GUEST BEDROOM #208
SCALE: 1/2" = 1'-0"

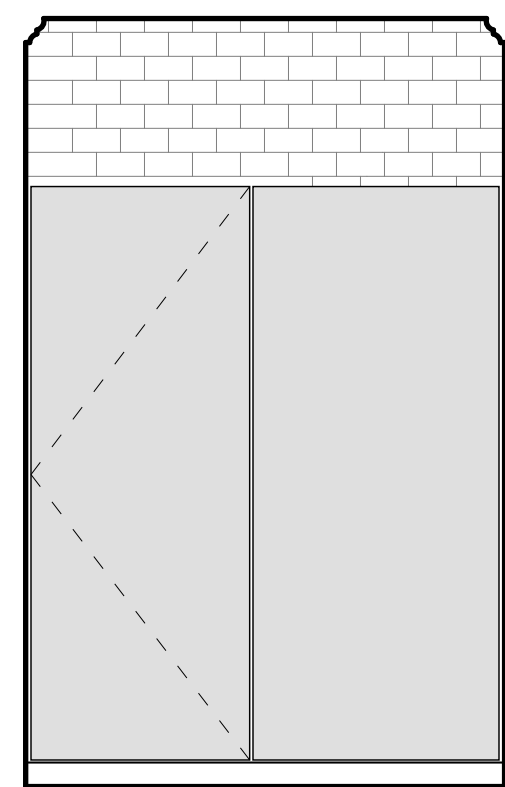


5
A404 GUEST BATH #207
SCALE: 1/2" = 1'-0"

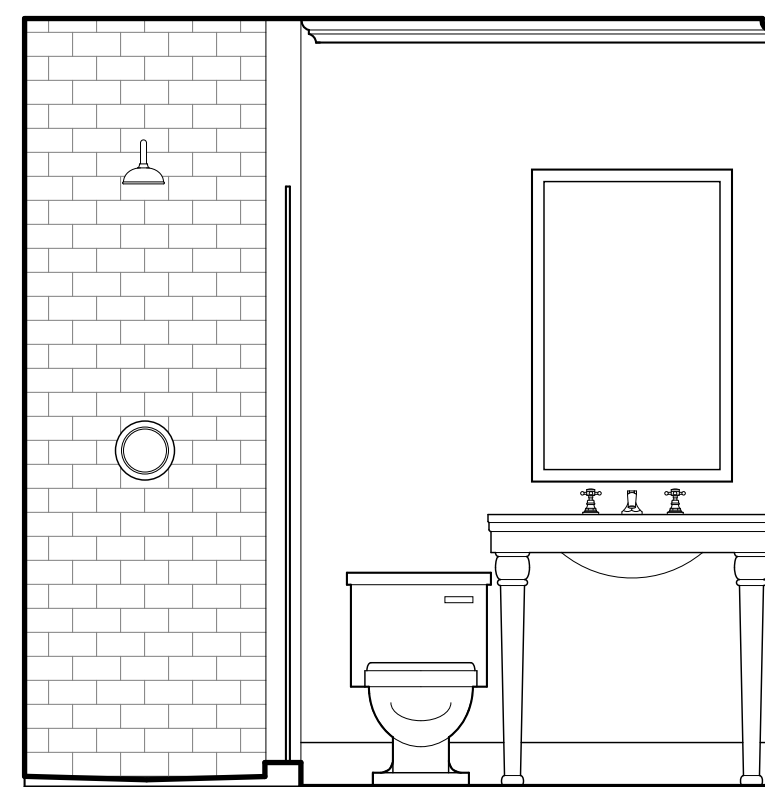


6
A404 GUEST BATH #207
SCALE: 1/2" = 1'-0"




7
A404 GUEST BATH #207
SCALE: 1/2" = 1'-0"

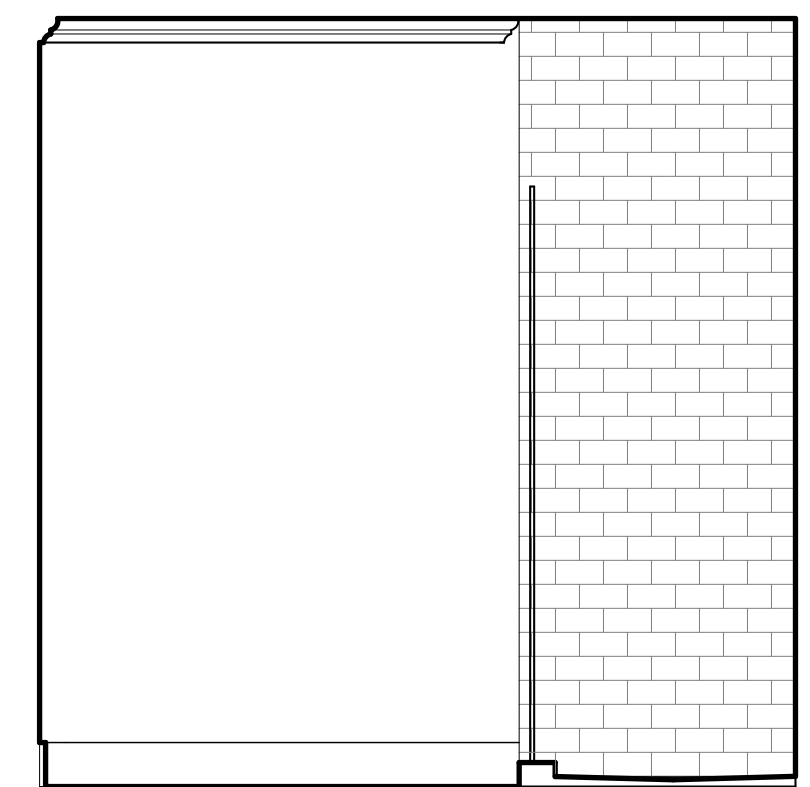


8
A404 GUEST BATH #207
SCALE: 1/2" = 1'-0"

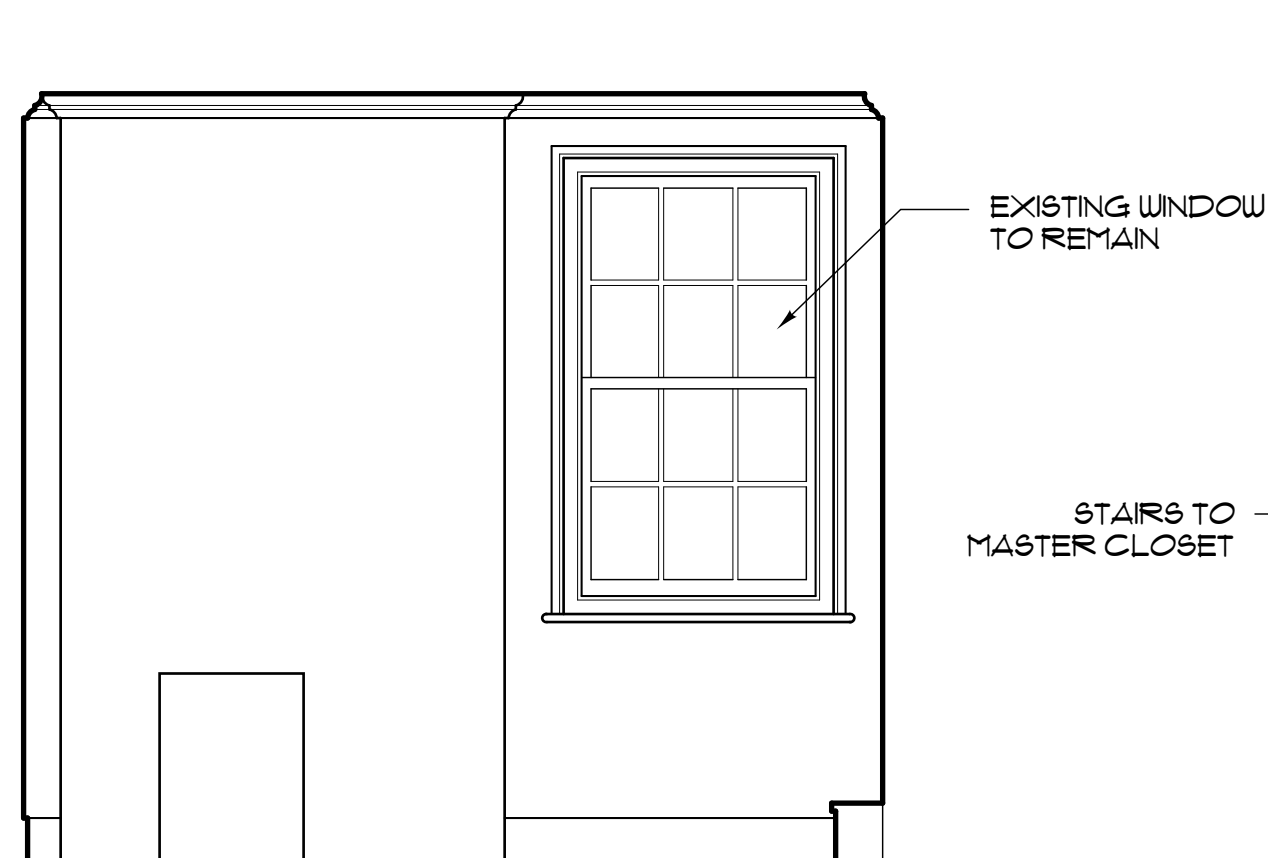


9
A404 OFFICE / SITTING ROOM #206
SCALE: 1/2" = 1'-0"

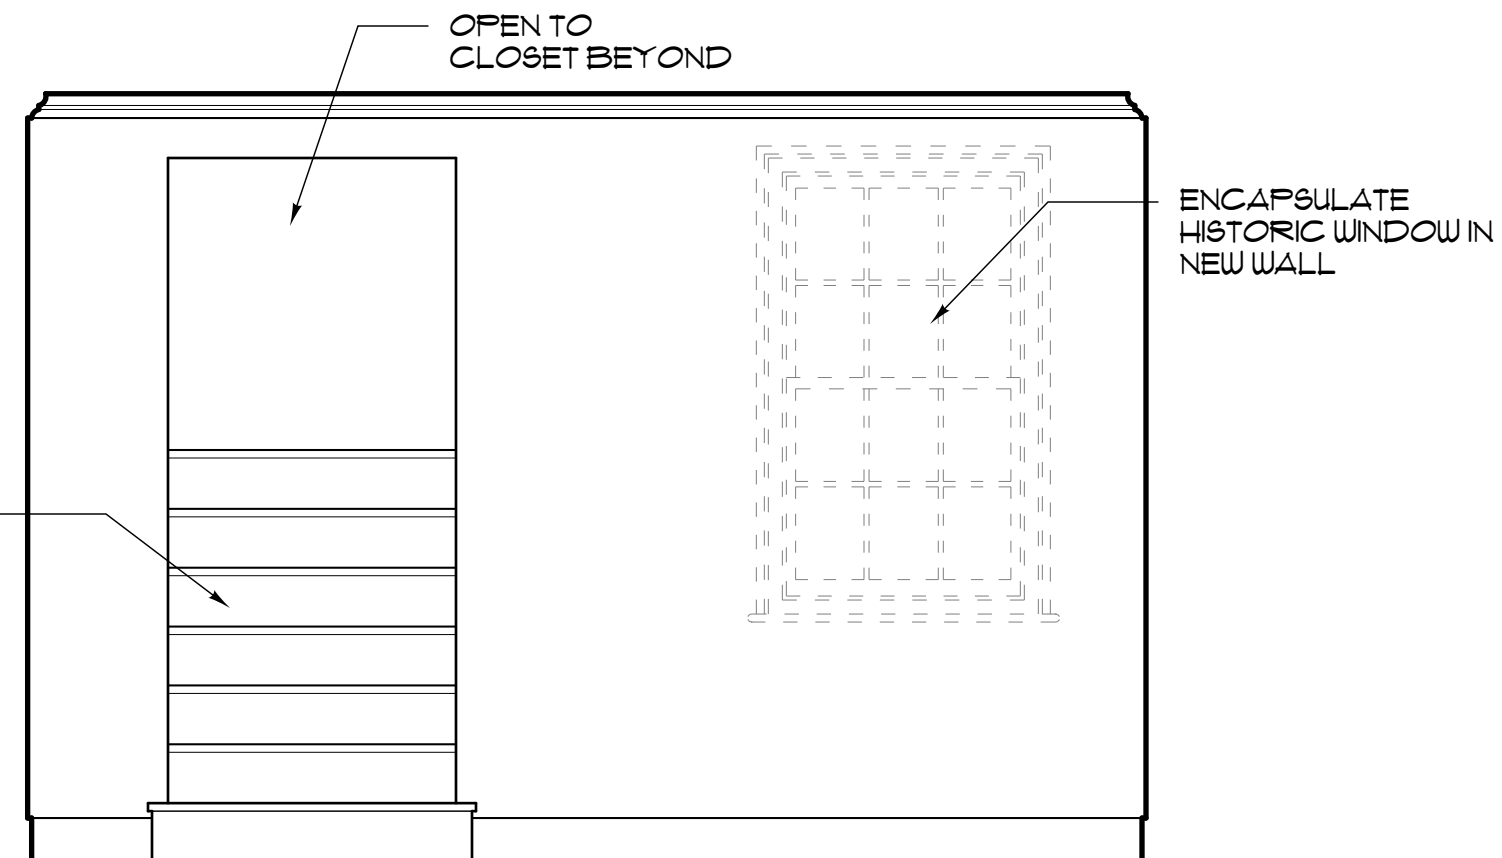

10
A404 OFFICE / SITTING ROOM #206
SCALE: 1/2" = 1'-0"

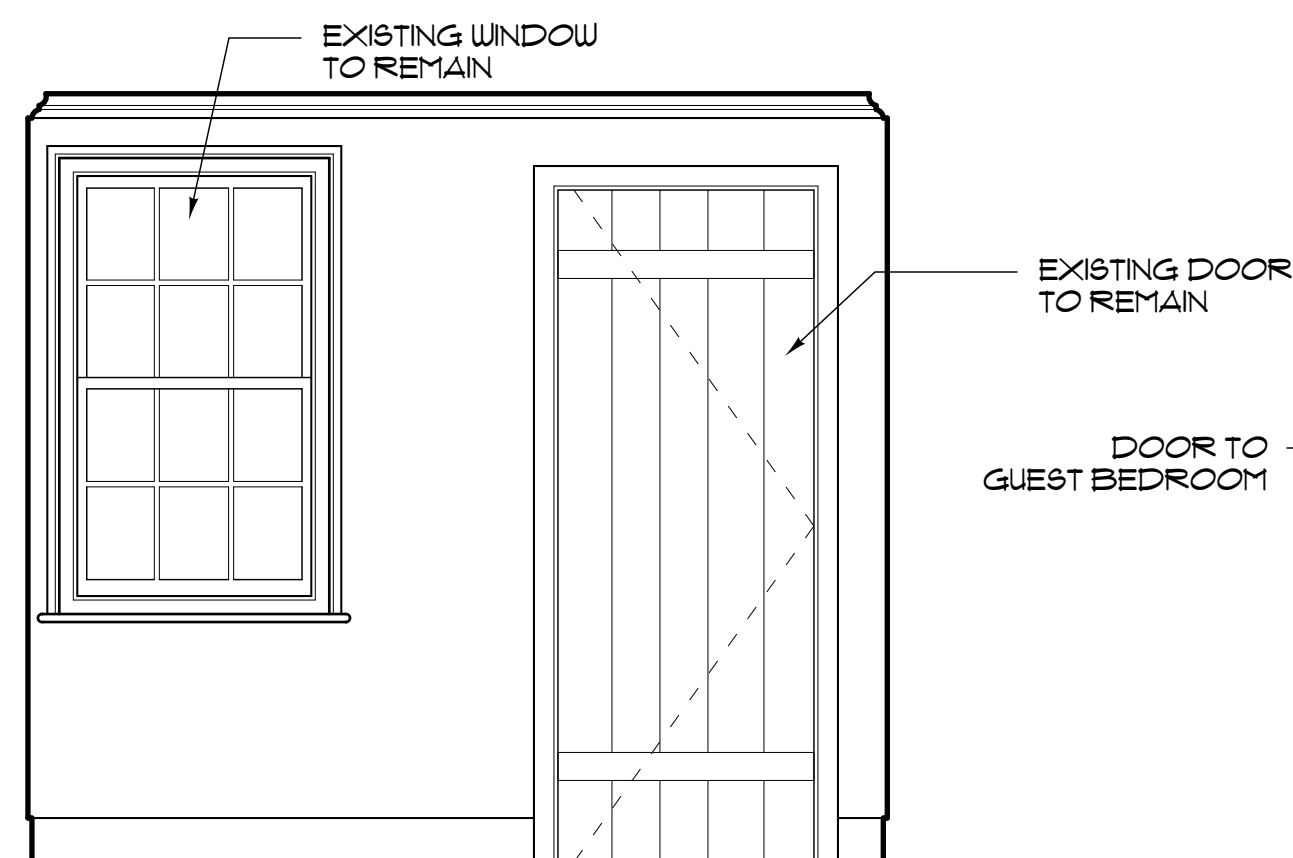

11
A404 OFFICE / SITTING ROOM #206
SCALE: 1/2" = 1'-0"

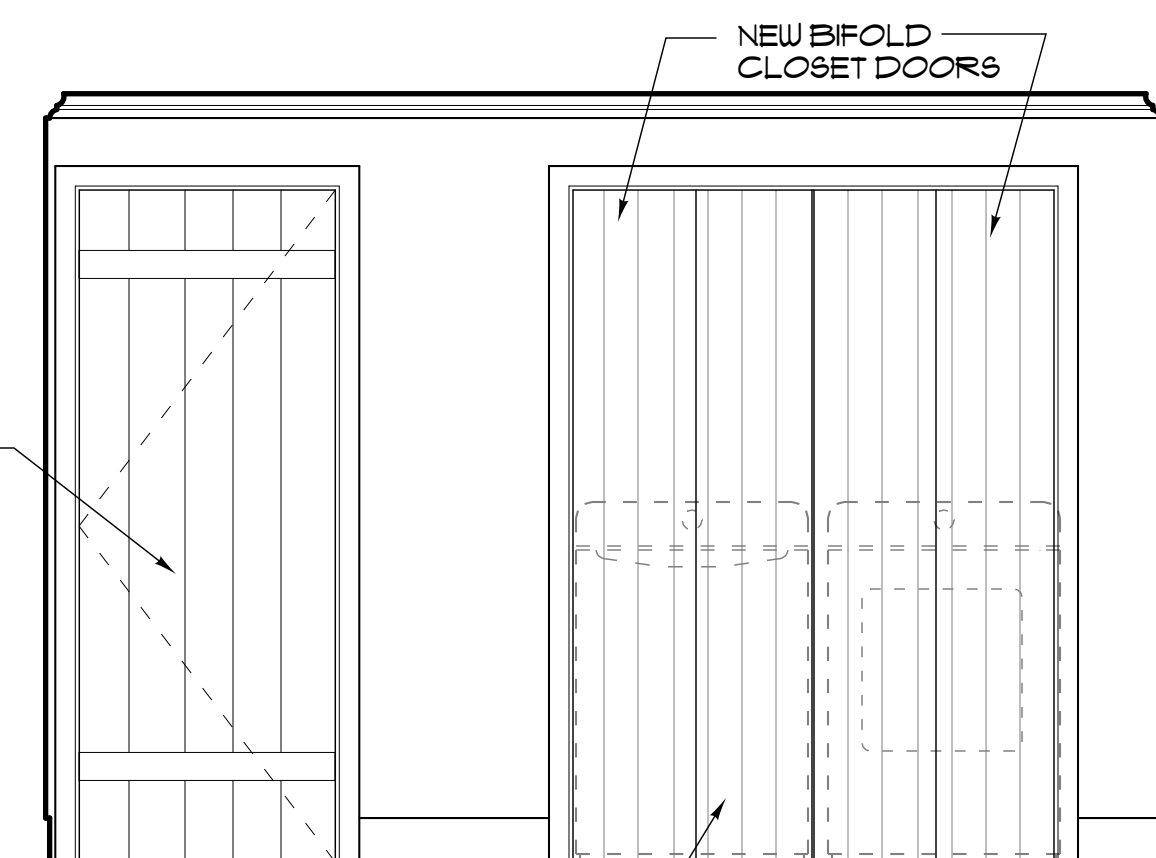

12
A404 OFFICE / SITTING ROOM #206
SCALE: 1/2" = 1'-0"


Glenn Keyes
Architects

12 Vanderhorst Street
Charleston, SC 29403
(843) 722-4100
www.glennkeyesarchitects.com

A REHABILITATION OF
35 LEGARE STREET
THE ELIZABETH WILLIAMS HOUSE
C. 1790
CHARLESTON, SC


INTERIOR
ELEVATIONS

REV.	DATE
PROJECT NUMBER	1414
DRAWING DATE	10/10/16
SHEET NUMBER	A404

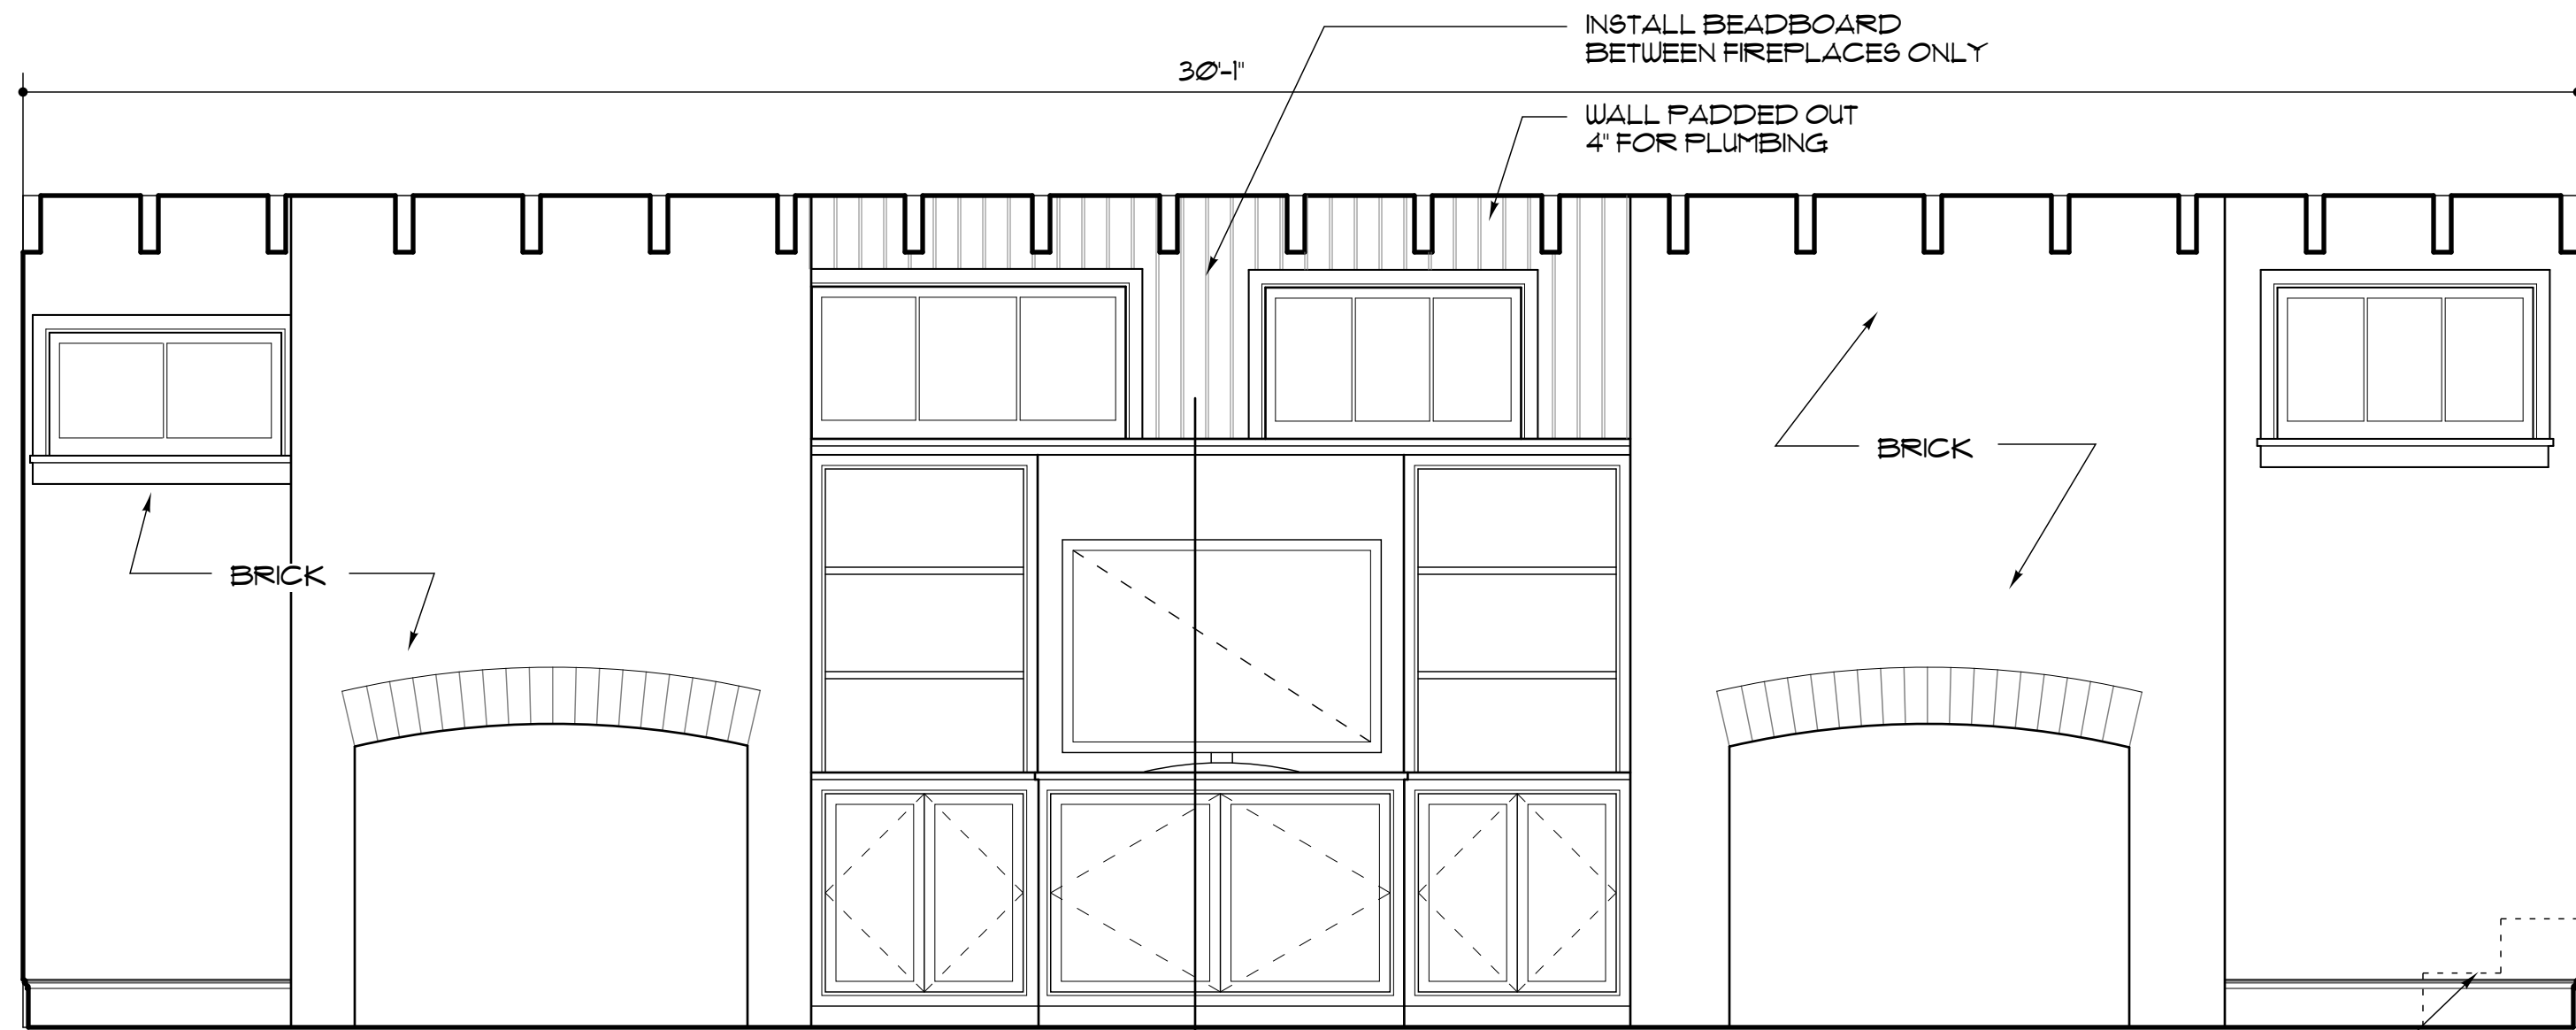


1 FAMILY ROOM #106
A405 SCALE: 1/2" = 1'-0"


la
A405

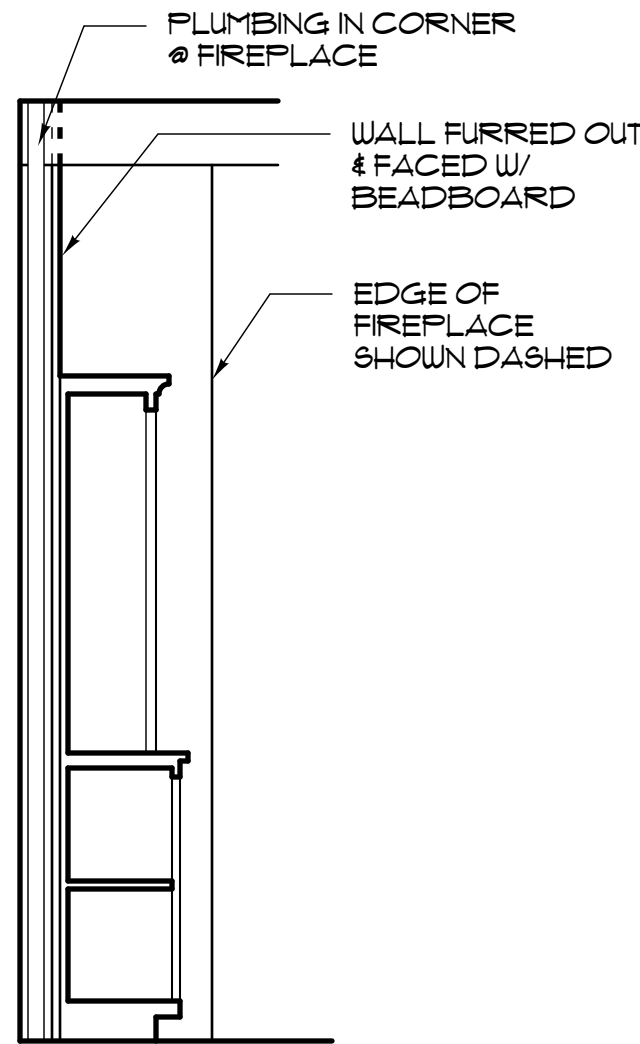


1a BUILT IN
A405 SCALE: 1/2" = 1'-0"

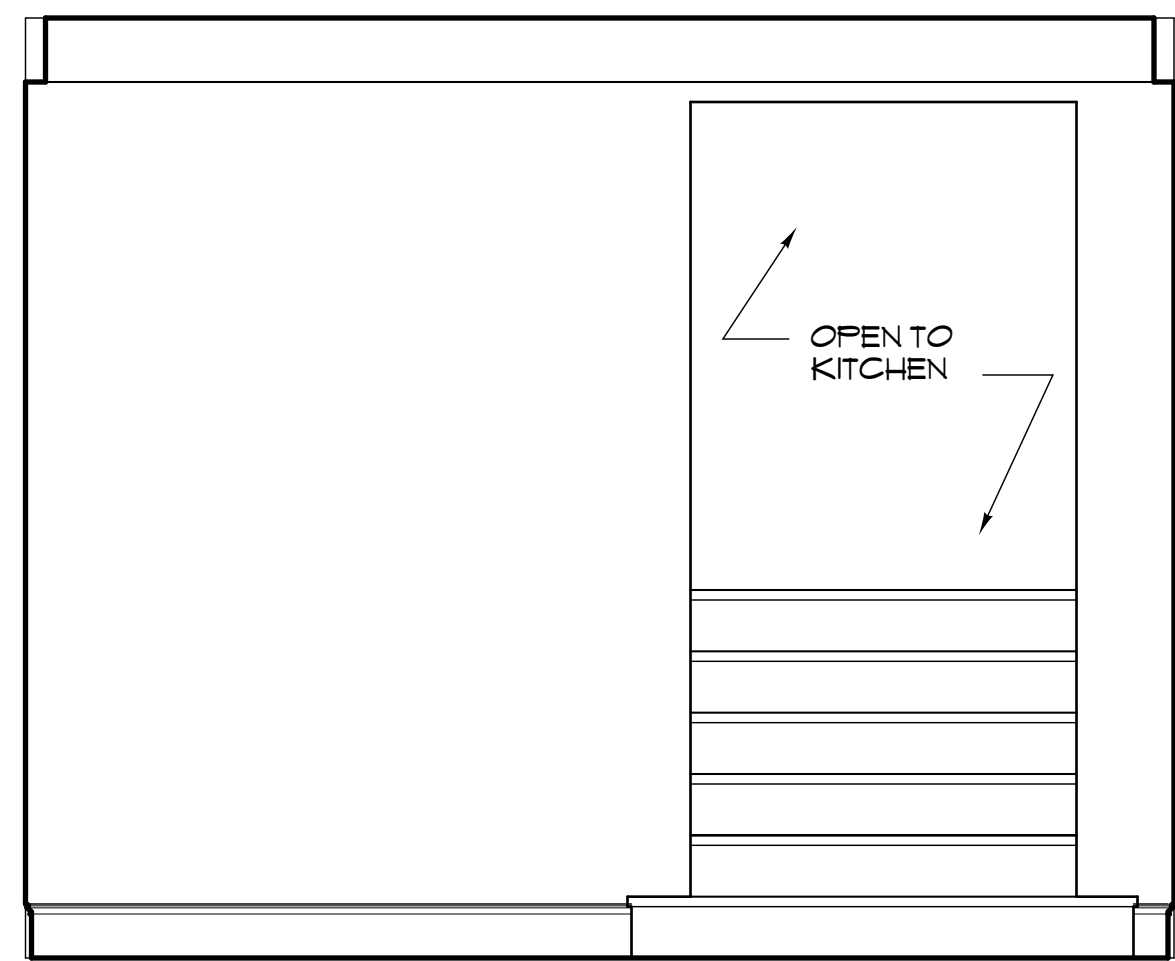


2 FAMILY ROOM #106
A405 SCALE: 1/2" = 1'-0"

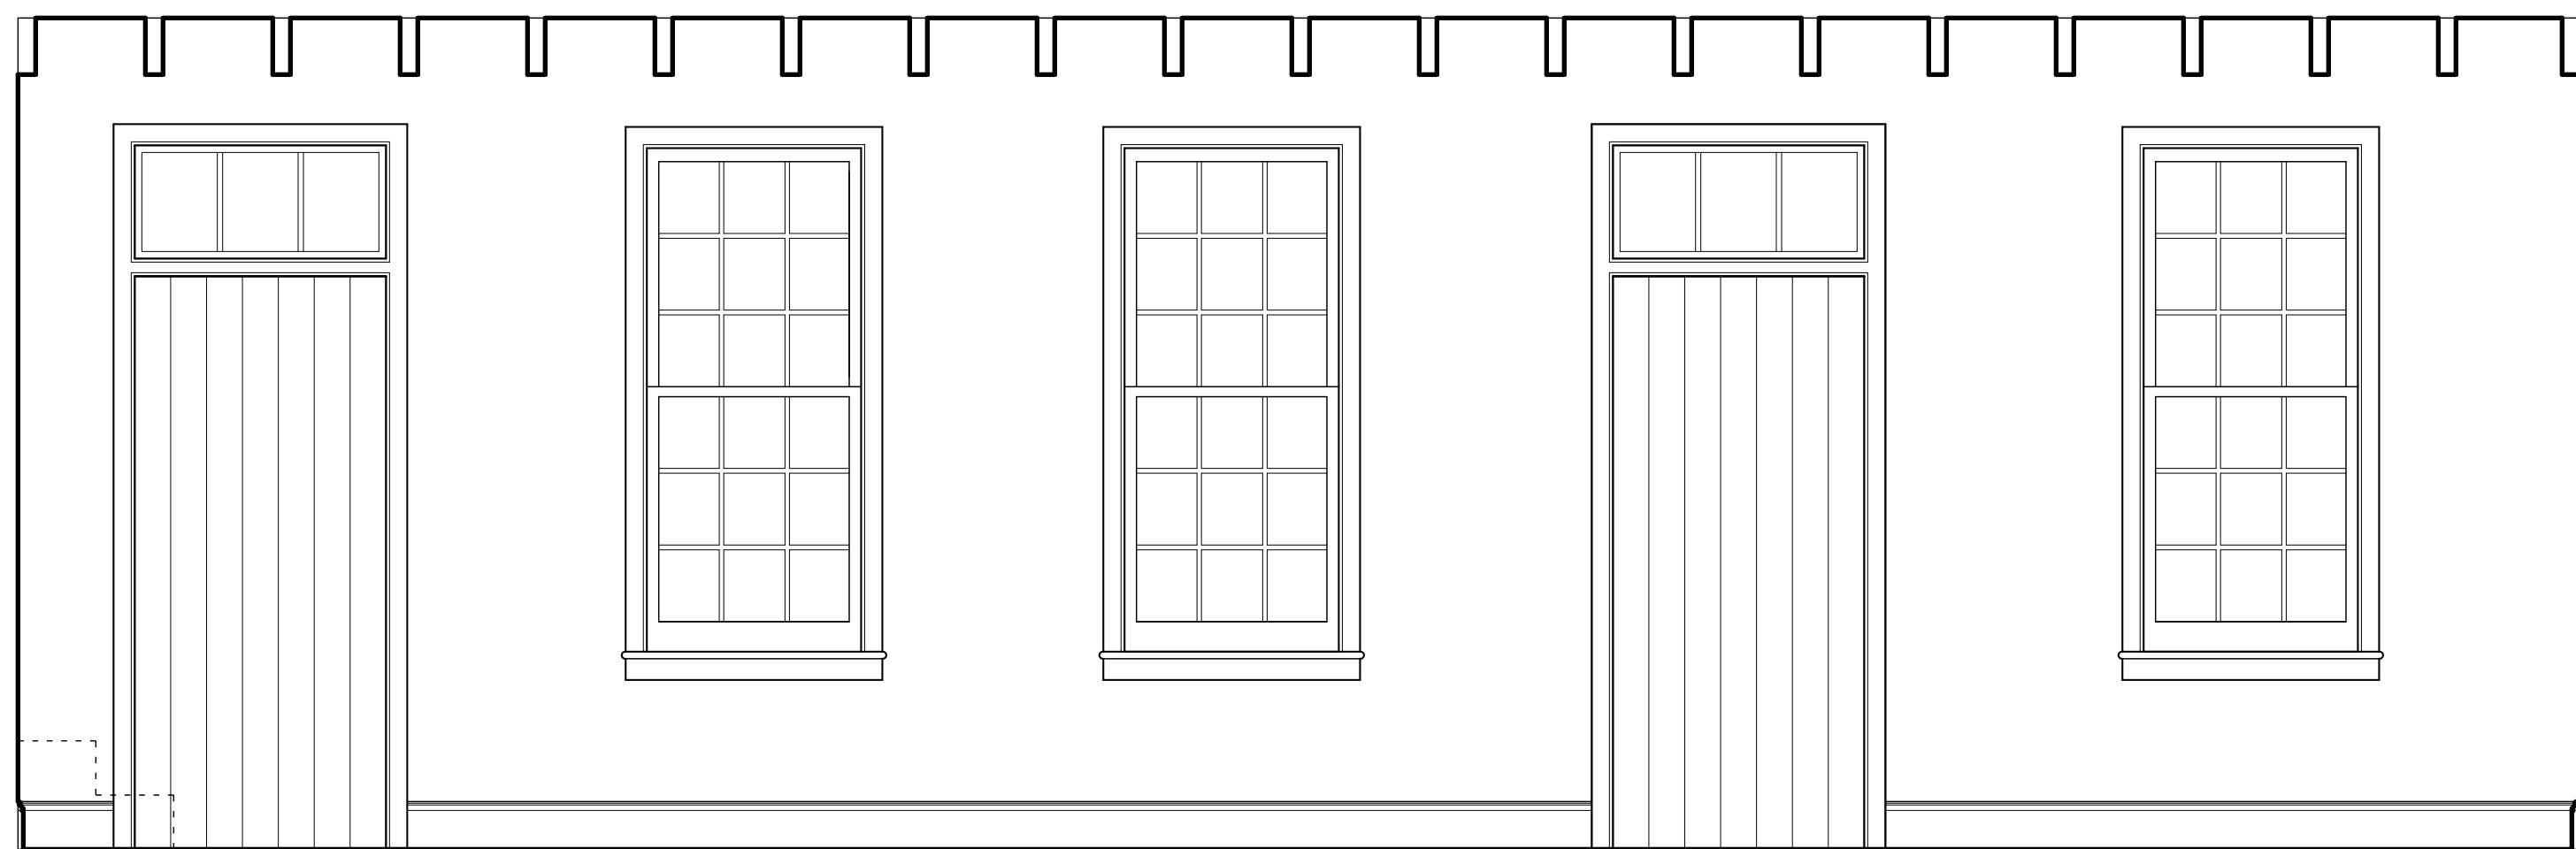

3 FAMILY ROOM #106
A405 SCALE: 1/2" = 1'-0"

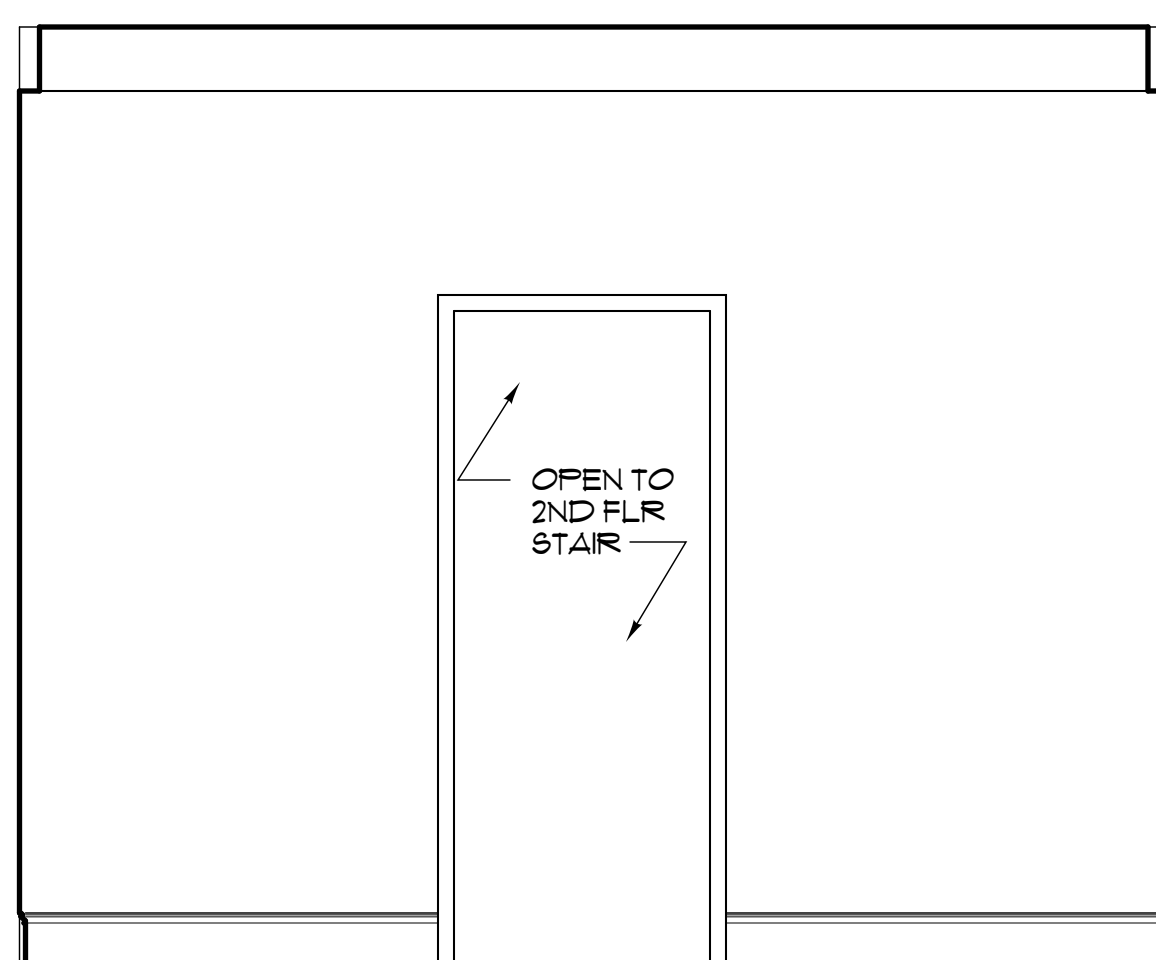

 
4 FAMILY ROOM #106
A405 SCALE: 1/2" = 1'-0"



5 STORAGE #109
A405 SCALE: 1/2" = 1'-0"




6 STORAGE #109
A405 SCALE: 1/2" = 1'-0"

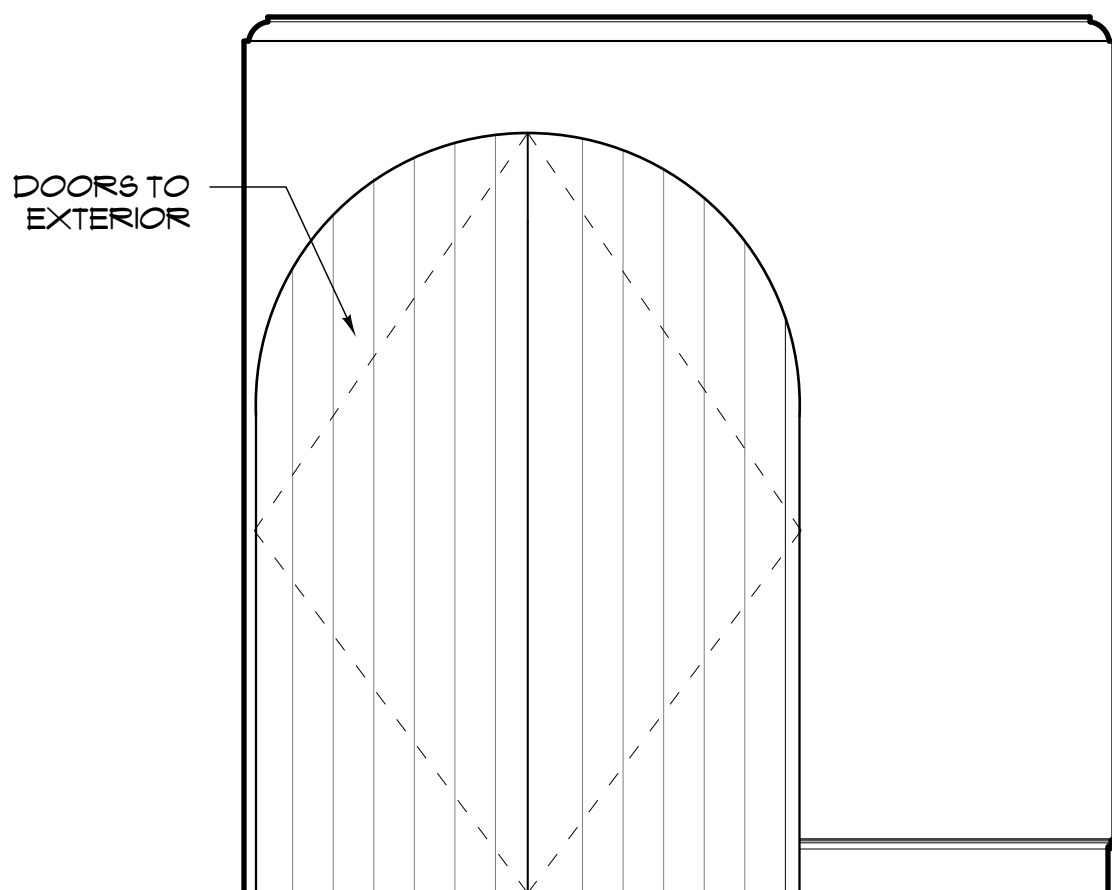

7 STORAGE #109
A405 SCALE: 1/2" = 1'-0"




8 STORAGE #109
A405 SCALE: 1/2" = 1'-0"

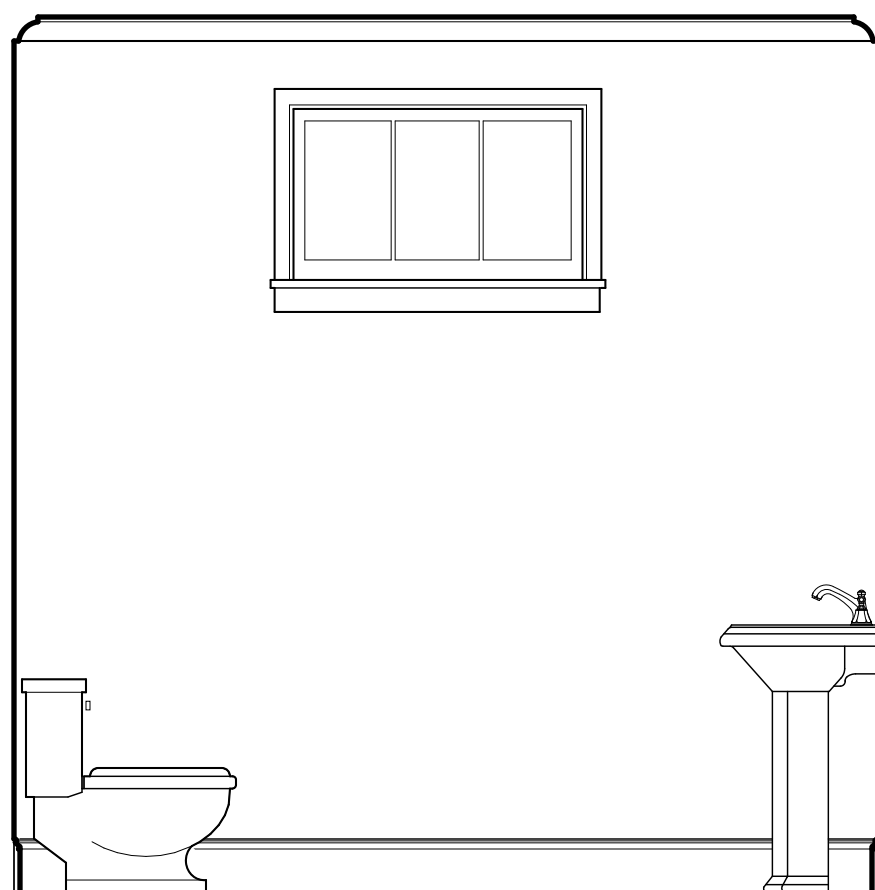


9 POWDER RM #107
A405 SCALE: 1/2" = 1'-0"



10 POWDER RM #107
A405 SCALE: 1/2" = 1'-0"

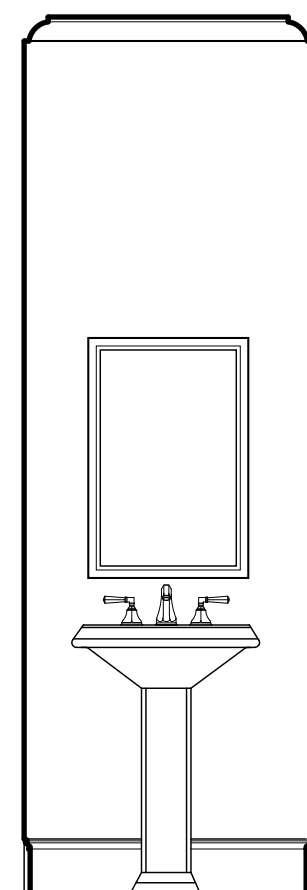

11 POWDER RM #107
A405 SCALE: 1/2" = 1'-0"

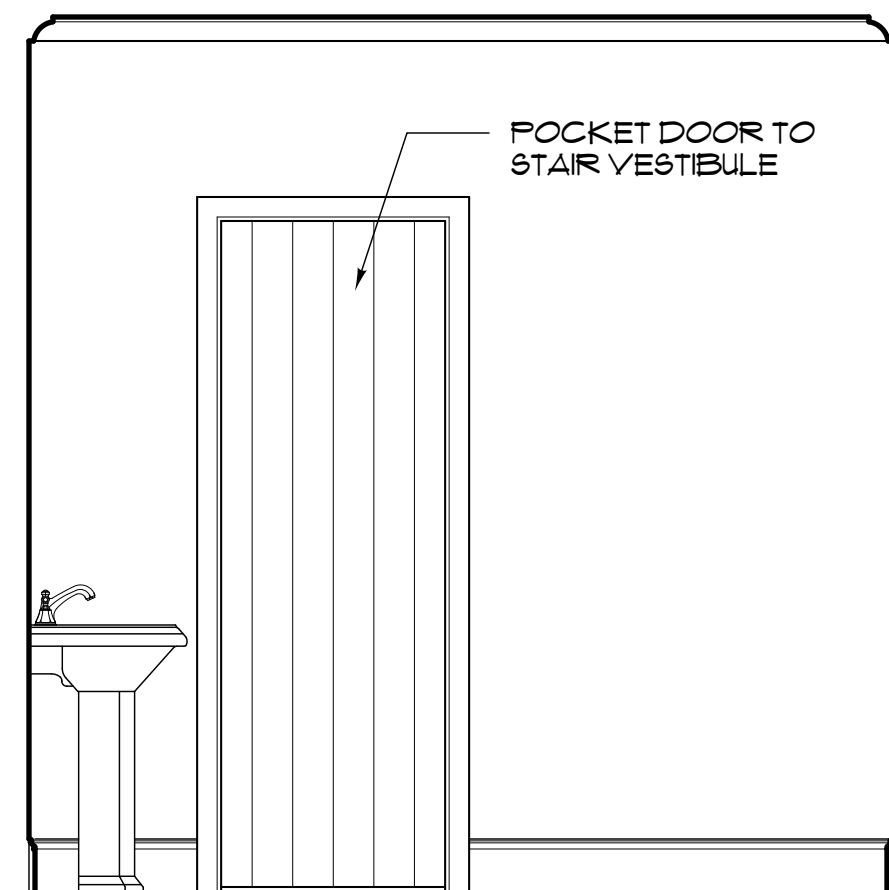


12 POWDER RM #107
A405 SCALE: 1/2" = 1'-0"

A REHABILITATION OF
35 LEGARE STREET
THE ELIZABETH WILLIAMS HOUSE
C. 1790
CHARLESTON, SC


INTERIOR
ELEVATIONS

REV.	DATE
PROJECT NUMBER	1414
DRAWING DATE	10/10/16
SHEET NUMBER	A405


Glenn Keyes Architects
12 Vanderhorst Street
Charleston, SC 29403
(843) 722-4100
www.glennkeyesarchitects.com

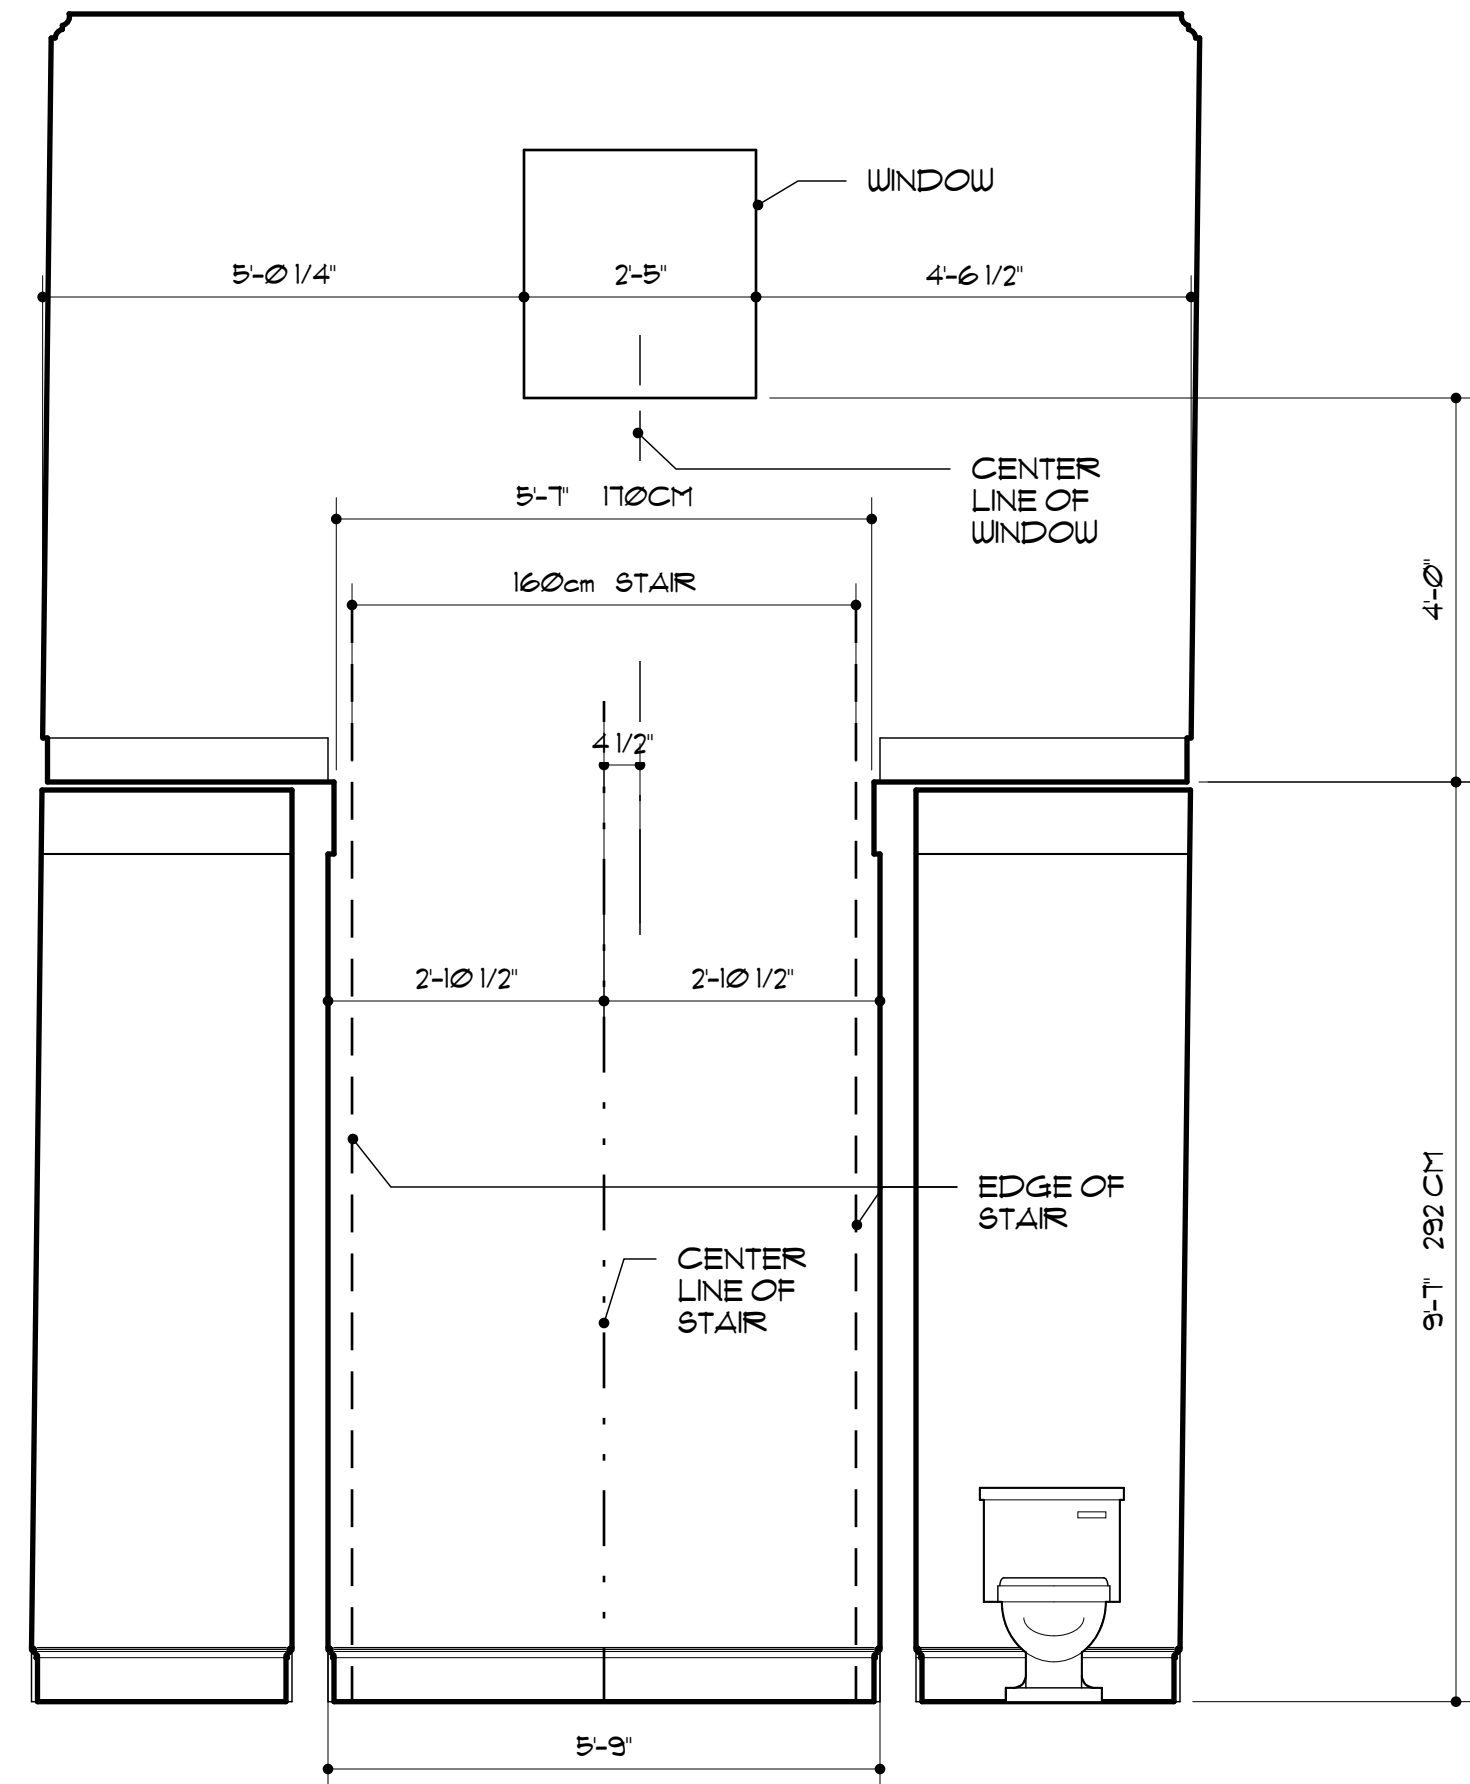


1
A406
STAIR WALL - WEST
SCALE: 1/2" = 1'-0"

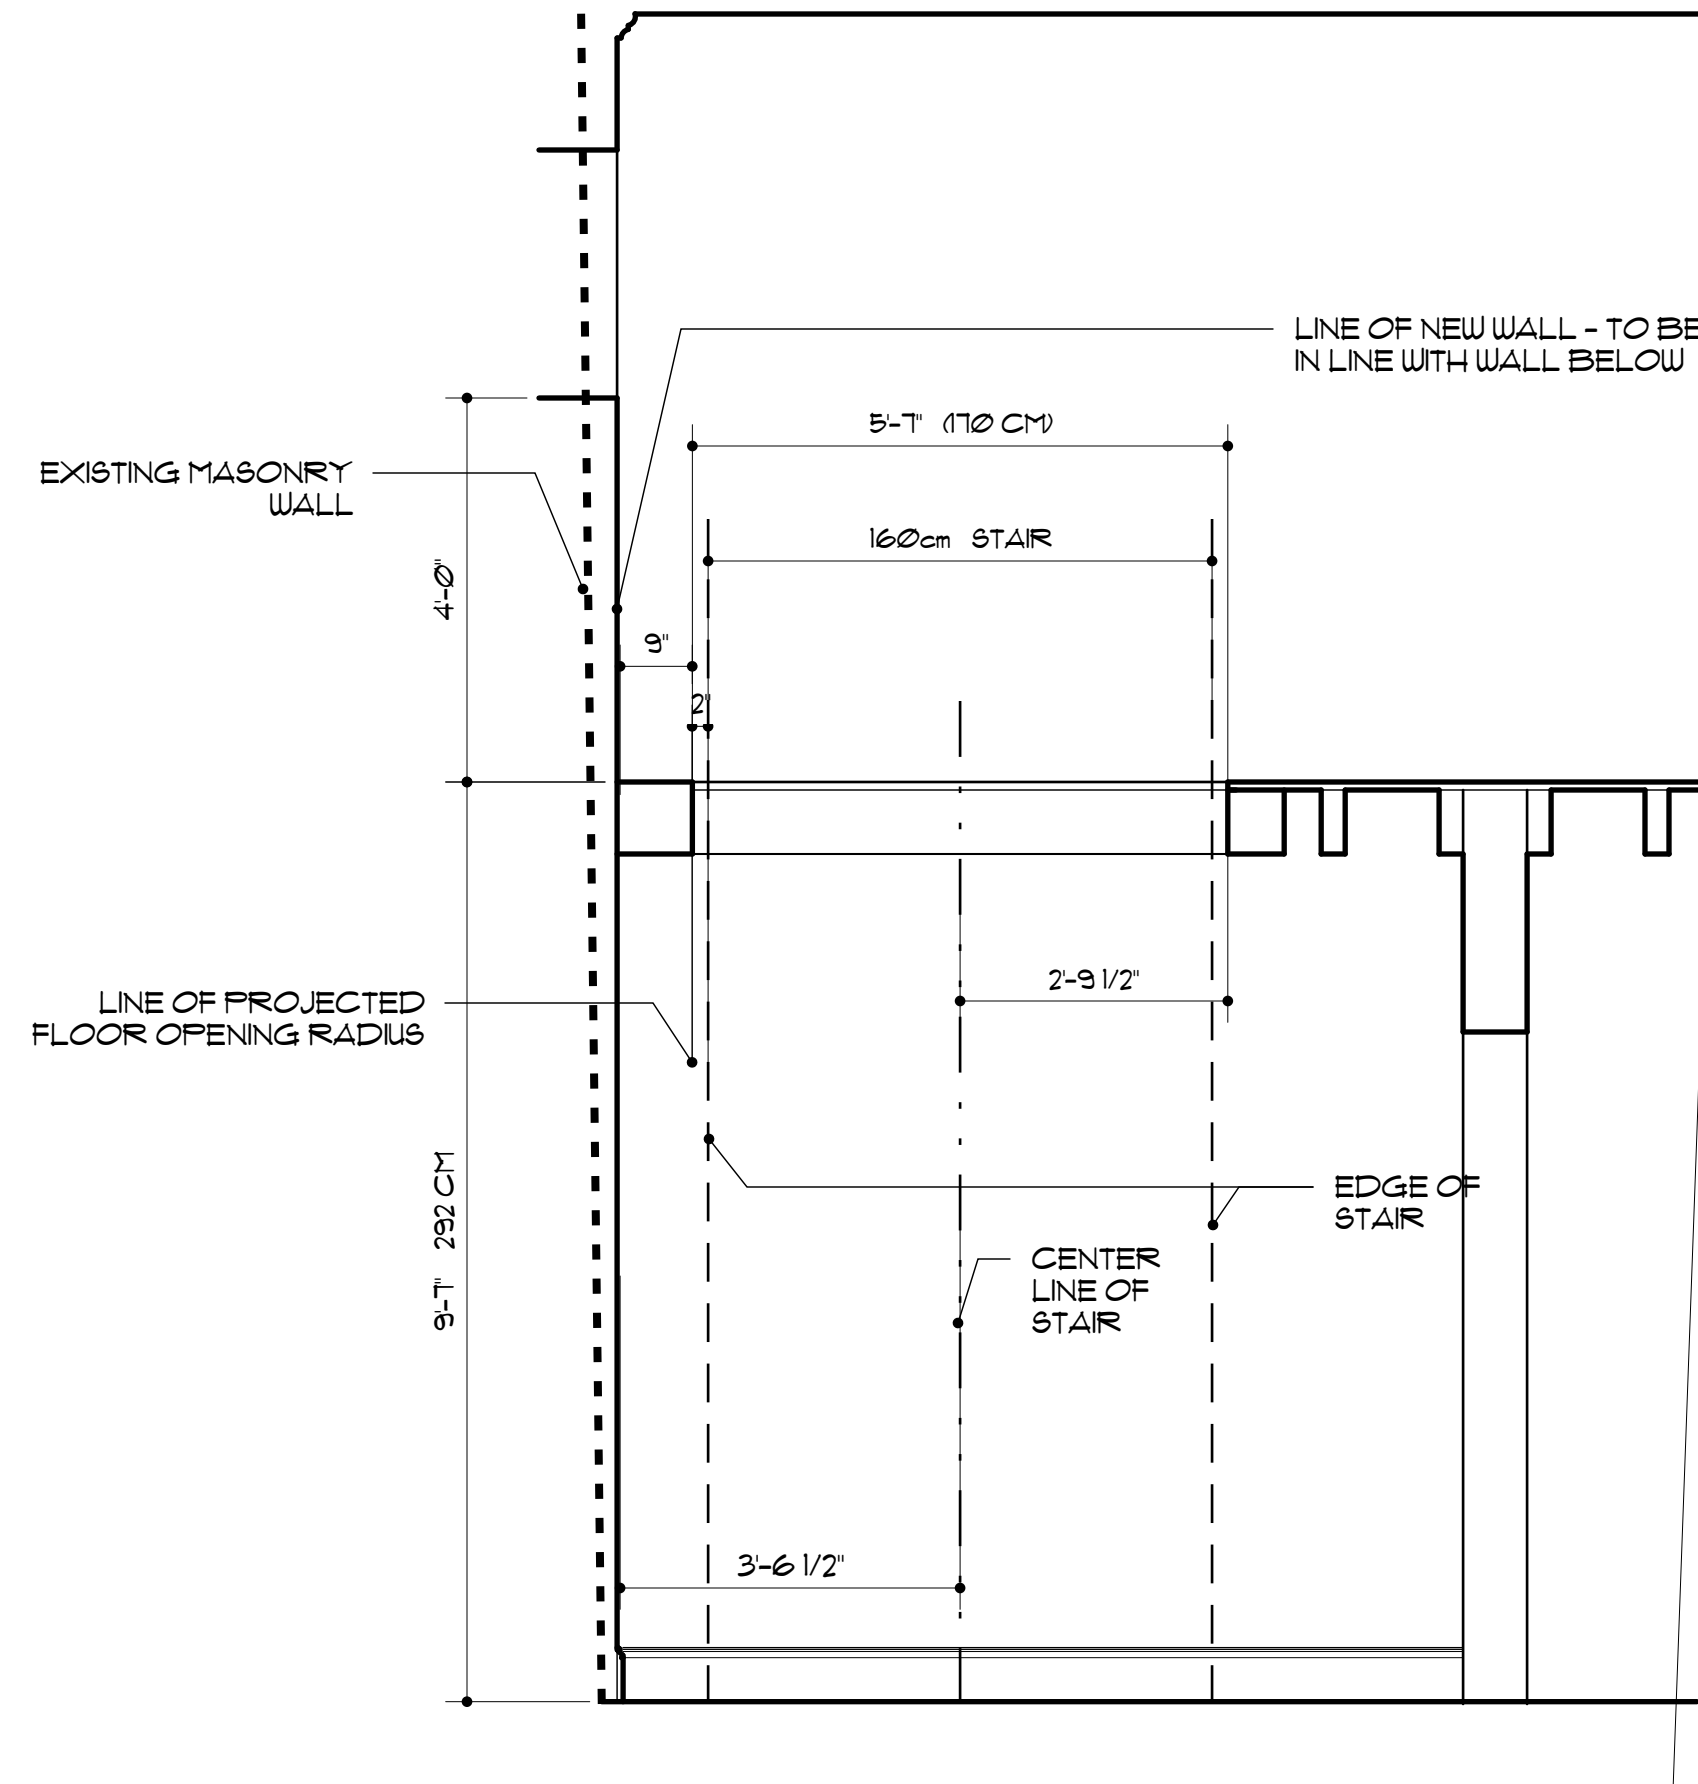





2
A406
STAIR WALL - NORTH
SCALE: 1/2" = 1'-0"

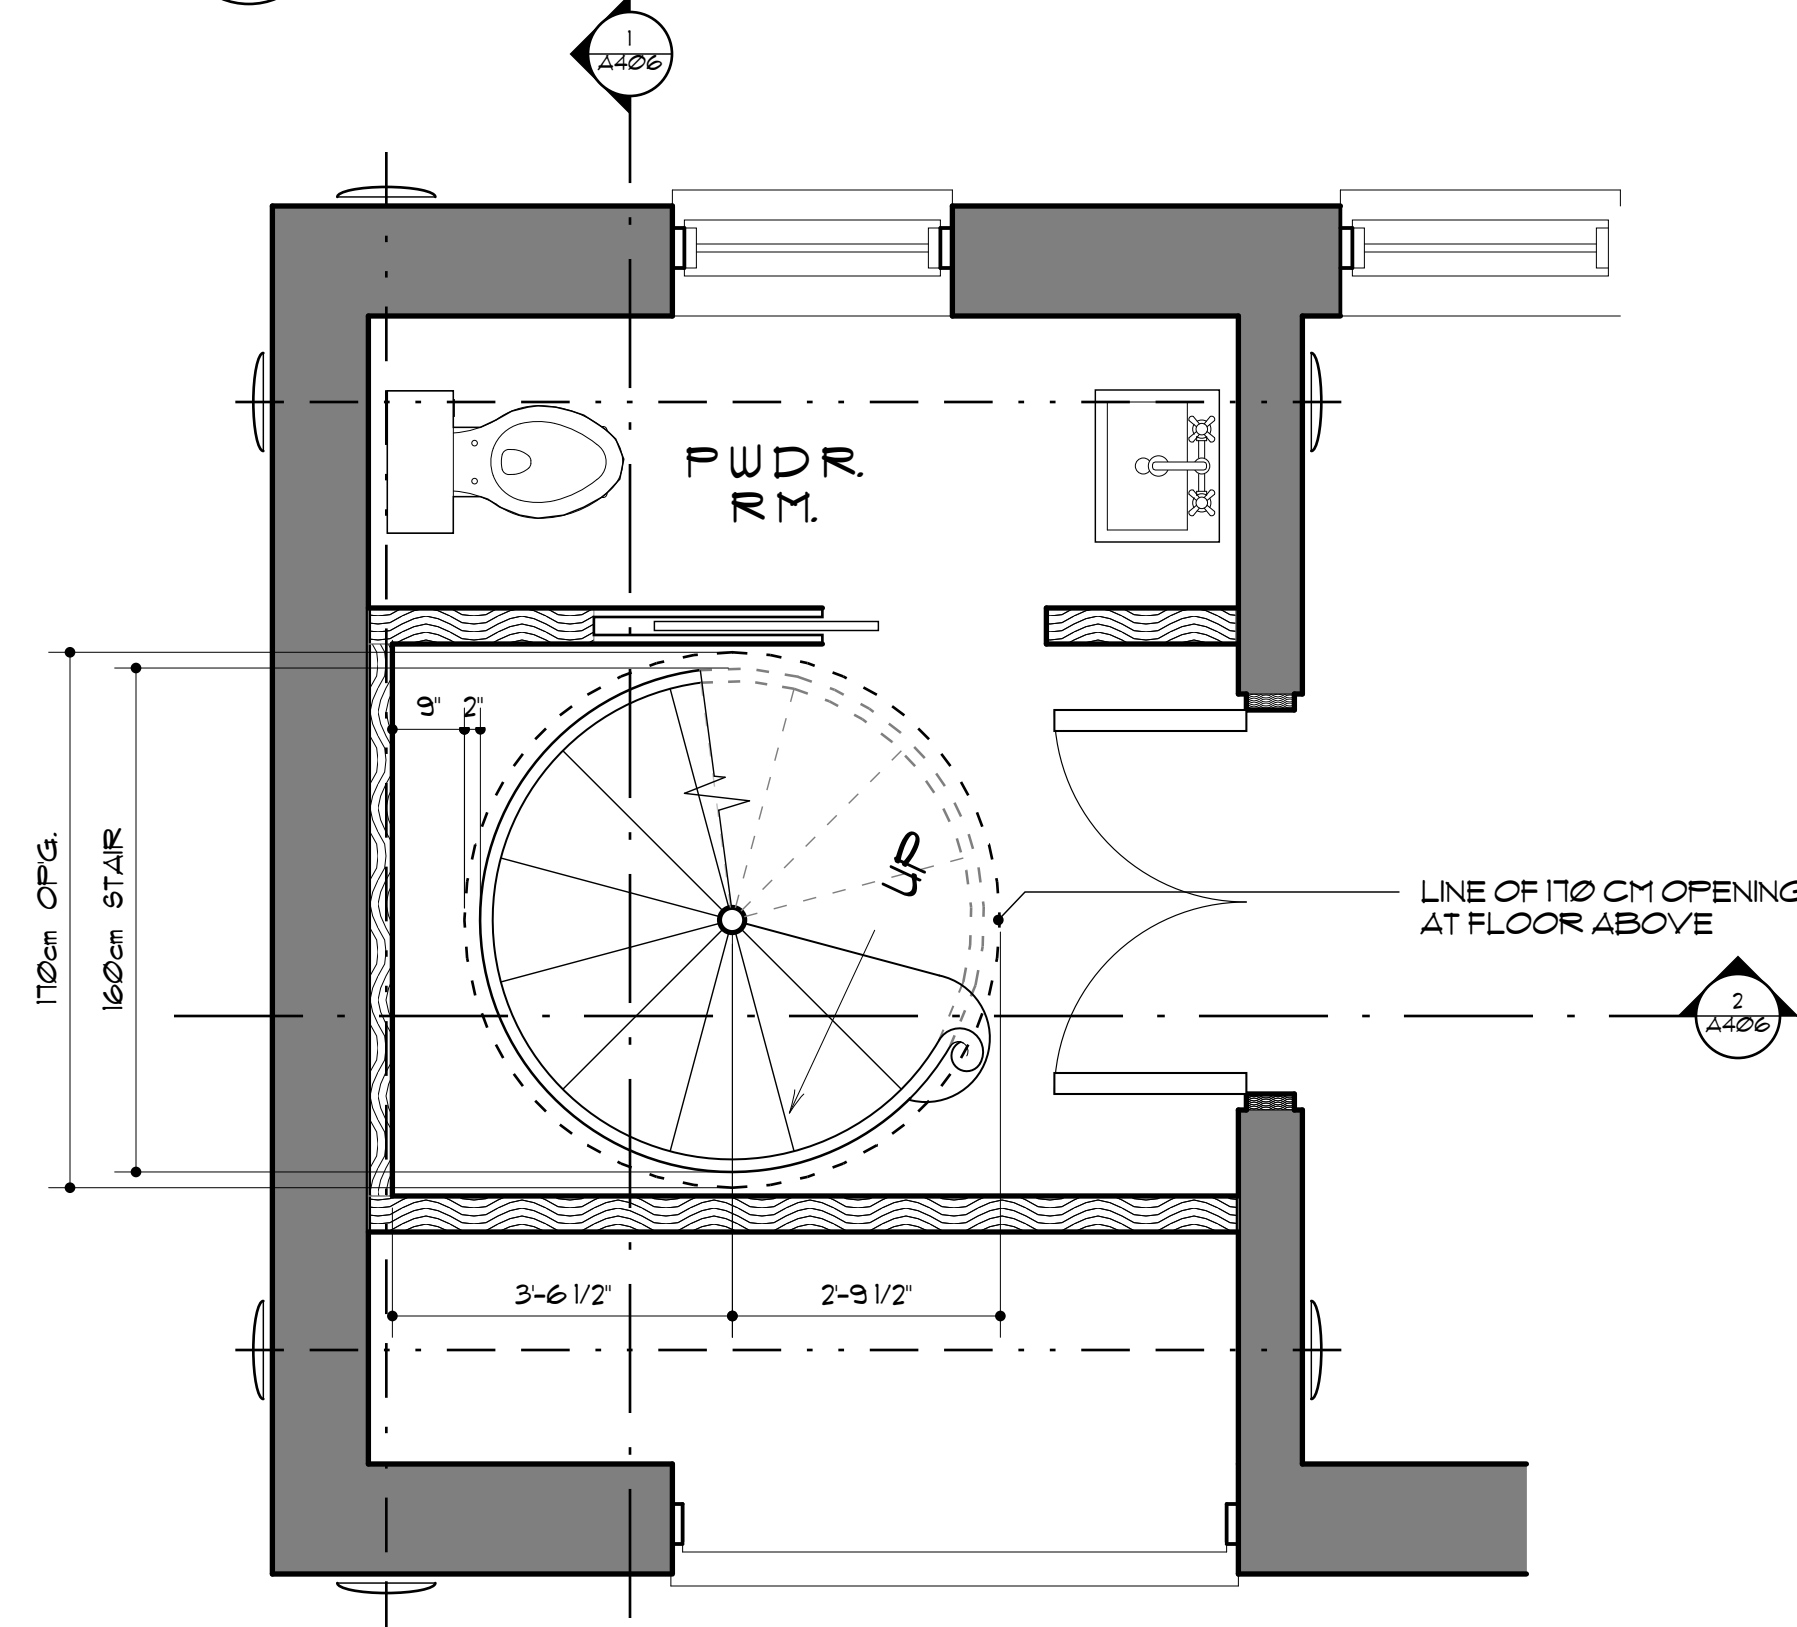

3
A406
FIRST FLOOR PLAN
SCALE: 1/2" = 1'-0"

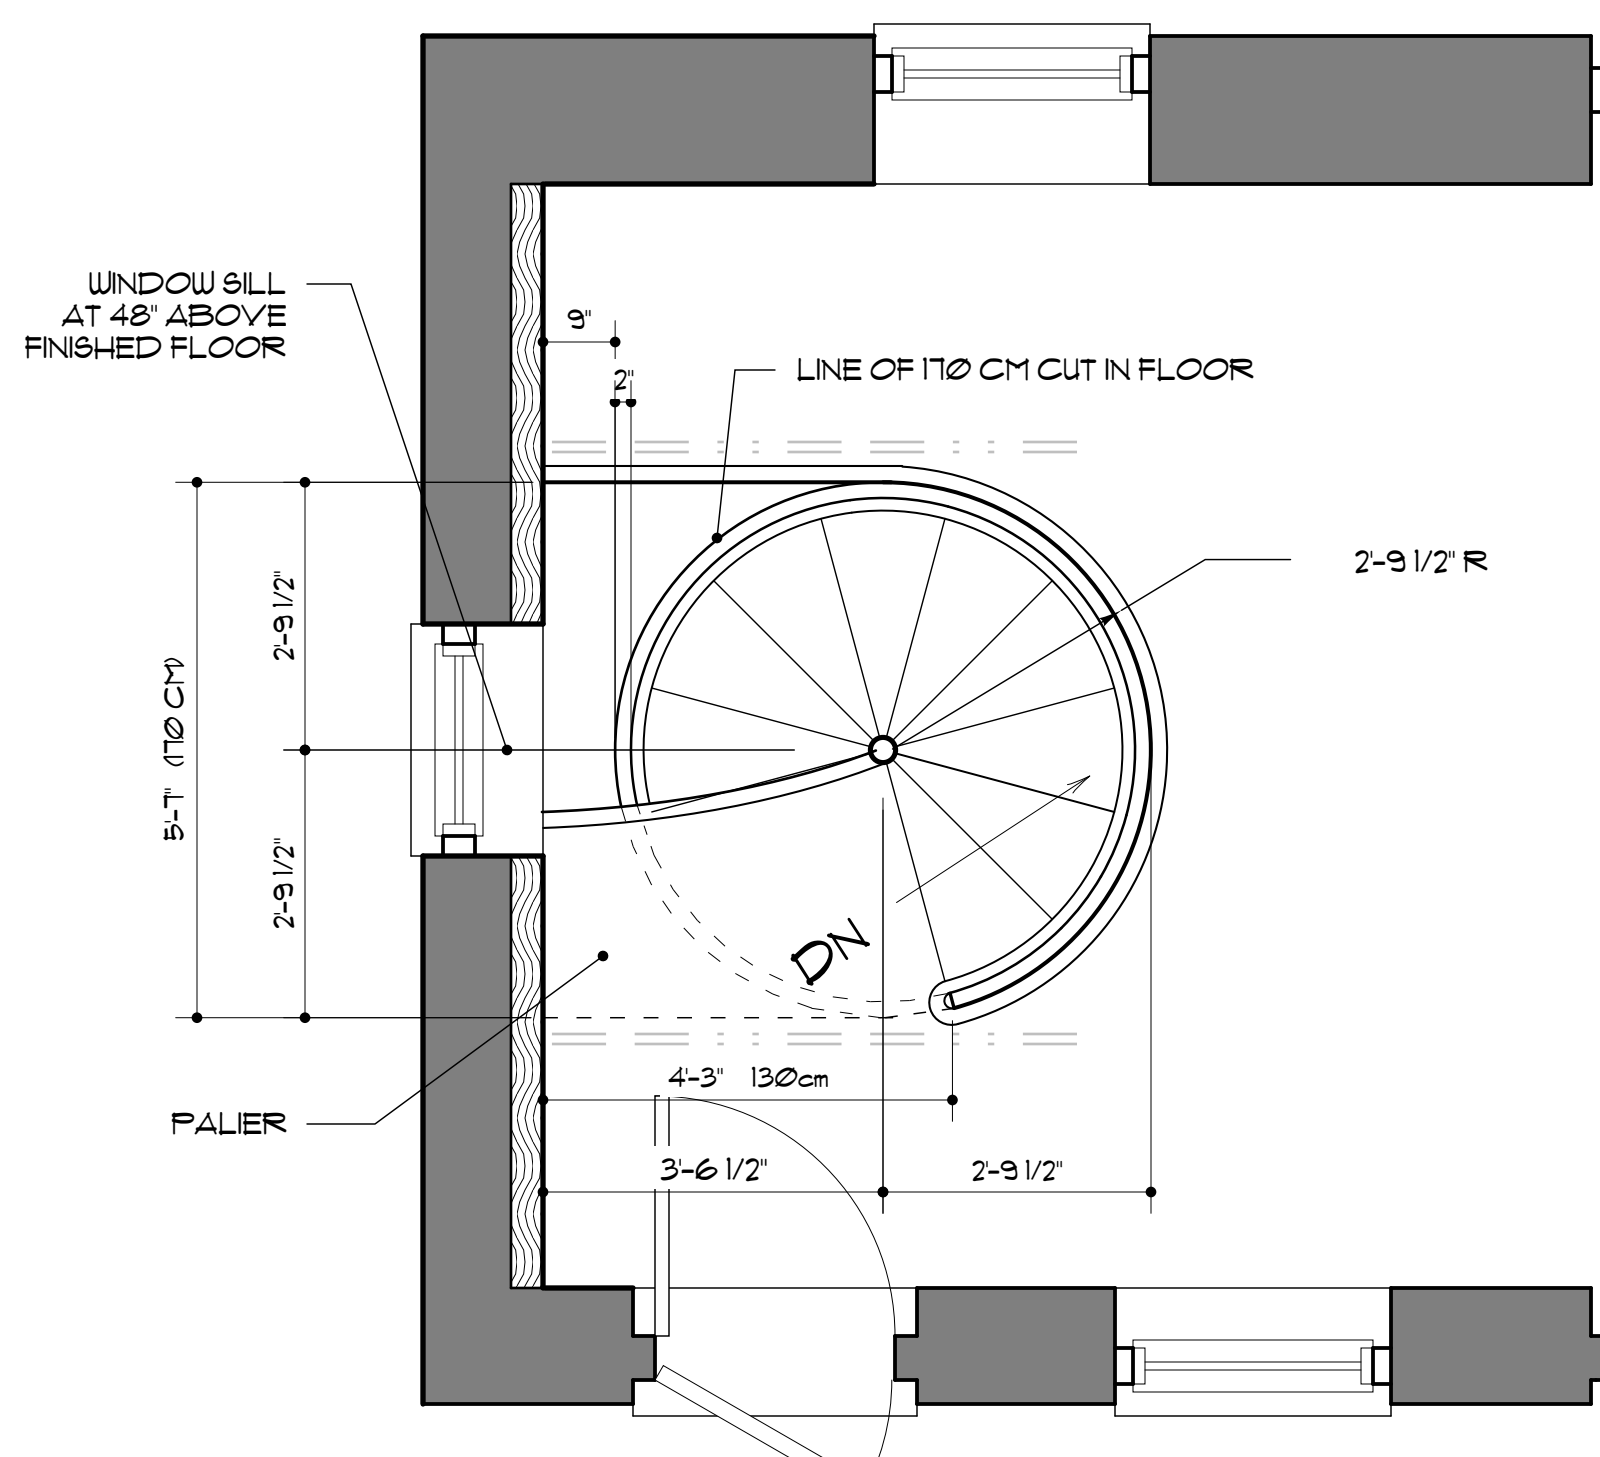

4
A406
SECOND FLOOR PLAN
SCALE: 1/2" = 1'-0"

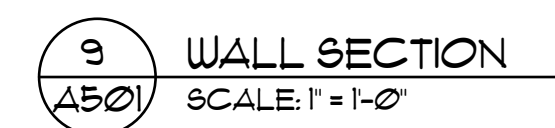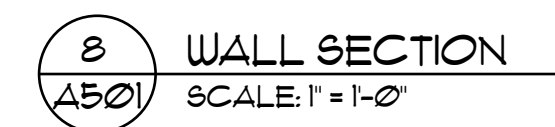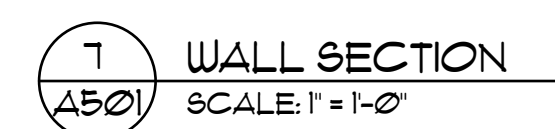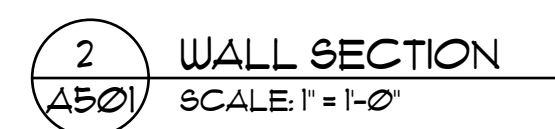


12 Vanderhorst Street
Charleston, SC 29403
(843) 722-4100
www.glennkeysarchitects.com



A REHABILITATION OF
35 LEGARE STREET
THE ELIZABETH WILLIAMS HOUSE
C. 1790
CHARLESTON SC

DETAILS

REV.	DATE
PROJECT NUMBER	
1414	
DRAWING DATE	
10/10/16	
SHEET NUMBER	
A501	

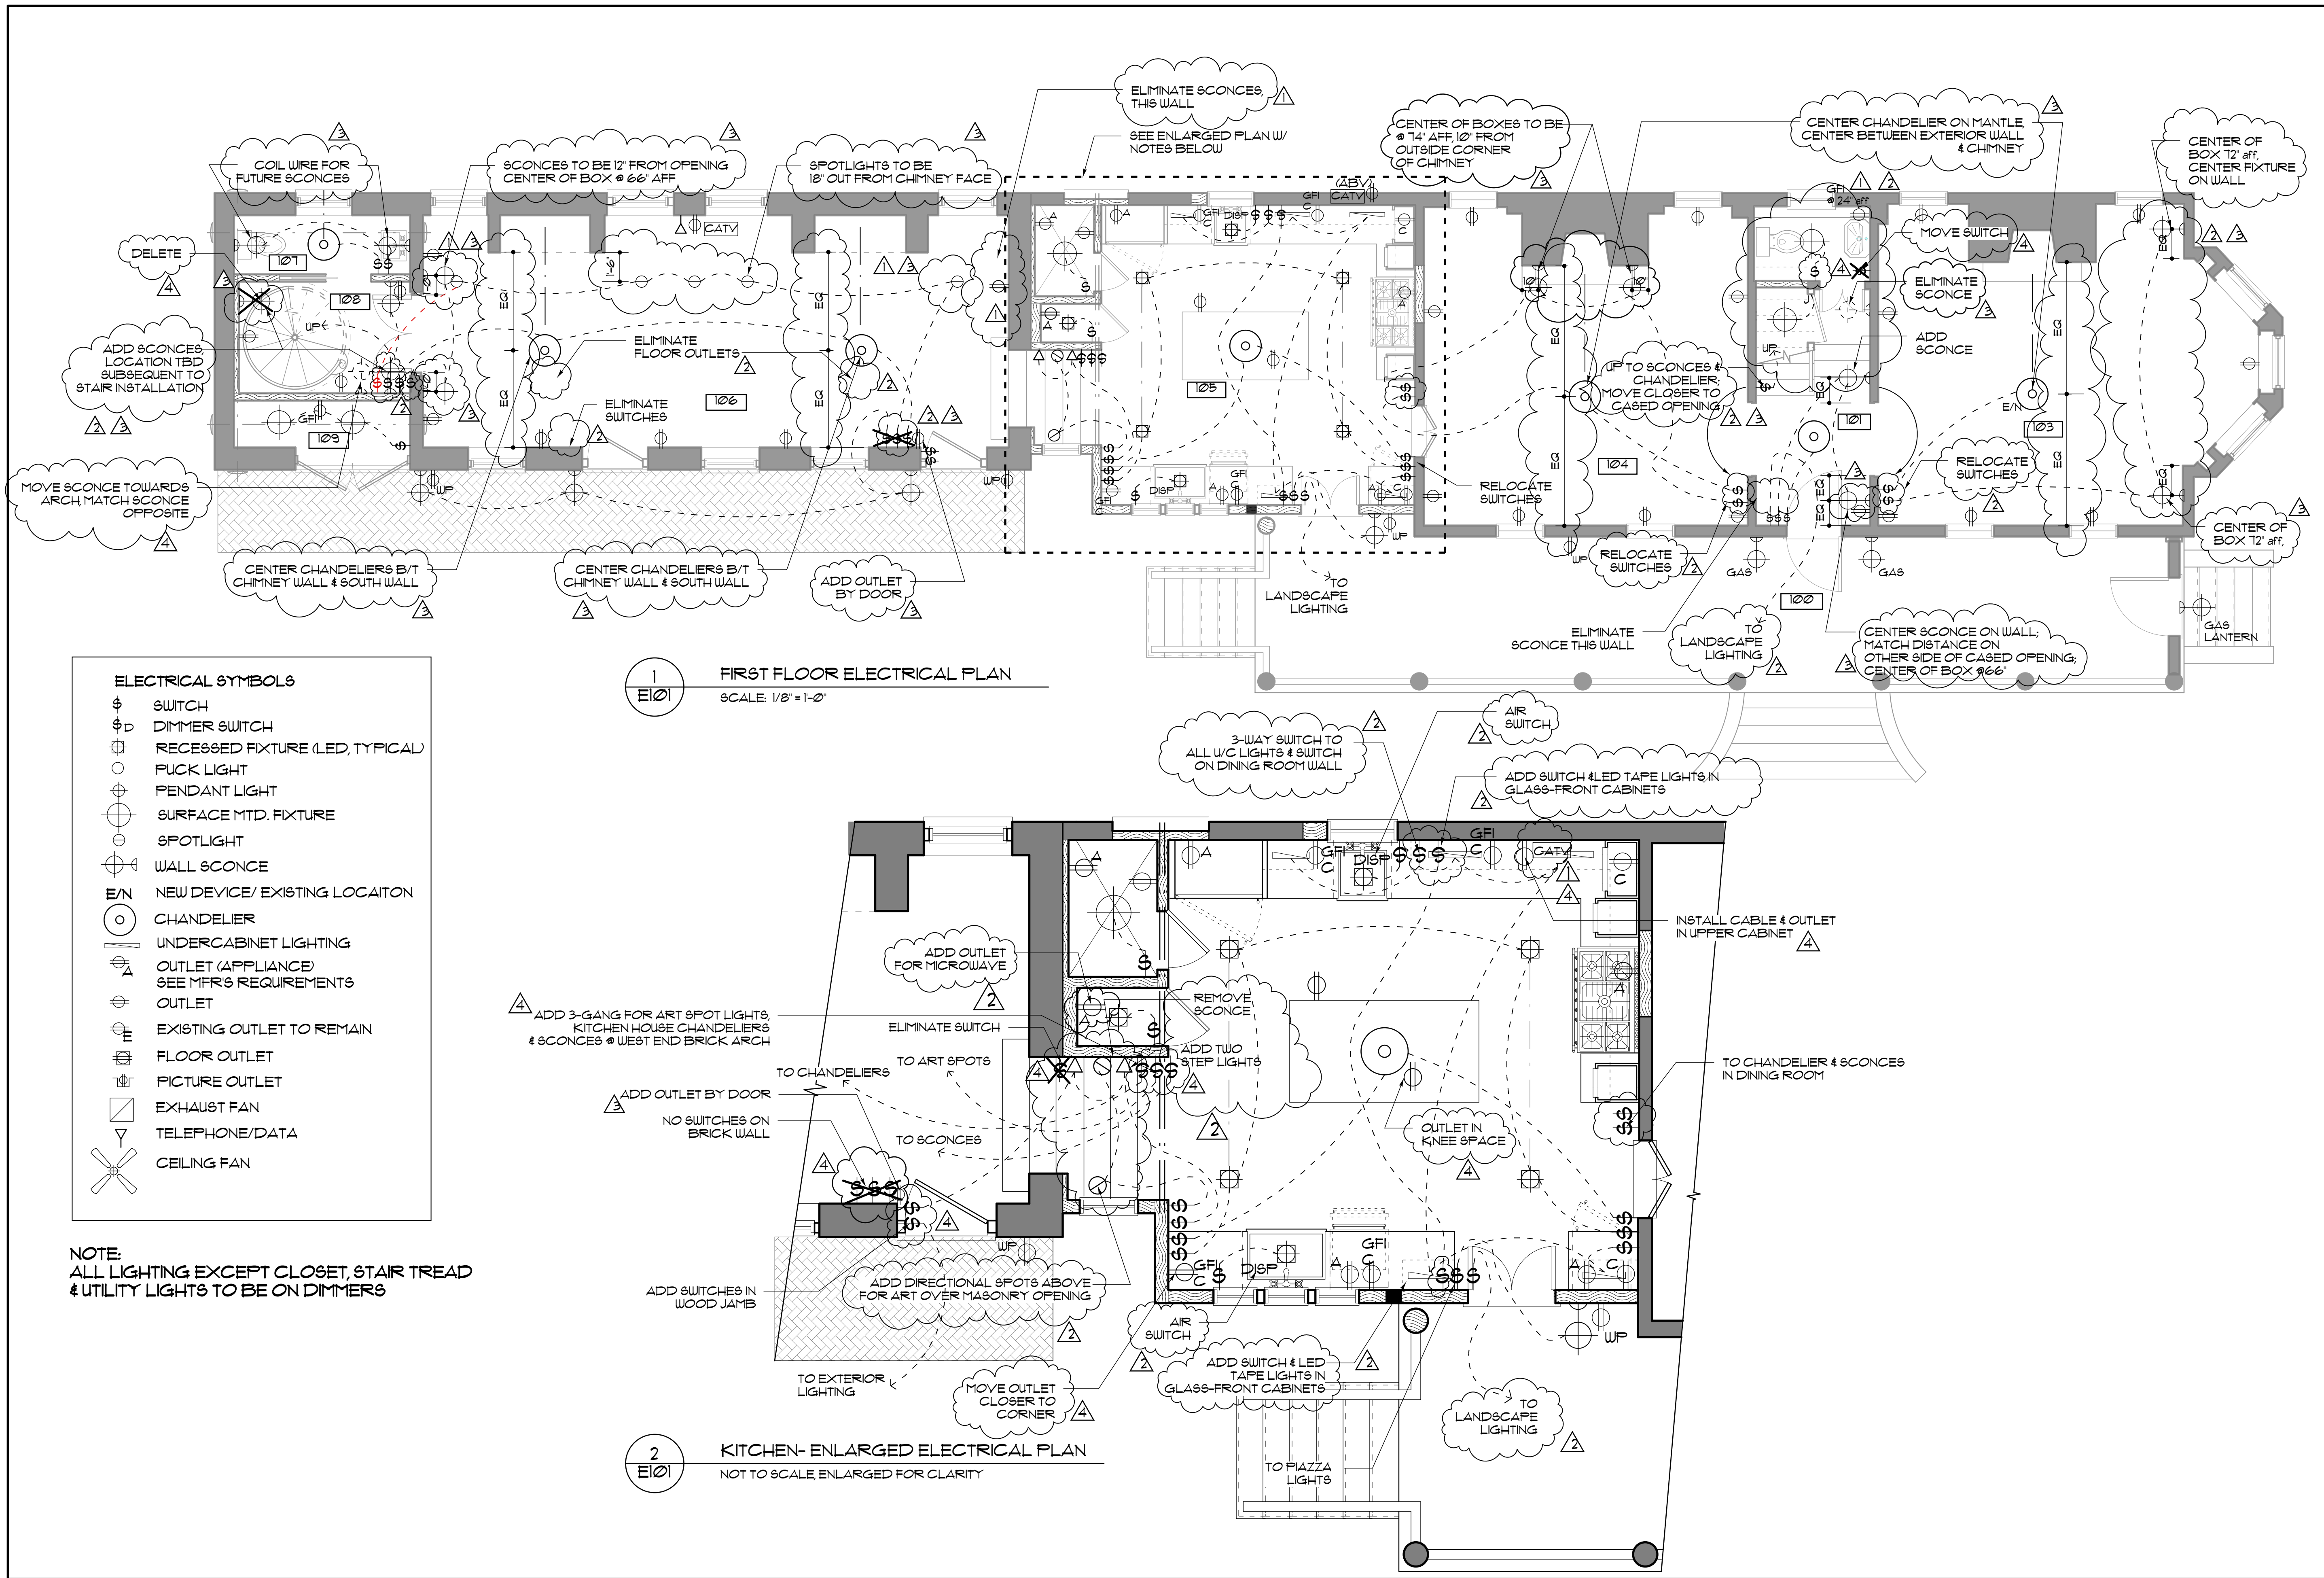

Glenn Keyes Architects


12 Vanderhorst Street
Charleston, SC 29403
(843) 722-4100
www.glennkeyesarchitects.com

A REHABILITATION OF
35 LEGARE STREET
THE ELIZABETH WILLIAMS HOUSE
C. 1790
CHARLESTON, SC

FIRST FLOOR ELECTRICAL PLAN

REV.	DATE
1	2-15-17
2	3-27-17
3	5-10-17
4	6-26-17

PROJECT NUMBER	1414
DRAWING DATE	10/10/16
SHEET NUMBER	E101

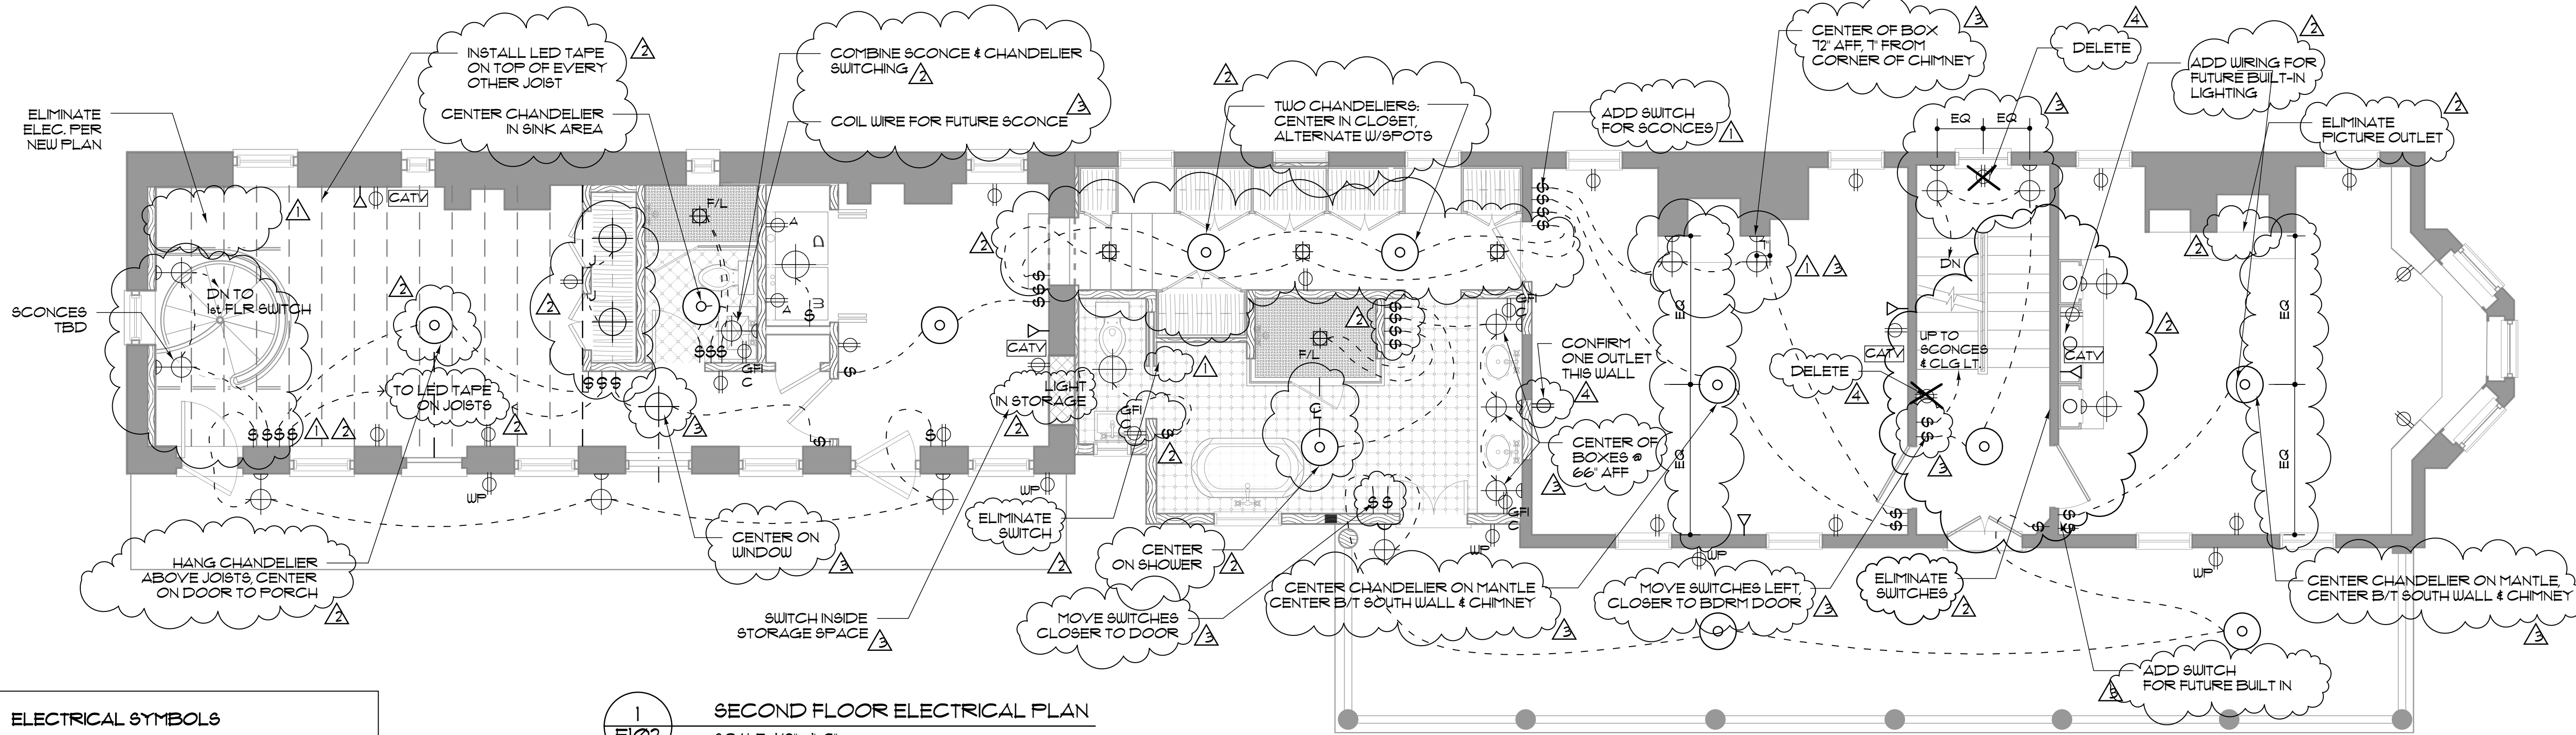

- ELECTRICAL SYMBOLS**
- \$ SWITCH
 - \$D DIMMER SWITCH
 - ⊕ RECESSED FIXTURE (LED, TYPICAL)
 - FLOOR LIGHT
 - ⊕ PENDANT LIGHT
 - ⊕ SURFACE MTD. FIXTURE
 - ⊕ SPOTLIGHT
 - ⊕ WALL SCONCE
 - E/N NEW DEVICE/ EXISTING LOCATION
 - CHANDELIER
 - UNDERCABINET LIGHTING
 - ⊕ OUTLET (APPLIANCE) SEE MFR'S REQUIREMENTS
 - ⊕ OUTLET
 - ⊕ EXISTING OUTLET TO REMAIN
 - ⊕ FLOOR OUTLET
 - ⊕ PICTURE OUTLET
 - EXHAUST FAN
 - ▽ TELEPHONE/DATA
 - ✕ CEILING FAN

NOTE:
ALL LIGHTING EXCEPT CLOSET, STAIR TREAD
& UTILITY LIGHTS TO BE ON DIMMERS


1
E102
SECOND FLOOR ELECTRICAL PLAN
SCALE: 1/8" = 1'-0"

Glenn Keyes Architects
12 Vanderhorst Street
Charleston, SC 29403
(843) 722-4100
www.glennkeyesarchitects.com

A REHABILITATION OF
35 LEGARE STREET
THE ELIZABETH WILLIAMS HOUSE
C. 1790
CHARLESTON, SC

**SECOND FLOOR
ELECTRICAL PLAN**

REV.	DATE
1	2-15-17
2	3-27-17
3	5-10-17
4	6-26-17
PROJECT NUMBER 1414	
DRAWING DATE 10/10/16	
SHEET NUMBER E102	

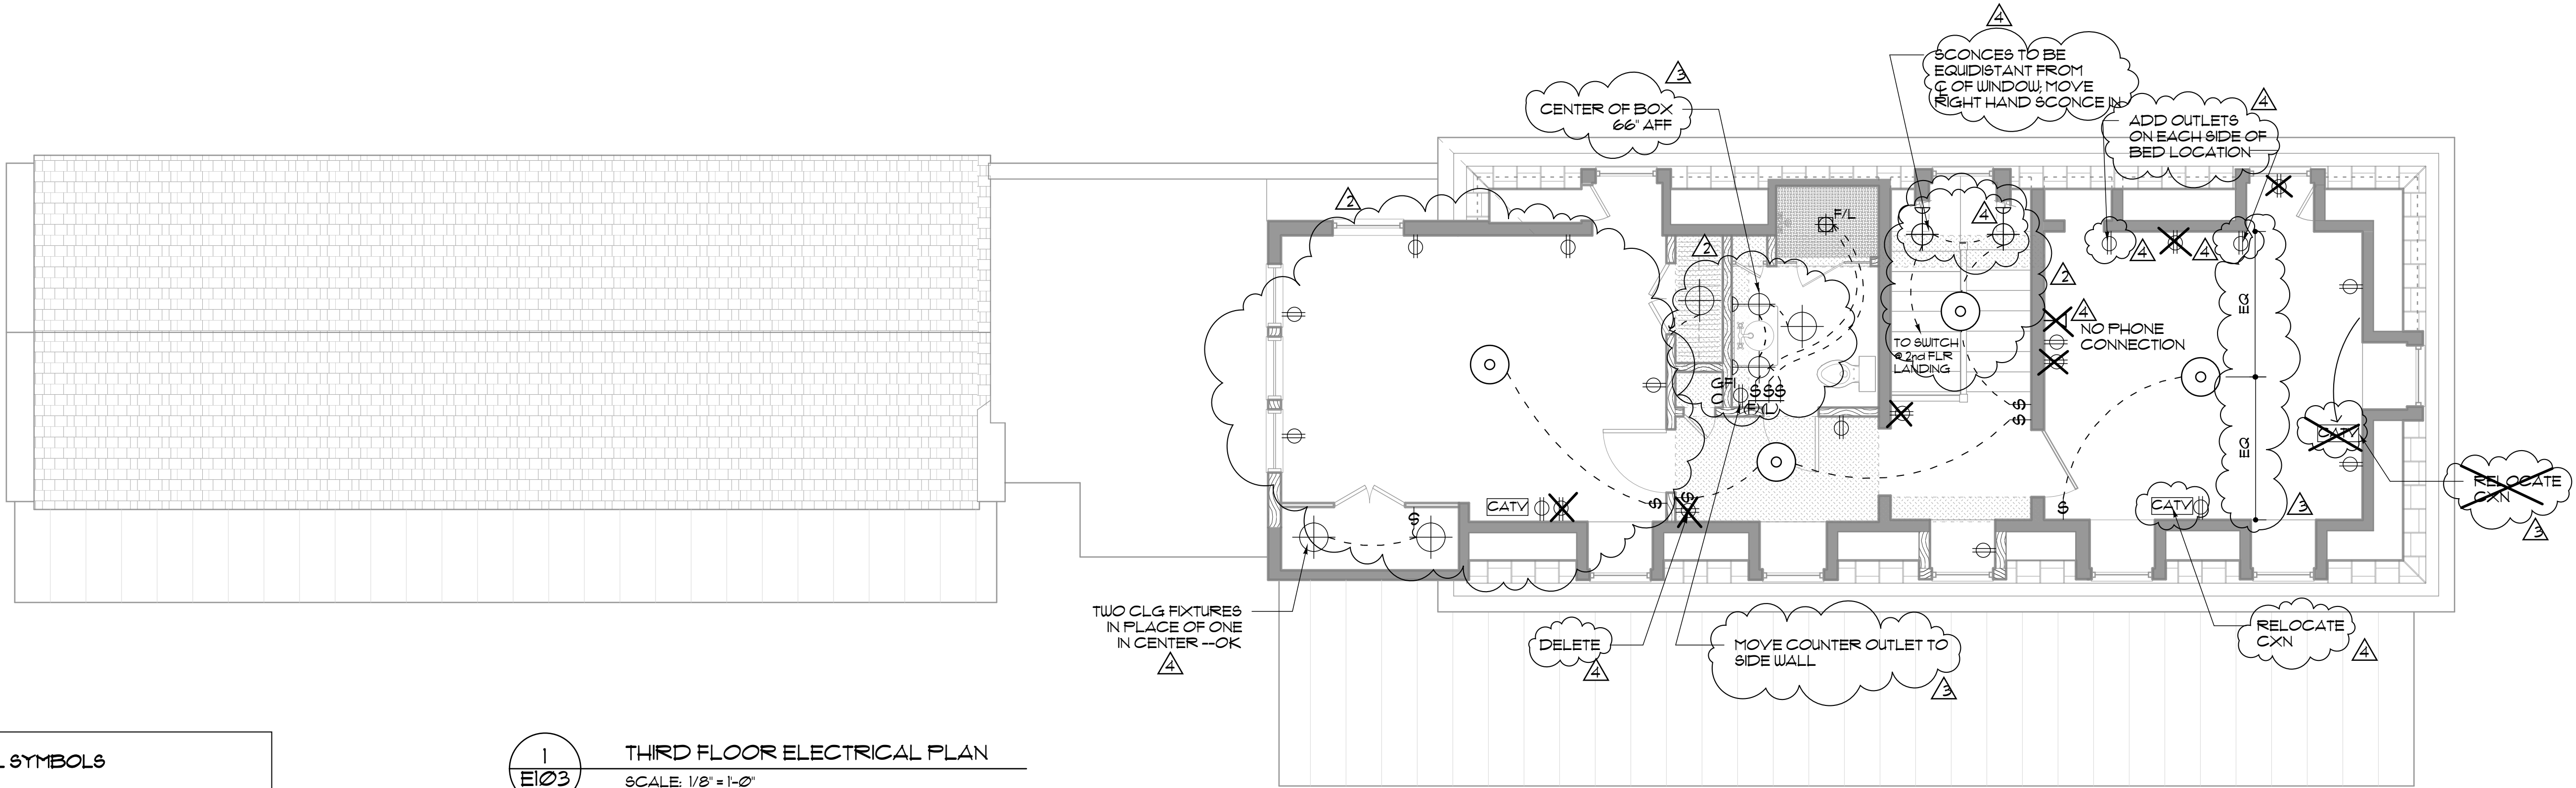

ELECTRICAL SYMBOLS

\$	SWITCH
\$D	DIMMER SWITCH
⊞	RECESSED FIXTURE (LED, TYPICAL)
○	FUCK LIGHT
⊕	PENDANT LIGHT
⊕	SURFACE MTD. FIXTURE
⊕	SPOTLIGHT
⊕	WALL SCONCE
E/N	NEW DEVICE/ EXISTING LOCAITON
○	CHANDELIER
—	UNDERCABINET LIGHTING
⊕A	OUTLET (APPLIANCE) SEE MFR'S REQUIREMENTS
⊕	OUTLET
⊕E	EXISTING OUTLET TO REMAIN
⊕	FLOOR OUTLET
⊕	PICTURE OUTLET
□	EXHAUST FAN
Y	TELEPHONE/DATA
✕	CEILING FAN

NOTE:
ALL LIGHTING EXCEPT CLOSET, STAIR TREAD
& UTILITY LIGHTS TO BE ON DIMMERS

1
E103

THIRD FLOOR ELECTRICAL PLAN

SCALE: 1/8" = 1'-0"

Glenn Keyes
Architects

12 Vanderhorst Street
Charleston, SC 29403
(843) 722-4100
www.glennkeyesarchitects.com

A REHABILITATION OF
35 LEGARE STREET
THE ELIZABETH WILLIAMS HOUSE
C. 1790
CHARLESTON SC

THIRD FLOOR
ELECTRICAL PLAN

REV.	DATE
1	2-15-17
2	3-27-17
3	5-10-17
4	6-26-17

PROJECT NUMBER 1414

DRAWING DATE 10/10/16

SHEET NUMBER
E103