





12 Vanderhorst Street
Charleston, SC 29403
(843) 722-4100
www.glenkeyesarchitects.com

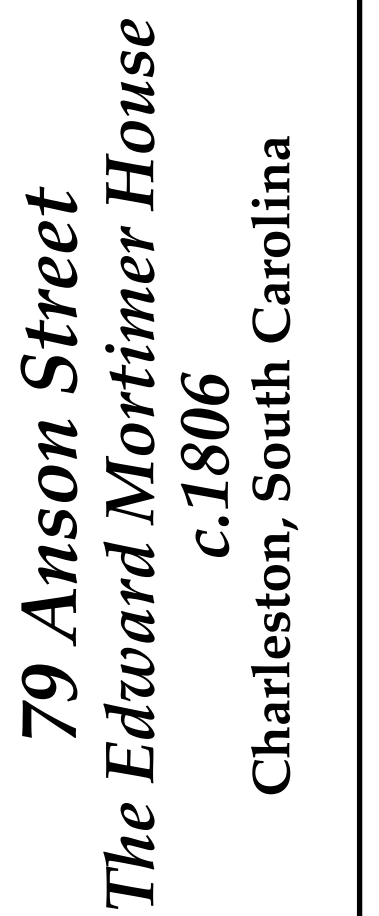

PROPOSED FLOOR PLANS


REV.	DATE
PROJECT NUMBER	
1705	
DRAWING DATE	
9/25/17	
SHEET NUMBER	

A|Ø|

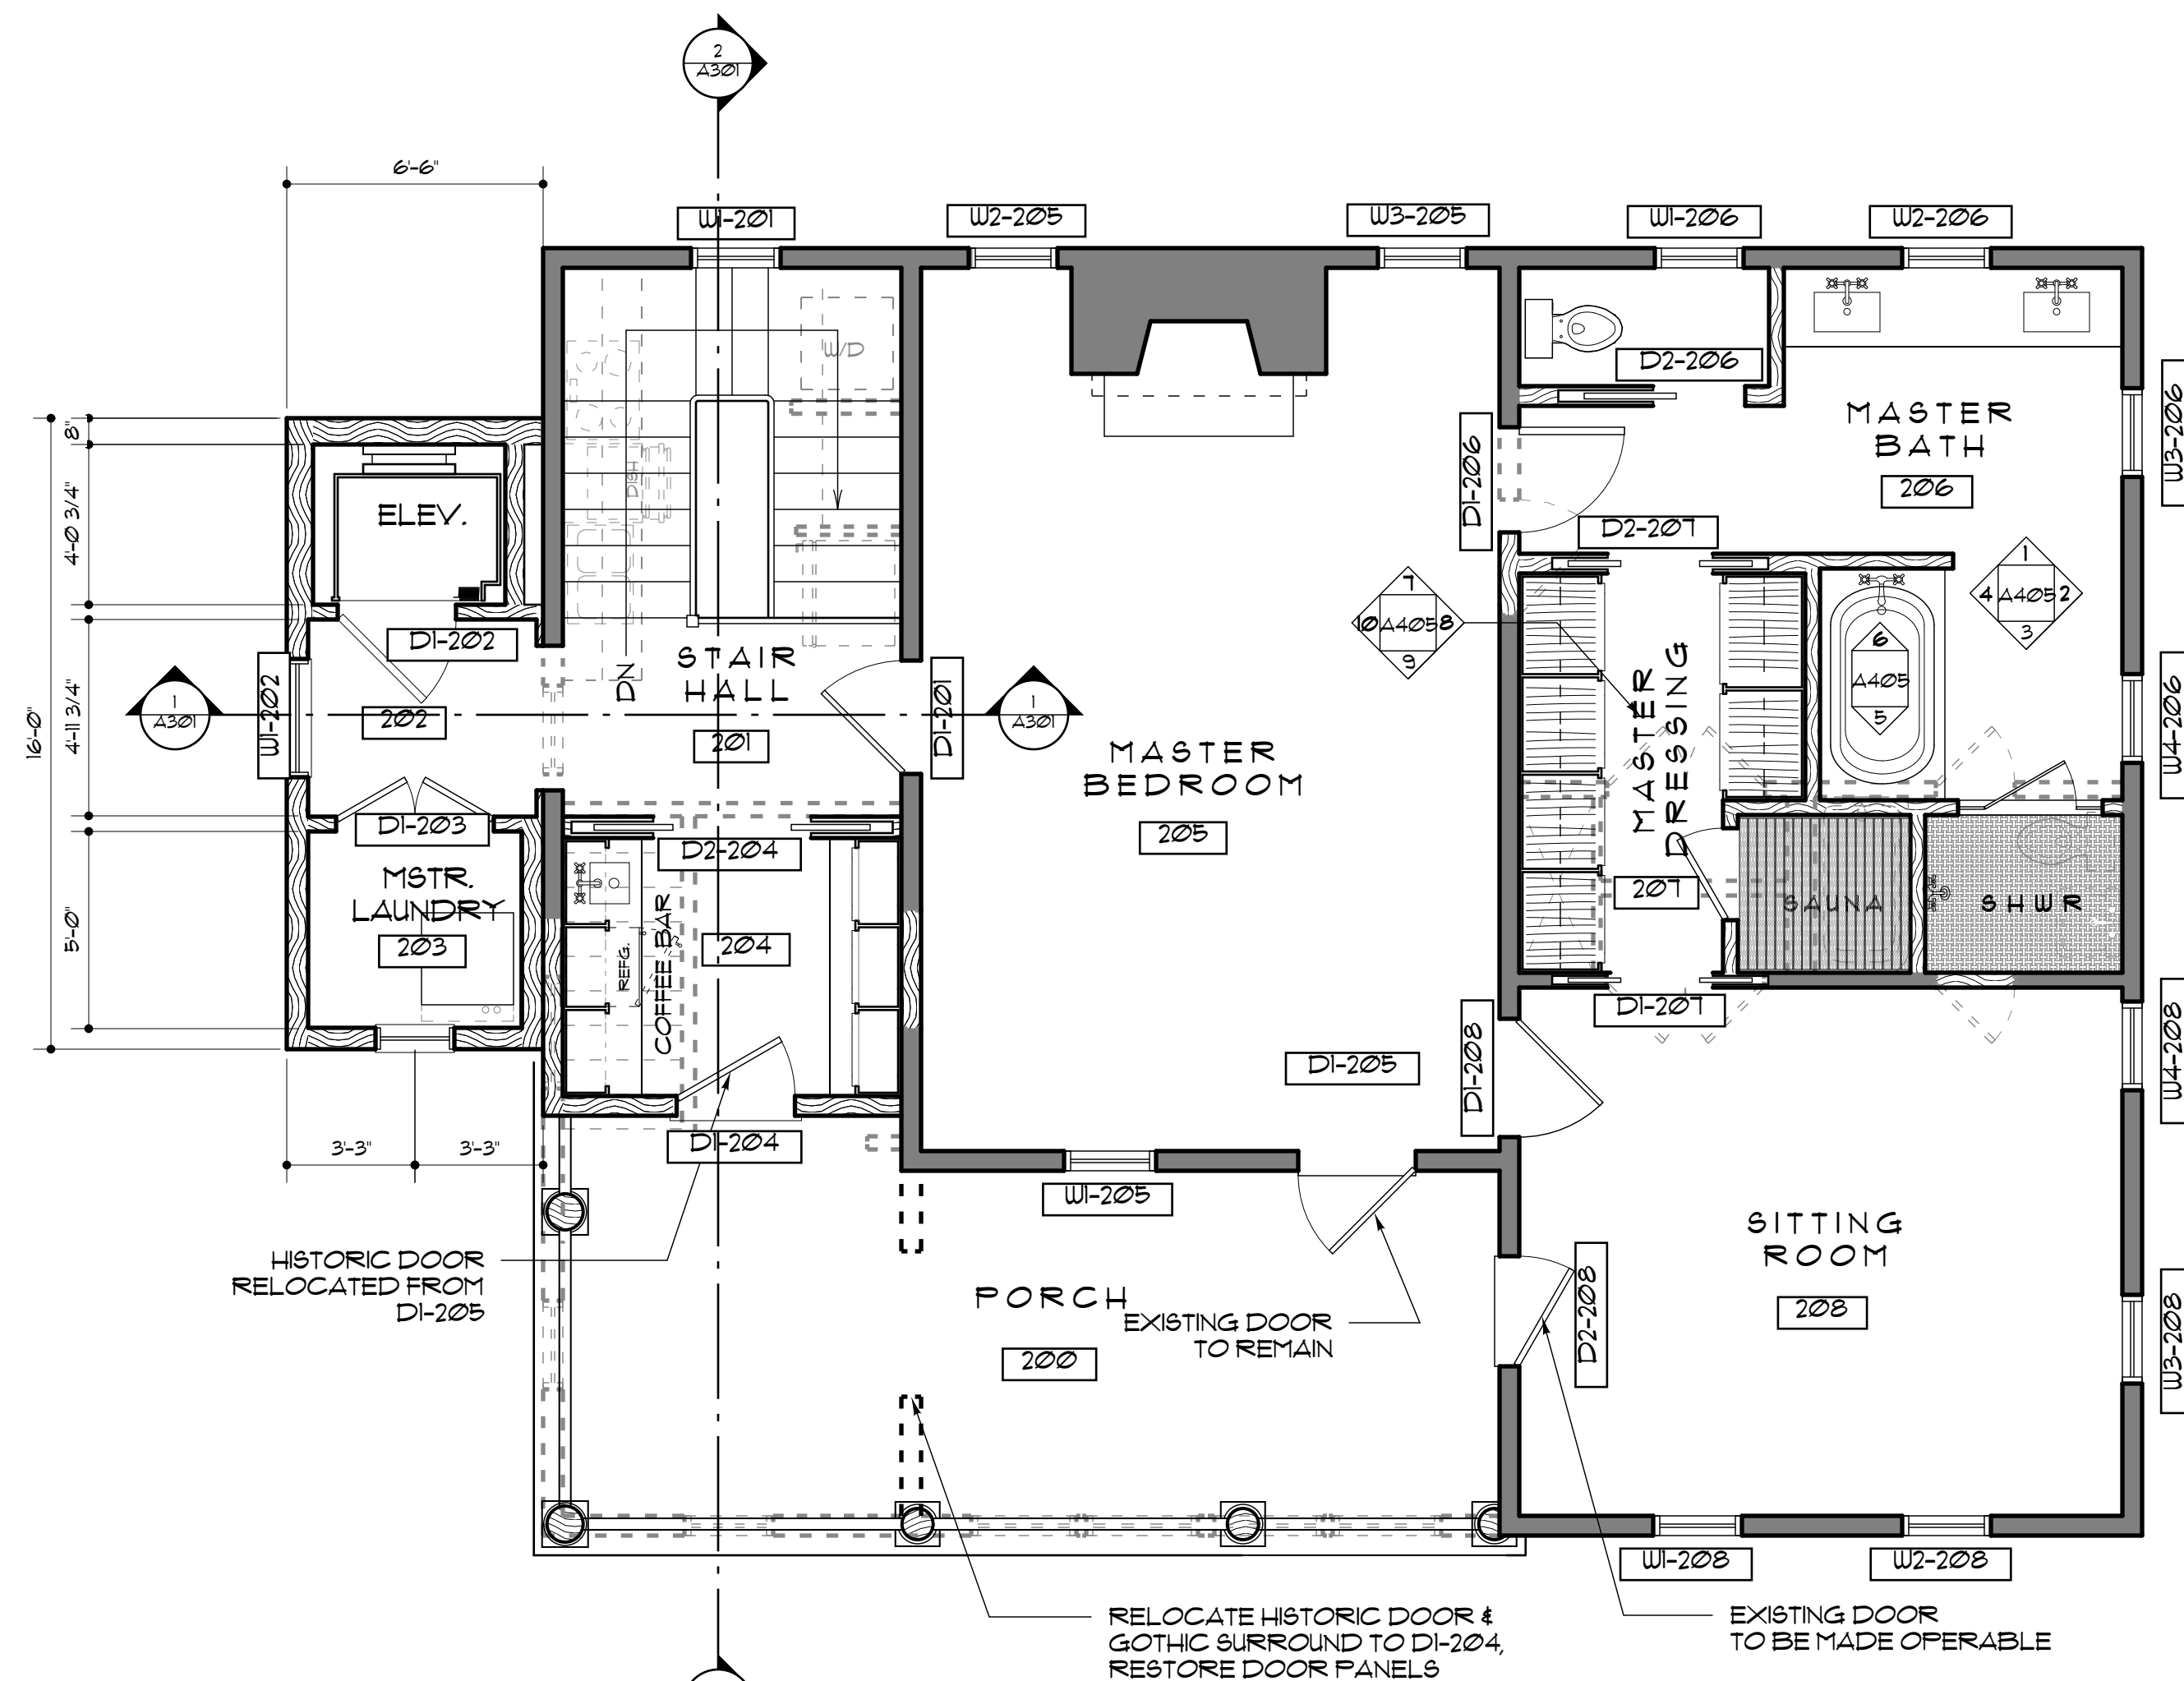


DOOR NOTES:

1. RELOCATE HISTORIC DOOR & SURROUND FROM WEST END OF EXISTING PORCH ENCLOSURE TO D1-204, EXISTING DOOR TO BE RESTORED BY REMOVING GLASS PANELS
2. EXISTING SIX PANEL DOOR @ D2-208 TO BE MADE OPERABLE

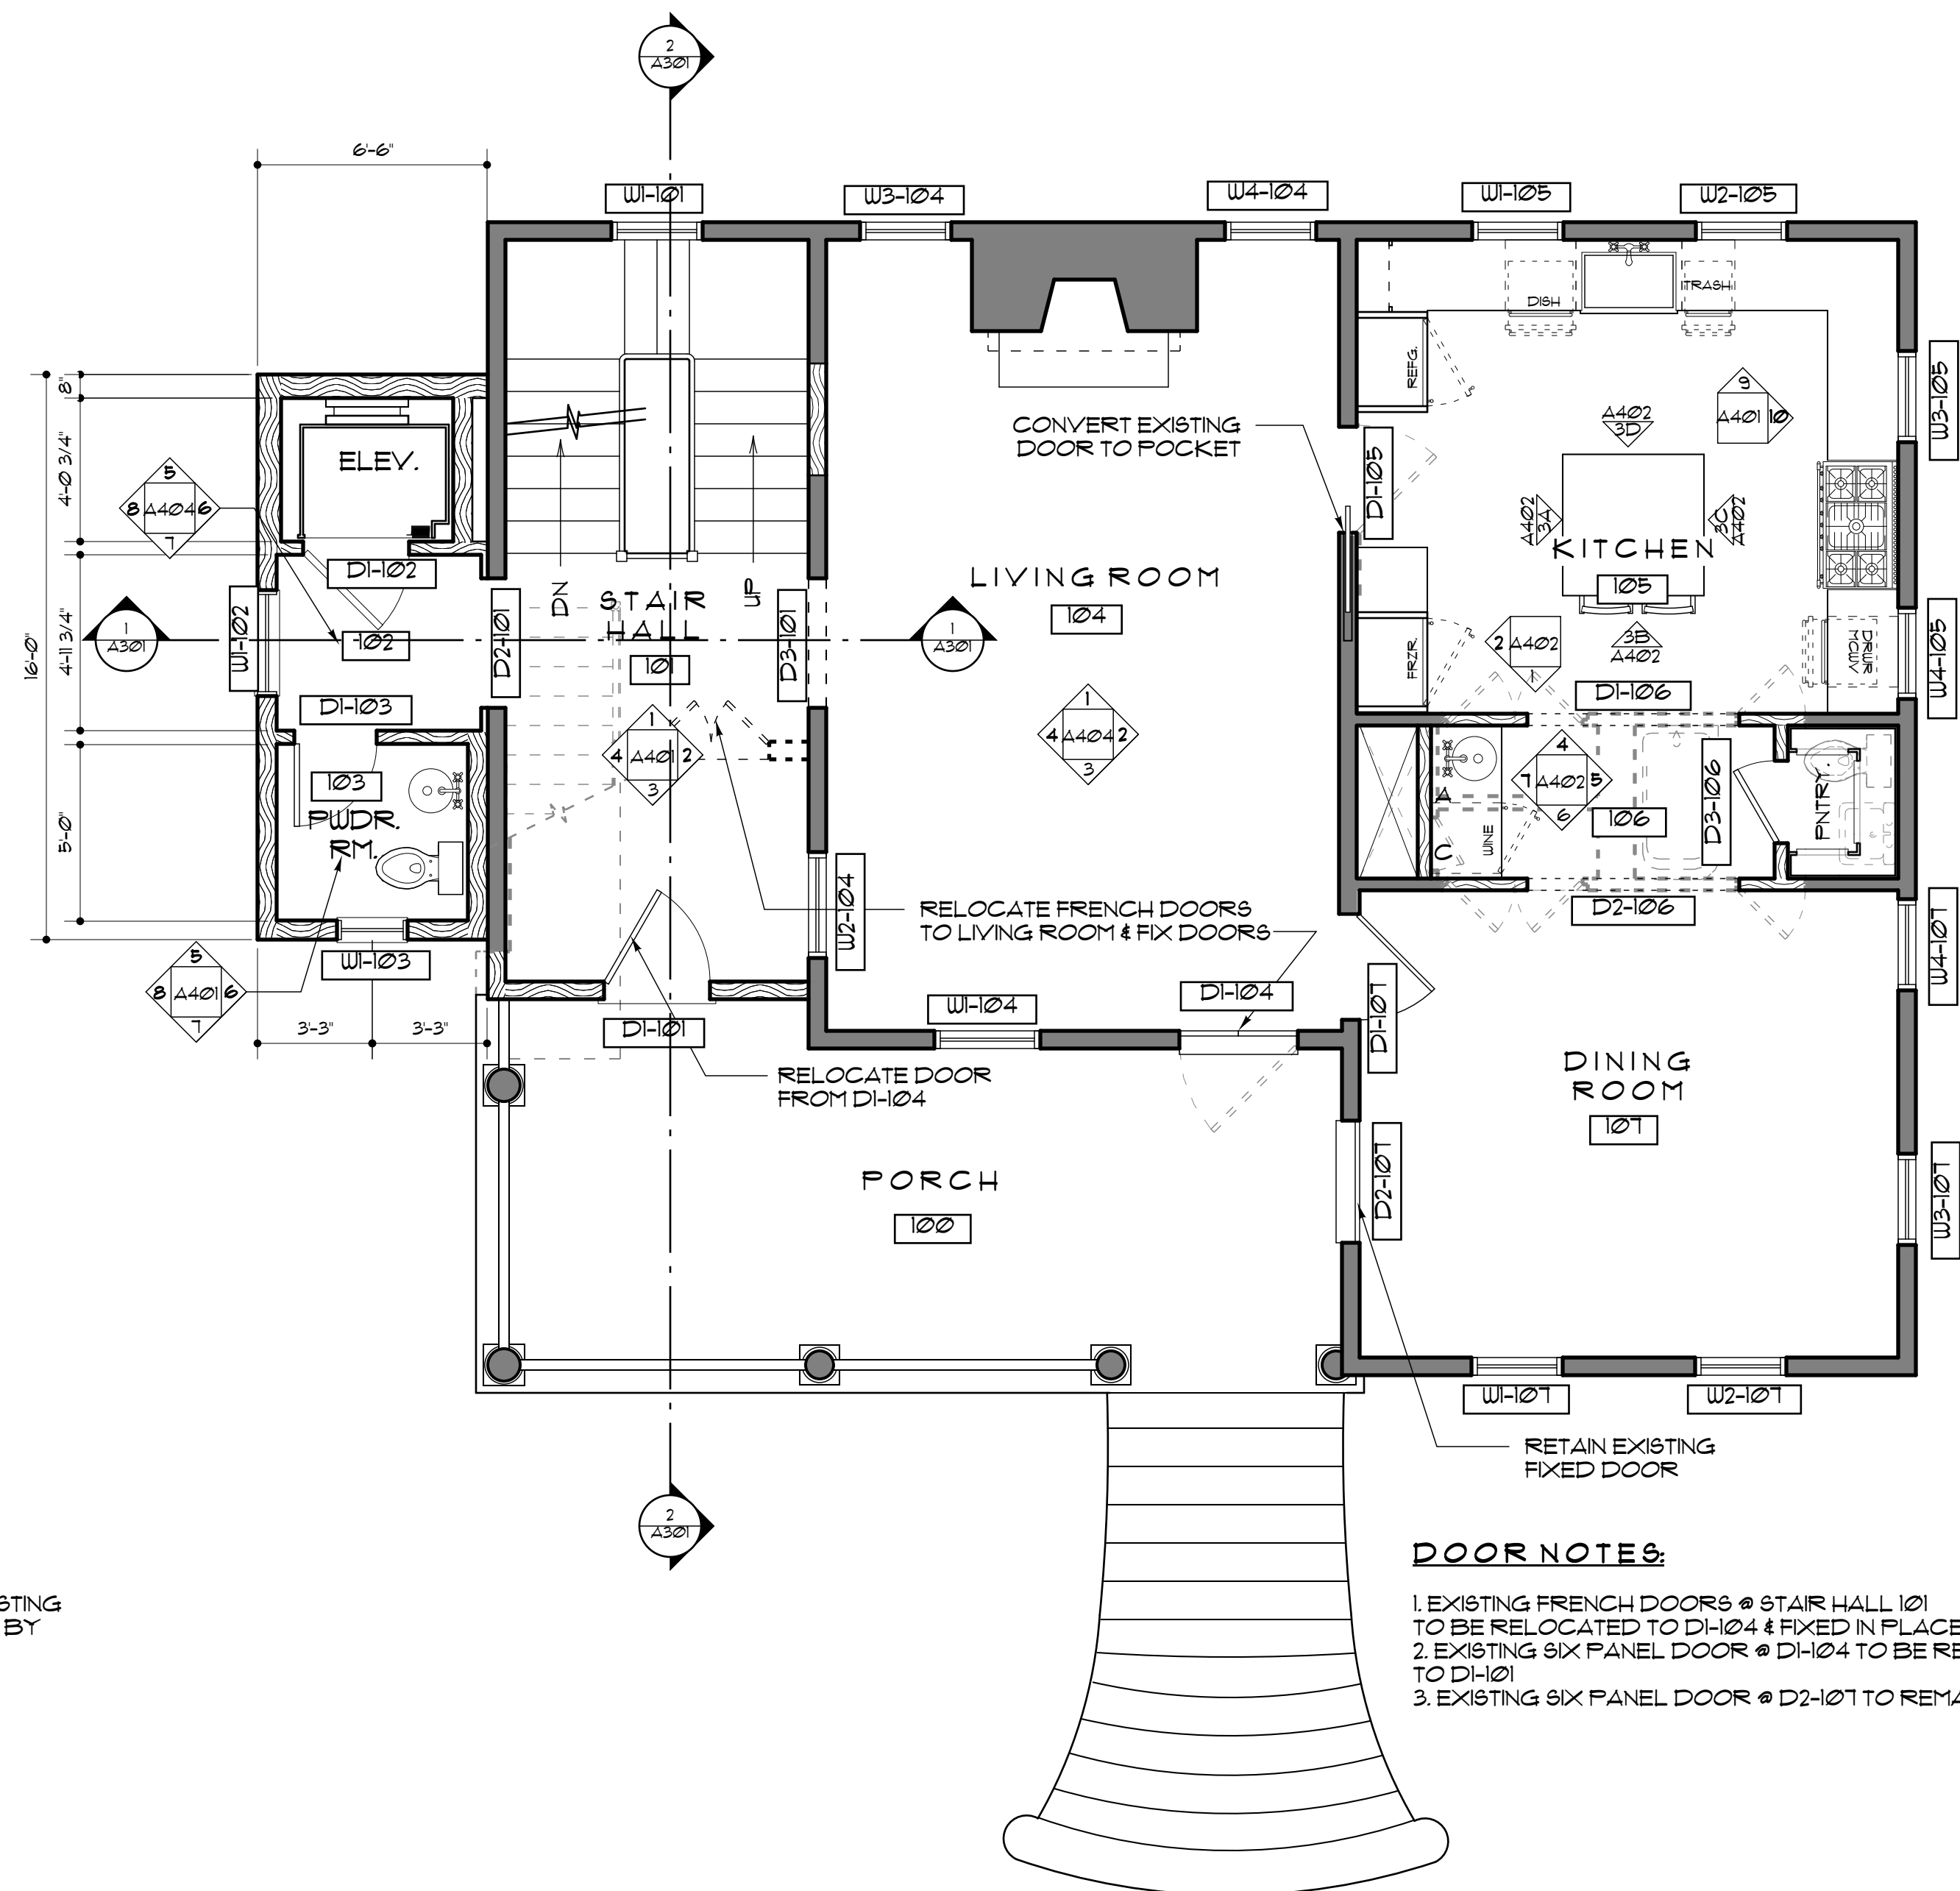

DOOR NOTES:


1. EXISTING FRENCH DOORS @ STAIR HALL 101
TO BE RELOCATED TO DI-104 & FIXED IN PLACE
2. EXISTING SIX PANEL DOOR @ DI-104 TO BE RELOCATED
TO DI-101
3. EXISTING SIX PANEL DOOR @ D2-107 TO REMAIN

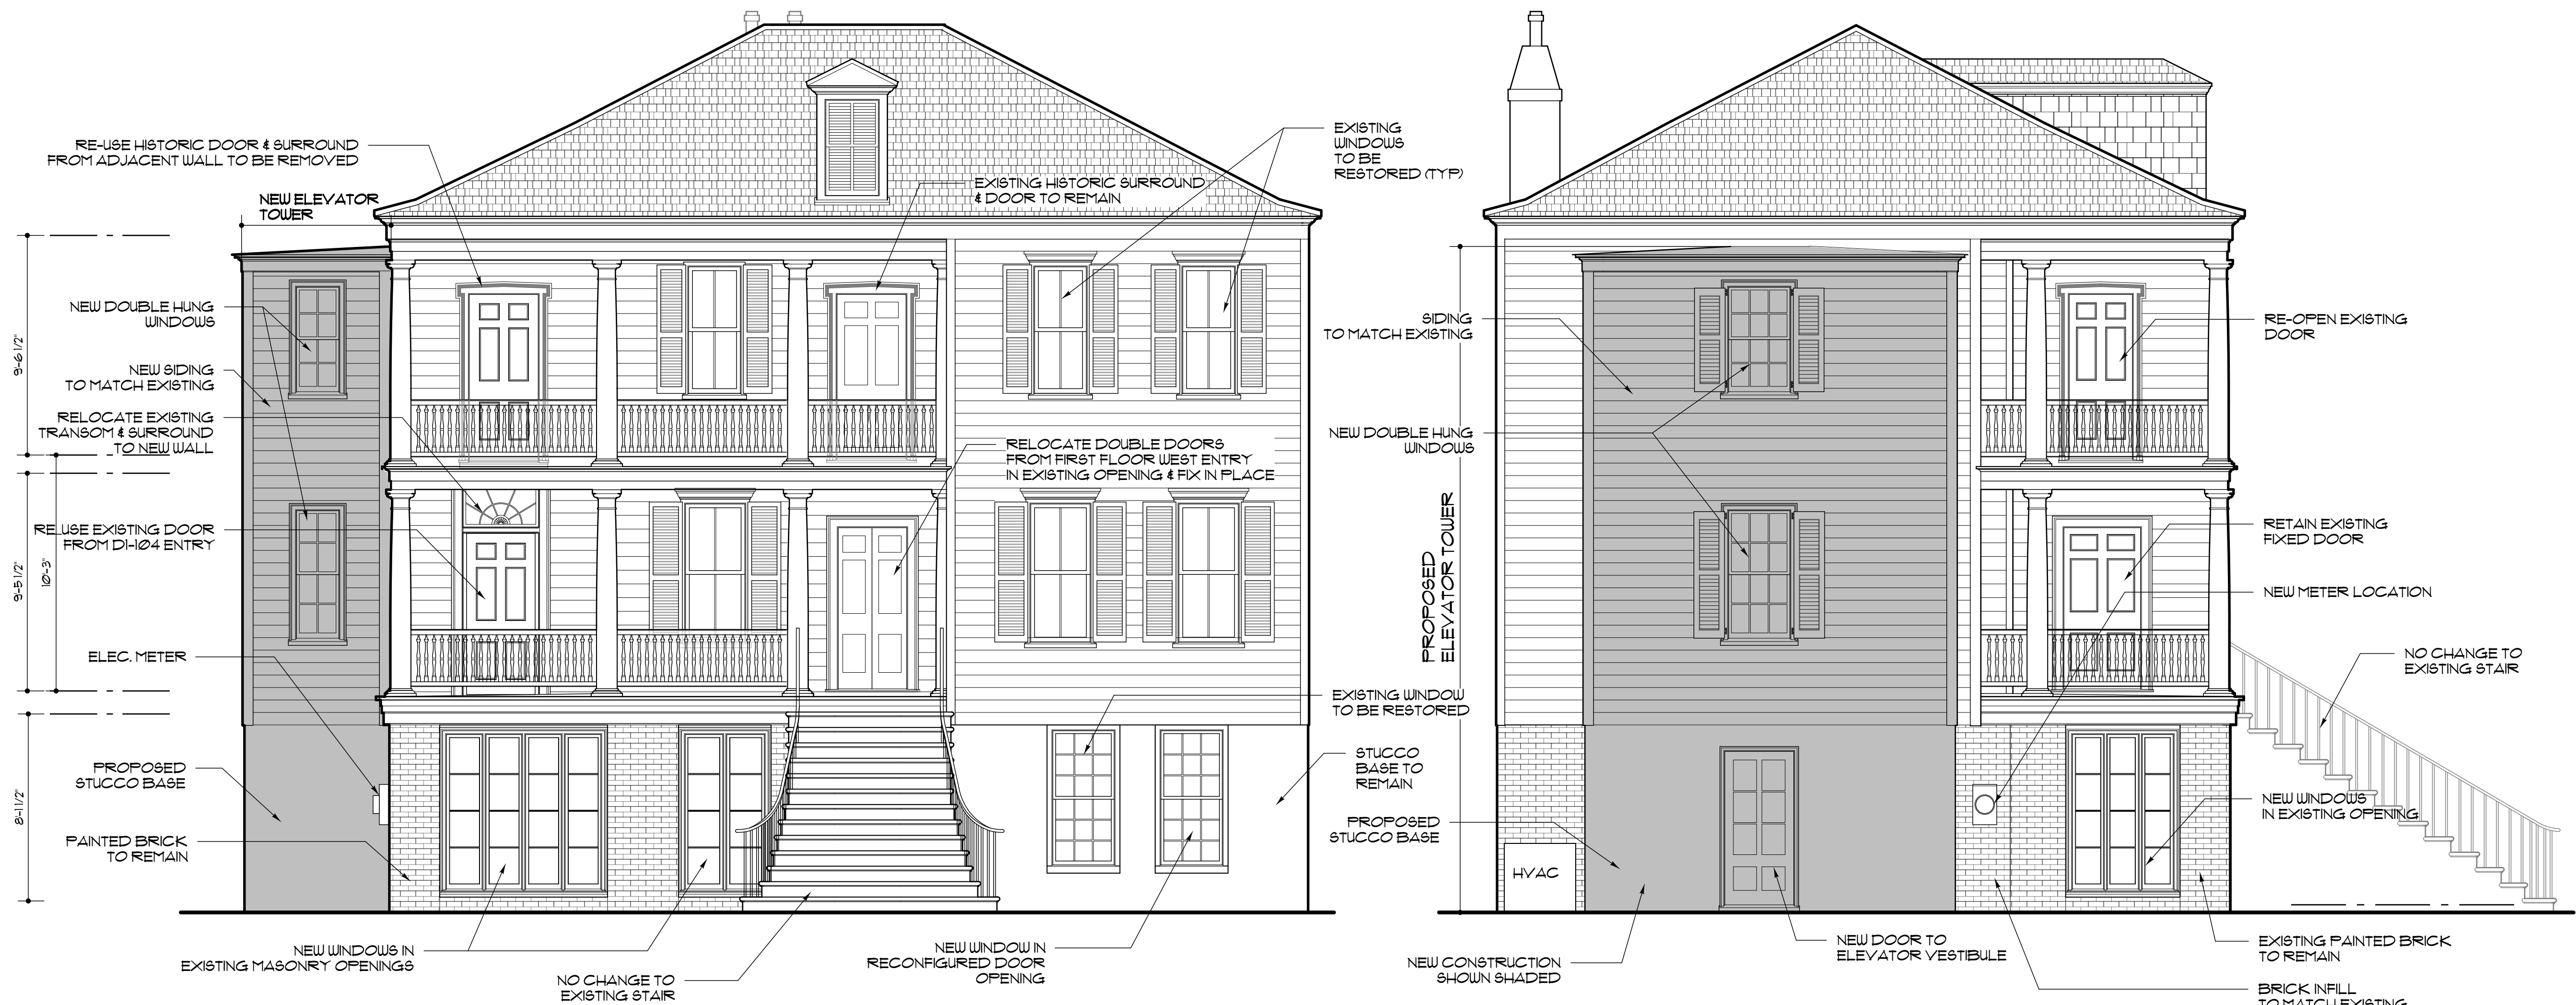

1 SOUTH ELEVATION
A201
SCALE: 1/4" = 1'-0"

2 WEST ELEVATION
A201
SCALE: 1/4" = 1'-0"

Glenn Keyes
Architects

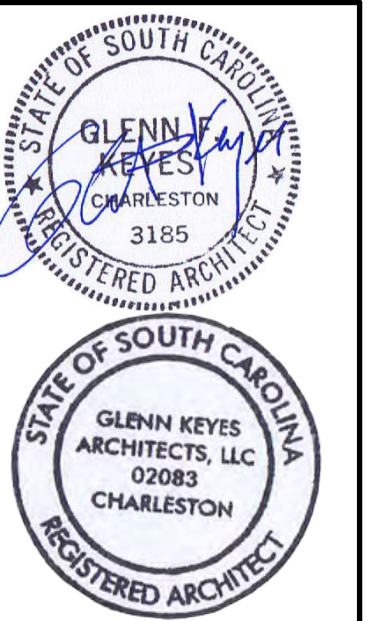

79 Anson Street
The Edward Mortimer House
c.1806
Charleston, South Carolina

PROPOSED WEST & SOUTH
ELEVATIONS

REV.	DATE
PROJECT NUMBER	1705
DRAWING DATE	9/25/17
SHEET NUMBER	A201




1
A202 EAST ELEVATION
SCALE: 1/4" = 1'-0"



2
A202 NORTH ELEVATION
SCALE: 1/4" = 1'-0"


Glenn Keyes
Architects
12 Vanderhorst Street
Charleston, SC 29403
(843) 722-1100
www.glennkeyesarchitects.com

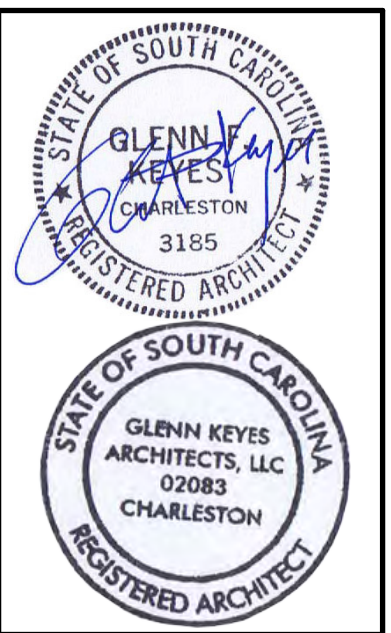


79 Anson Street
The Edward Mortimer House
c.1806
Charleston, South Carolina

PROPOSED EAST & NORTH
ELEVATIONS

REV.	DATE
PROJECT NUMBER	1705
DRAWING DATE	9/25/17
SHEET NUMBER	A202

 

1
Δ3Ø1

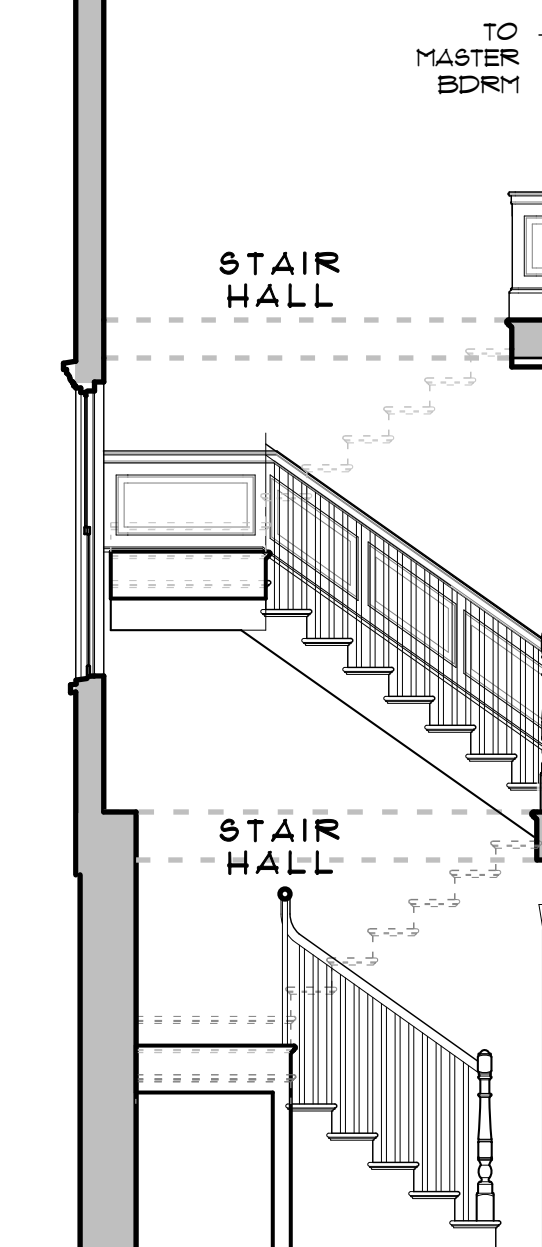










2
Δ301

12 Vanderhorst Street
Charleston, SC 29403
(843) 722-4100
www.glenkeyesarchitects.com




PROPOSED SECTIONS

REV.	DATE
PROJECT NUMBER	
1705	
DRAWING DATE	
9/25/17	
SHEET NUMBER	
A301	

 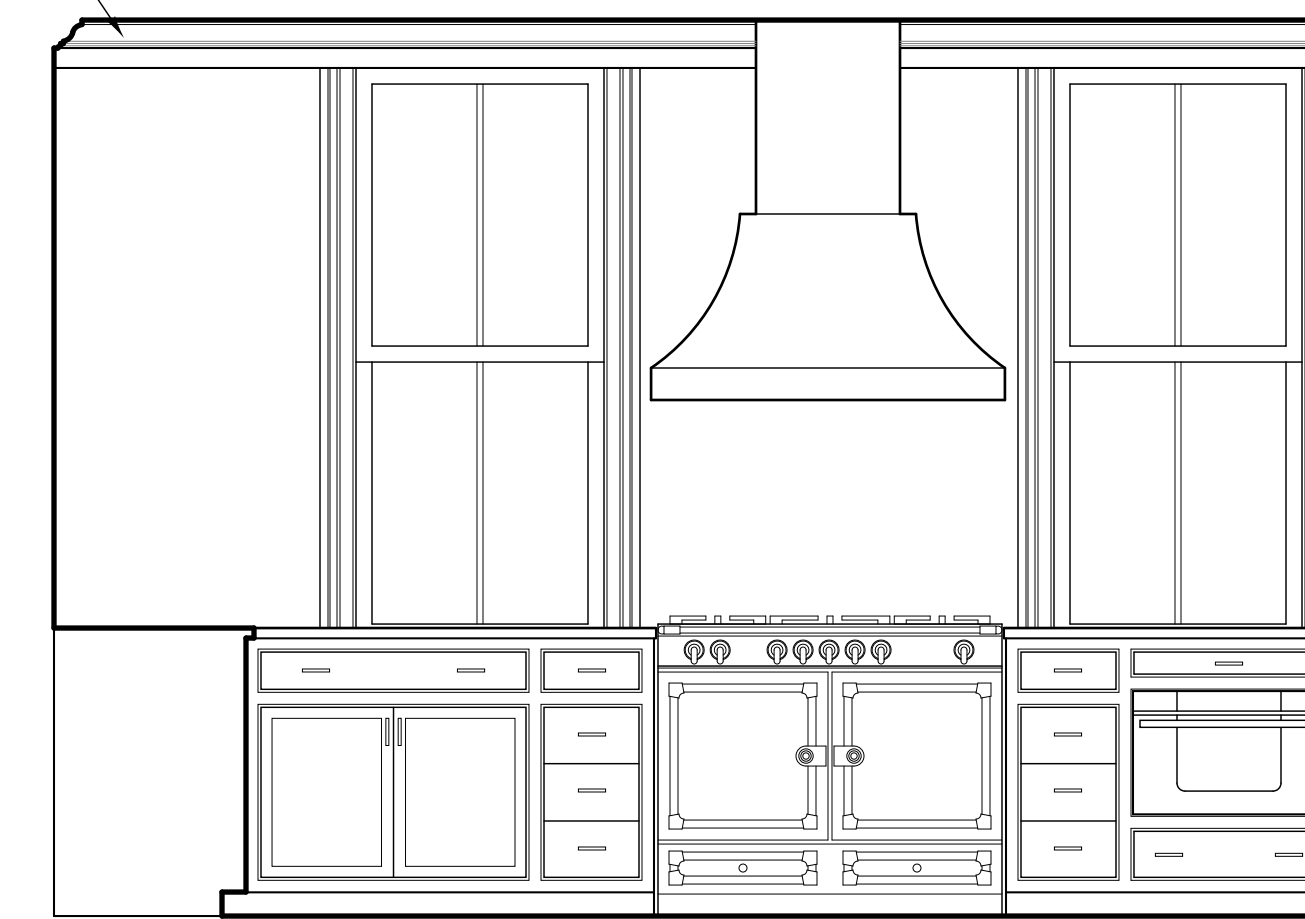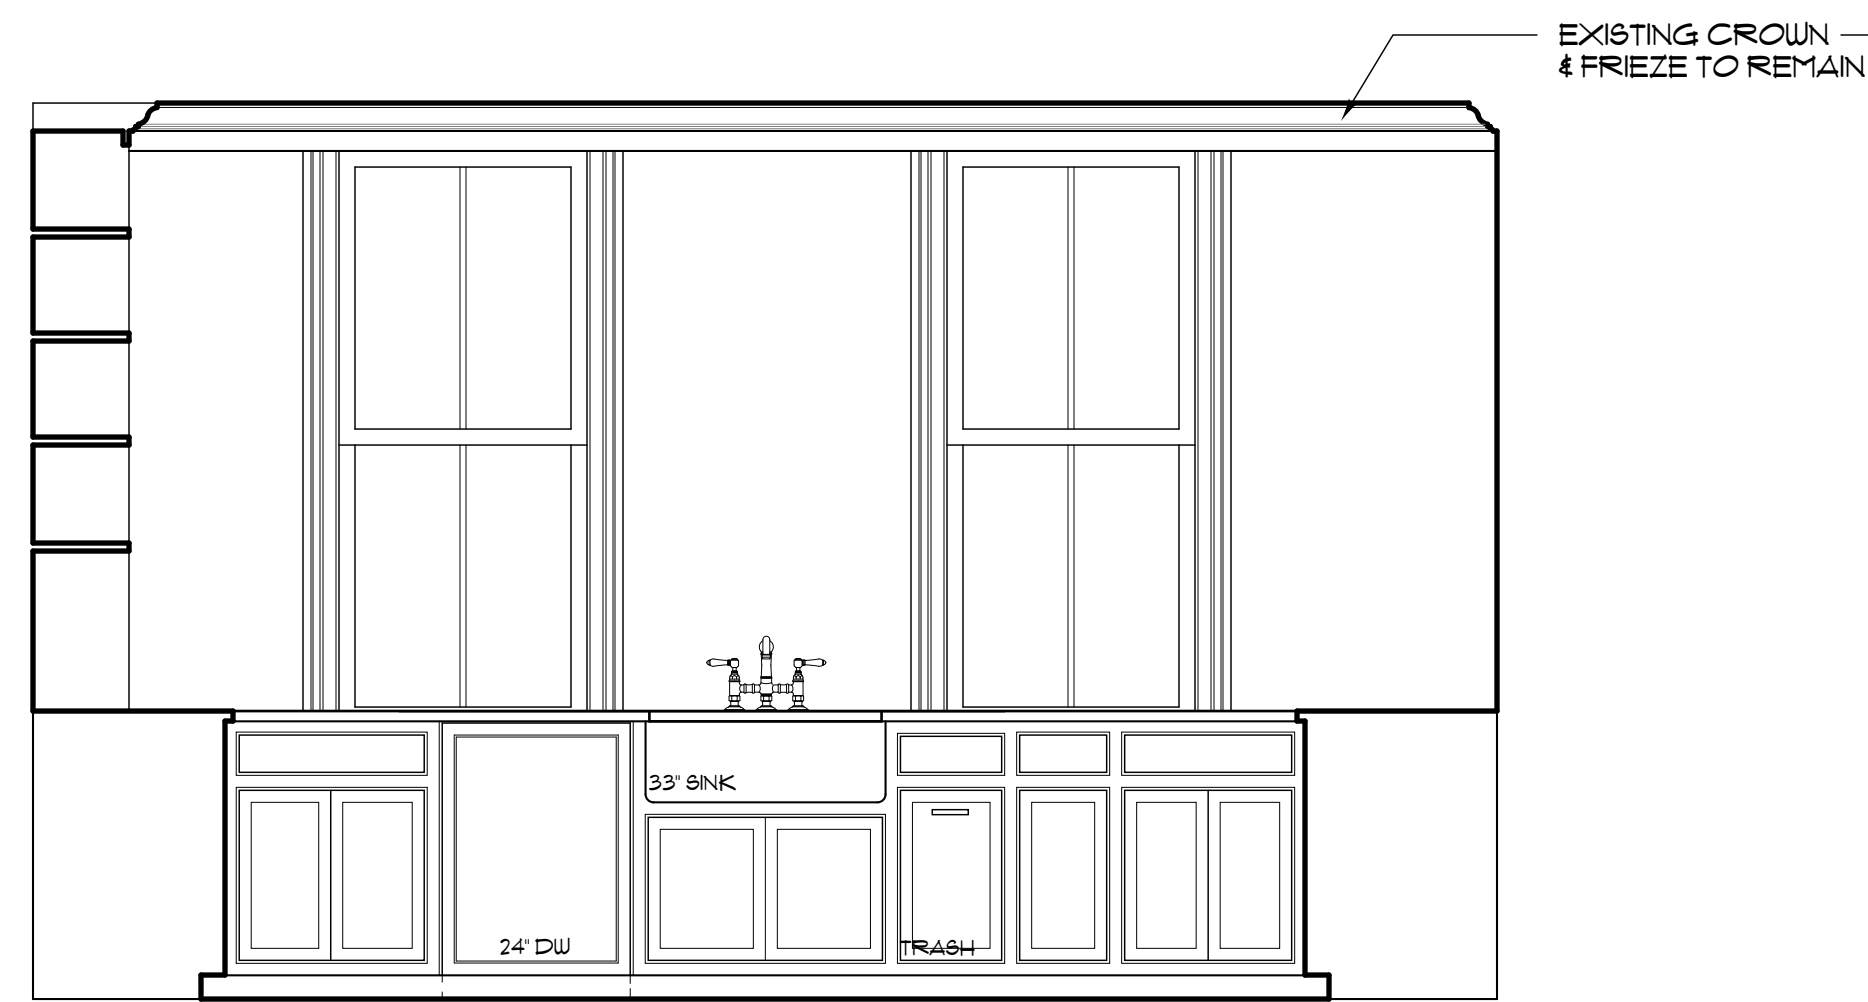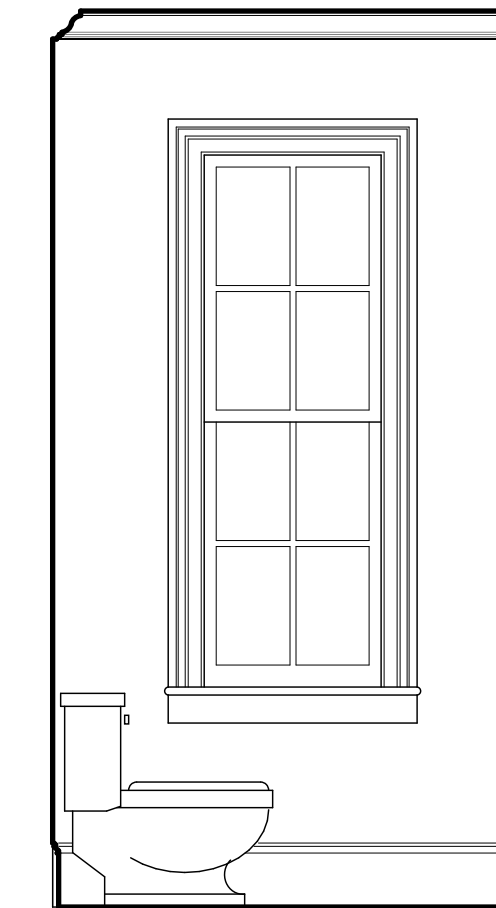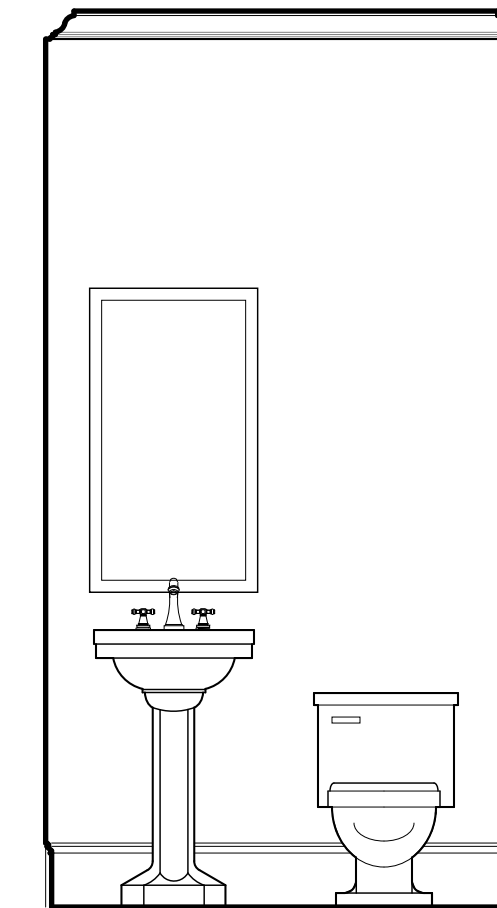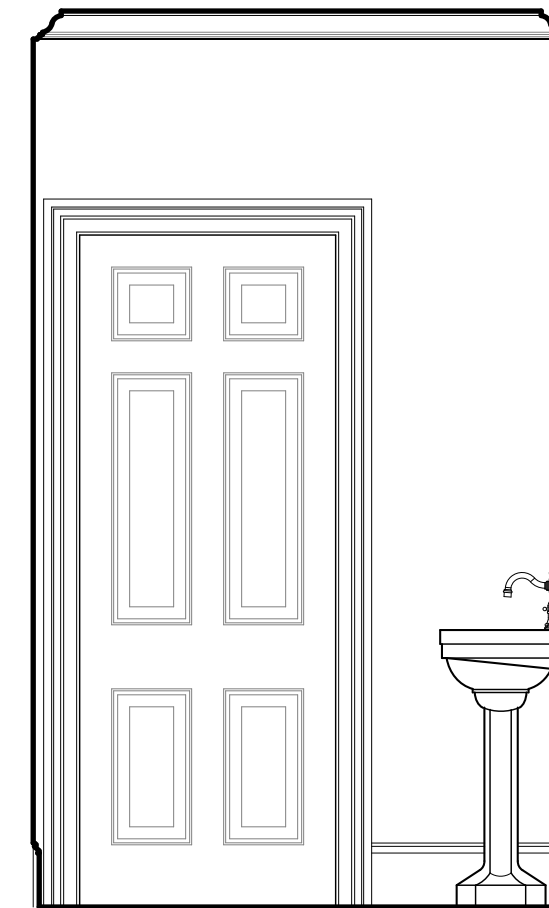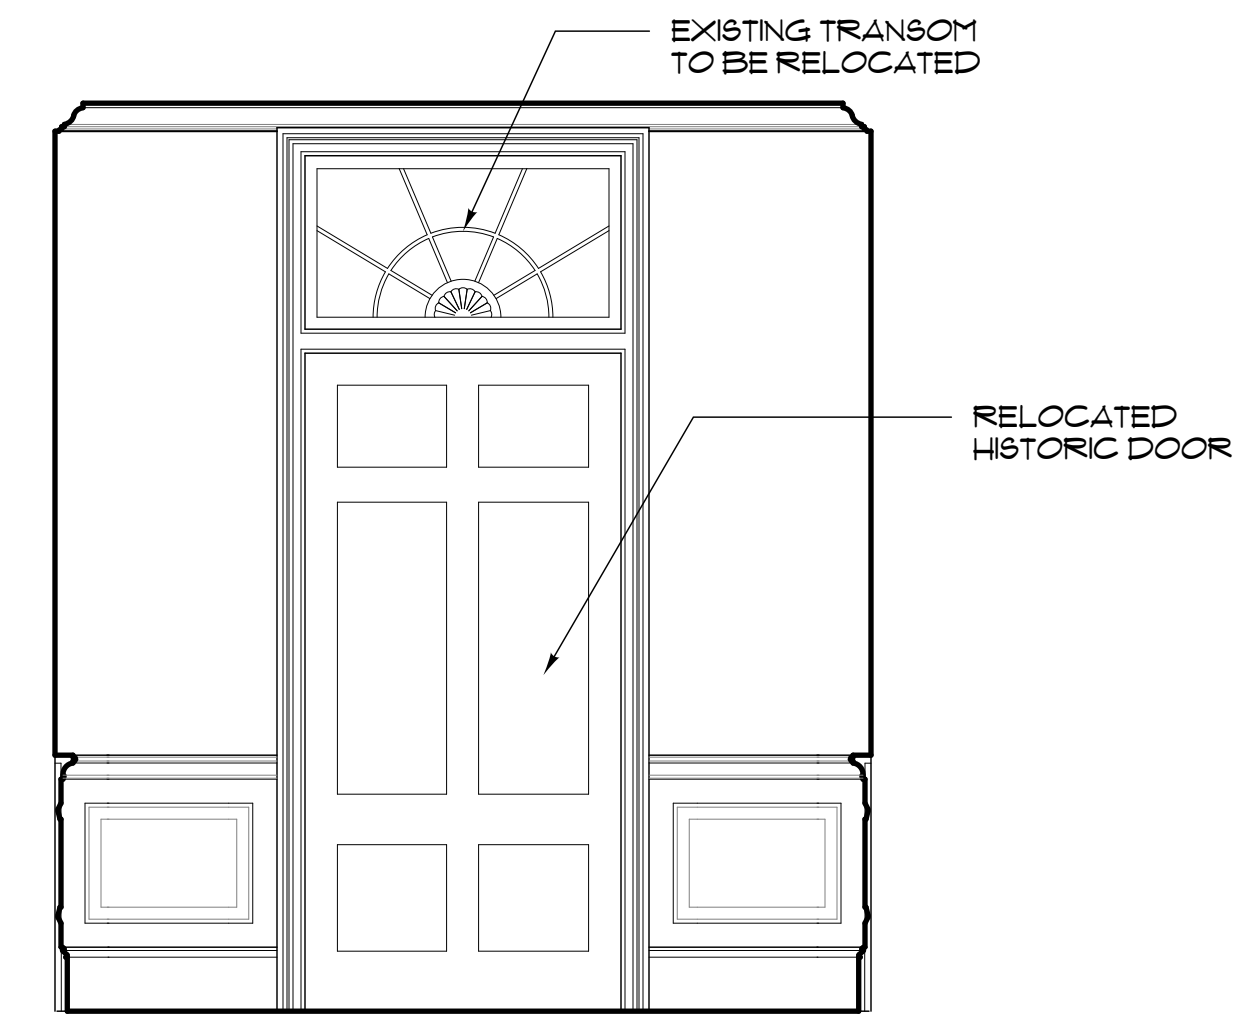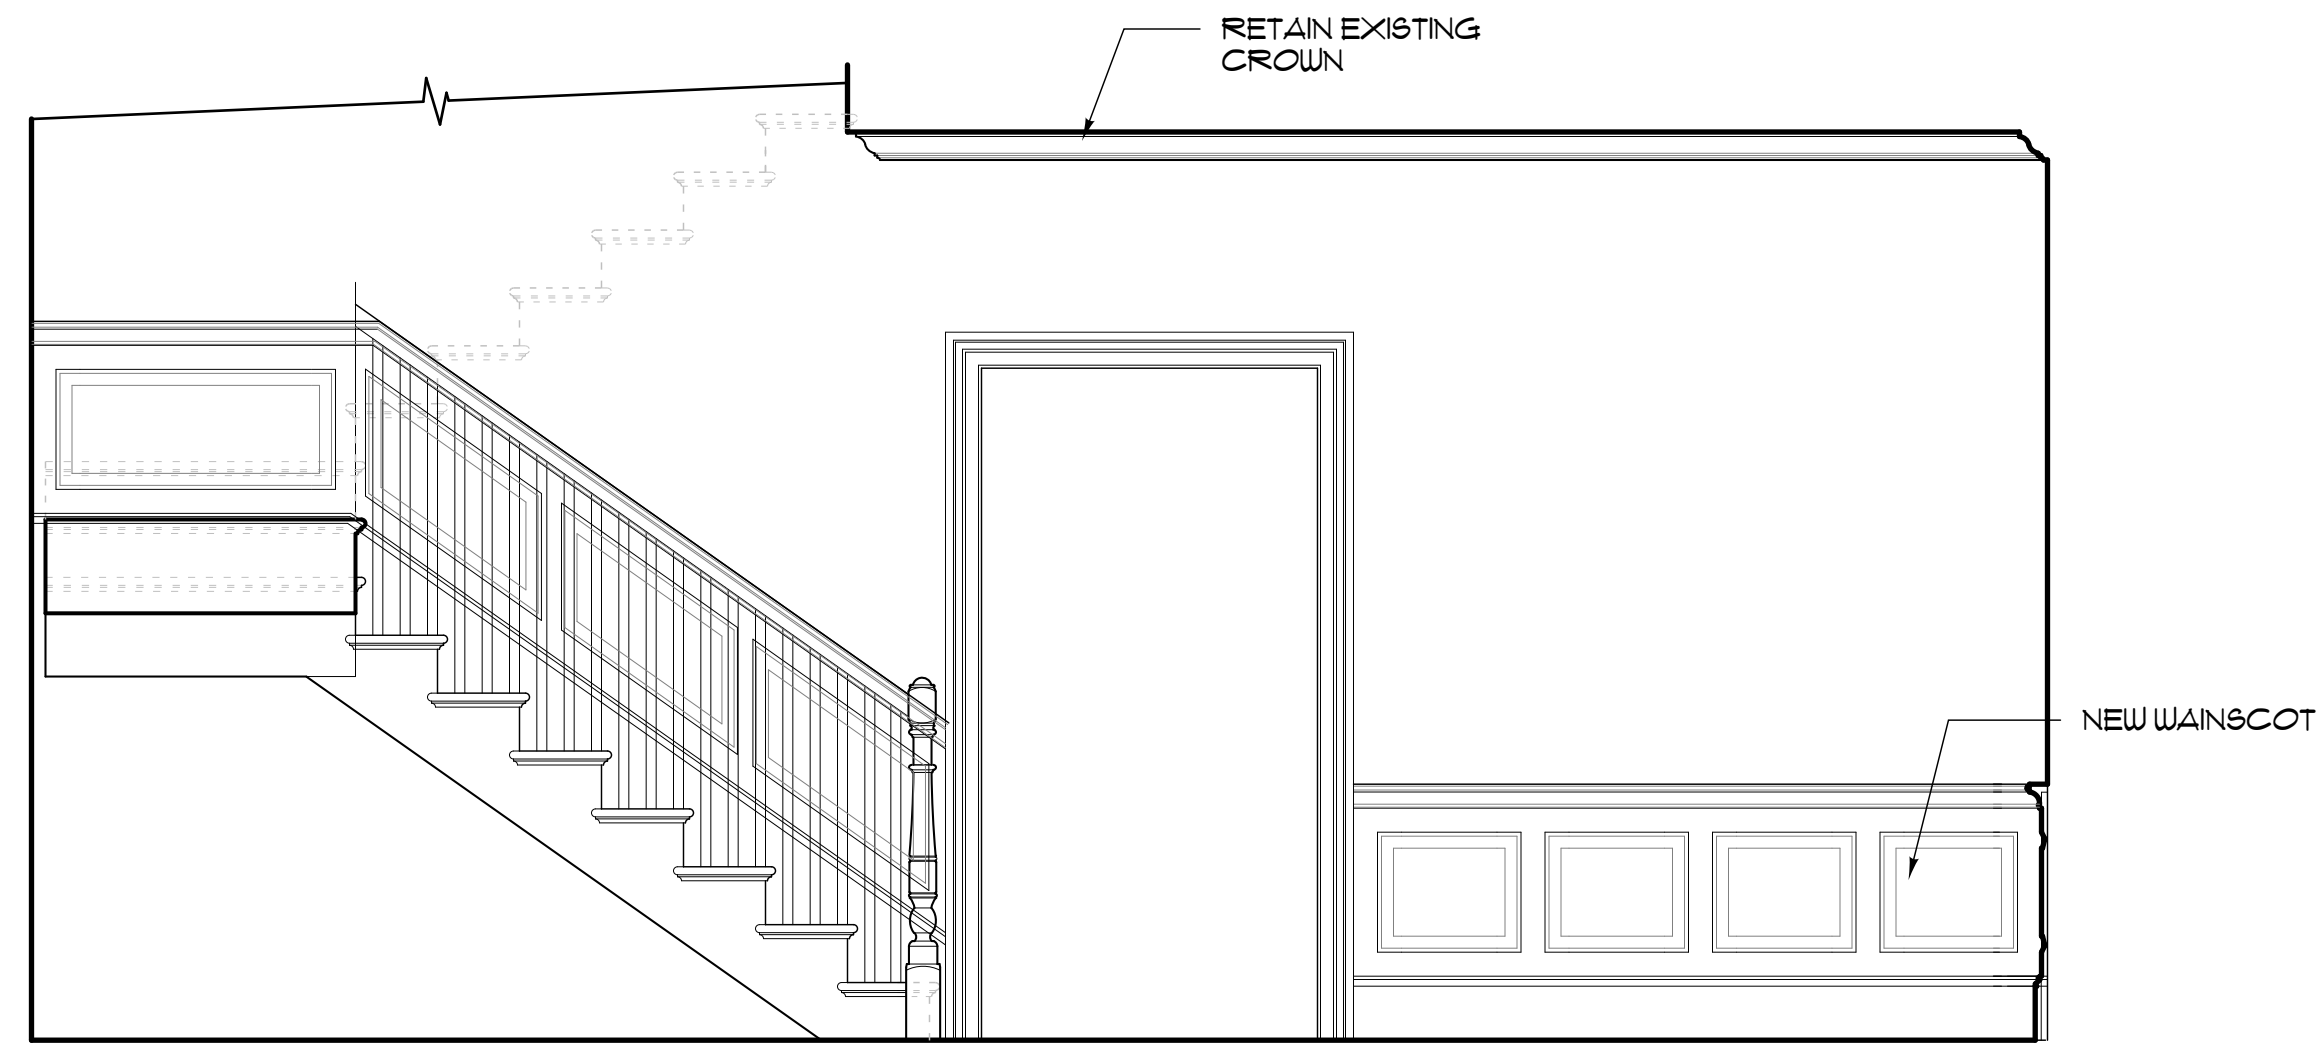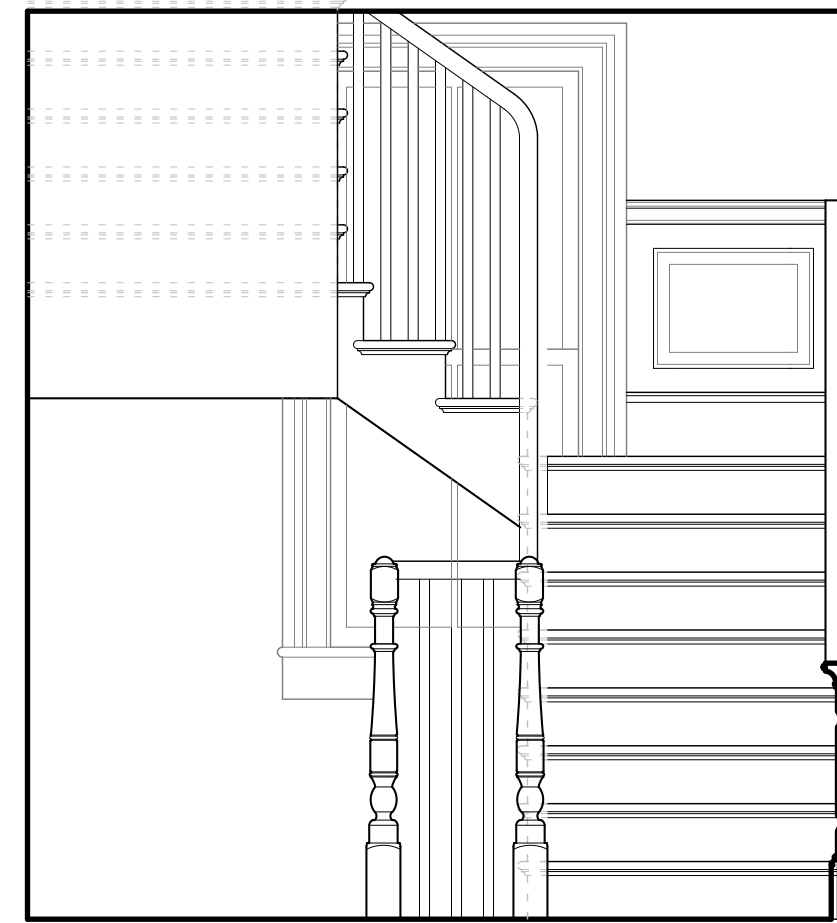Glenn Keyes
Architects

12 Vandermorist Street
Charleston, SC 29403
(843) 722-4100
www.glenkeyesarchitects.com

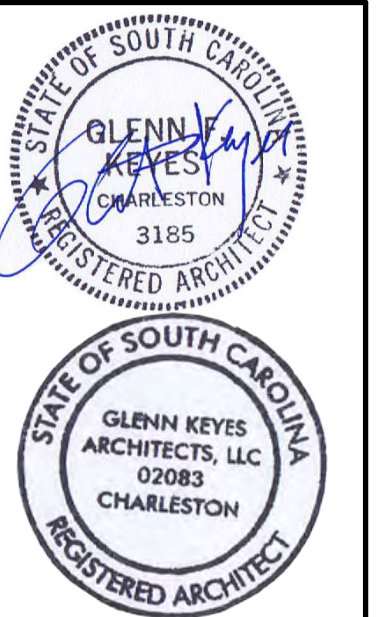

79 Anson Street
The Edward Mortimer House
c.1806
Charleston, South Carolina

INTERIOR ELEVATIONS





REV.	DATE
PROJECT NUMBER	
1705	
DRAWING DATE	
8/30/17	
SHEET NUMBER	




1
A402 KITCHEN ELEVATION
SCALE: 1/4" = 1'-0"




2
A402 KITCHEN ELEVATION
SCALE: 1/4" = 1'-0"

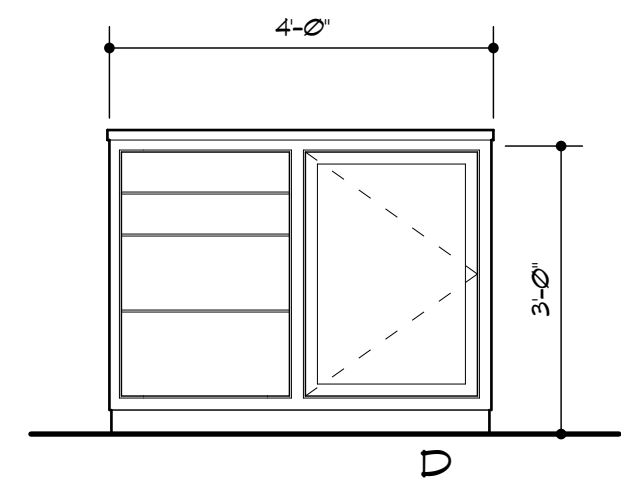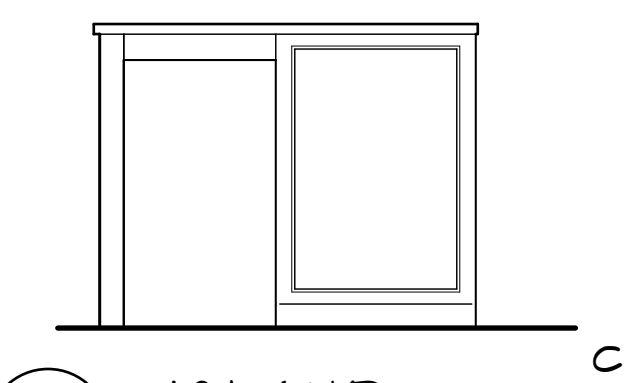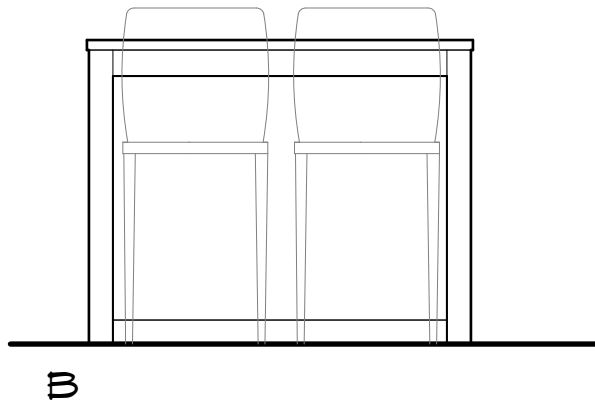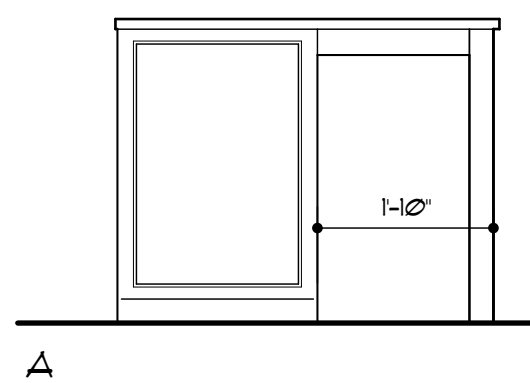


3
A402 ISLAND
SCALE: 1/4" = 1'-0"

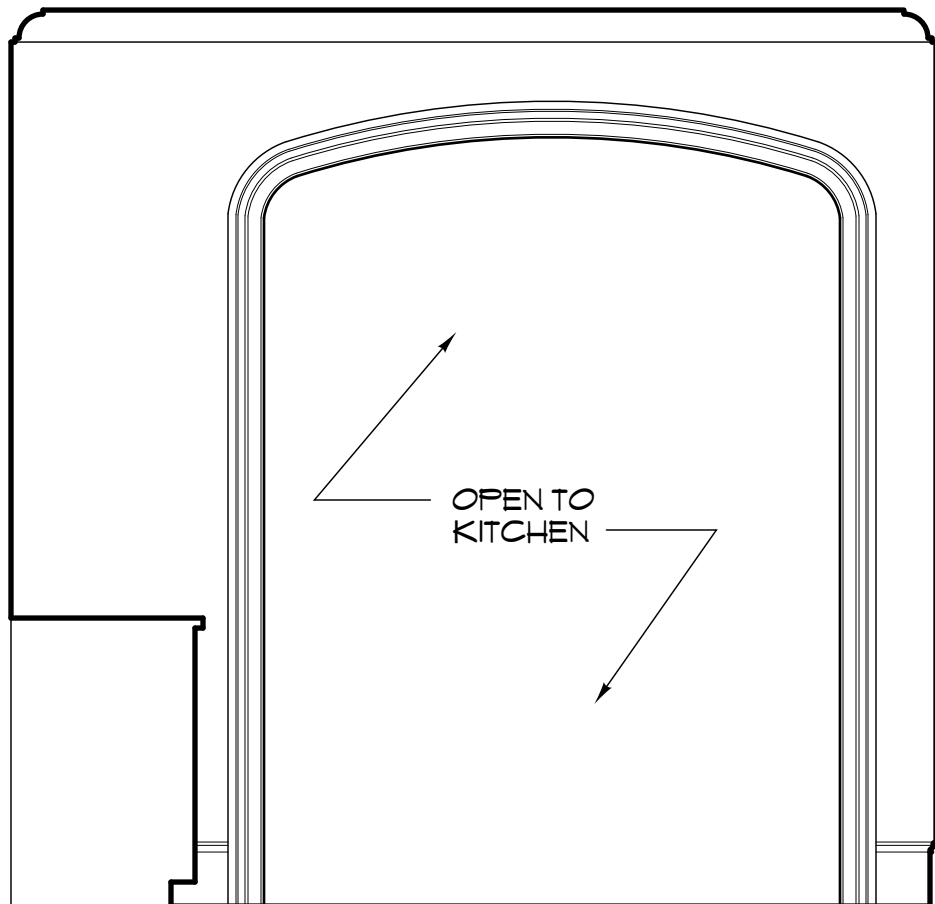


4
A402 BAR
SCALE: 1/4" = 1'-0"

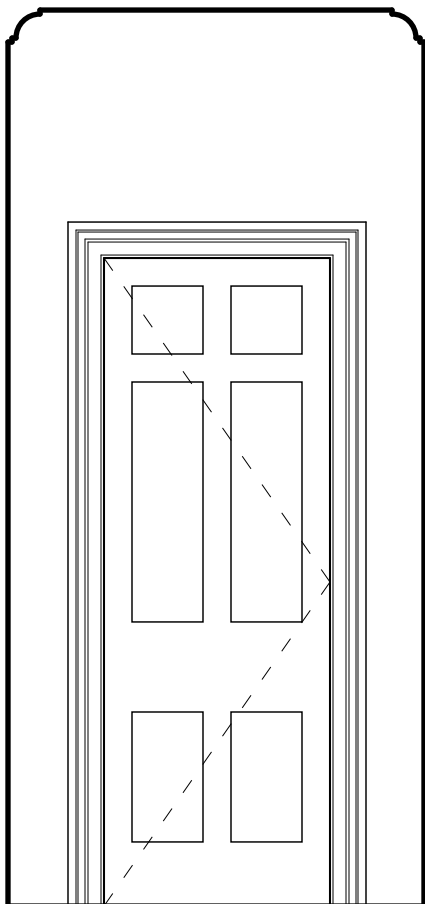


5
A402 BAR
SCALE: 1/4" = 1'-0"

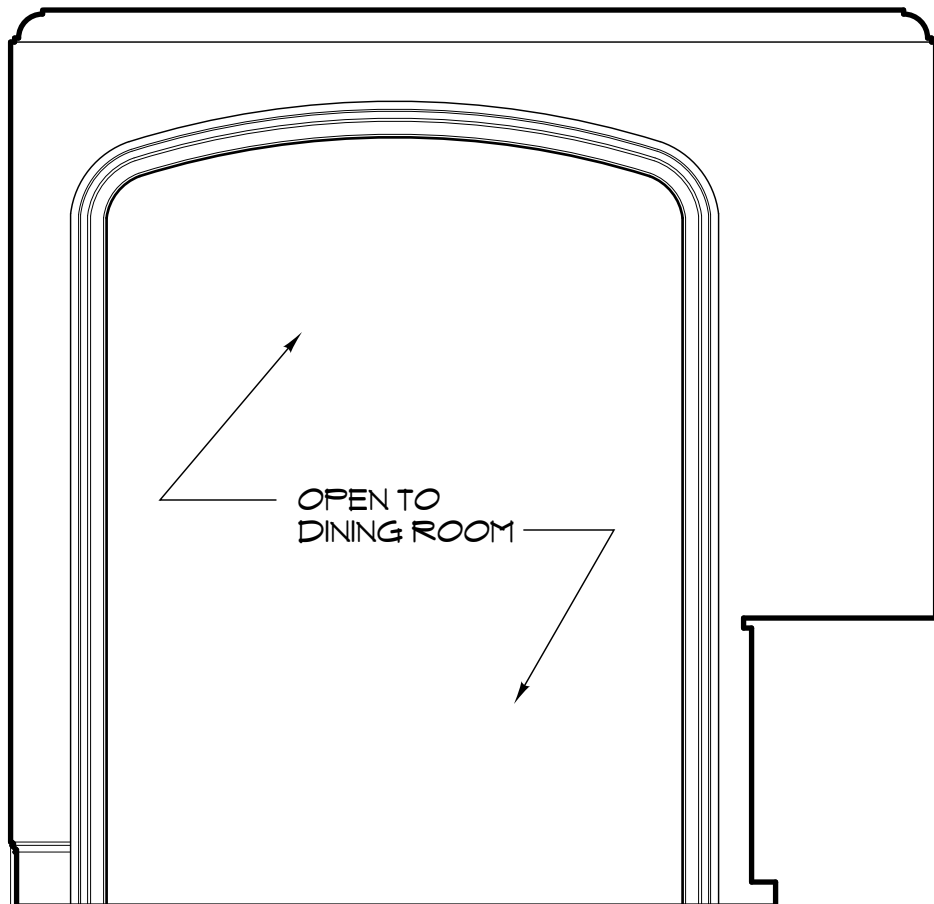


6
A402 BAR
SCALE: 1/4" = 1'-0"

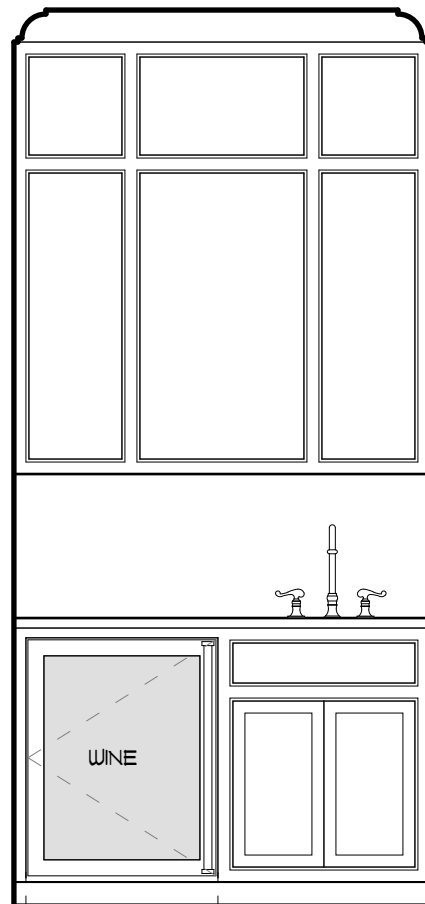


7
A402 BAR
SCALE: 1/4" = 1'-0"

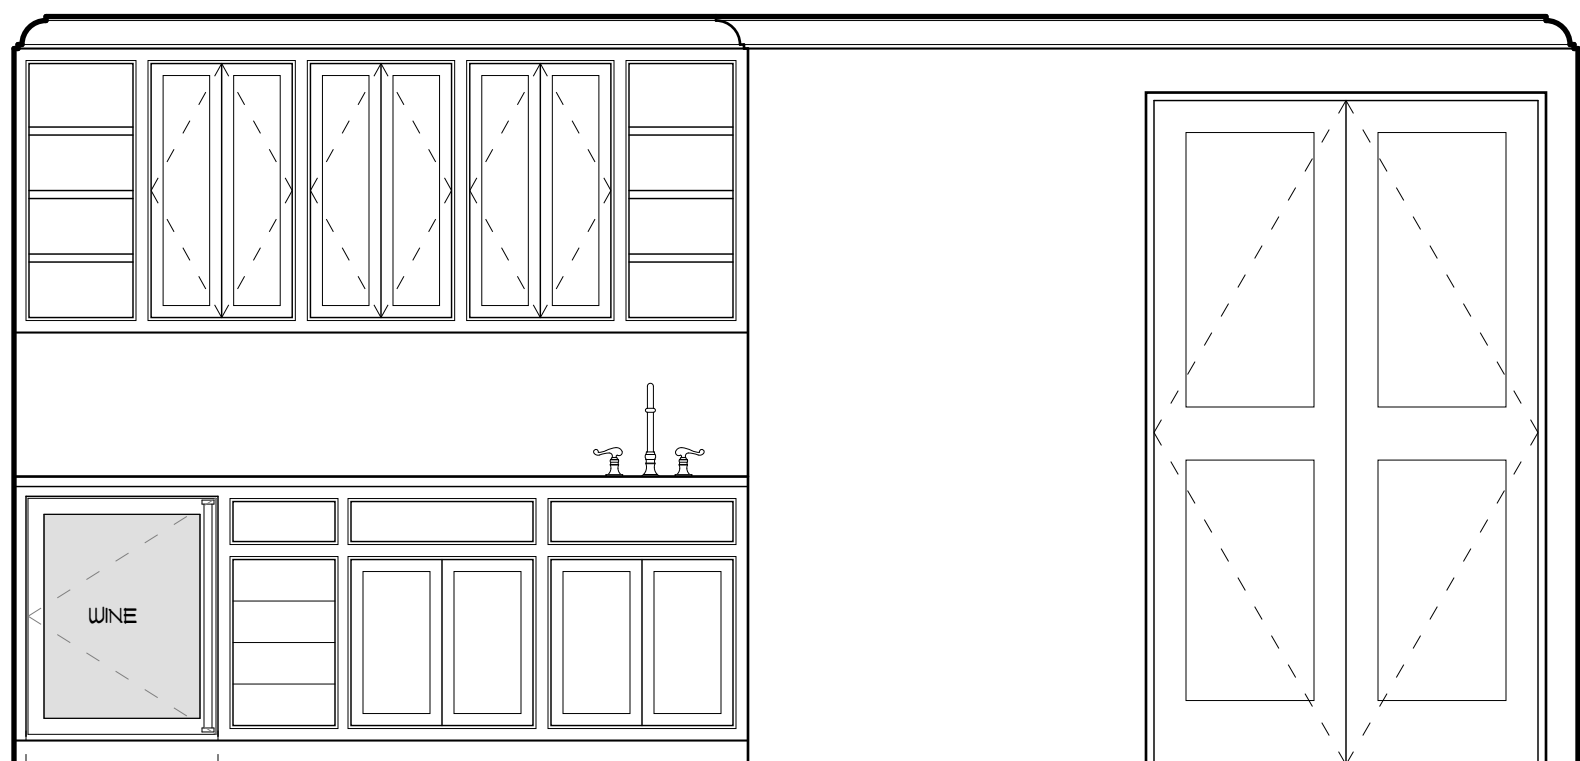


8
A402 GAMEROOM
SCALE: 1/4" = 1'-0"

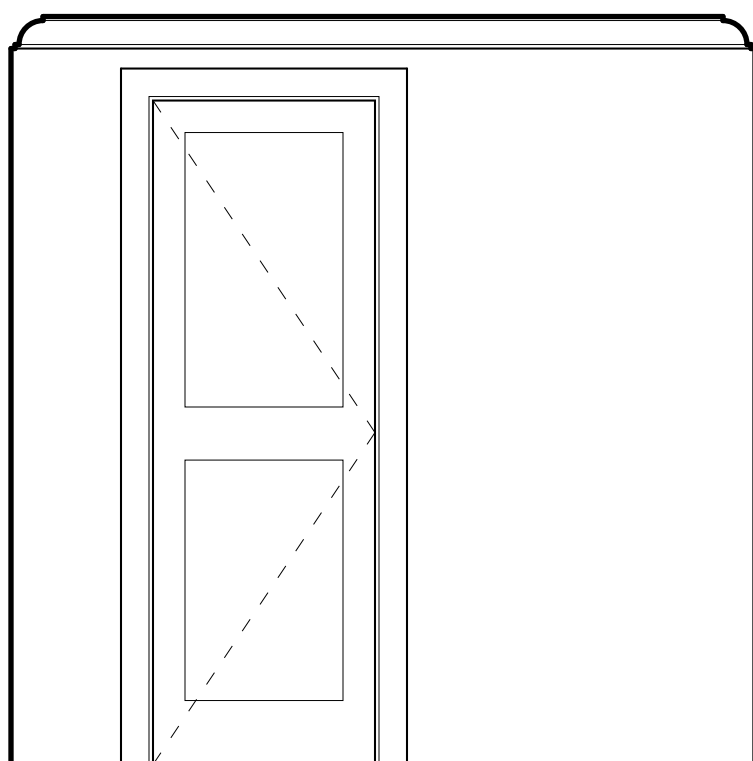


9
A402 GAMEROOM
SCALE: 1/4" = 1'-0"

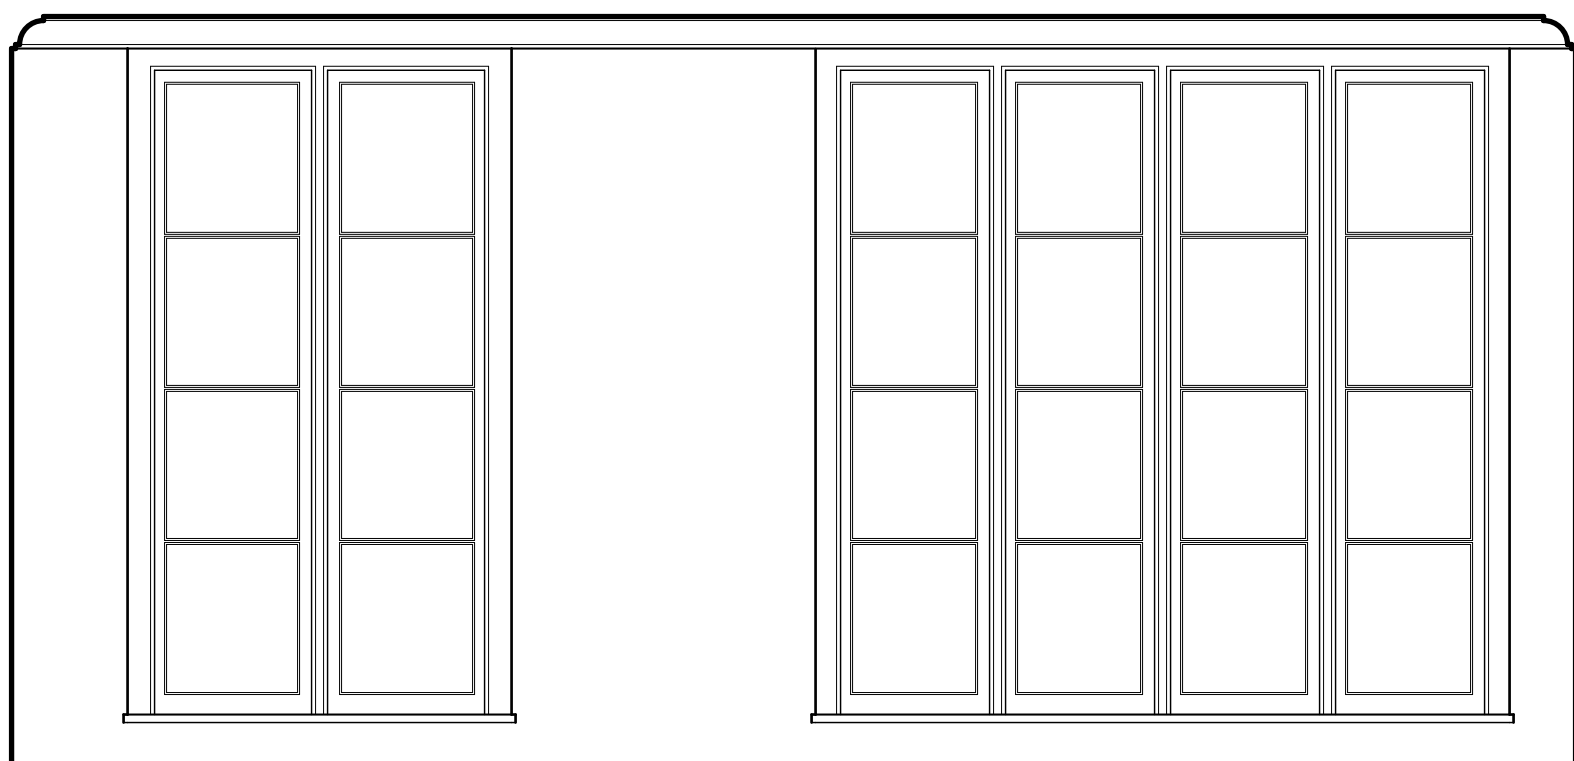


10
A402 GAMEROOM
SCALE: 1/4" = 1'-0"

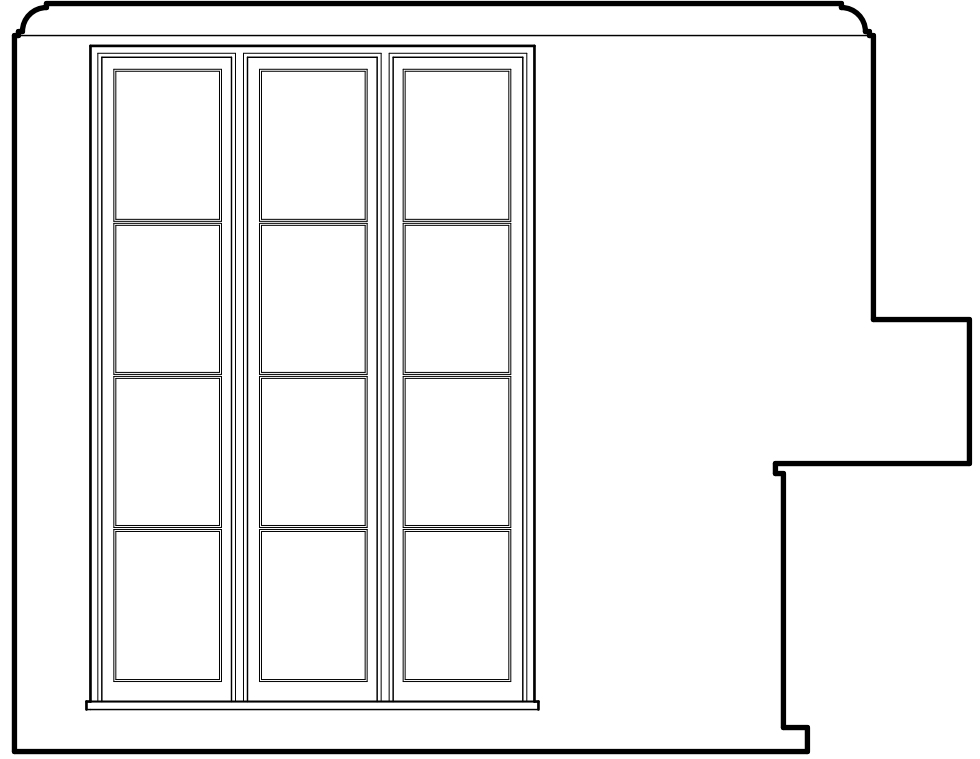


1
A403
GAMEROOM
SCALE: 1/4" = 1'-0"

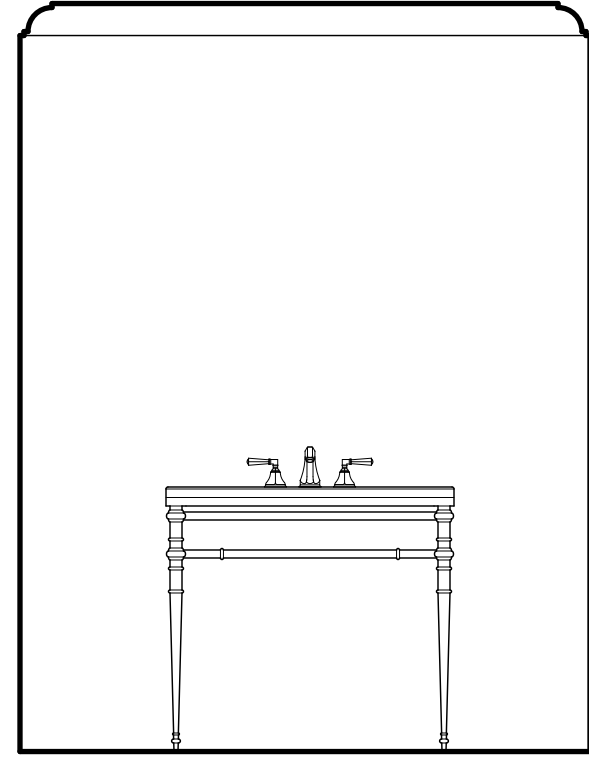


2
A403
BATH
SCALE: 1/4" = 1'-0"

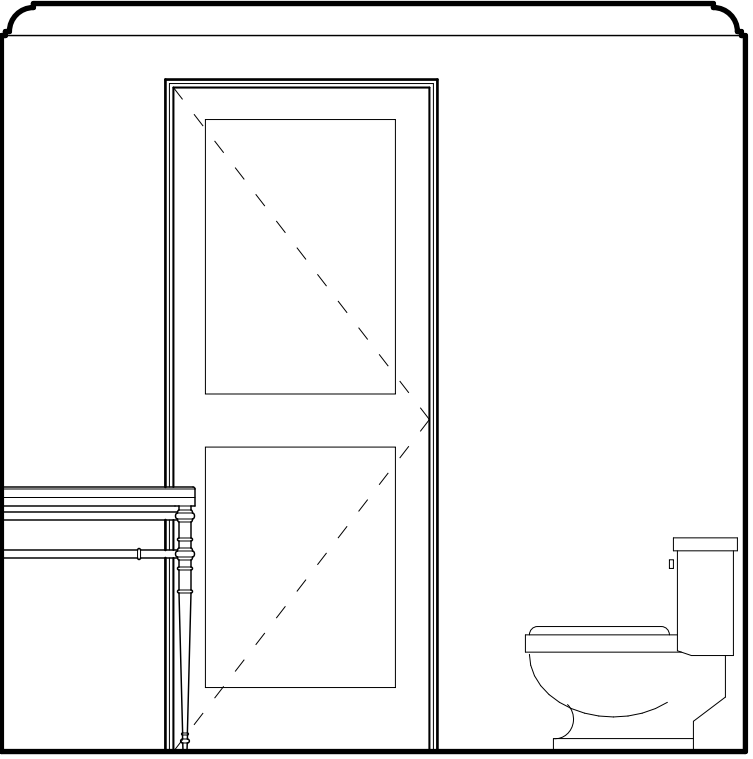


3
A403
BATH
SCALE: 1/4" = 1'-0"

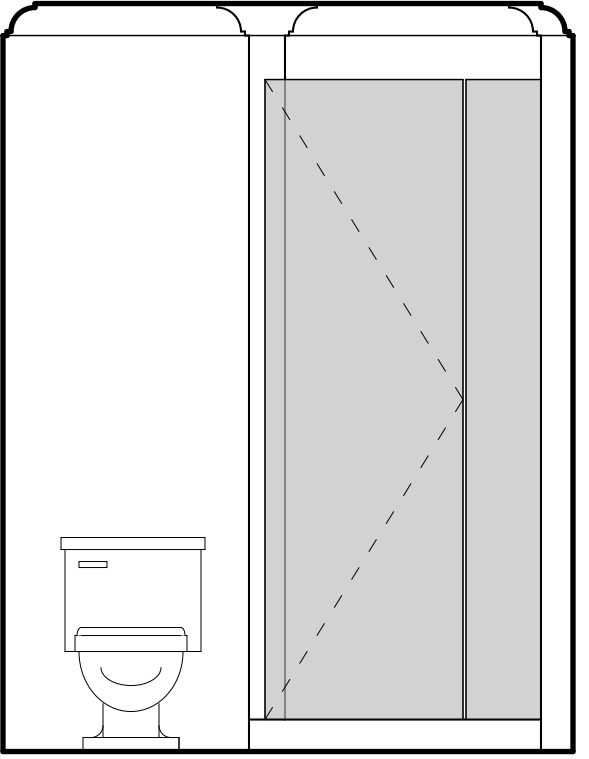


4
A403
BATH
SCALE: 1/4" = 1'-0"

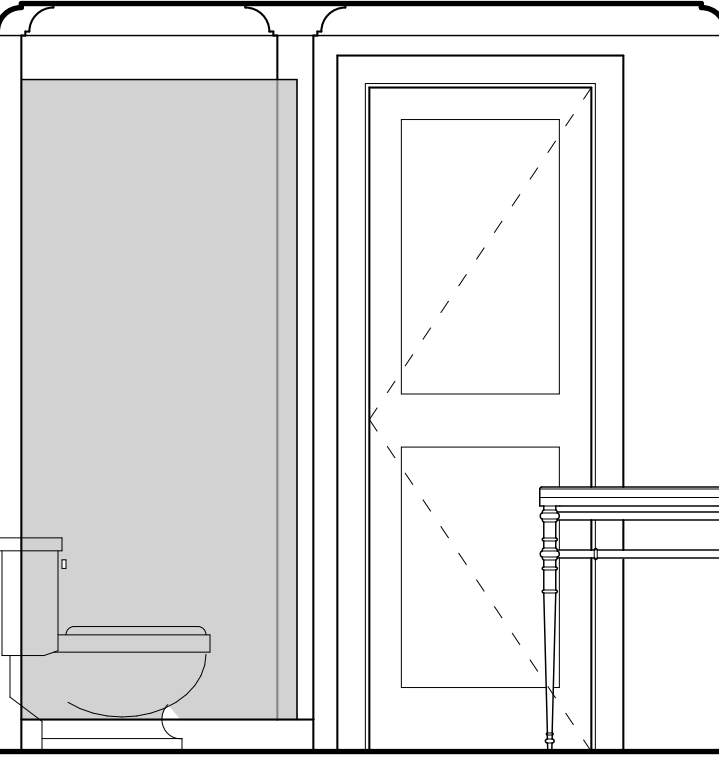


5
A403
BATH
SCALE: 1/4" = 1'-0"

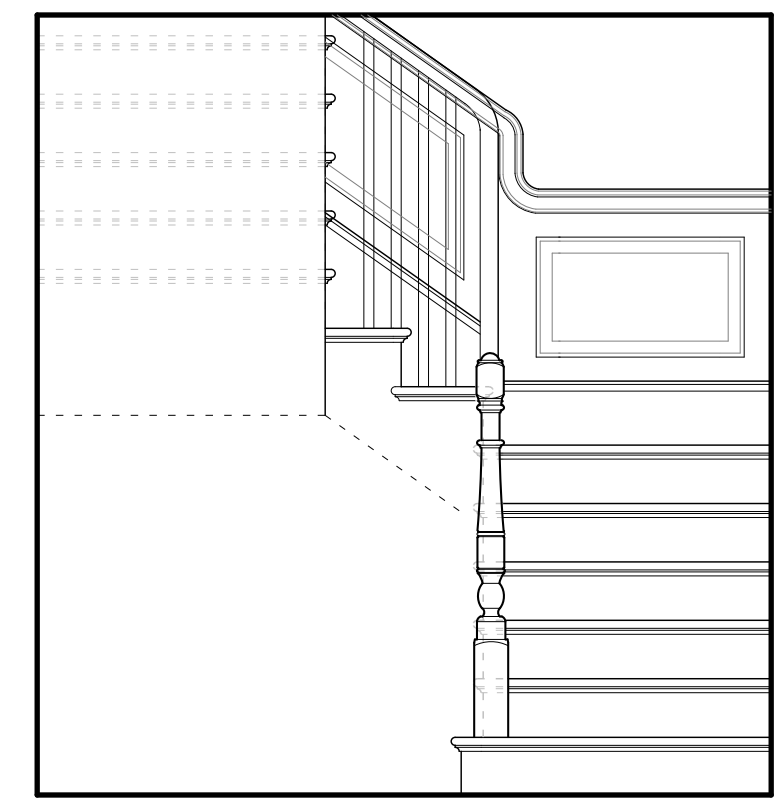


6
A403
STAIR HALL
SCALE: 1/4" = 1'-0"

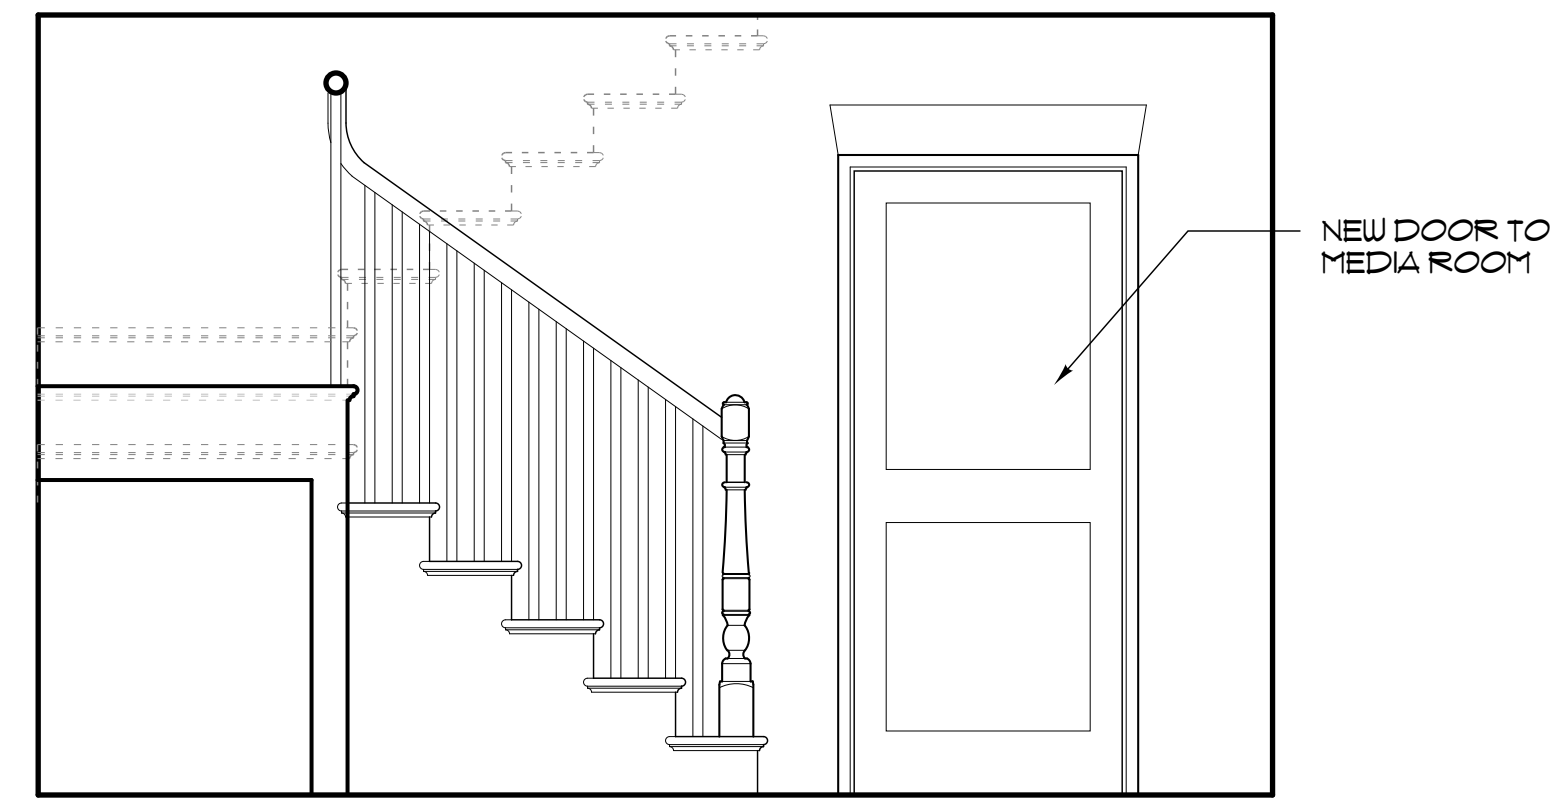


7
A403
STAIR HALL
SCALE: 1/4" = 1'-0"

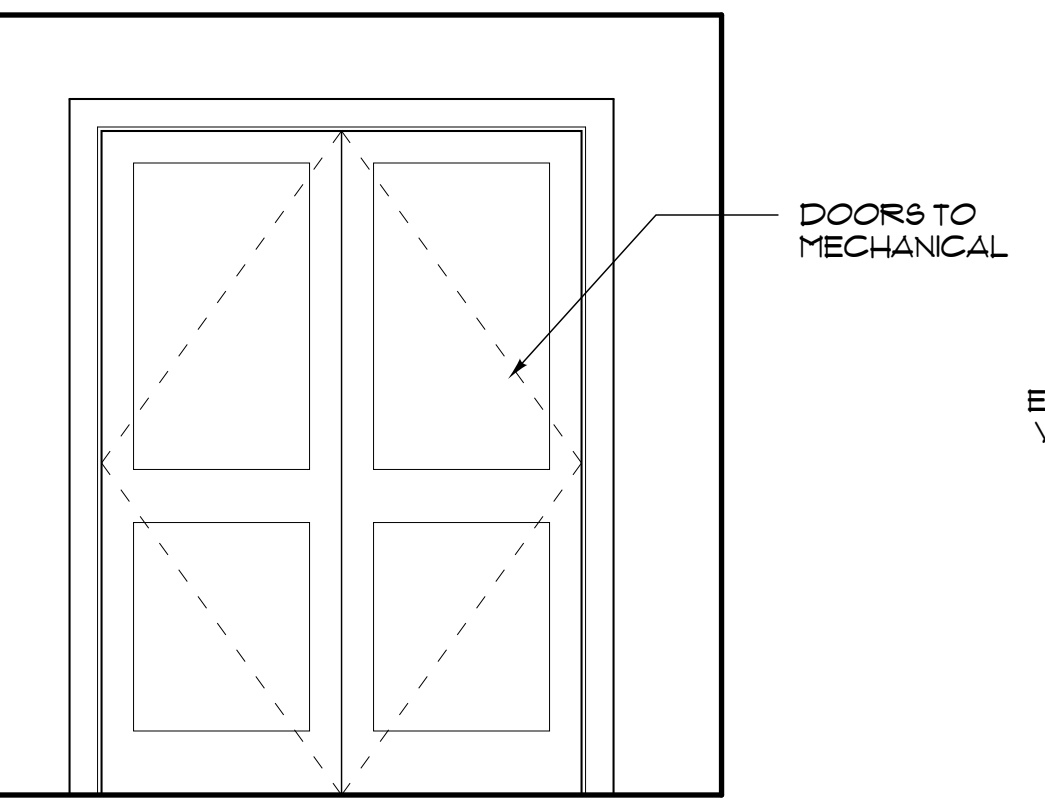


8
A403
STAIR HALL
SCALE: 1/4" = 1'-0"

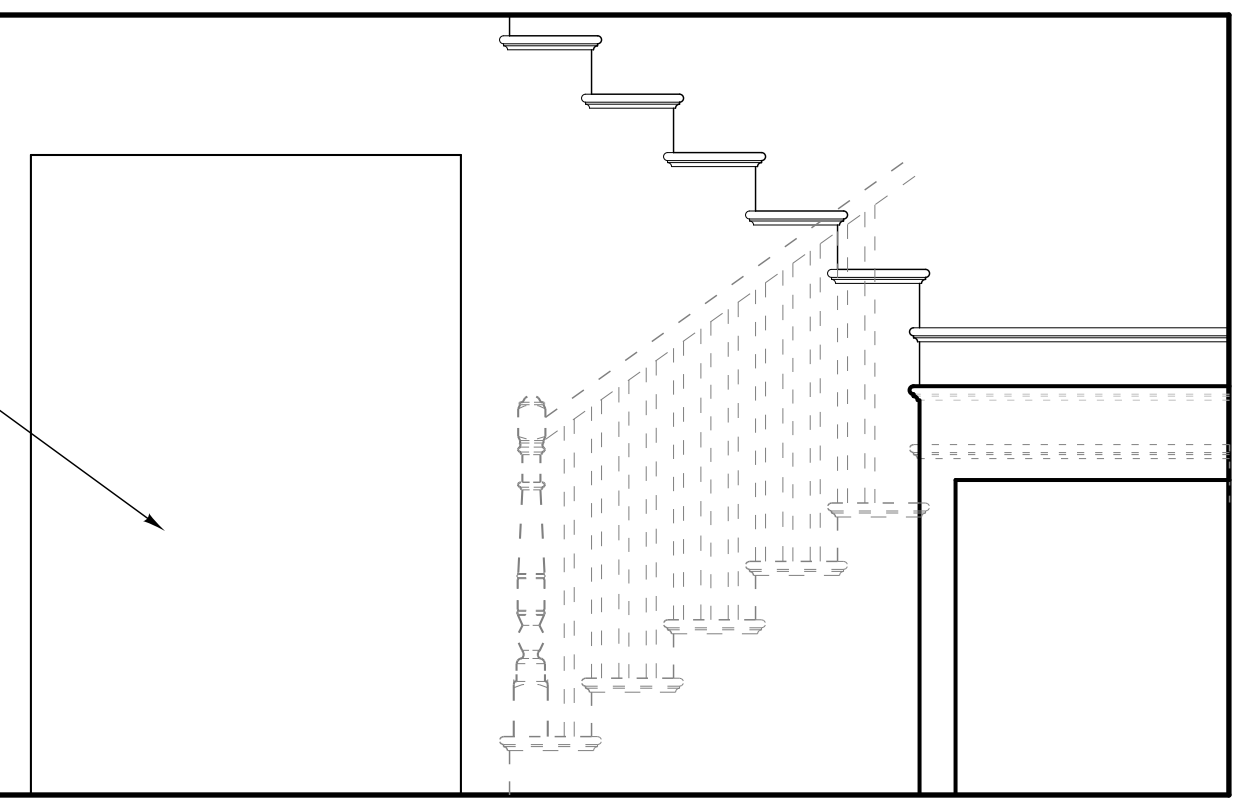


9
A403
STAIR HALL
SCALE: 1/4" = 1'-0"

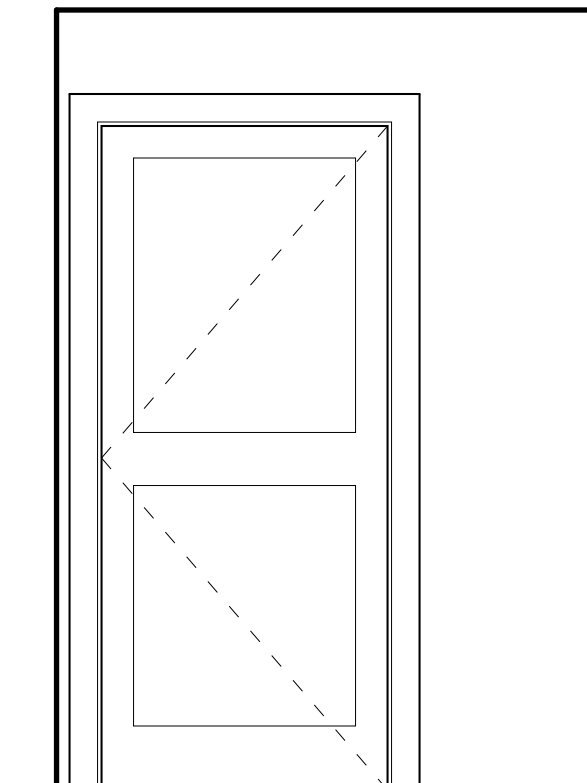


10
A403
GROUND FLOORENTRY
SCALE: 1/4" = 1'-0"

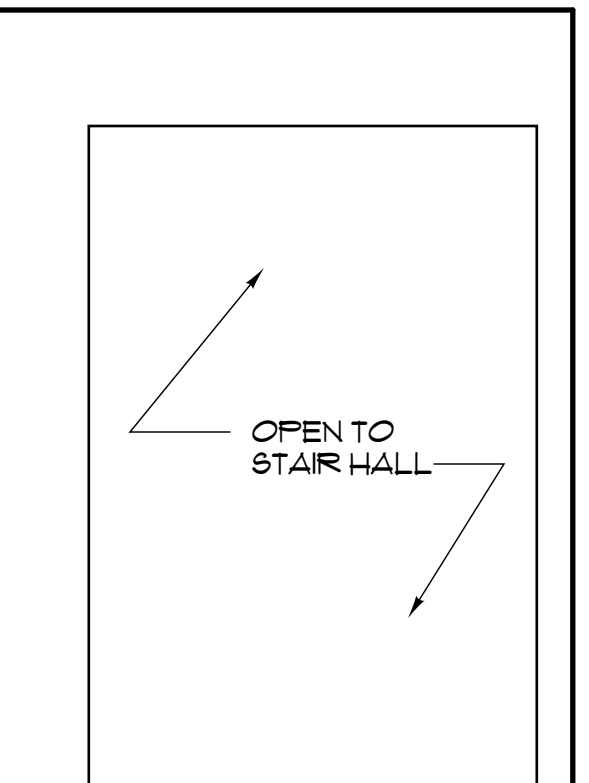





11
A403
GROUND FLOORENTRY
SCALE: 1/4" = 1'-0"

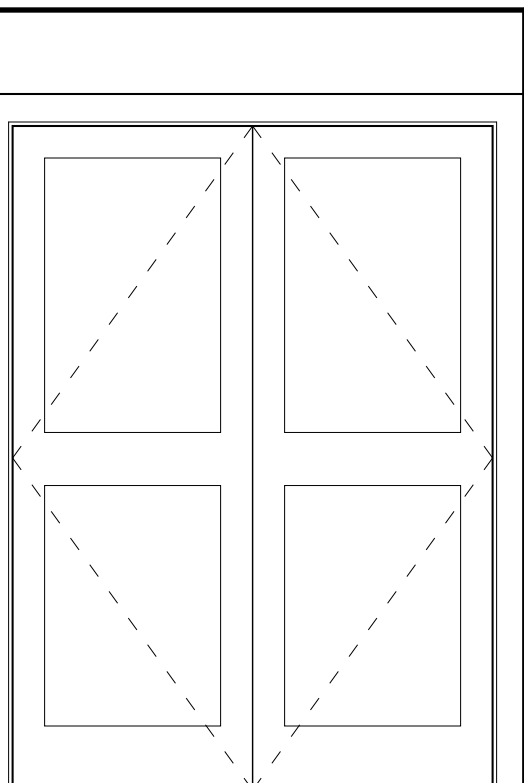


12
A403
GROUND FLOORENTRY
SCALE: 1/4" = 1'-0"

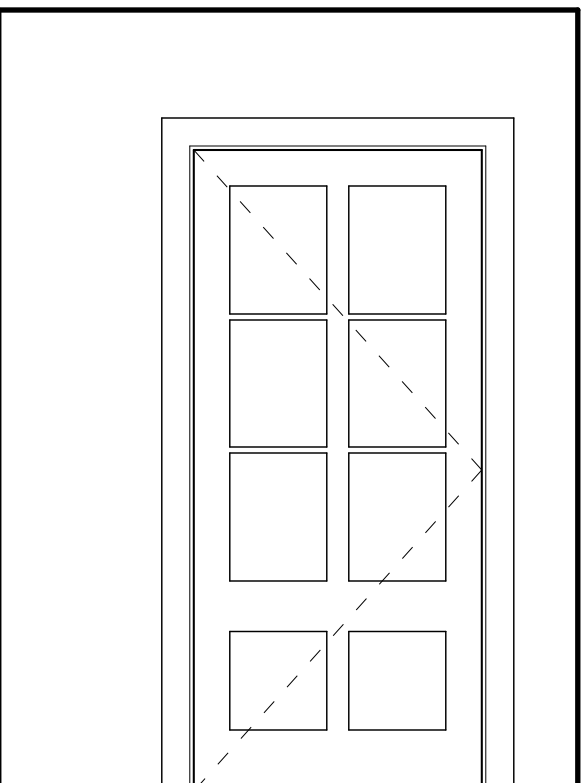

13
A403
GROUND FLOORENTRY
SCALE: 1/4" = 1'-0"

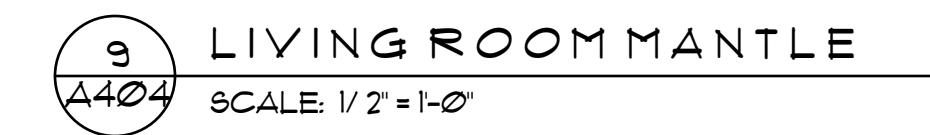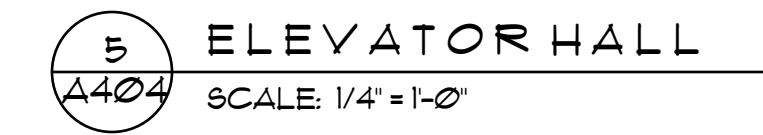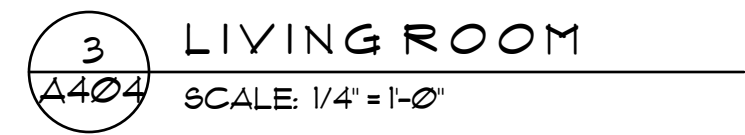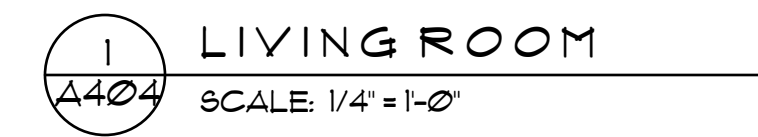Glenn Keyes
Architects

12 Vanderhorst Street
Charleston, SC 29403
(843) 722-4100
www.glenkeyesarchitects.com

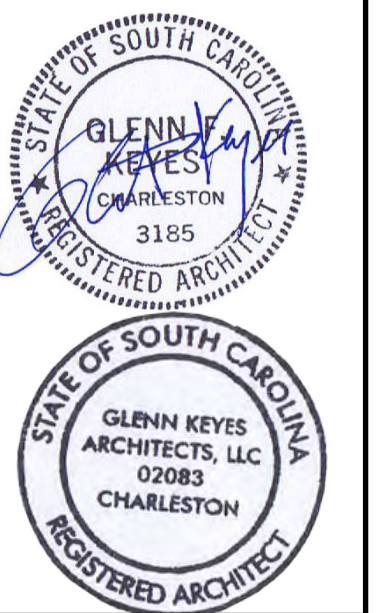


79 Anson Street
The Edward Mortimer House
c.1806
Charleston, South Carolina


INTERIOR ELEVATIONS

REV.	DATE
PROJECT NUMBER	
1705	
DRAWING DATE	
8/30/17	
SHEET NUMBER	

A404

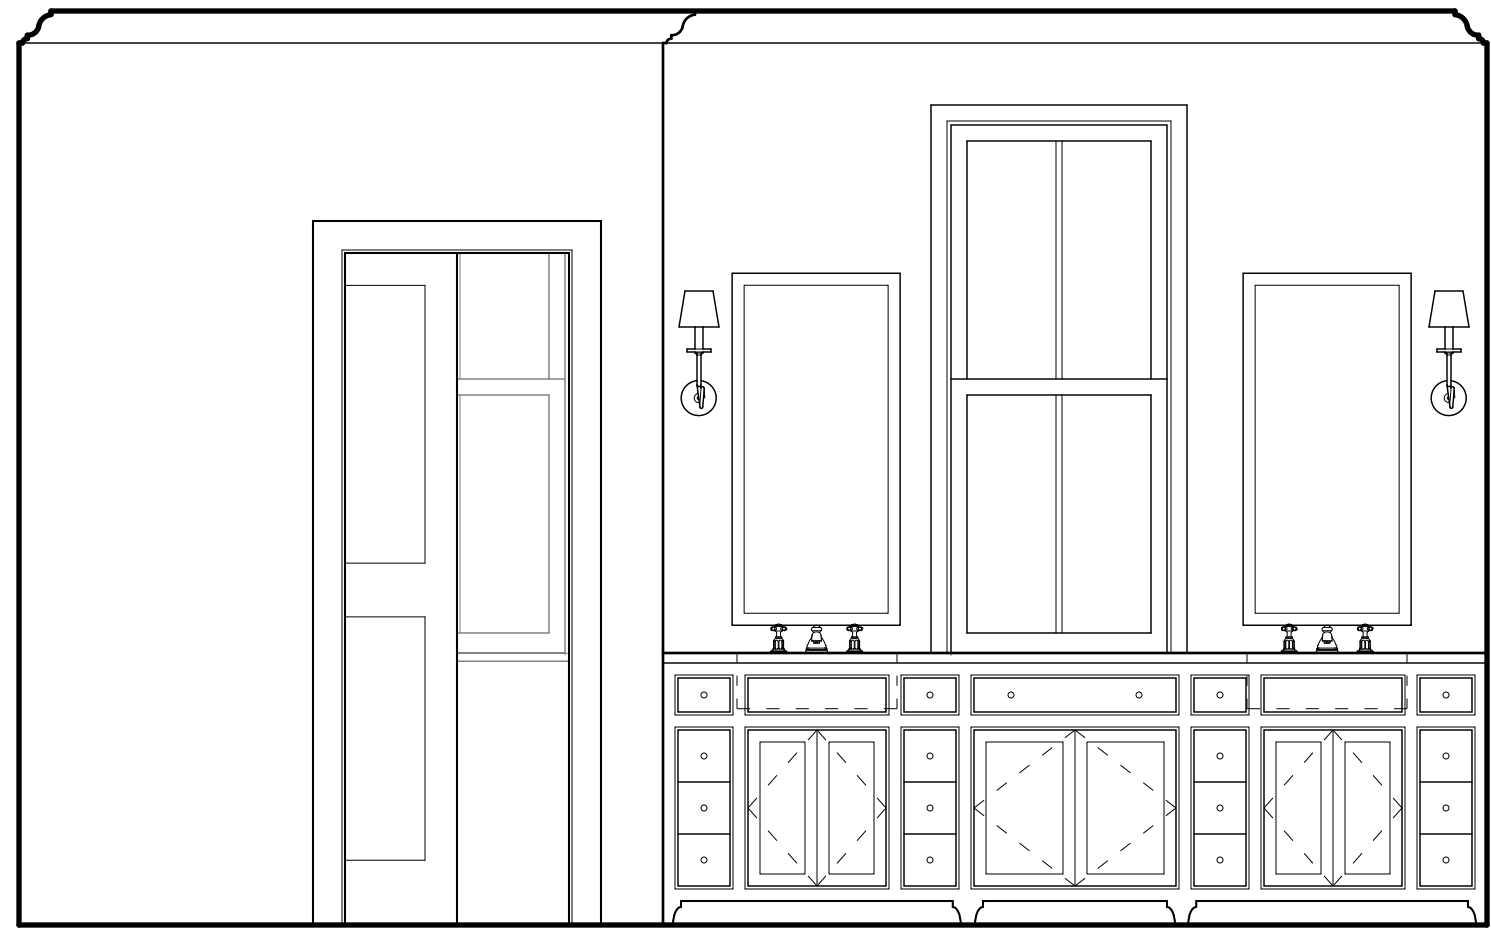


1 MASTER BATHROOM
A405 SCALE: 1/4" = 1'-0"

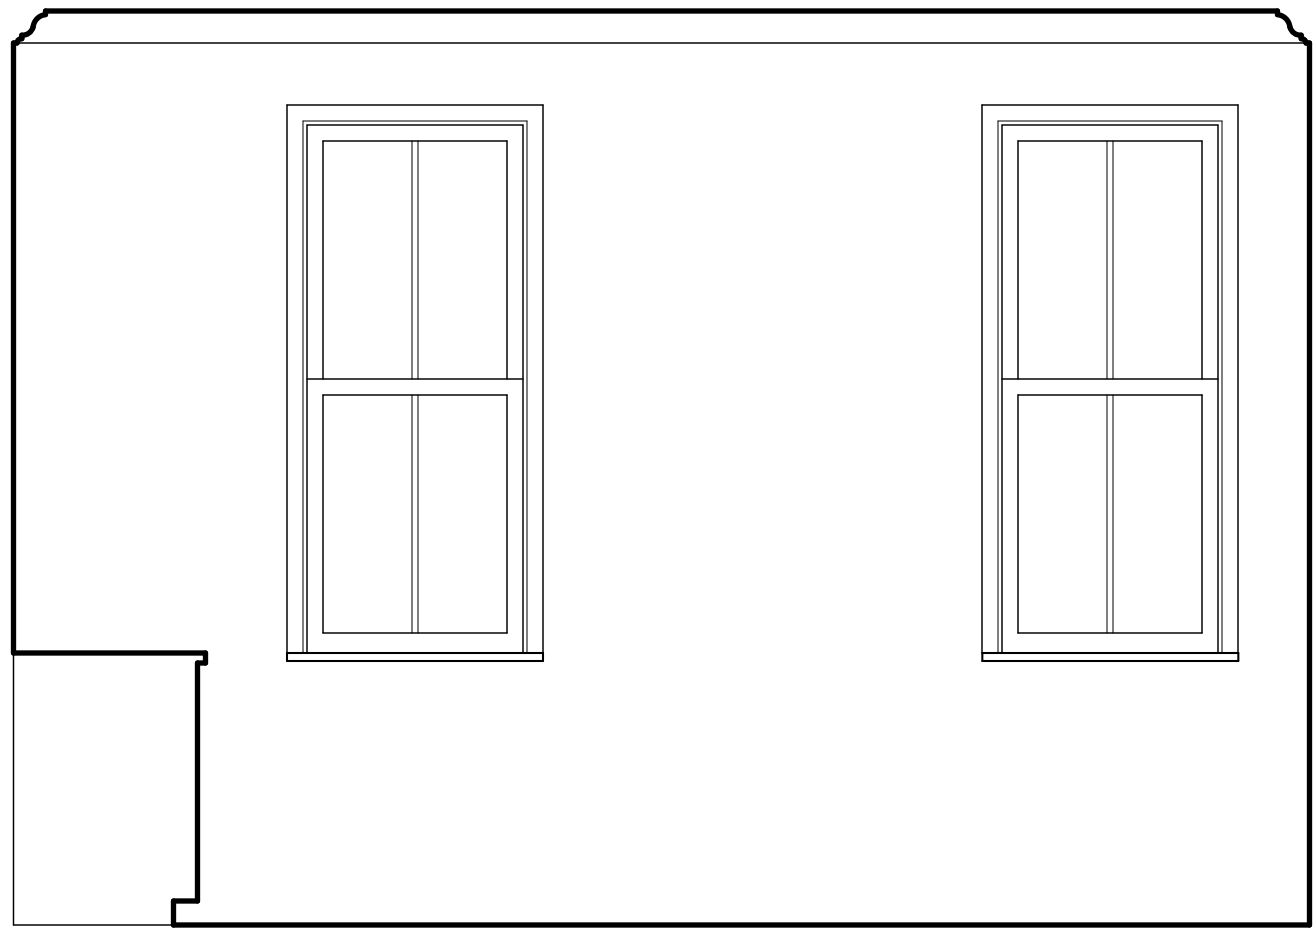


2 MASTER BATHROOM
A405 SCALE: 1/4" = 1'-0"




3 MASTER BATHROOM
A405 SCALE: 1/4" = 1'-0"

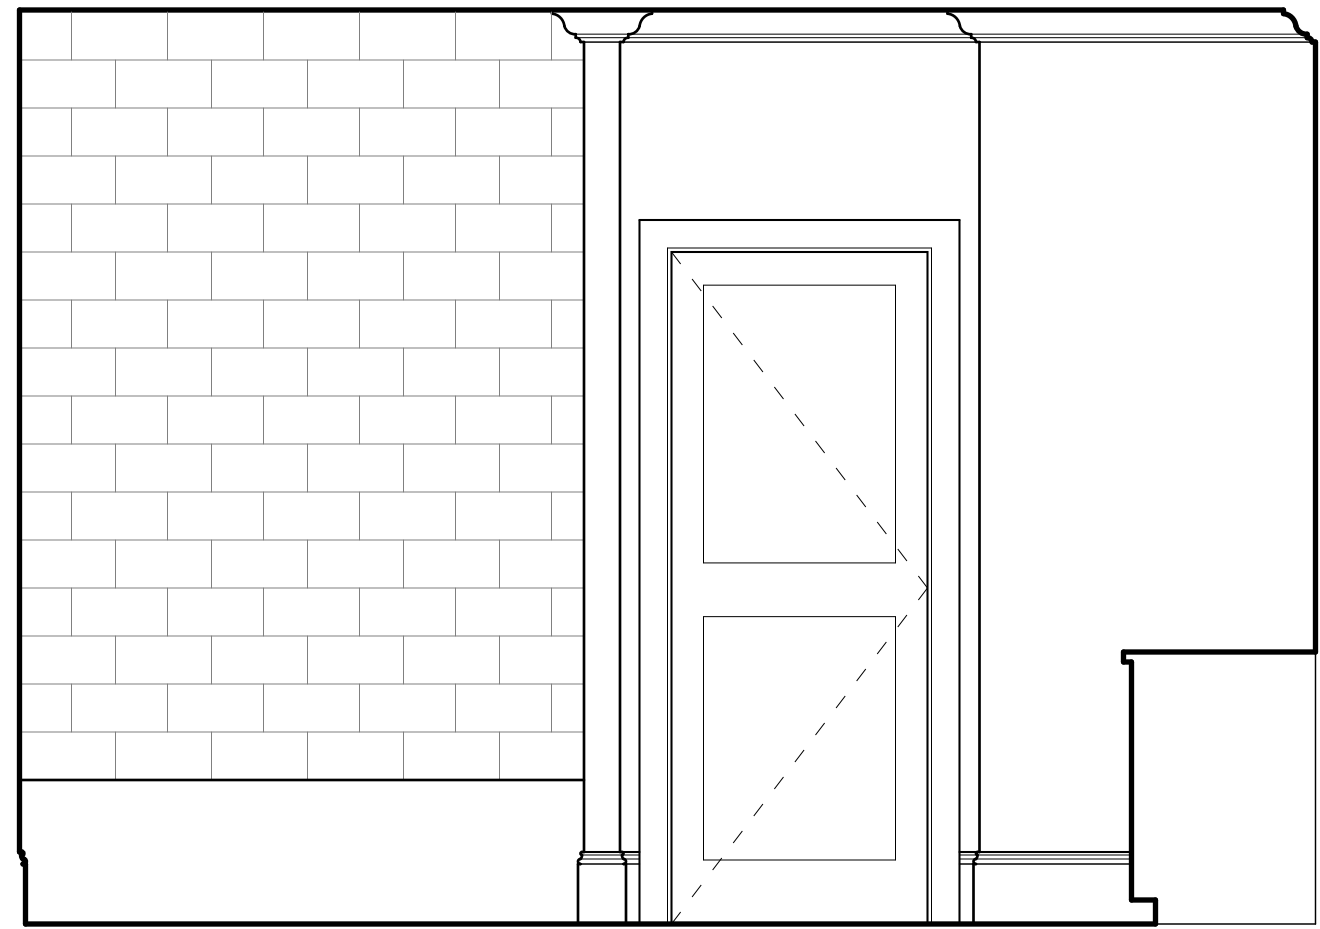


4 MASTER BATHROOM
A405 SCALE: 1/4" = 1'-0"

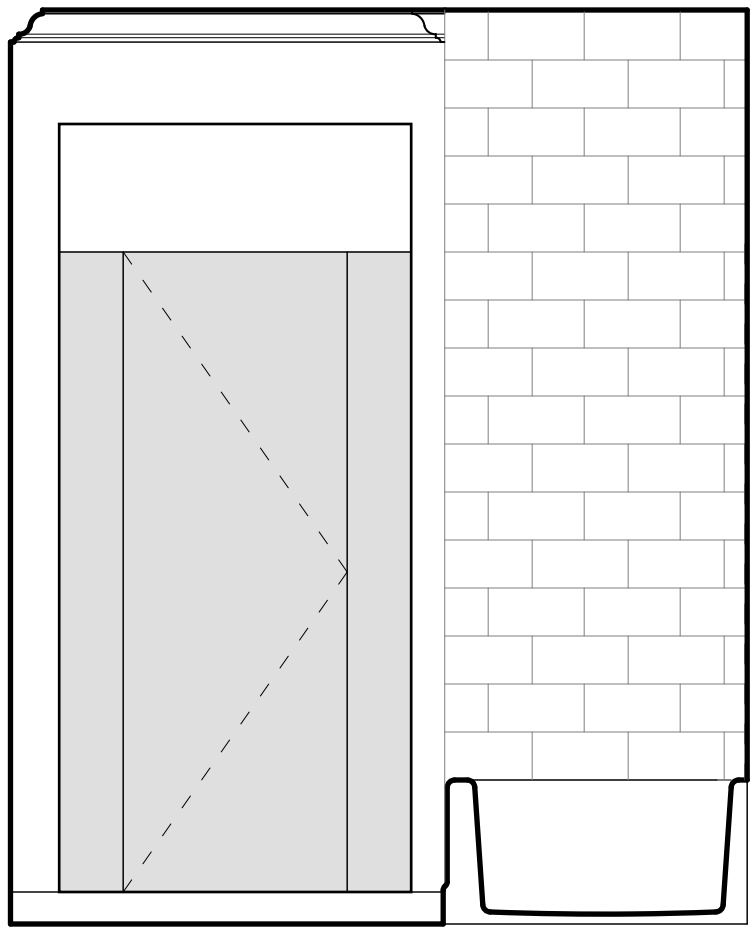


5 MASTER BATHROOM
A405 SCALE: 1/4" = 1'-0"

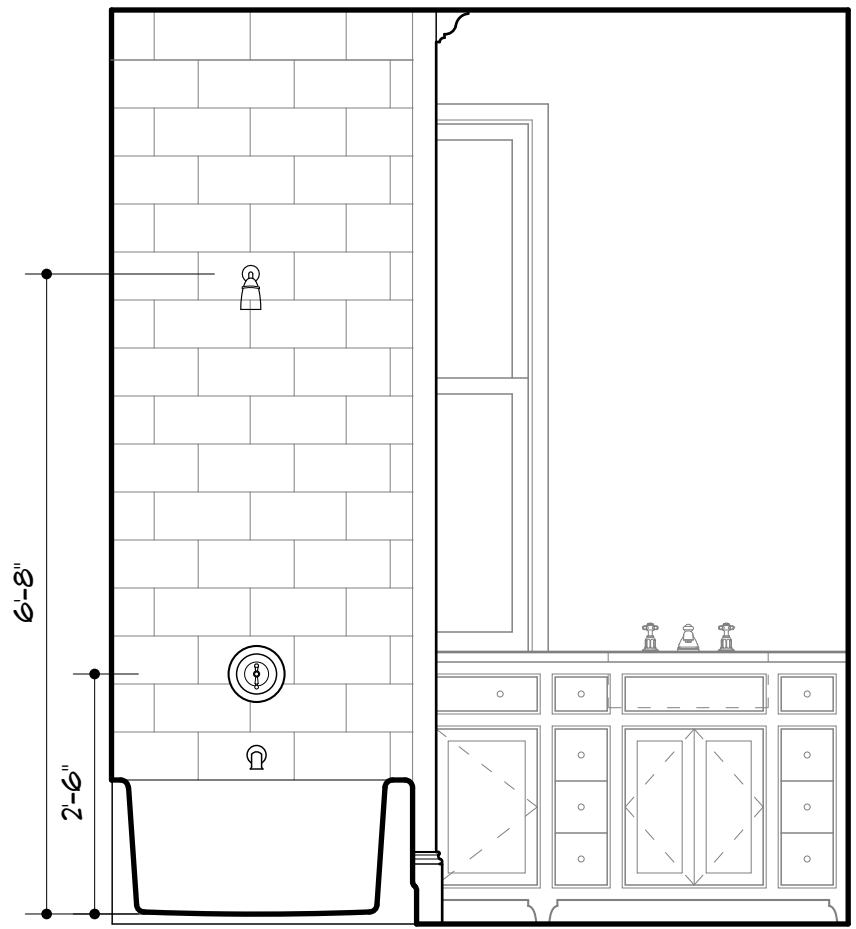


6 MASTER BATHROOM
A405 SCALE: 1/4" = 1'-0"

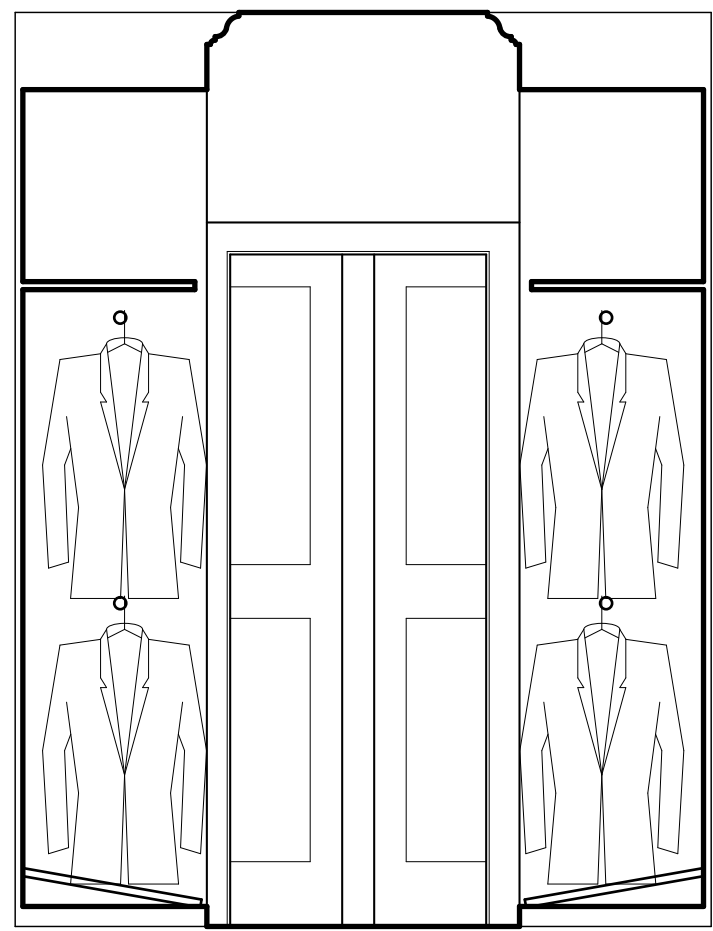


7 MASTER DRESSING
A405 SCALE: 1/4" = 1'-0"

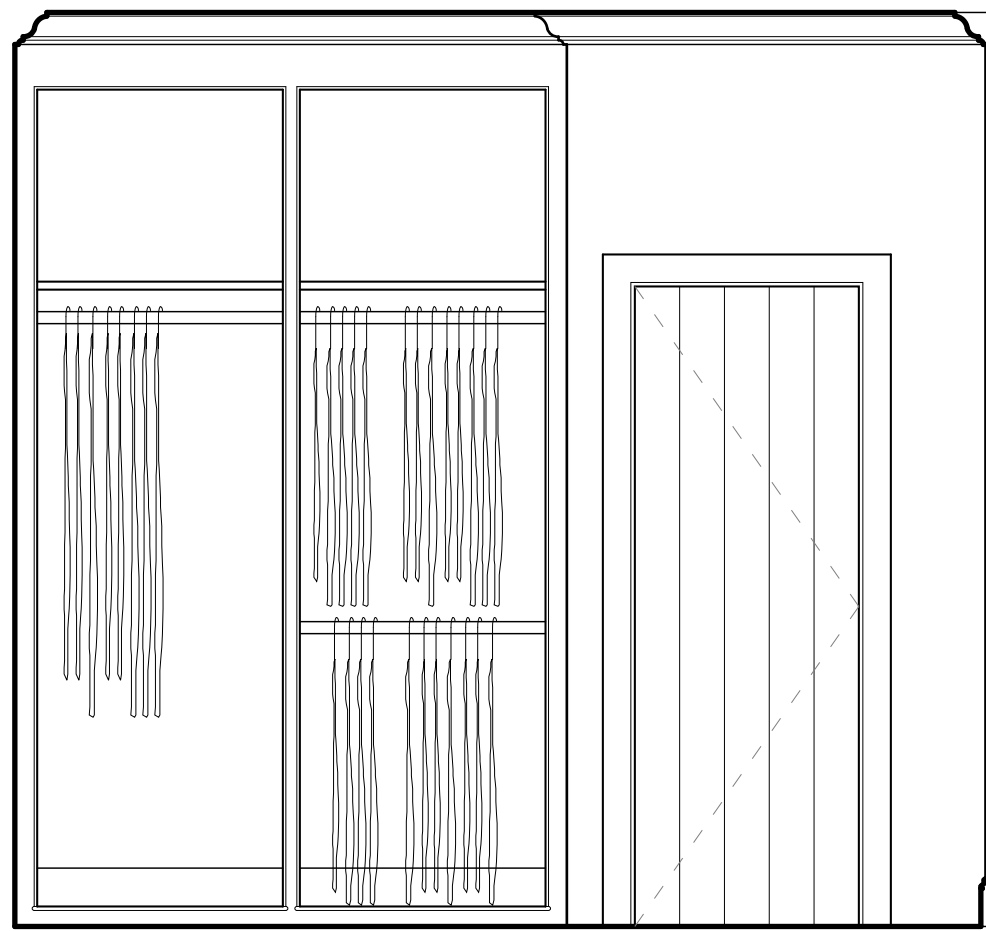

8 MASTER DRESSING
A405 SCALE: 1/4" = 1'-0"

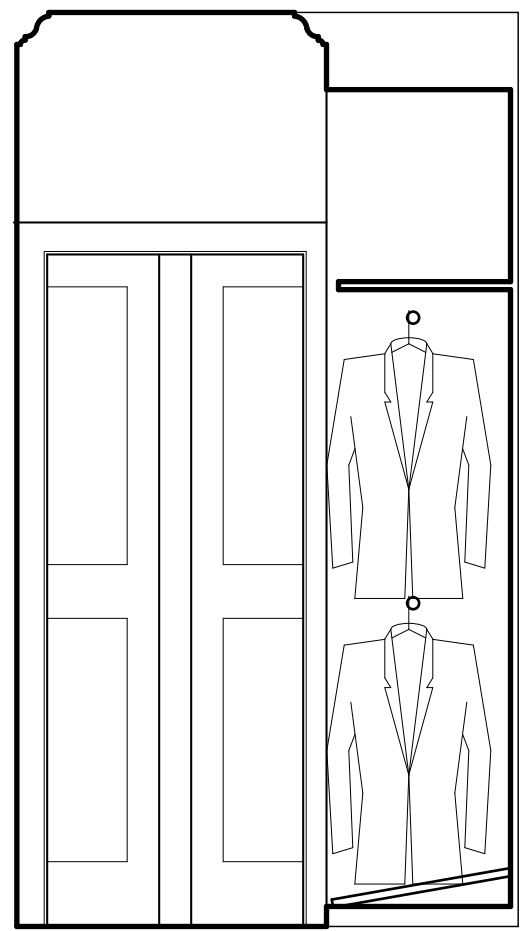


9 MASTER DRESSING
A405 SCALE: 1/4" = 1'-0"

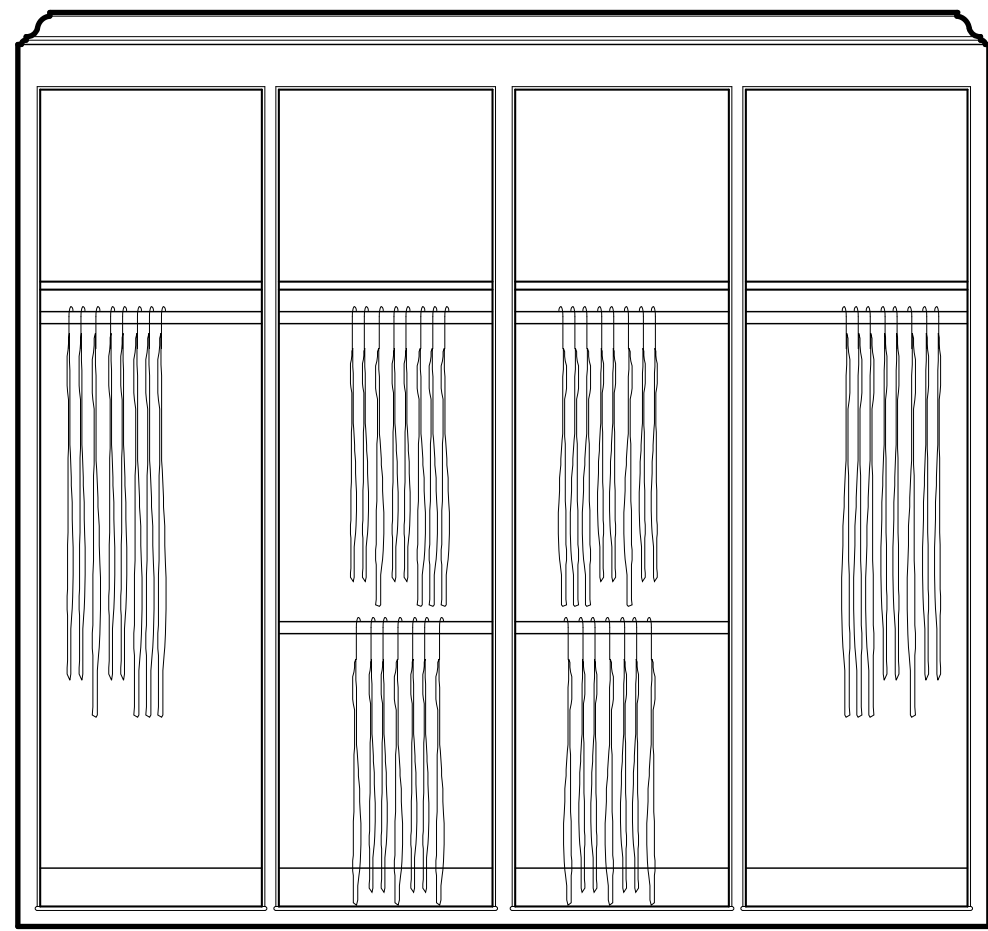

10 MASTER DRESSING
A405 SCALE: 1/4" = 1'-0"

Glenn Keyes
Architects

12 Vanderhorst Street
Charleston, SC 29403
(843) 722-4100
www.glennkeyesarchitects.com

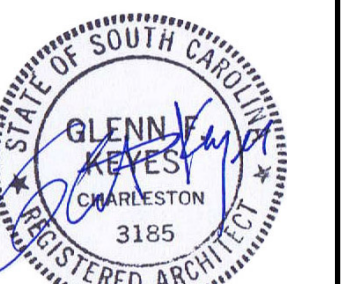

79 Anson Street
The Edward Mortimer House
c.1806
Charleston, South Carolina


INTERIOR ELEVATIONS

REV.	DATE


PROJECT NUMBER 1705

DRAWING DATE 8/30/17

SHEET NUMBER A405

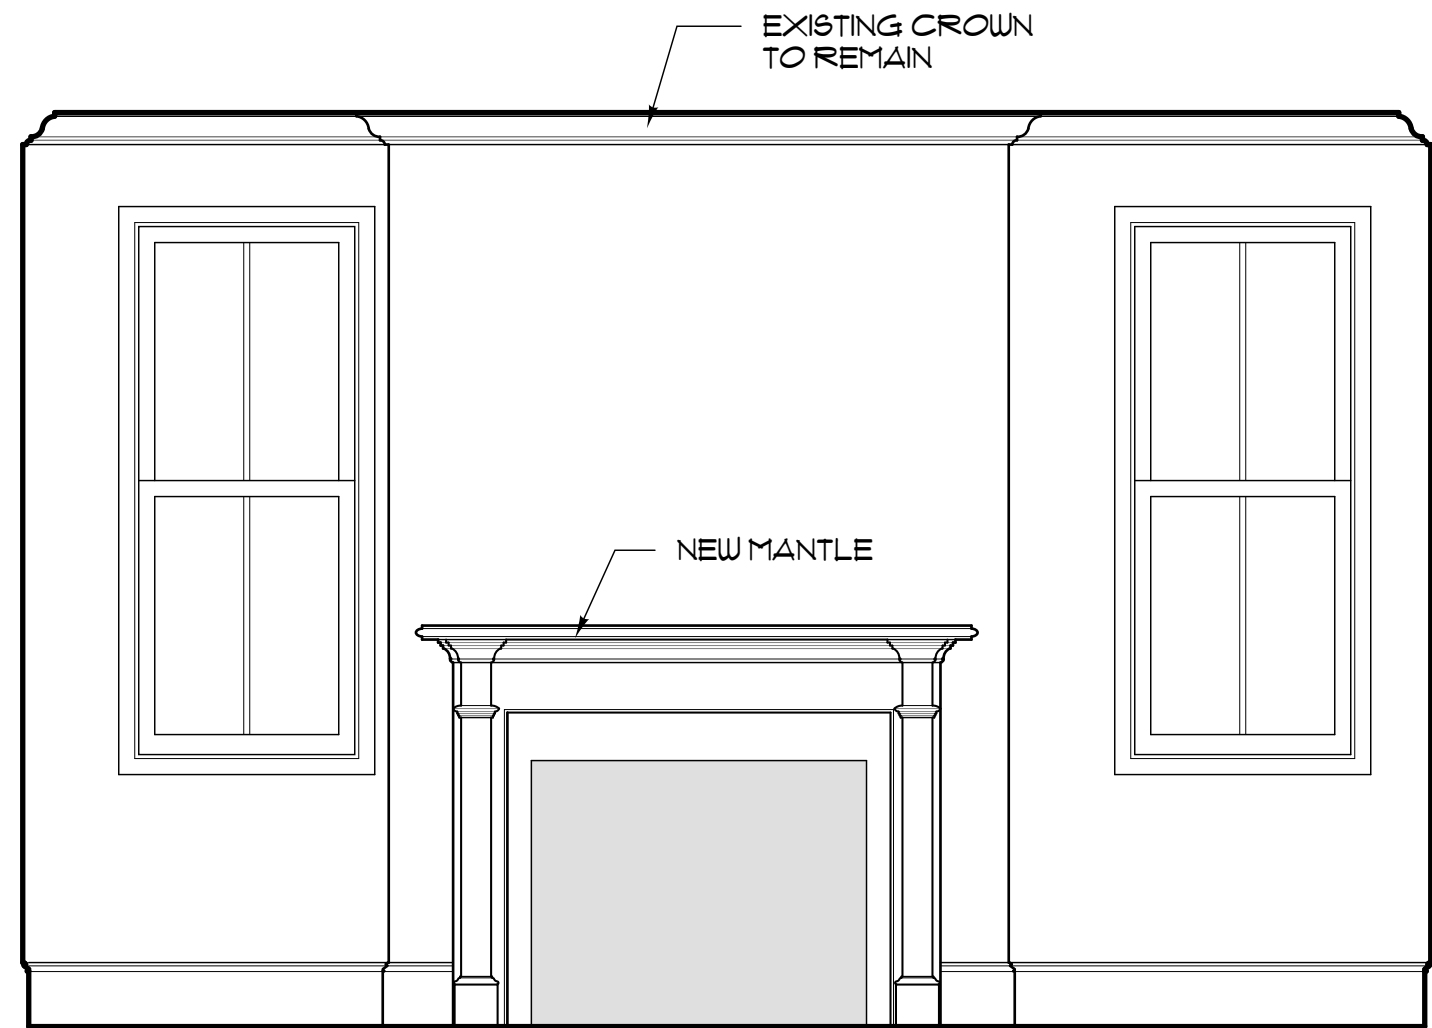

1
MASTER BEDROOM
SCALE: 1/4" = 1'-0"

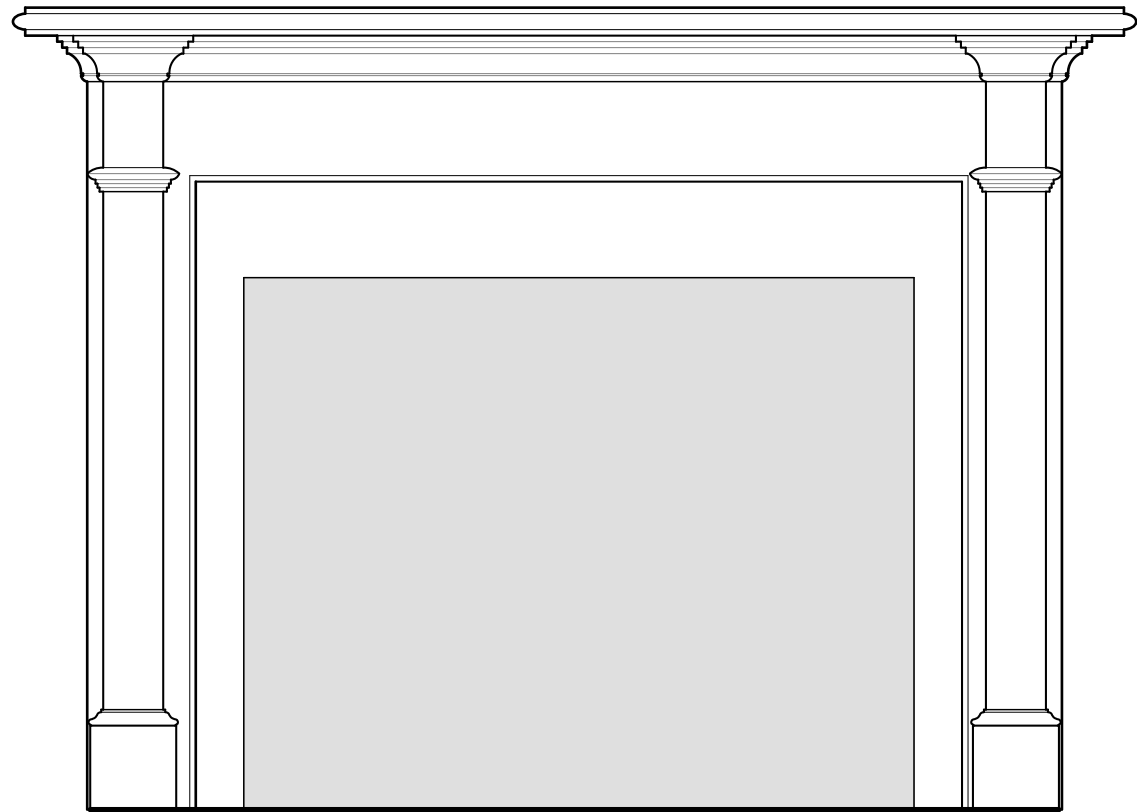

2
MASTER BEDROOM MANTLE
SCALE: 1/2" = 1'-0"

Glenn Keyes
Architects

12 Vanderhorst Street
Charleston, SC 29403
(843) 722-4100
www.glennkeyesarchitects.com

STATE OF SOUTH CAROLINA
GLENN KEYES
CHARLESTON
REGISTERED ARCHITECT
3185




STATE OF SOUTH CAROLINA
GLENN KEYES
ARCHITECTS, LLC
02083
CHARLESTON
REGISTERED ARCHITECT

79 Anson Street
The Edward Mortimer House
c.1806
Charleston, South Carolina

INTERIOR ELEVATIONS

REV.	DATE

PROJECT NUMBER	1705
DRAWING DATE	8/30/17
SHEET NUMBER	A406

  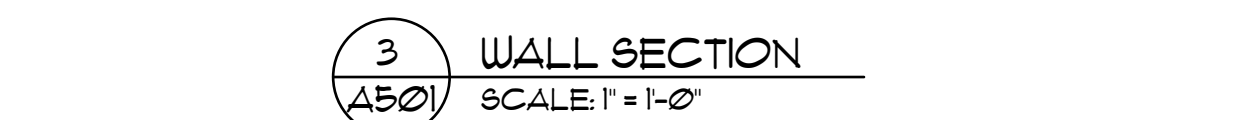

MORTAR SHALL BE TYPE S AND SHALL BE MADE USING A PORTLAND CEMENT/LIME MIX. MASONRY CEMENT SHALL NOT BE USED.




SHEET NUMBER

12 Vanderhorst Street
Charleston, SC 29403
(843) 722-4100
www.glennekevesarchitects.com

DESIGN CRITERIA: 2006 IBC
ROOF LIVE LOAD 20 PSF
FLOOR LIVE LOAD 40 PSF
WIND LOADS ASCE 7-10
150 MPH
EXPOSURE B
ENCLOSED BUILDING
q_{BASIC} = 34 PSF ULT (21 PSF ASD)

GEOTECHNICAL RECOMMENDATIONS ARE BY SOIL CONSULTANTS INC.
REPORT NO. 130044, DATED JUNE 18, 2013. MAXIMUM ALLOWABLE SOIL
BEARING PRESSURE = 1500 PSF AFTER SOIL REMEDIATION.



- 3 WALL SECTION
A502 SCALE: 1" = 1'-0"

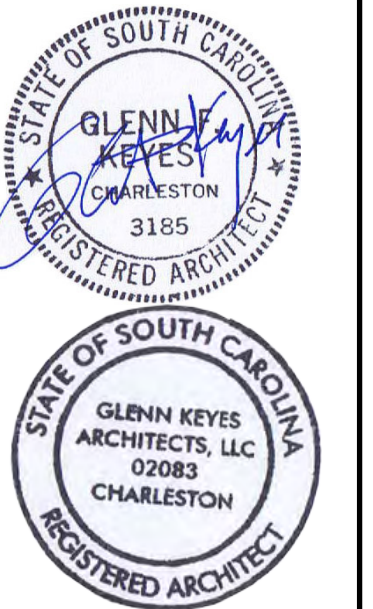

79 Anson Street
The Edward Mortimer House
c.1806
Charleston, South Carolina

DETAILS

A502

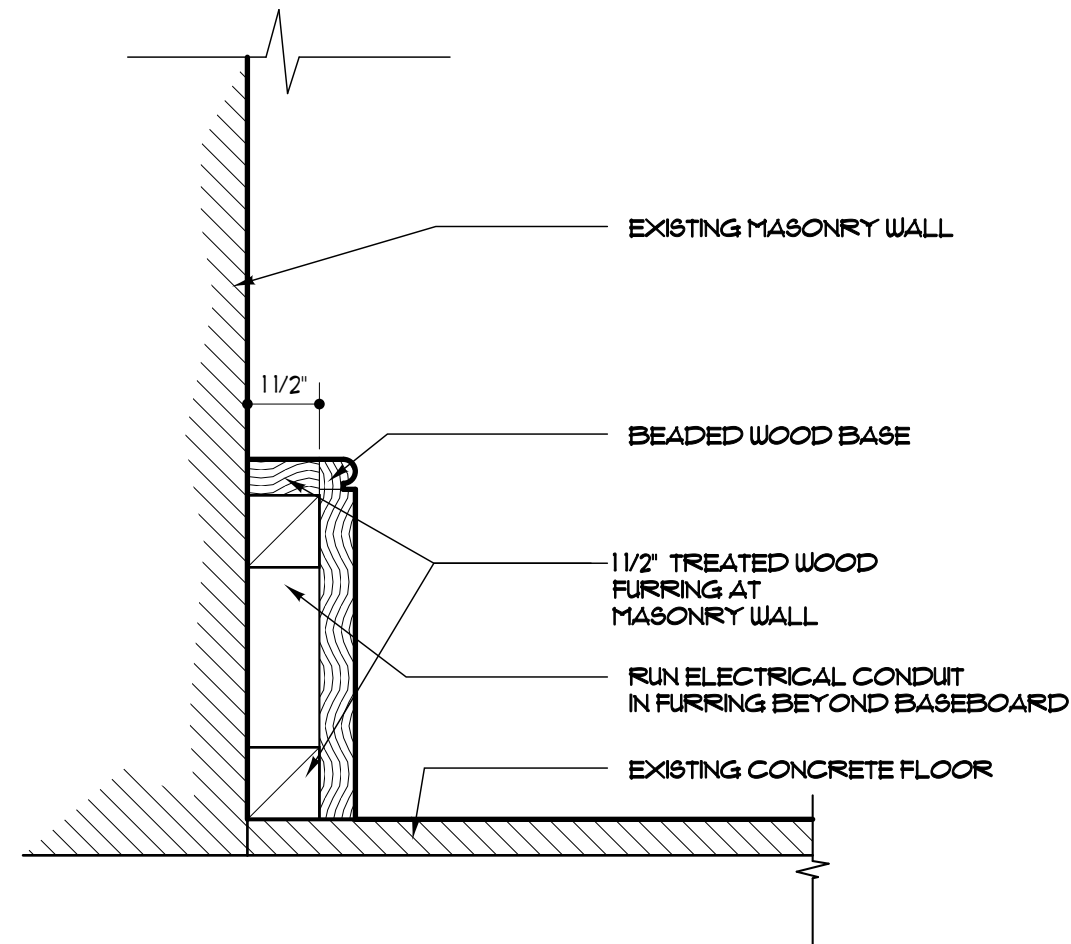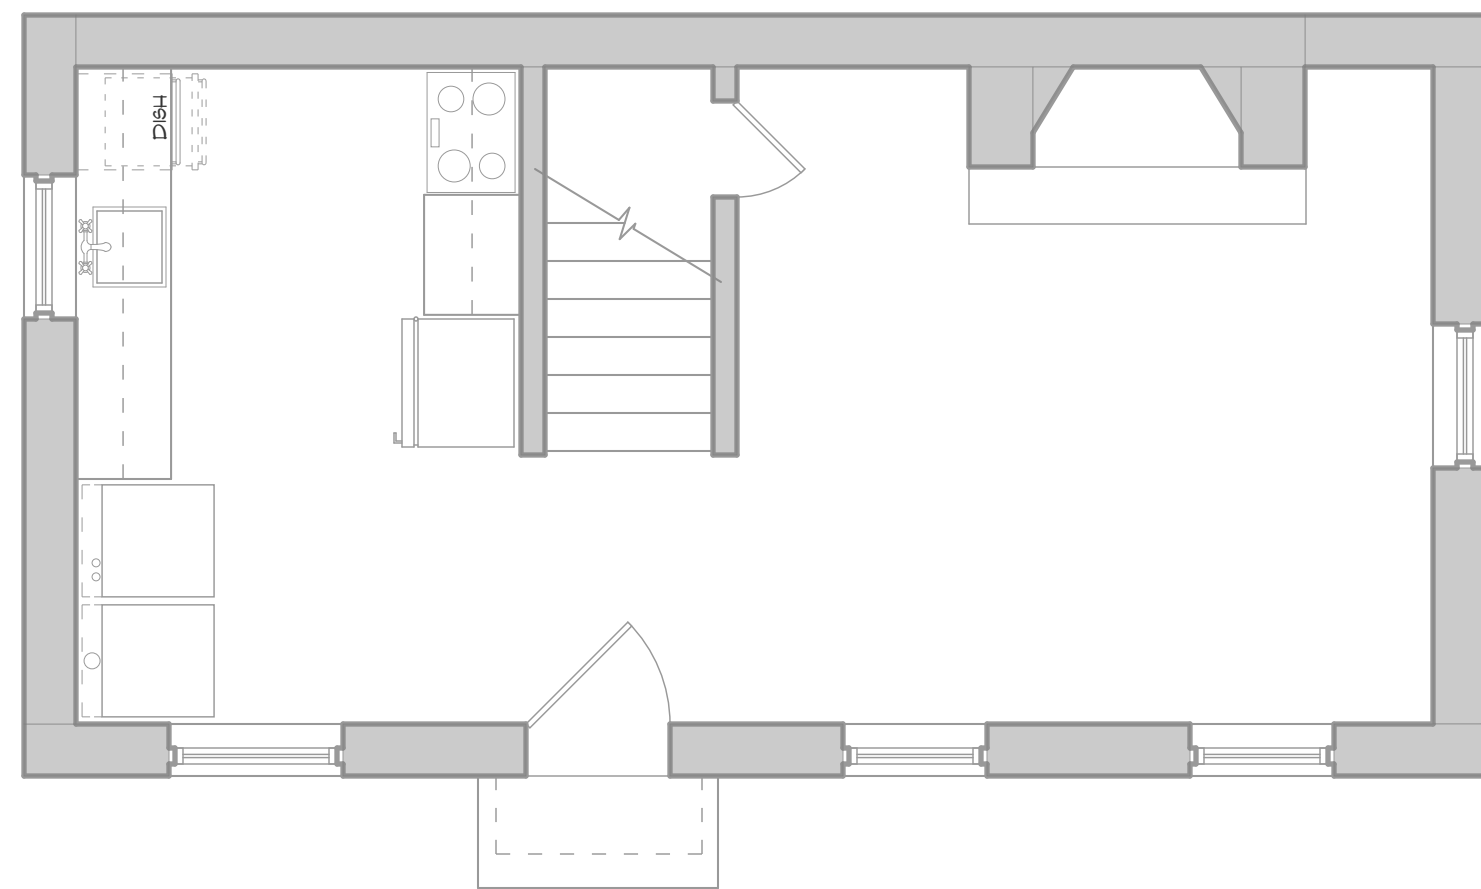


2 THICKENED BASEBOARD DETAIL
E100 SCALE: 3" = 1" - Ø"

- ### ELECTRICAL SYMBOLS
- | | |
|---|--|
|  | SWITCH |
|  | DIMMER SWITCH |
|  | RECESSED FIXTURE |
|  | PUCK LIGHT |
|  | PENDANT LIGHT |
|  | SURFACE MTD. FIXTURE |
|  | SPOTLIGHT |
|  | WALL SCONCE |
|  | NEW DEVICE/ EXISTING LOCATION |
|  | CHANDELIER |
|  | UNDERCABINET LIGHTING |
|  | OUTLET (APPLIANCE) |
|  | SEE MFR'S REQUIREMENTS |
|  | OUTLET |
|  | EXISTING OUTLET TO REMAIN |
|  | OUTLET @ COUNTER HEIGHT |
|  | FLOOR OUTLET |
|  | PICTURE OUTLET |
| | NOTE: PICTURE OUTLET @ FIREPLACE
TO BE 24" ABOVE MANTLE |
|  | EXHAUST FAN |
|  | TELEPHONE |
|  | CEILING FAN |

NOTE:
-REMOVE ALL SURFACE MOUNTED CONDUIT
-OUTLETS TO BE IN NEW THICKENED BASEBOARD,
SEE DETAIL

**Glenn Keyes
Architects**


12 Vandermorist Street
Charleston, SC 29403
(843) 722-4100
www.glenkeyesarchitects.com

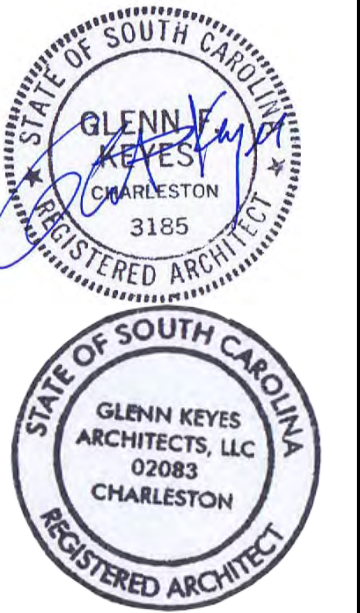


79 Anson Street
The Edward Mortimer House
c.1806
Charleston, South Carolina

PROPOSED ELECTRICAL PLANS

REV.	DATE
PROJECT NUMBER	
1705	
DRAWING DATE	
9/25/17	
SHEET NUMBER	
E100	

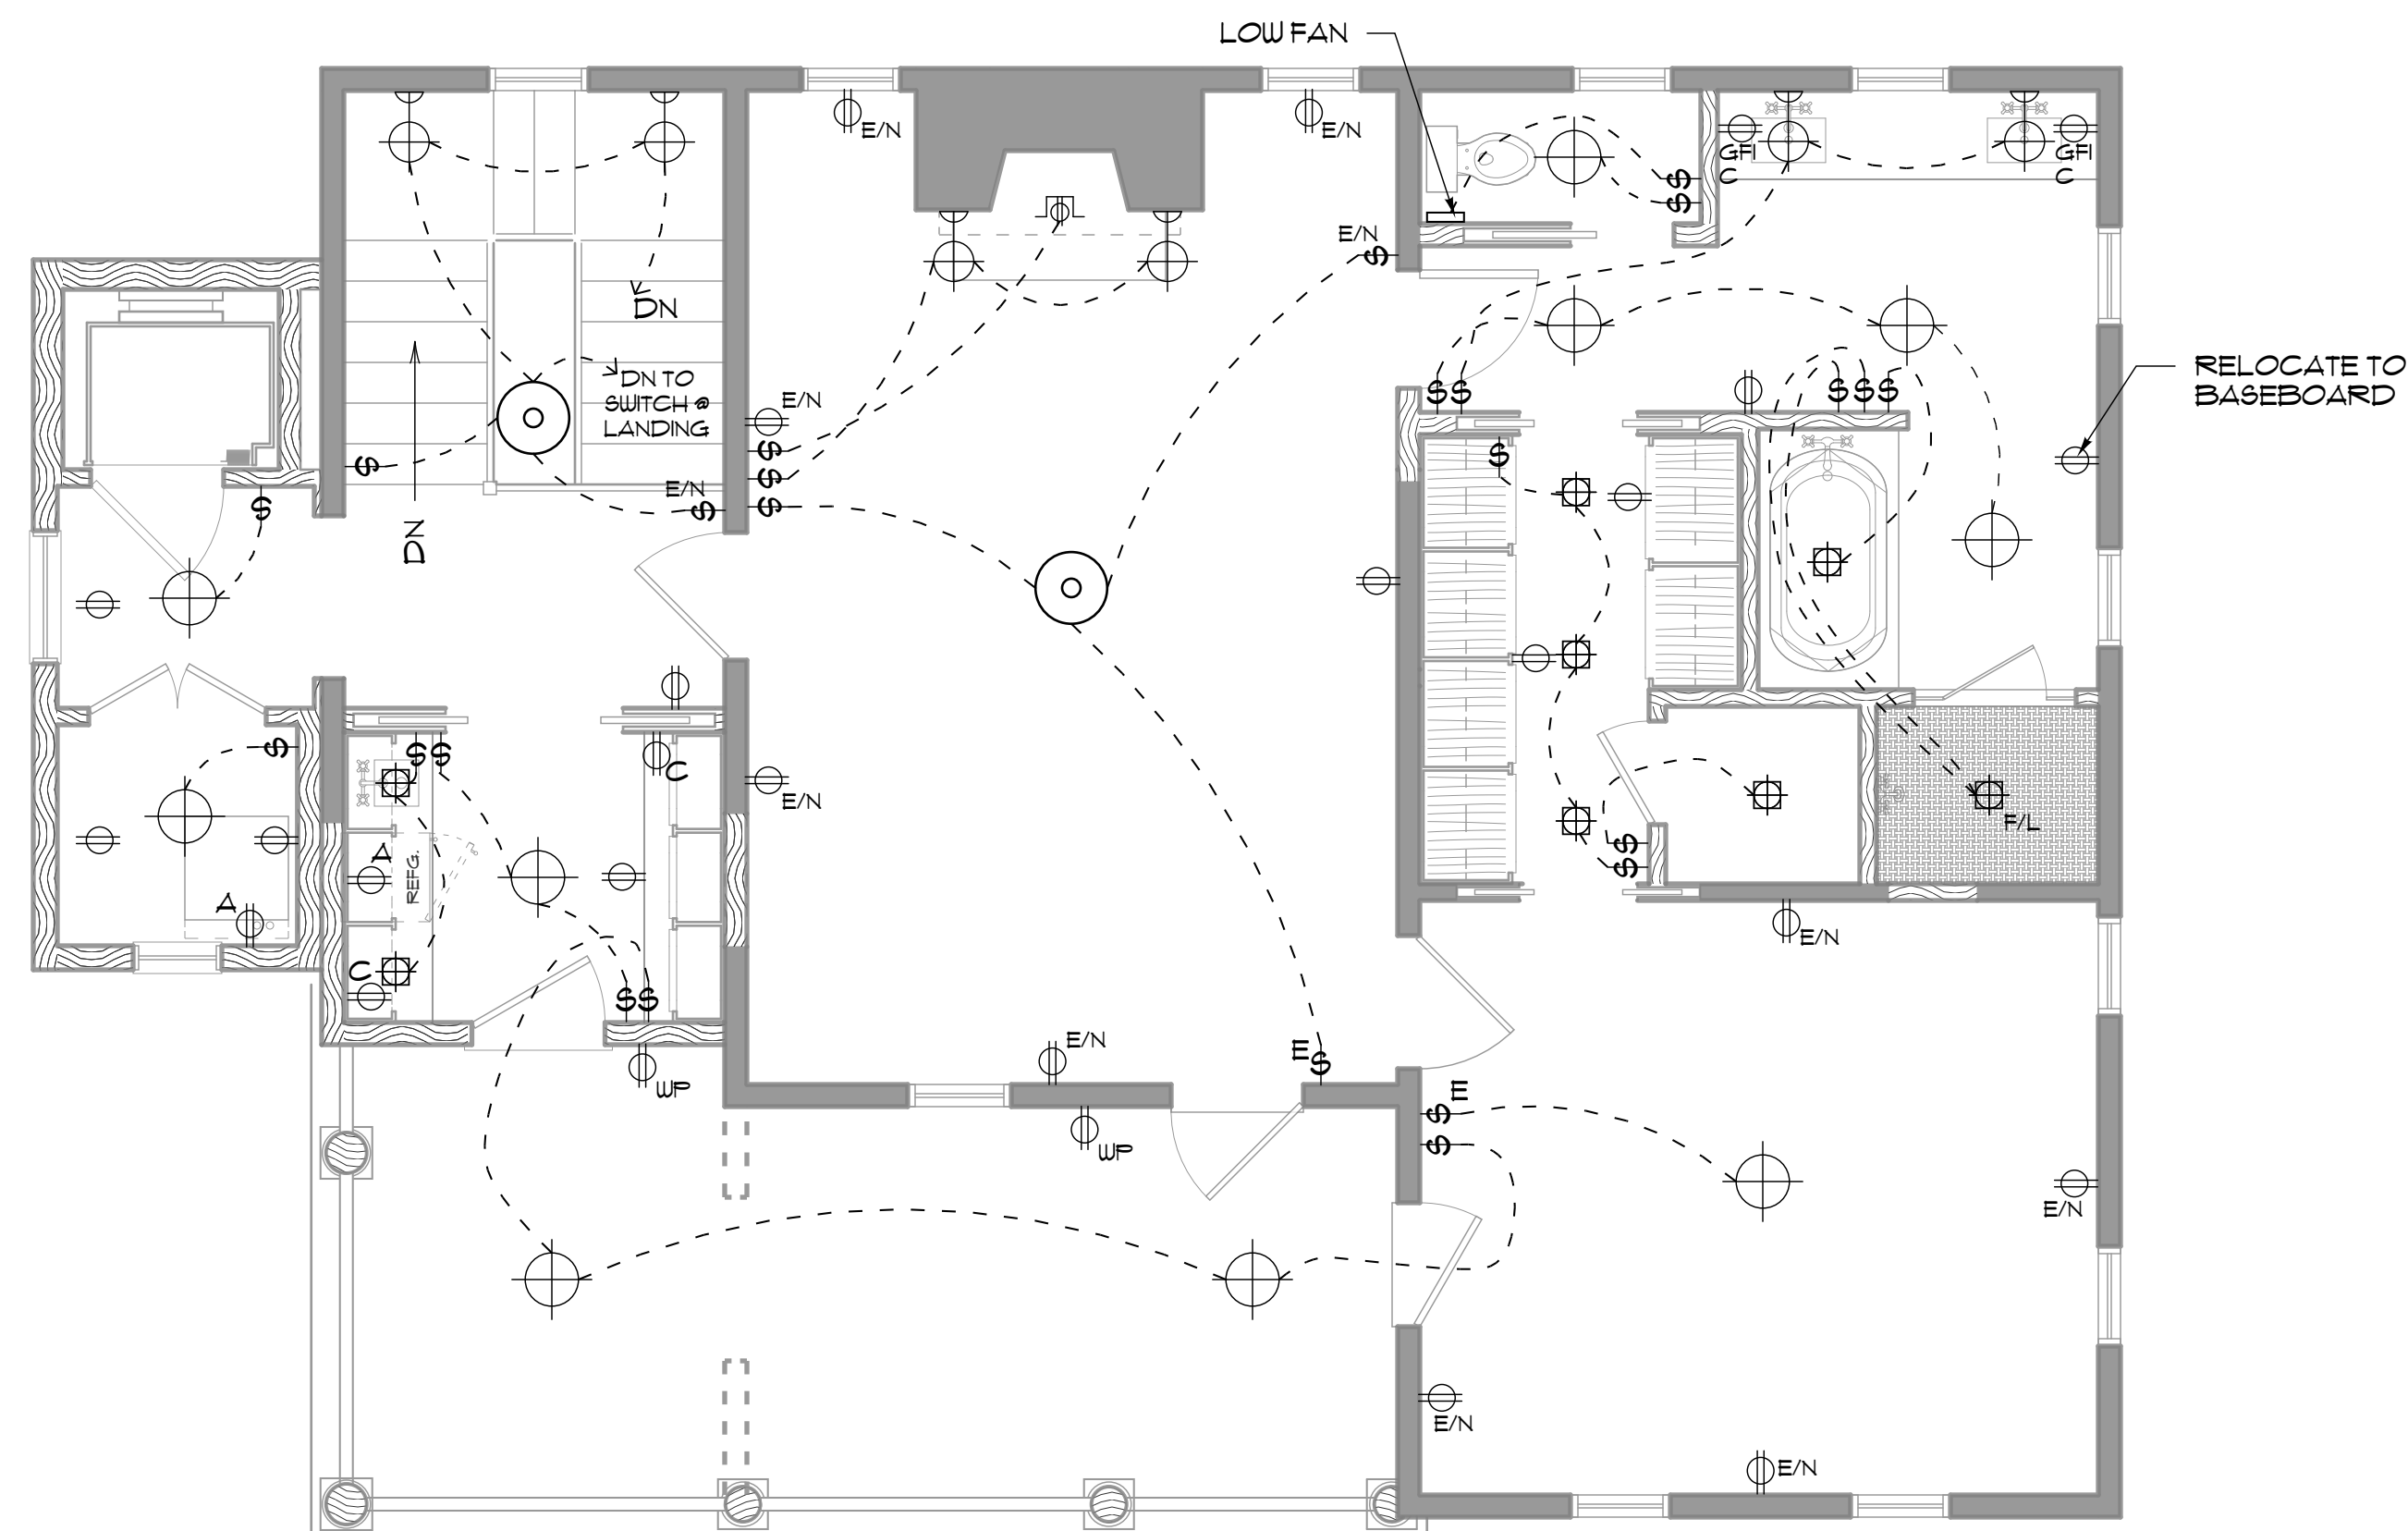

2 SECOND FLOOR ELECTRICAL PLAN
E101 SCALE: 1/4" = 1'-0"

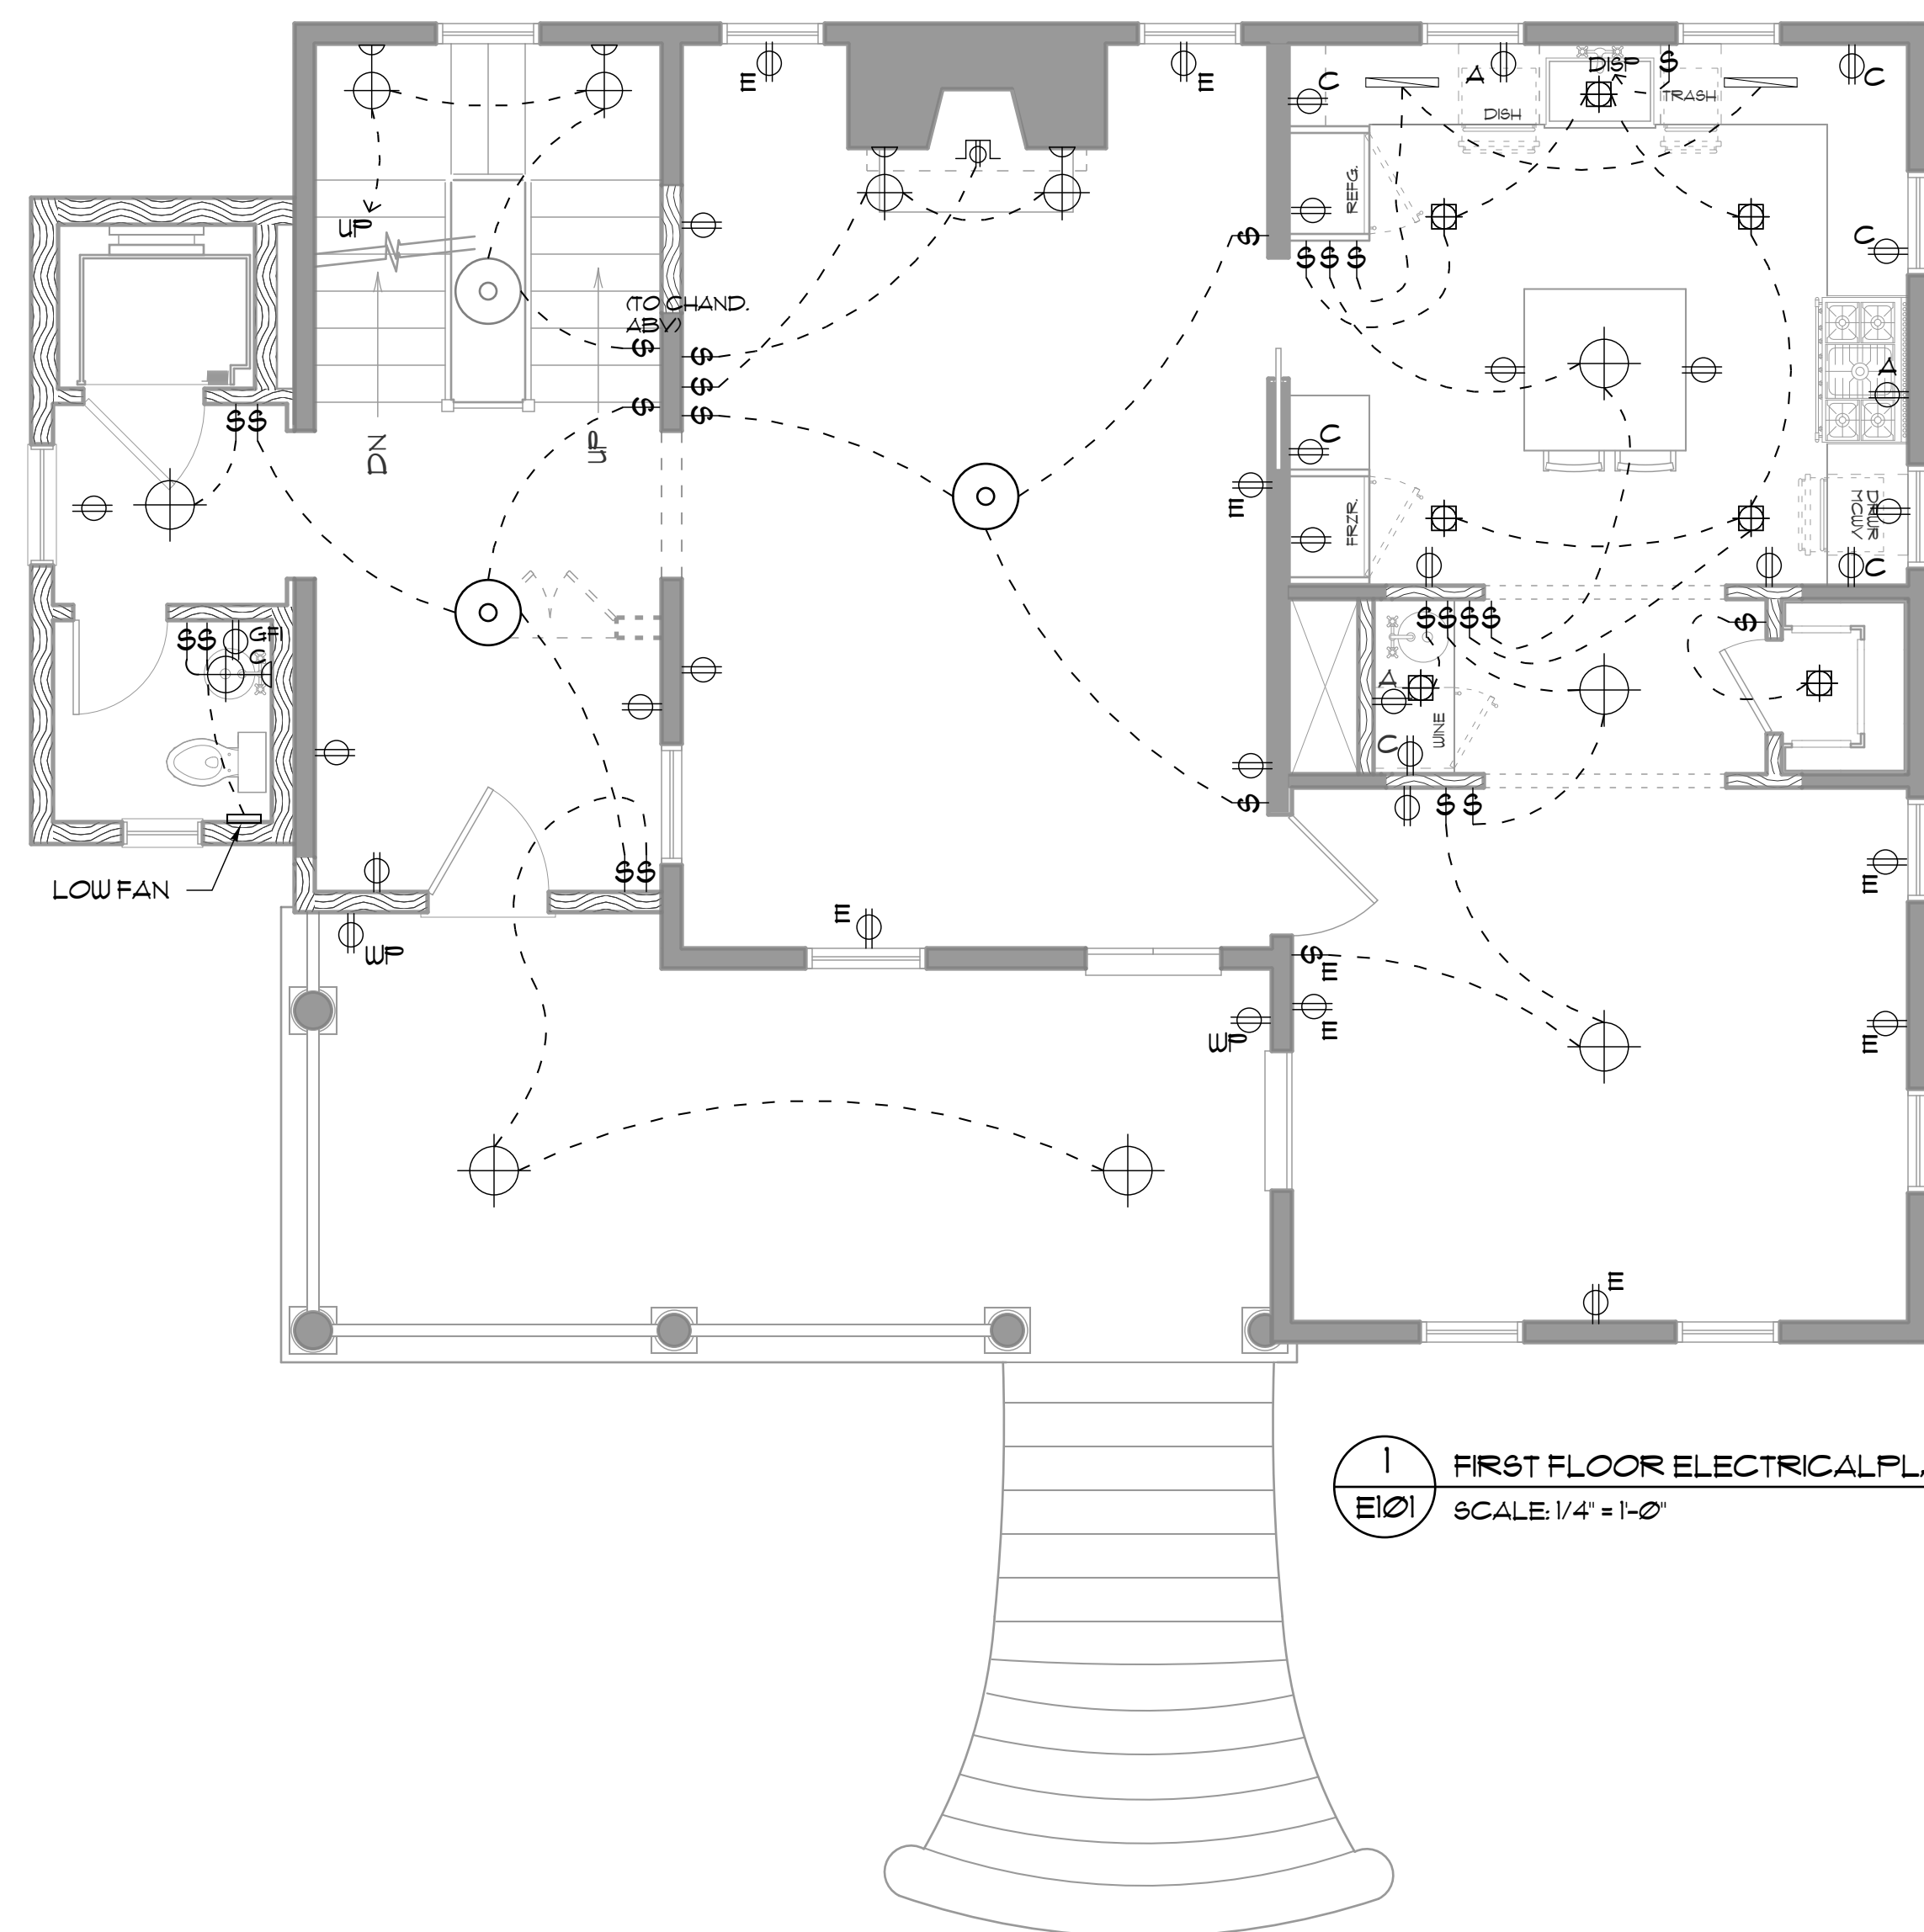

1 FIRST FLOOR ELECTRICAL PLAN
E101 SCALE: 1/4" = 1'-0"


ELECTRICAL SYMBOLS

- | | | | |
|---|-----------------------|---|-------------------------------|
|  | SWITCH |  | OUTLET (APPLIANCE) |
|  | DIMMER SWITCH |  | SEE MFR'S REQUIREMENTS |
|  | RECESSED FIXTURE |  | OUTLET |
|  | PUCK LIGHT |  | EXISTING OUTLET TO REMAIN |
|  | PENDANT LIGHT |  | OUTLET @ COUNTER HEIGHT |
|  | SURFACE MTD. FIXTURE |  | FLOOR OUTLET |
|  | SPOTLIGHT |  | PICTURE OUTLET |
|  | WALL SCONCE |  | NEW DEVICE/ EXISTING LOCATION |
|  | CHANDELIER |  | EXHAUST FAN |
|  | UNDERCABINET LIGHTING |  | TELEPHONE |
| | |  | CEILING FAN |

NOTE:
ALL OUTLETS TO BE INSTALLED HORIZONTALLY
IN BASEBOARDS

**Glenn Keyes
Architects**

12 Vanderhorst Street
Charleston, SC 29403
(843) 722-4100
www.glenkeyesarchitects.com

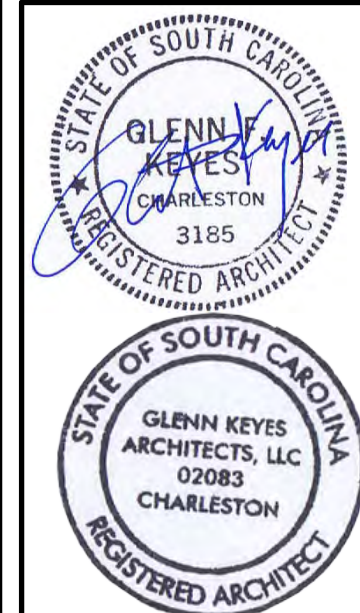

79 Anson Street
The Edward Mortimer House
c.1806
Charleston, South Carolina

PROPOSED ELECTRICAL PLANS

REV.	DATE
PROJECT NUMBER 1705	
DRAWING DATE 9/25/17	
SHEET NUMBER E101	