

Moore Residence

Lot 15 Wraggborough Square
Charleston, South Carolina


November 10, 1997

Drawing Index

- T1 Title Sheet, Site Plan
- A1 First Floor Plan
- A2 Second and Third Floor Plans, Window Details
- A3 Elevations, Building Sections
- A4 Elevations, Dormer & Fence Details
- A5 Wall Sections, Eave Details
- A6 Section Details
- A7 Schedules
- A8 Interior Elevations
- A9 Interior Elevations
- E1 First Floor Electrical Plan
- E2 Second and Third Floor Electrical Plans
- M1 First Floor Mechanical Layout
- M2 Second and Third Floor Mechanical Layouts
- S1 Foundation and First Floor Framing Plan
- S2 Second and Third Floor Framing Plan
- S3 Roof Framing Plan, Structural Details

Dufford / Young Architects

143 Wentworth Street
Charleston, SC 29401
803 577 0737

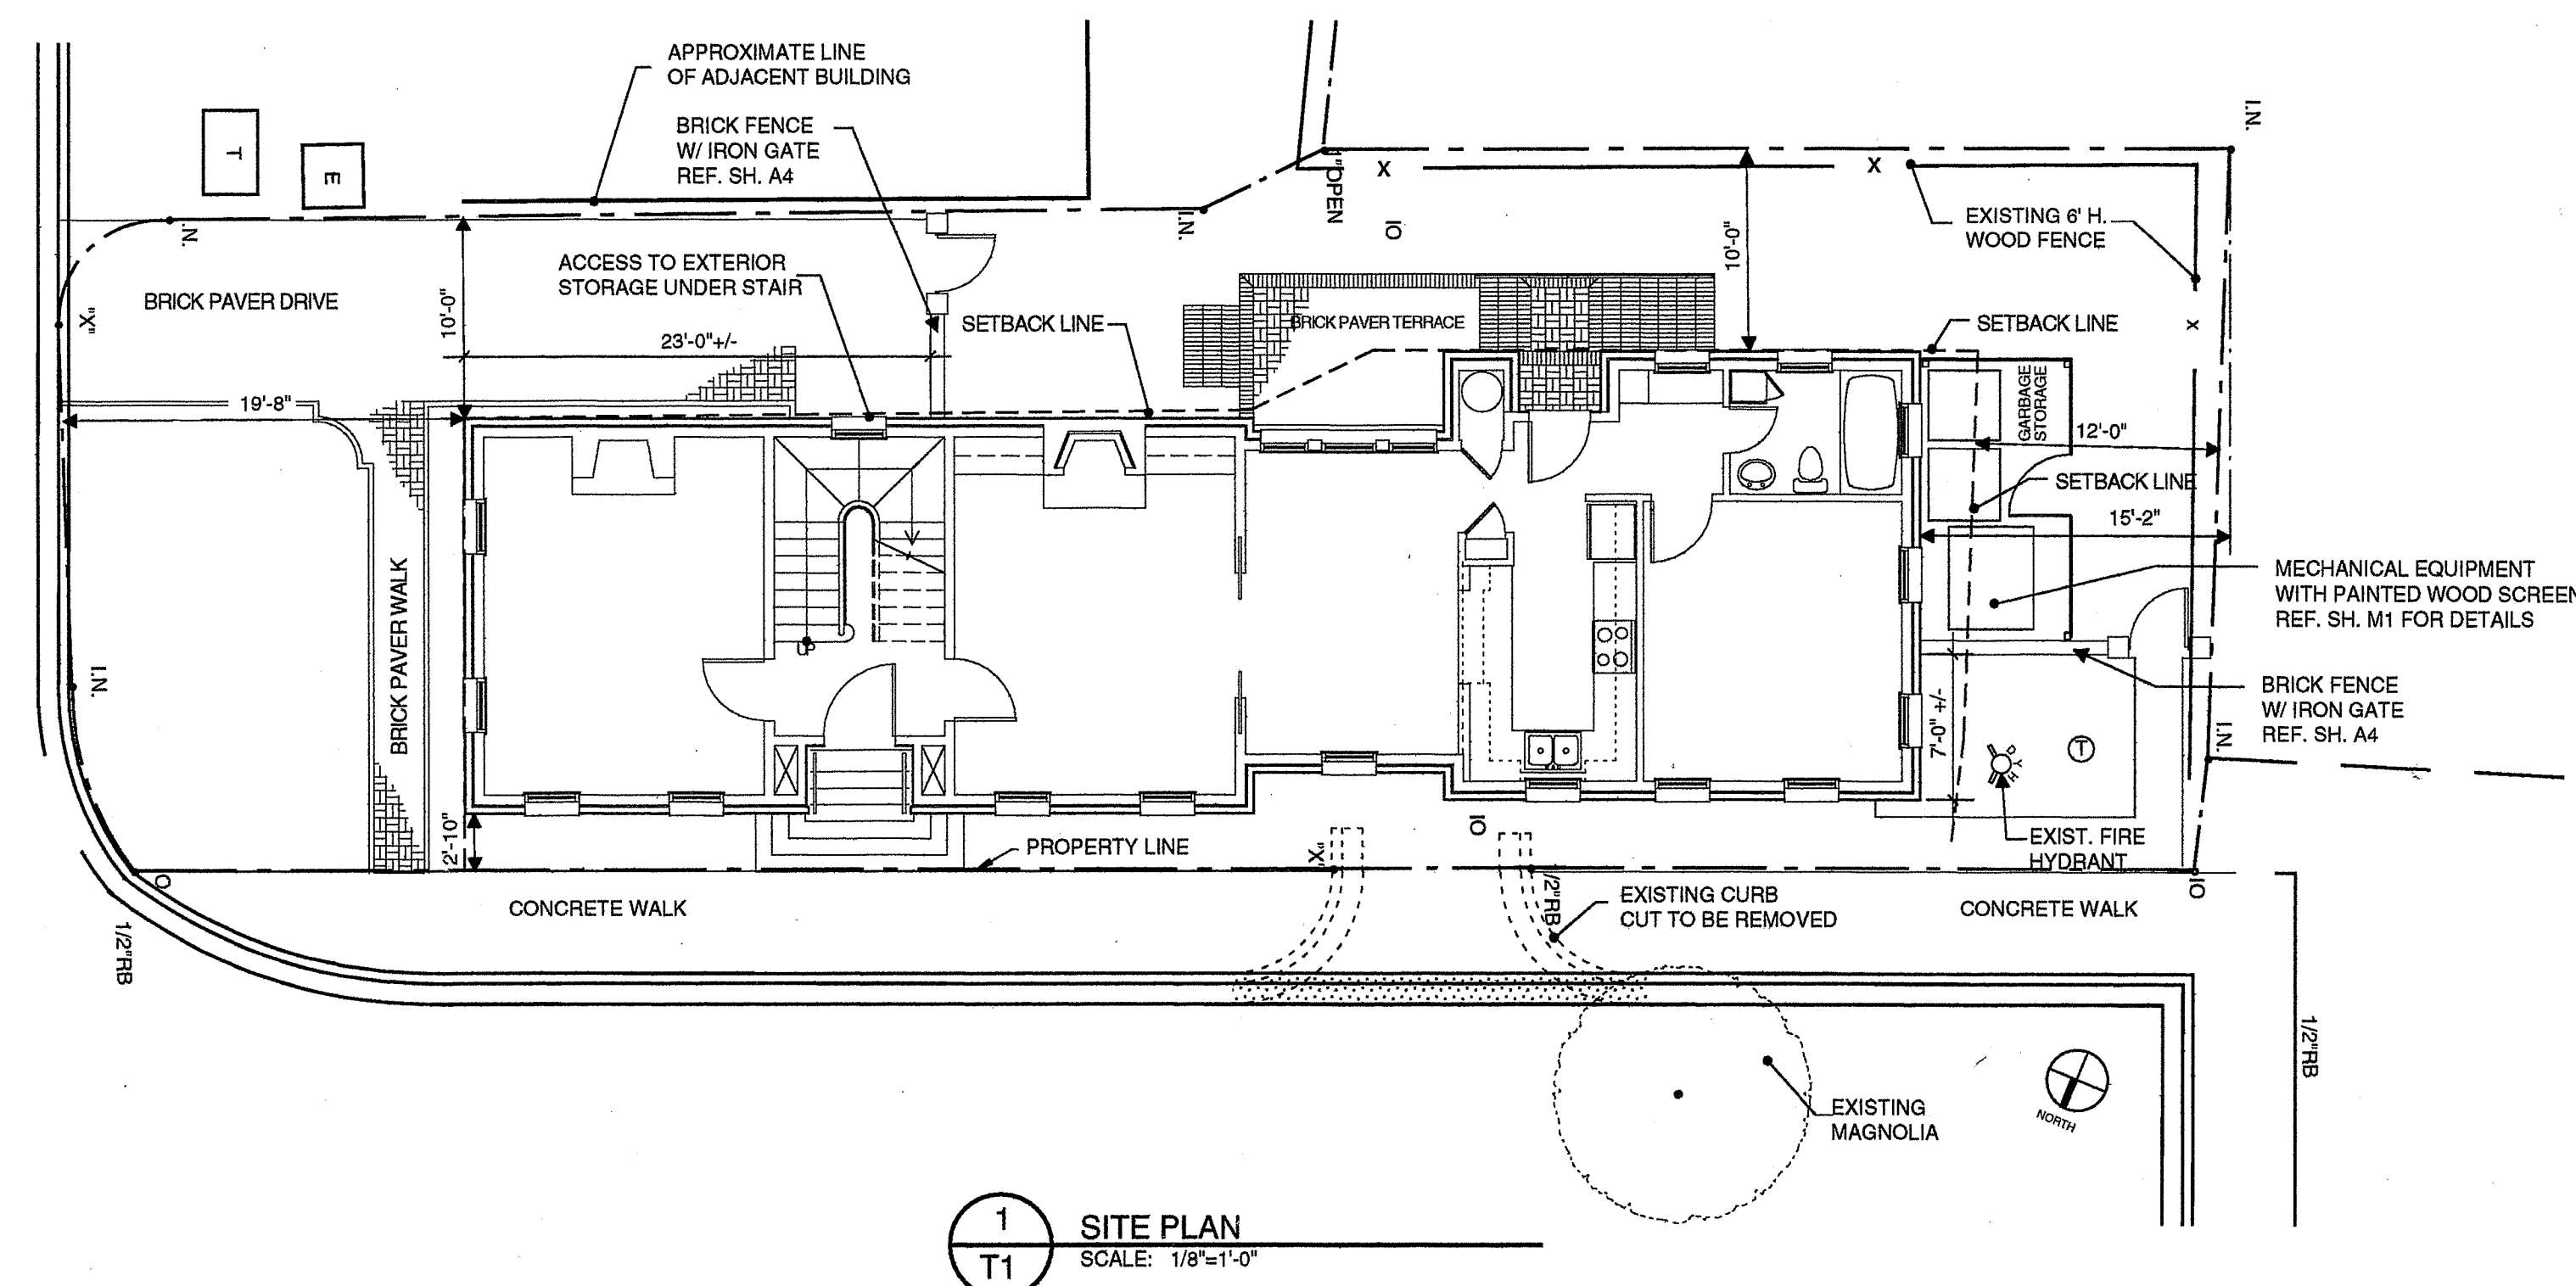

John L. Young Architect
Philip H. Dufford Architect

23 Coming Street
Charleston, SC 29401
803 577 0737

MOORE RESIDENCE
Wraggborough Square
Charleston, South Carolina

date
9/18/97

drawn
JLY/PHD

comm. no.


revisions

TITLE SHEET

T1

WRAGGLANE.015.2

Copyright © 1997
John L. Young, P.A.
in association with
Philip H. Dufford, P.A.
143 Wentworth Street
Charleston, S.C. 29401
803 577 0737
All rights reserved.
The reproduction or use
of this drawing or the
design herein without the
written consent of the
Architect is prohibited.
Architect waives all
responsibility and liability for
failure to follow these plans
and design their convey or
problems which arise from
other's failure to obtain and
follow the architect's
guidance with respect to any
inaccuracies, errors,
omissions, ambiguities or
conflicts which are alleged.

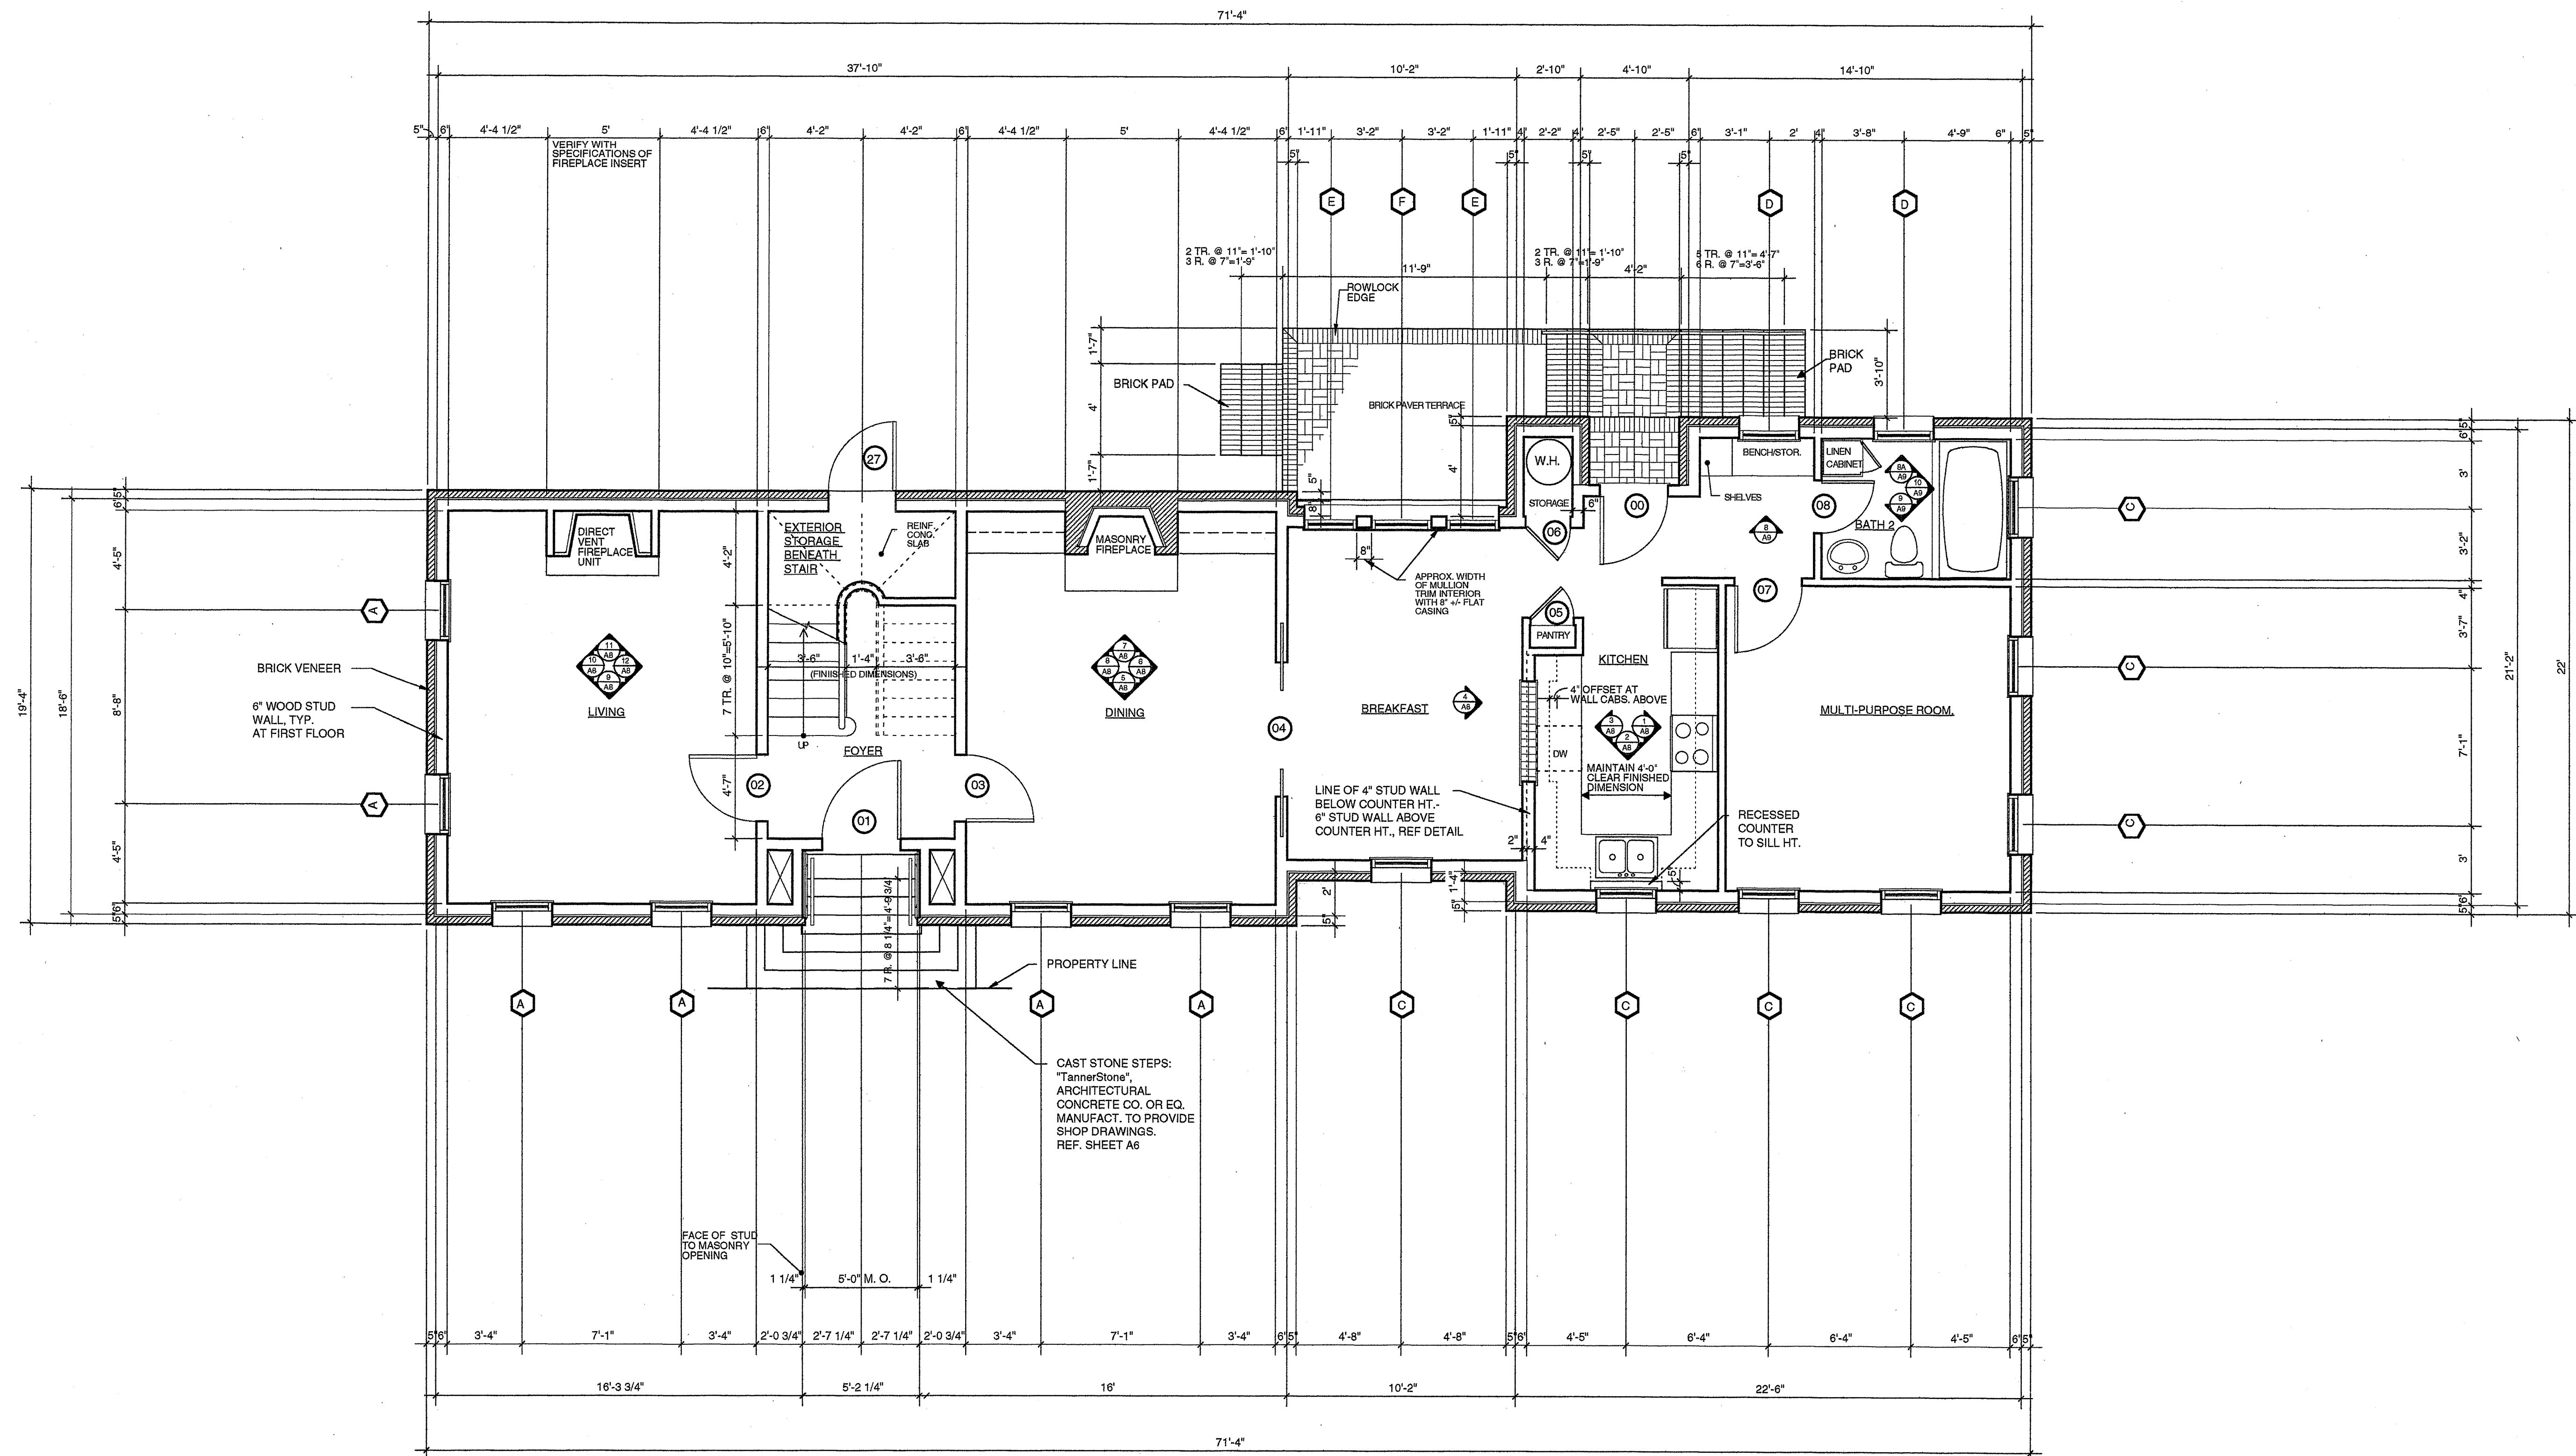

1 FIRST FLOOR PLAN
A1 SCALE: 1/4"=1'-0"




Dufford / Young Architects

143 Wentworth Street
Charleston, SC 29401
803 577 0737

MOORE RESIDENCE
Wraggborough Square
Charleston, South Carolina

date
11/10/97
drawn
JLY/PHD
comm. no.
revisions

FIRST FLOOR PLAN A1

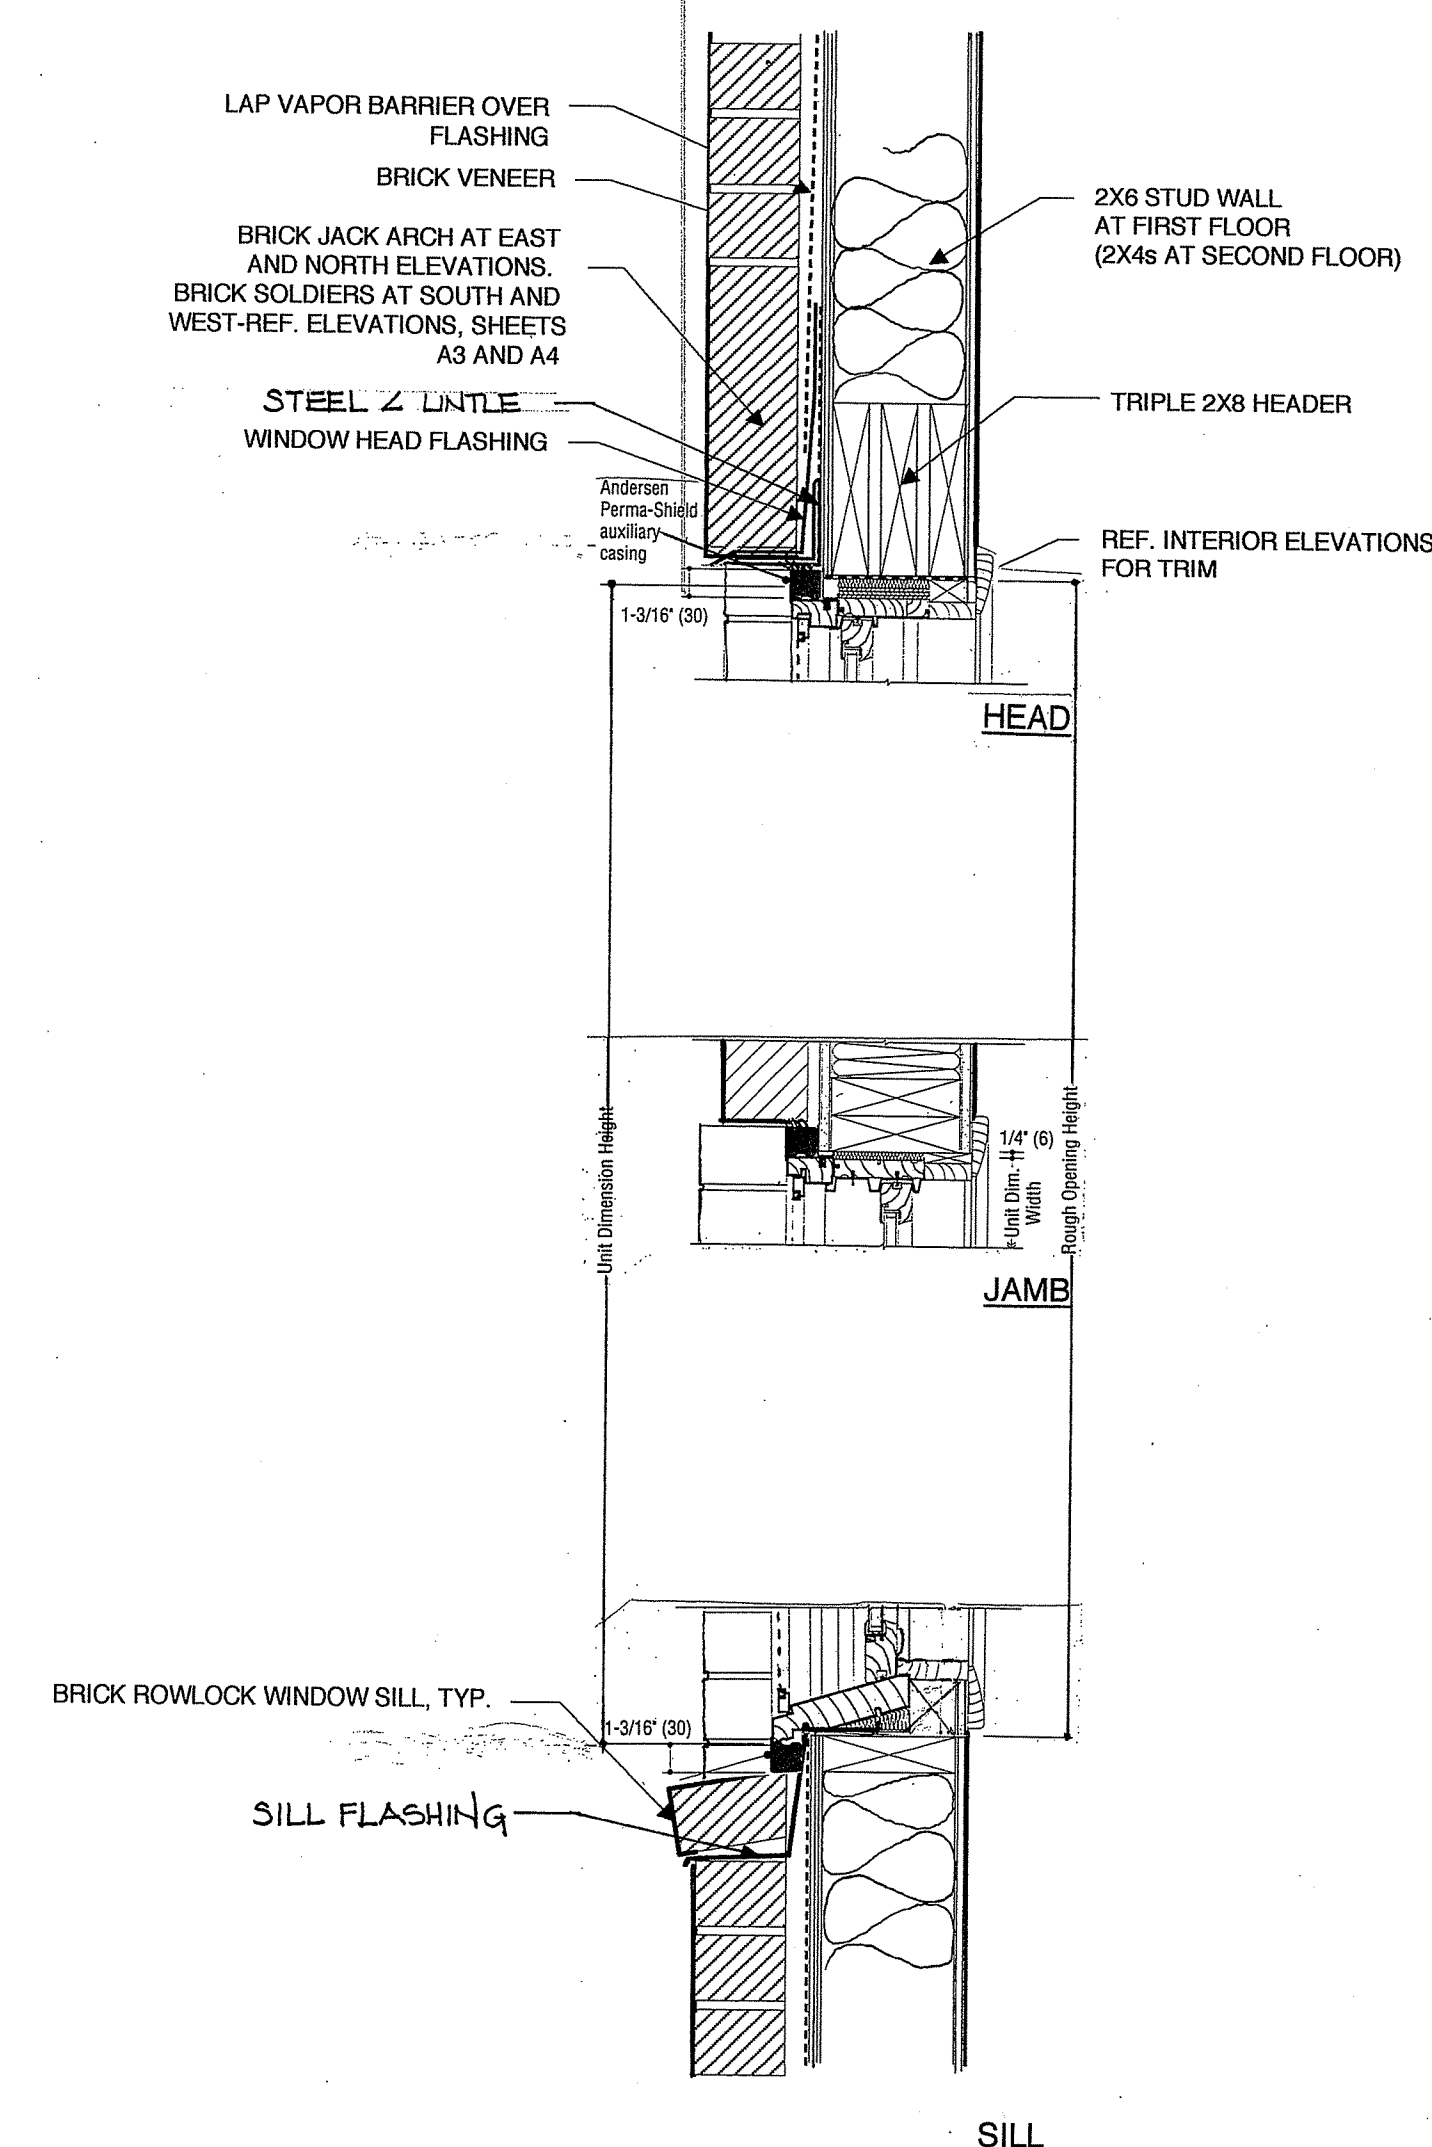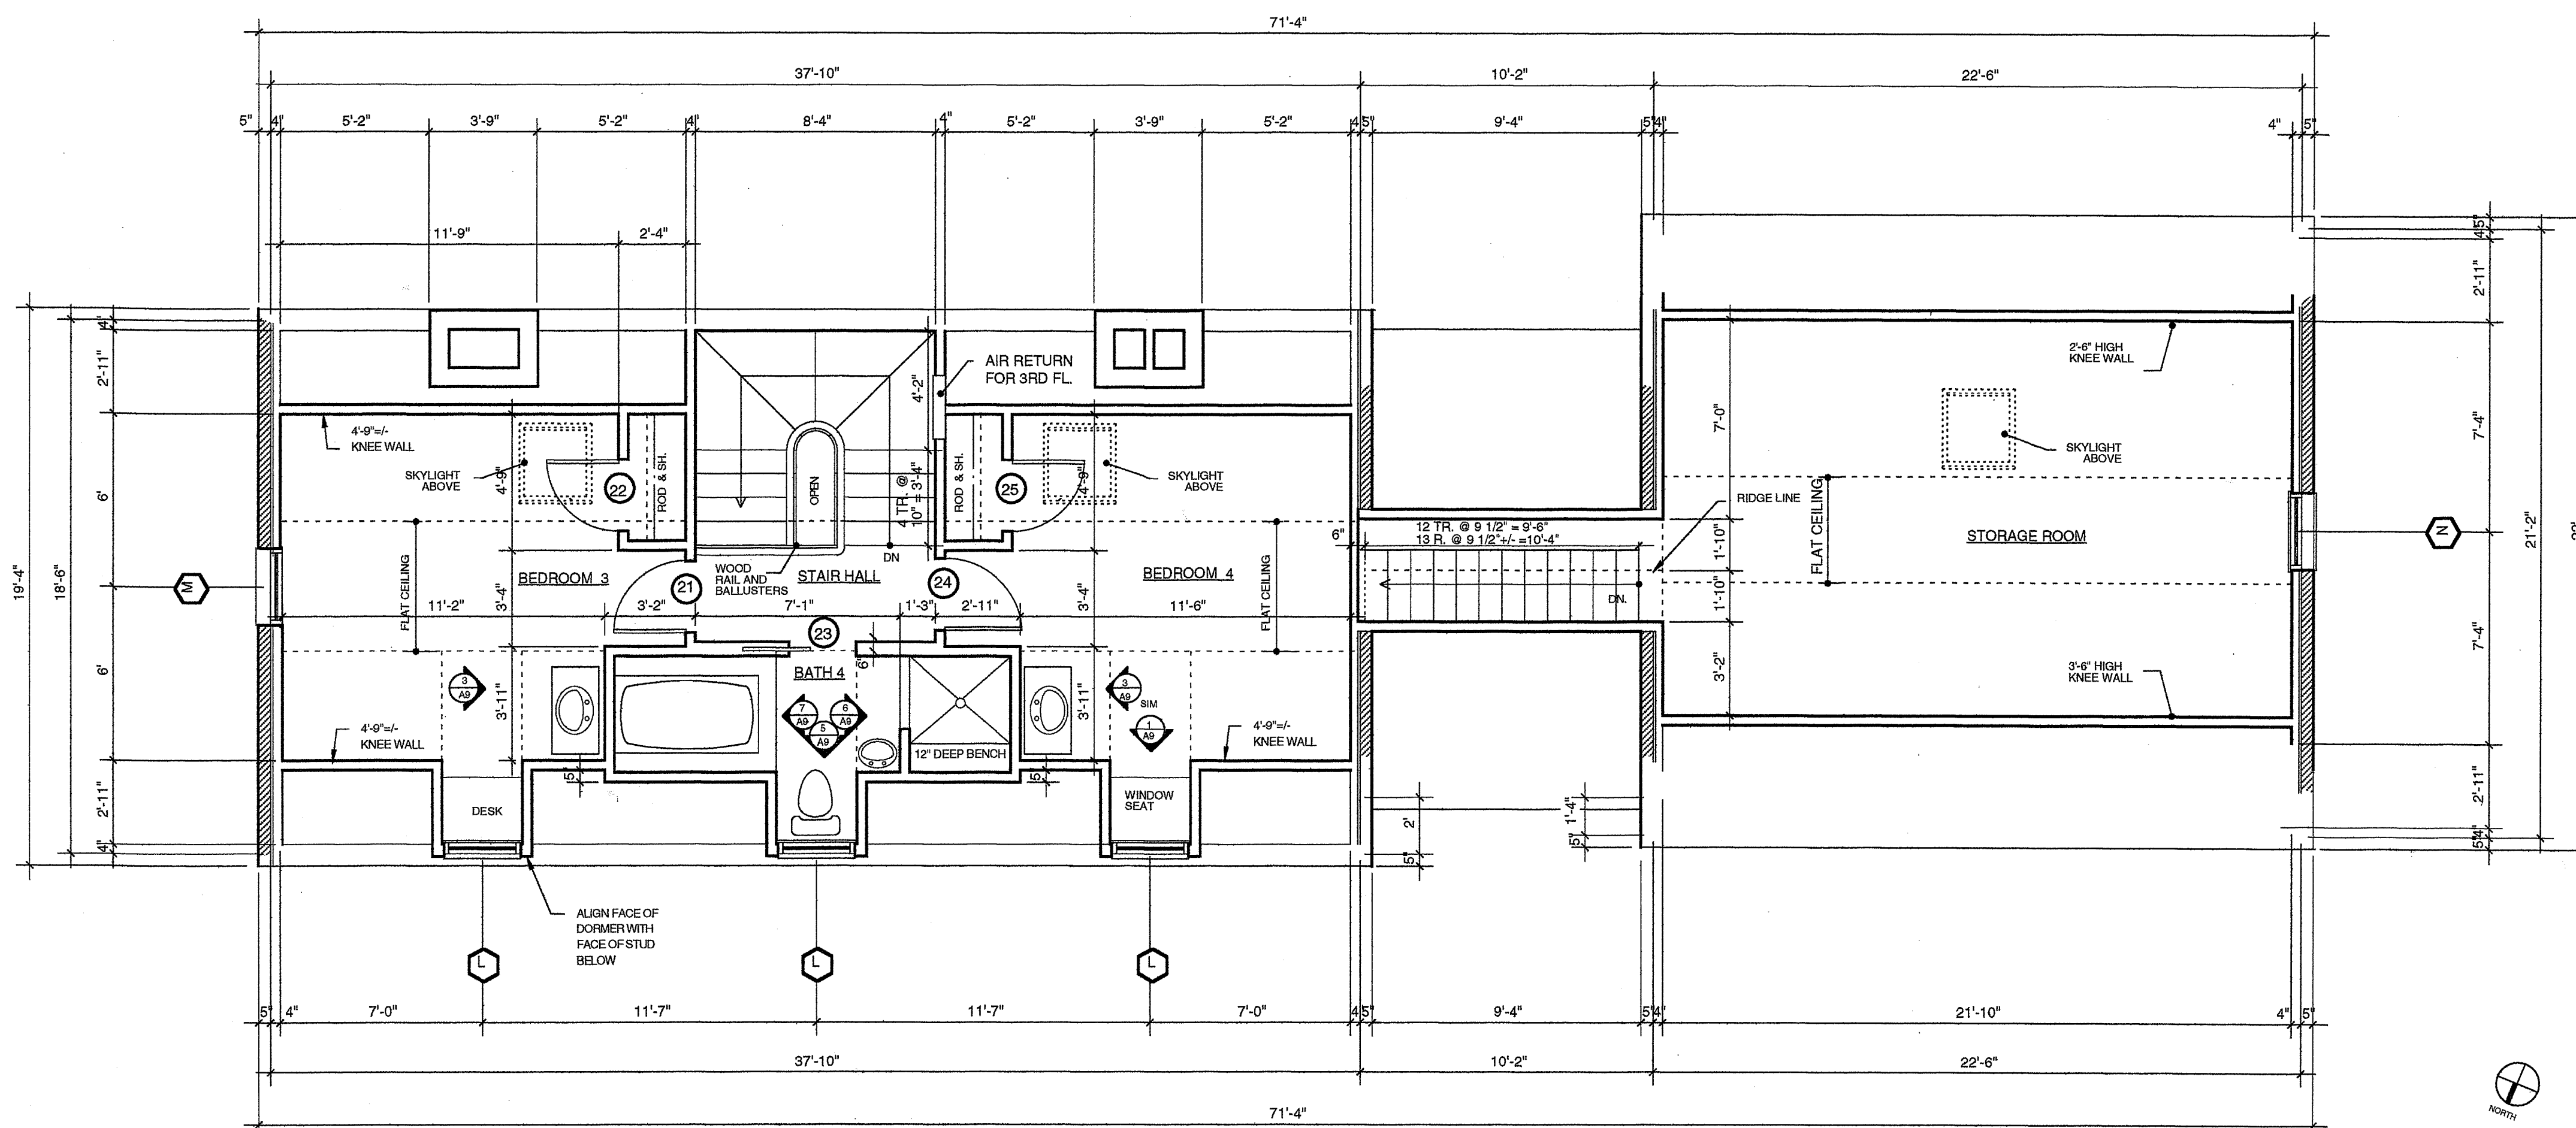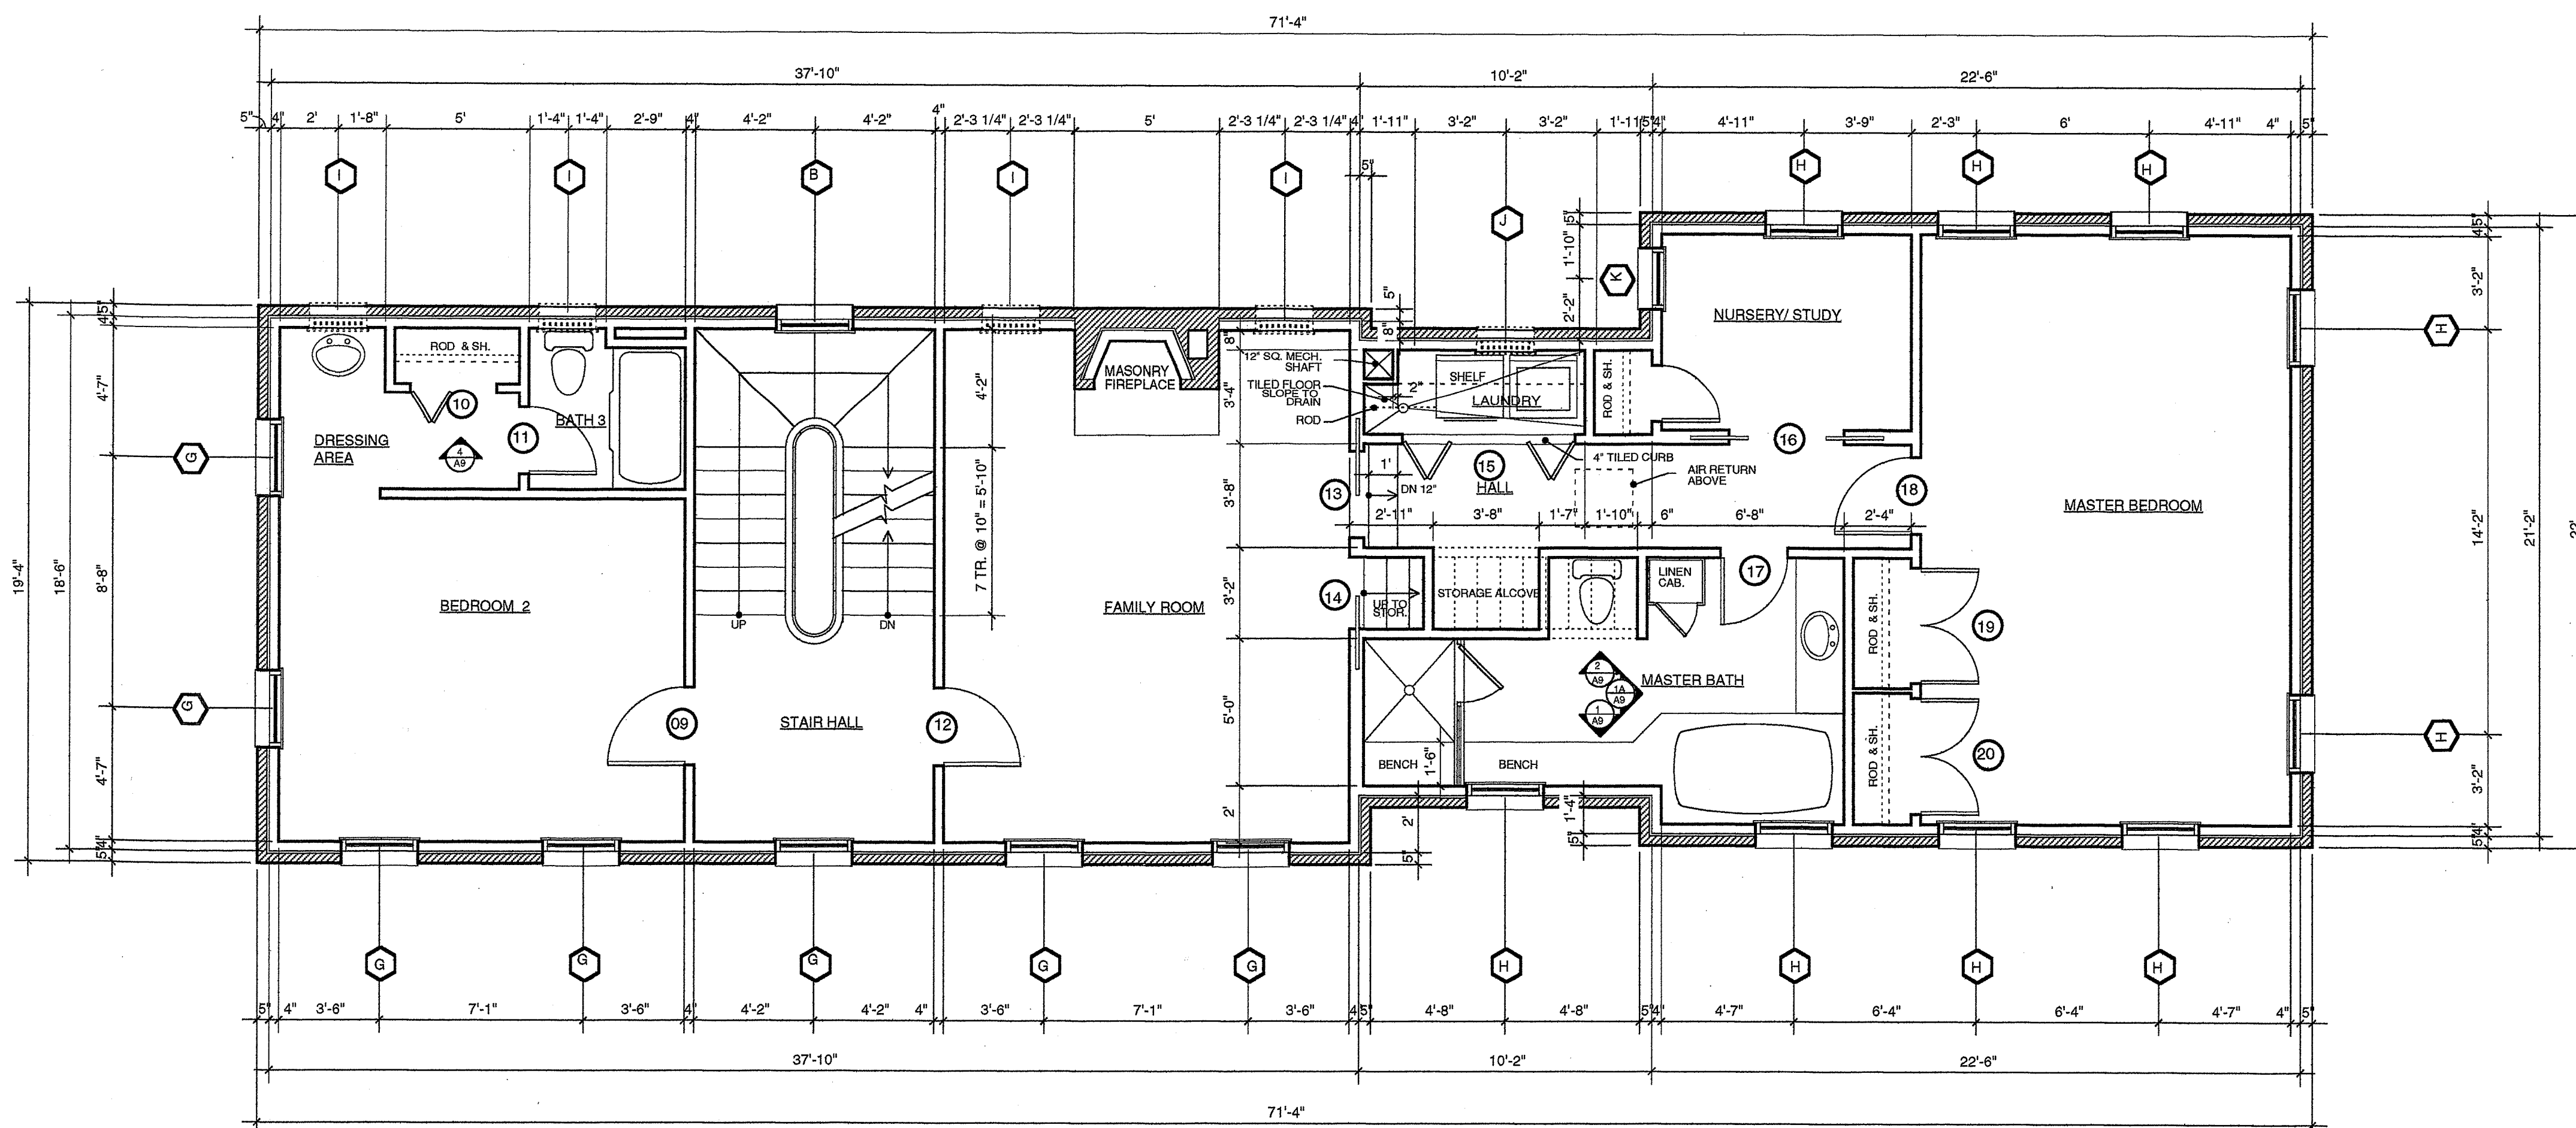

Copyright © 1997,
John L. Young, F.A.
in association with
Philip H. Dufford, F.A.
143 Wentworth Street
Charleston, S.C. 29401
803 577 0737
All rights reserved.
The reproduction or use
of this drawing or the
design herein without the
written consent of the
Architect is prohibited.
Architect waives all
responsibility and liability for
failure to follow these plans
and design, their convey or
provisions which arise from
other's failure to obtain and
follow the architect's
guidance with respect to any
inconsistencies, errors,
omissions, ambiguities or
conflicts which are alleged.

Dufford / Young Architects

143 Wentworth Street
Charleston, SC 29401
803 577 0737


MOORE RESIDENCE
Wraggborough Square
Charleston, South Carolina

date
11/10/97
drawn
JLY/PHD
comm. no.
revisions




1 EAST ELEVATION
SCALE: 1/4"=1'-0"


2 NORTH ELEVATION
SCALE: 1/4"=1'-0"

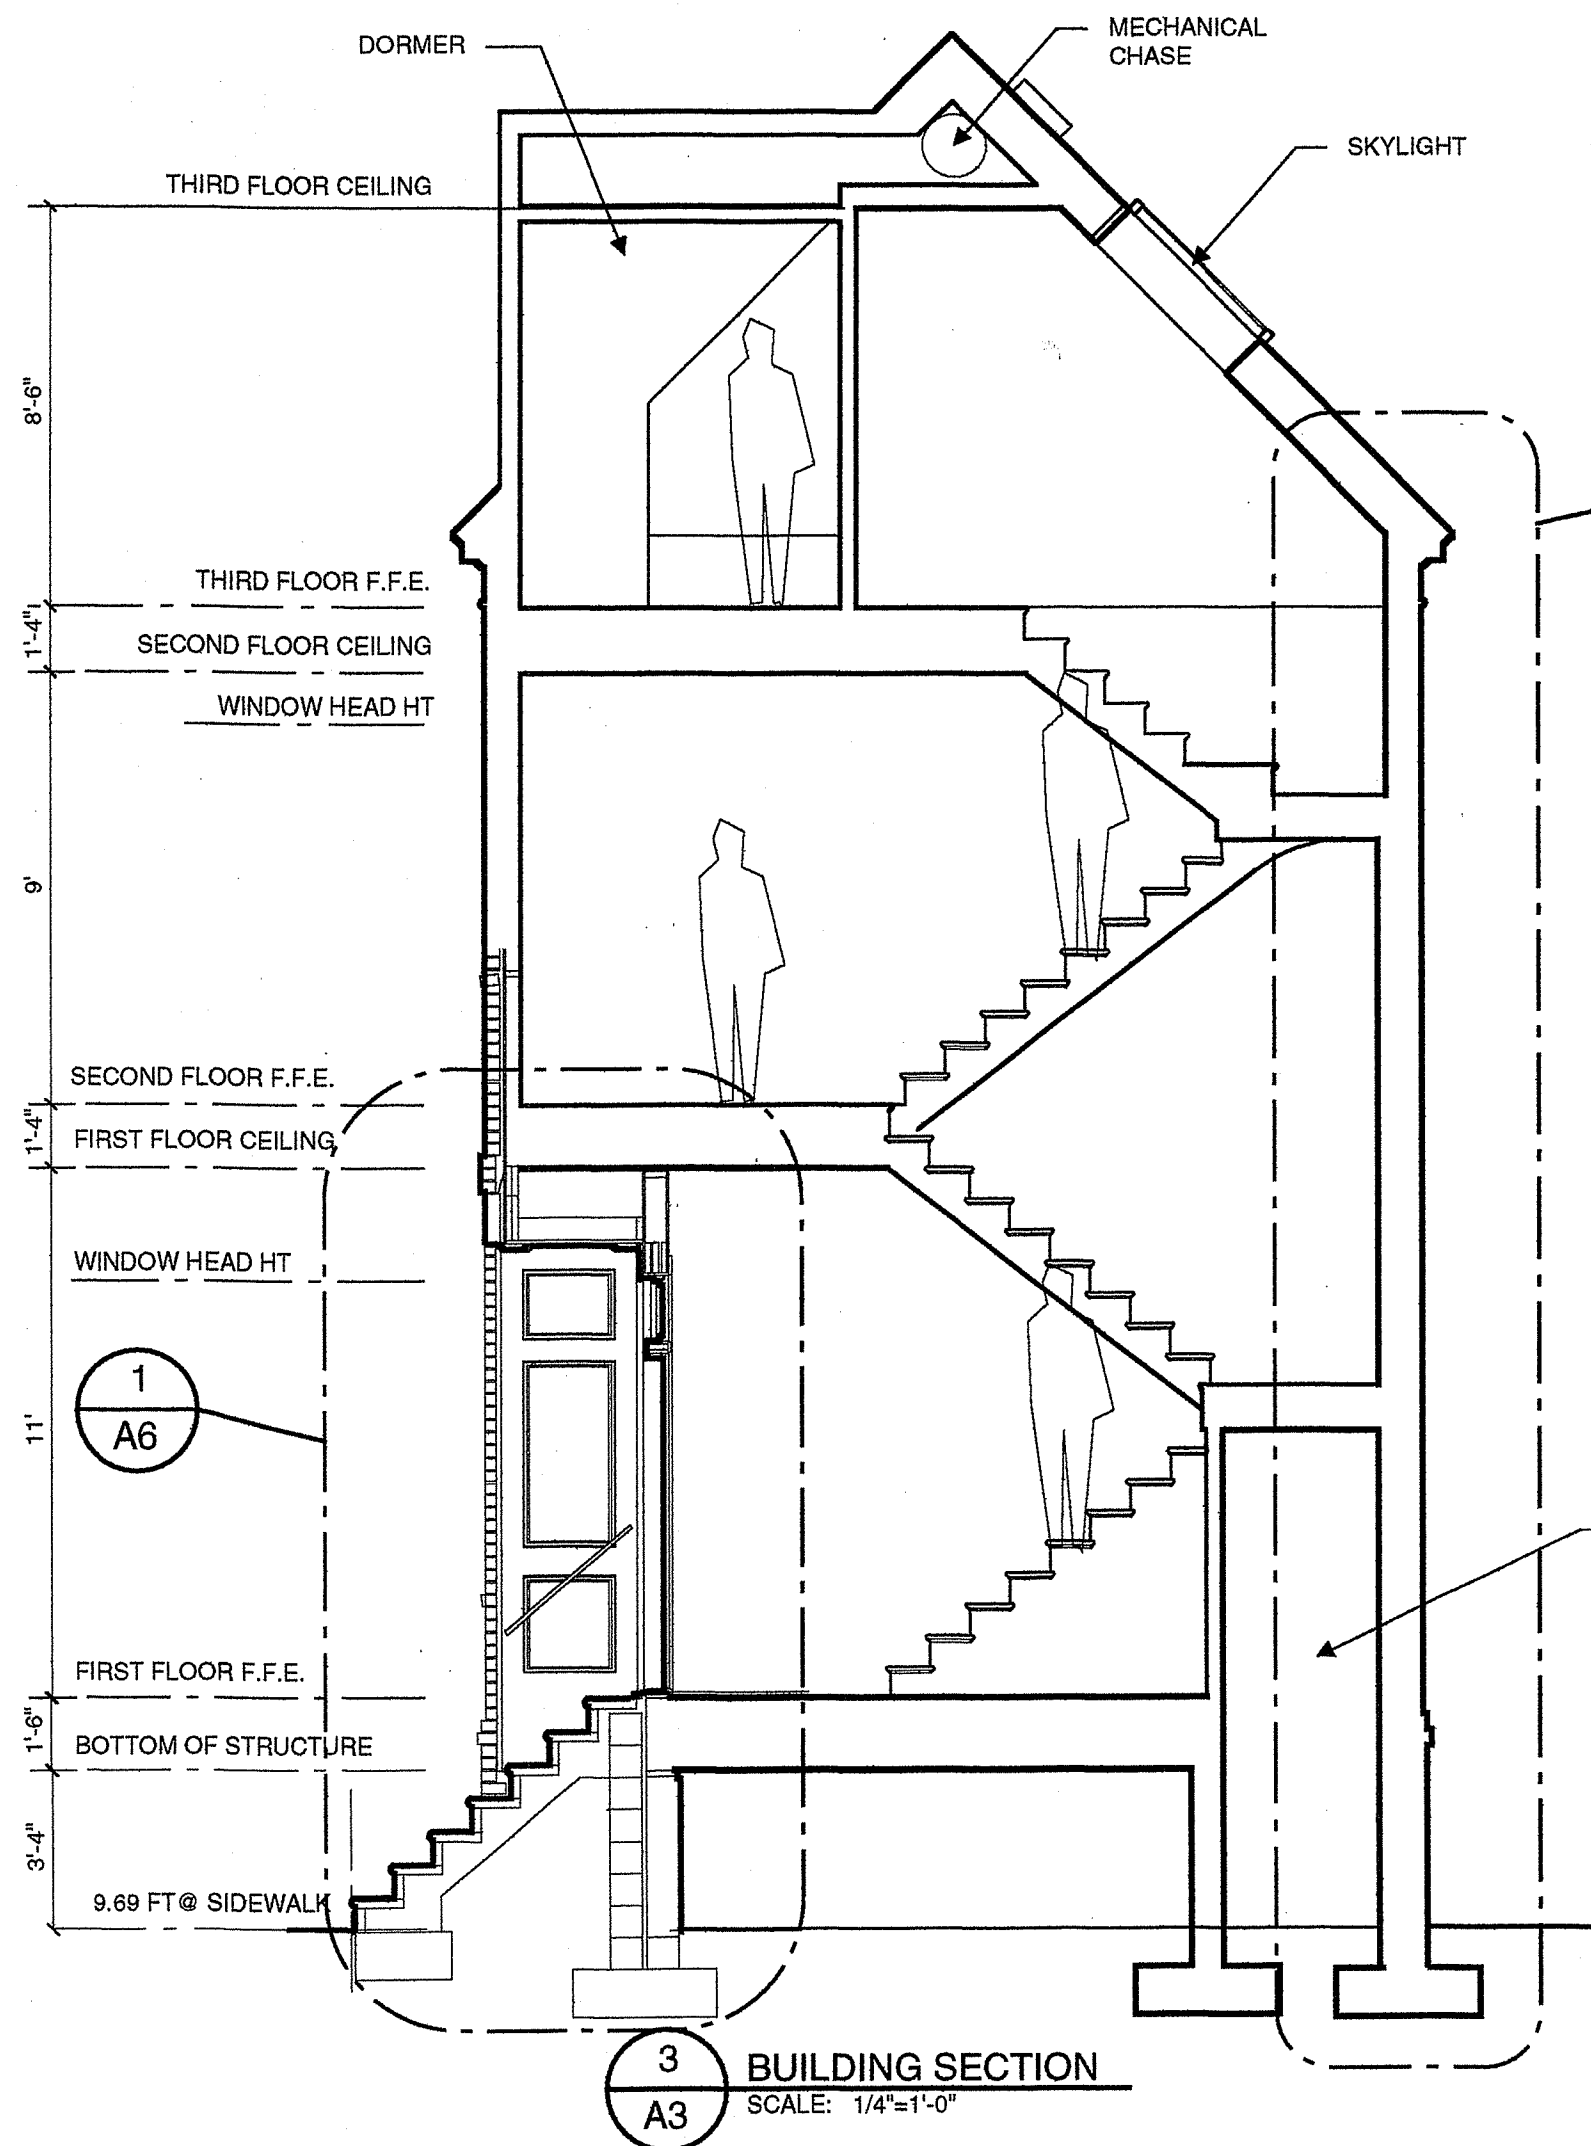

3 BUILDING SECTION
SCALE: 1/4"=1'-0"

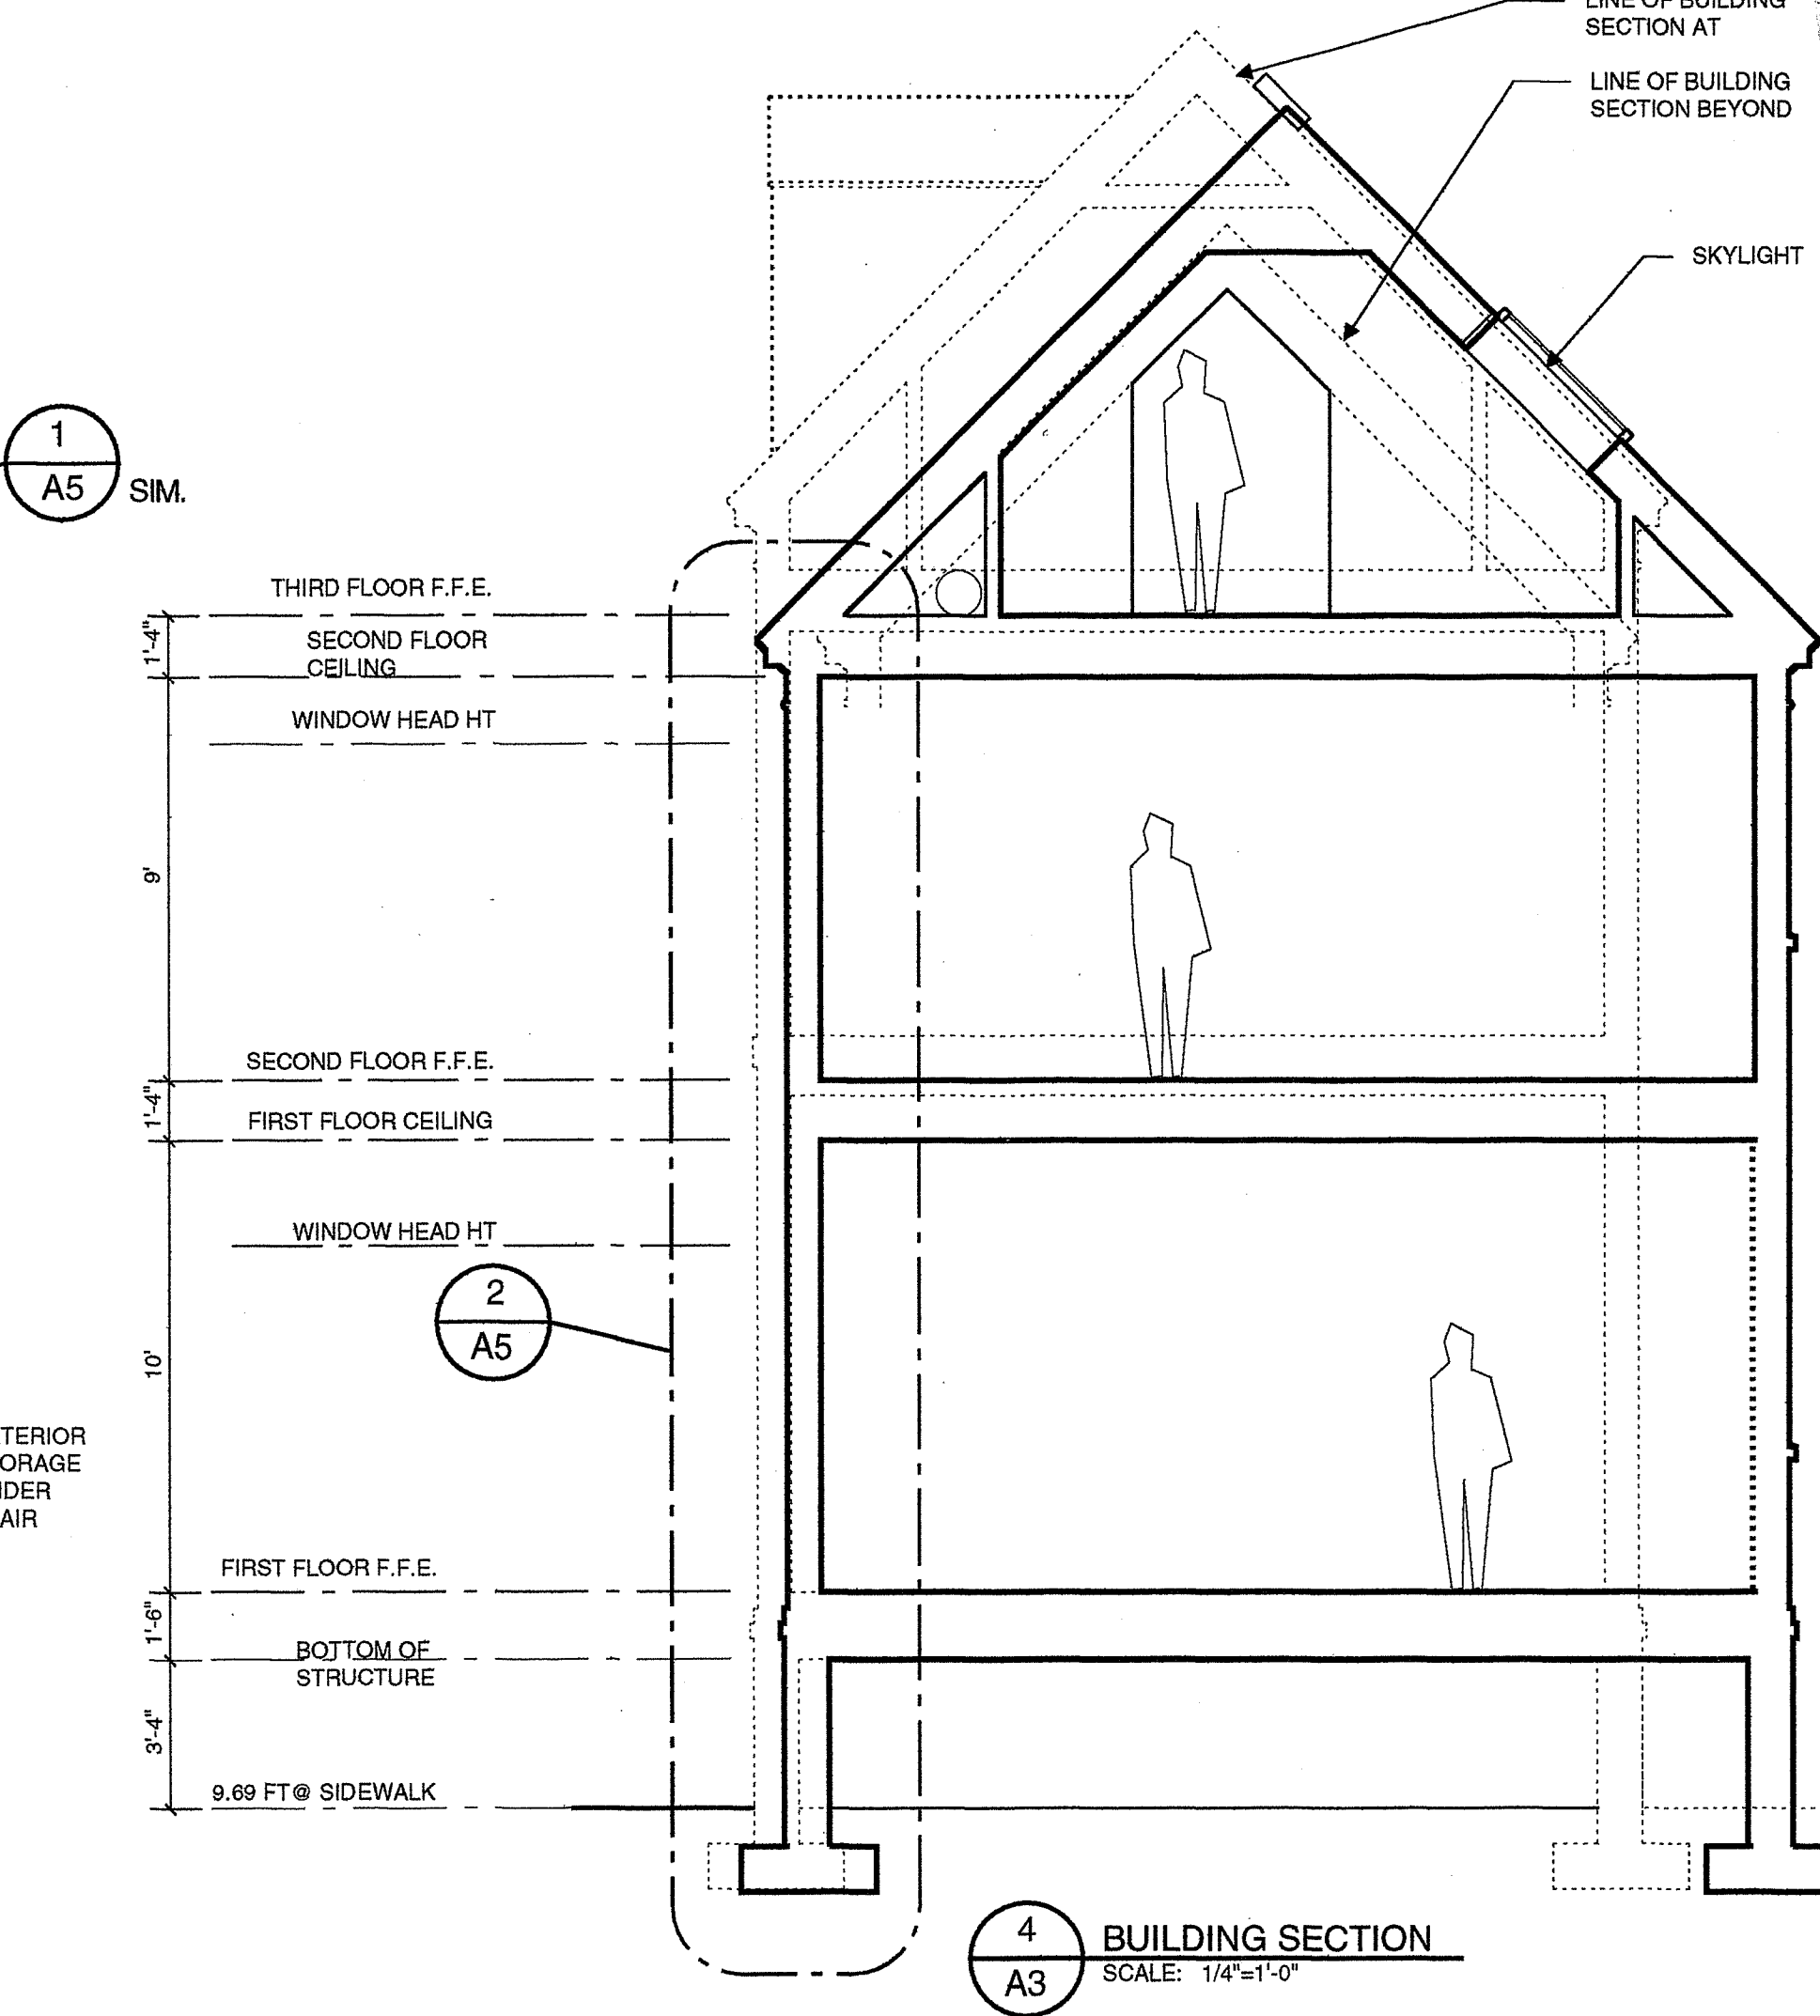

4 BUILDING SECTION
SCALE: 1/4"=1'-0"

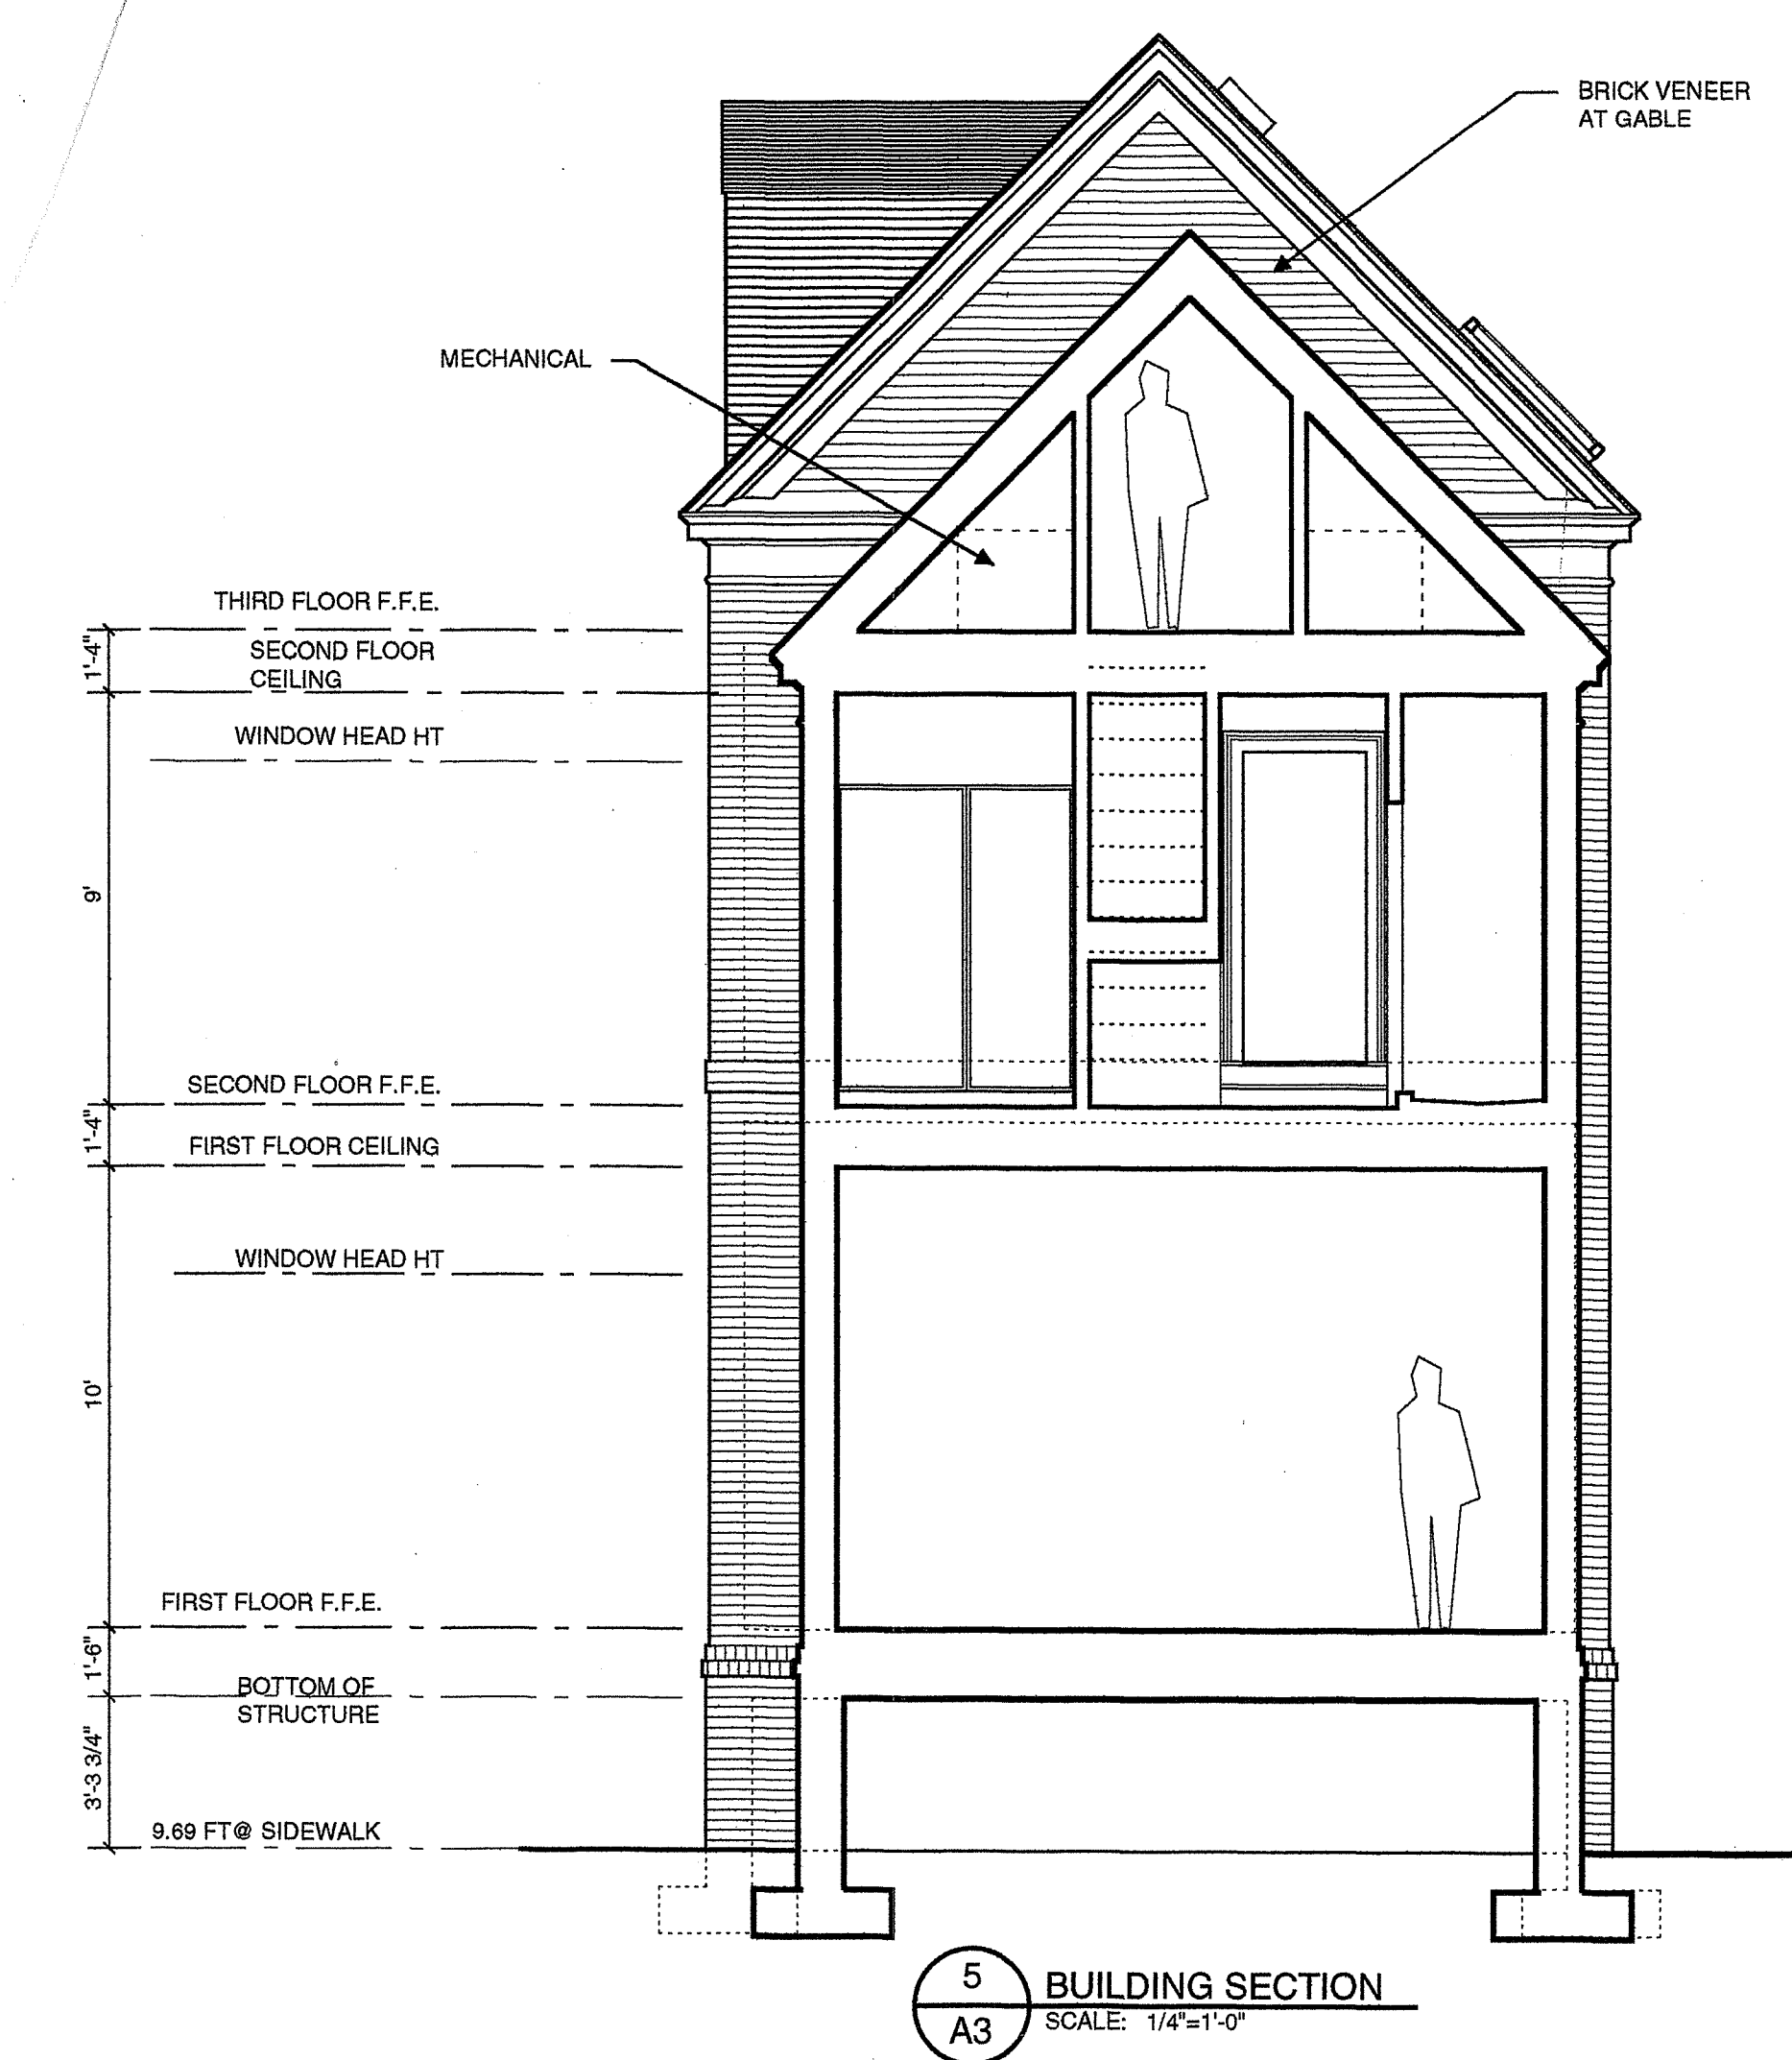

5 BUILDING SECTION
SCALE: 1/4"=1'-0"


Copyright © 1997
John F. Young, P.A.
in association with
Philip H. Dufford, P.A.
143 Wentworth Street
Charleston, S.C. 29401
803 577 0737
All rights reserved.
The reproduction or use
of this drawing or the
design herein without the
written consent of the
Architect is prohibited.
Architect waives all
responsibility and liability for
failure to follow these plans
and design they convey or
problems which arise from
others failure to obtain and
follow the architect's
guidance with respect to any
inconsistencies, errors,
omissions, ambiguities or
conflicts which are alleged.

Dufford / Young Architects

143 Wentworth Street
Charleston, SC 29401
803 577 0737






MOORE RESIDENCE
Wraggborough Square
Charleston, South Carolina

date
11/10/97
drawn
JLY/PHD
comm. no.
revisions

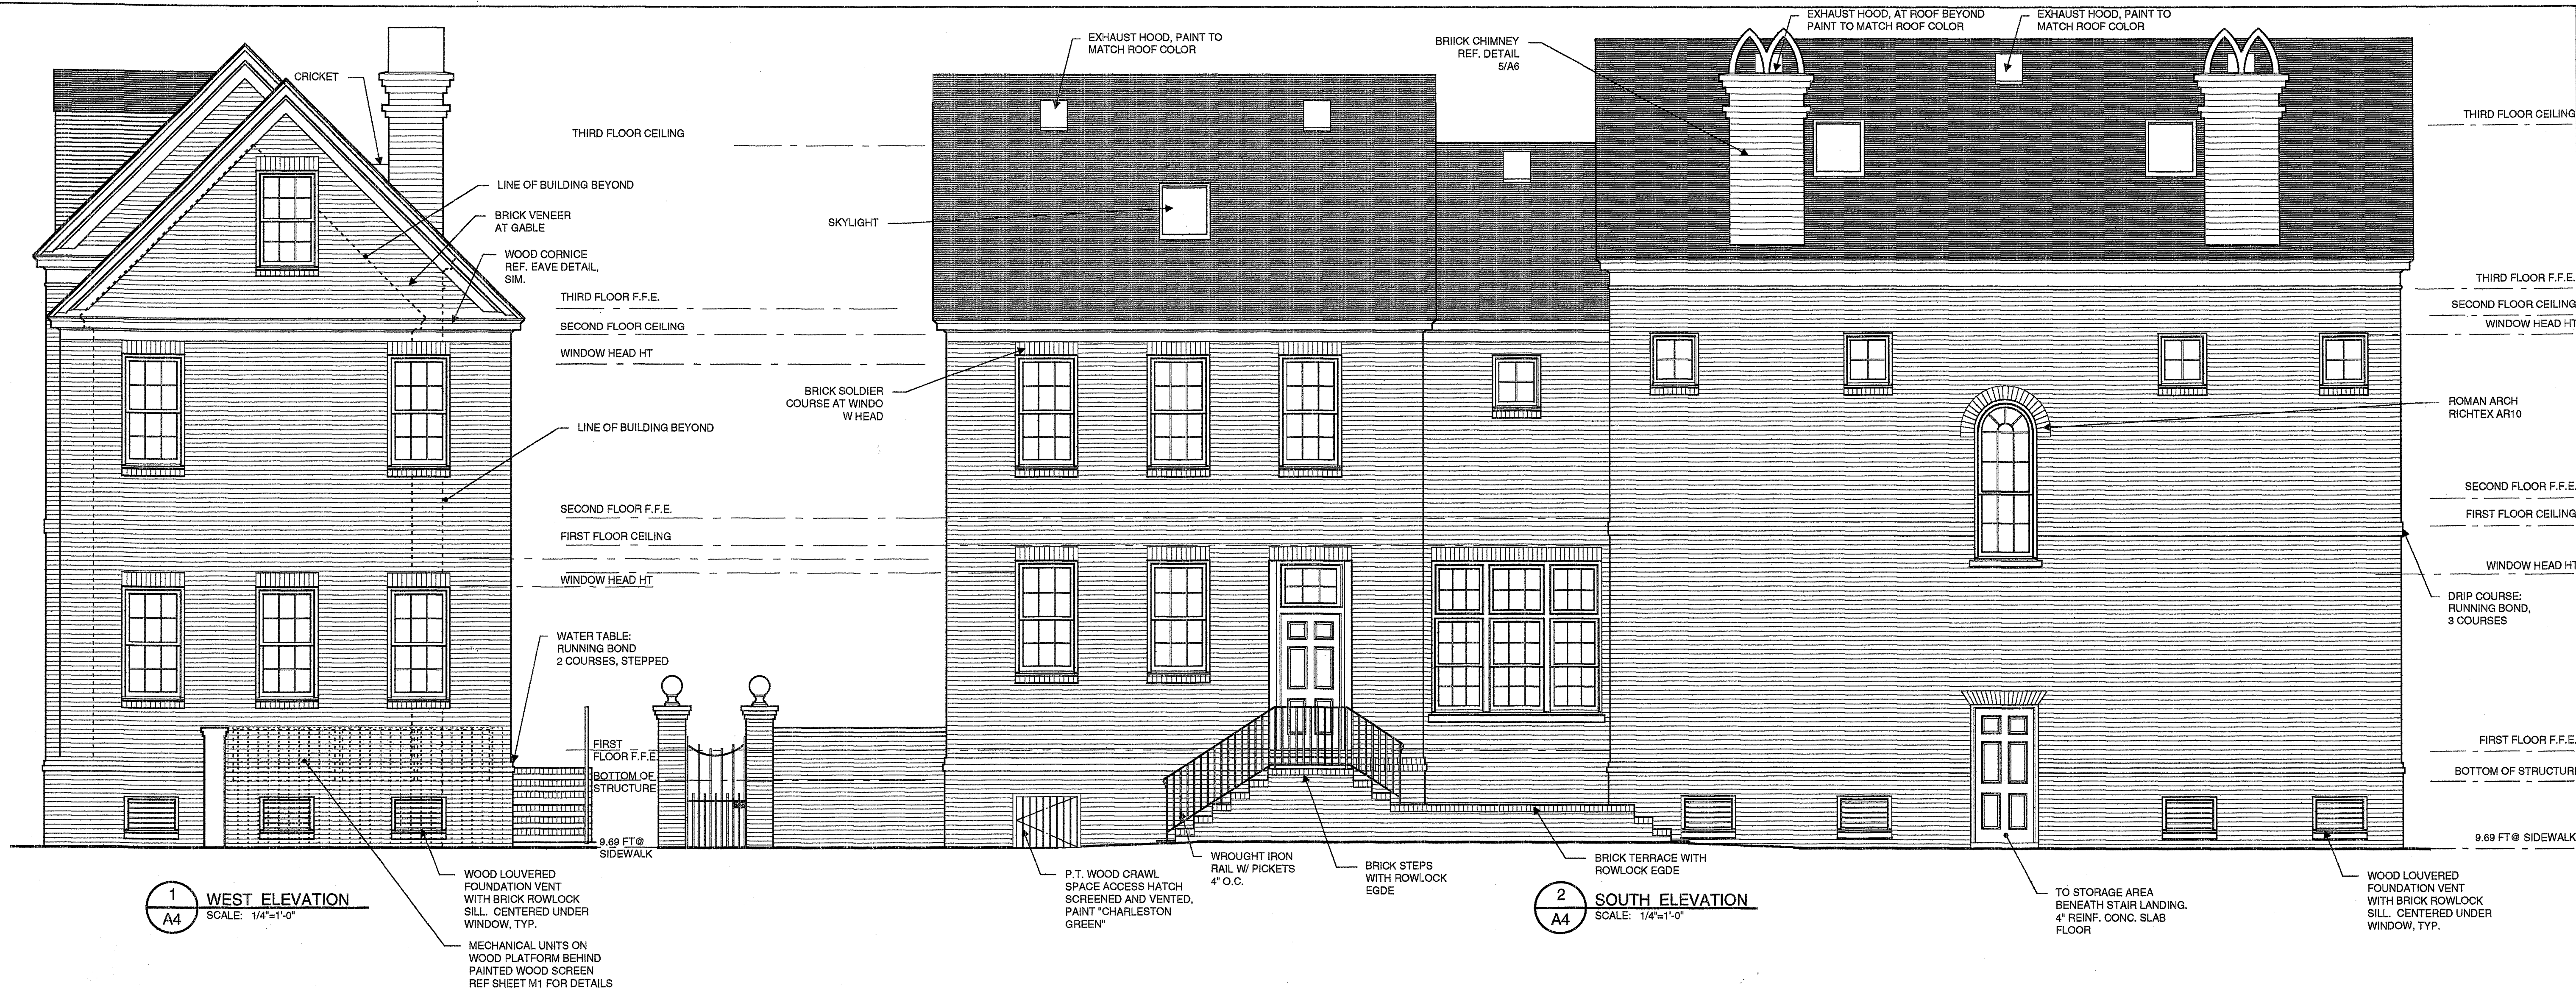

Copyright © 1997
John L. Young, P.A.
In association with
Philip H. Dufford, P.A.
143 Wentworth Street
Charleston, S.C. 29401
803 577 0737
All rights reserved.
The reproduction or use
of this drawing or the
design herein without the
written consent of the
Architect is prohibited.

Architect waives all
responsibility and liability for
failure to follow these plans
and design they convey or
problems which arise from
other's failure to obtain and
follow the architect's
guidance with respect to any
inconsistencies, errors,
omissions, ambiguities or
conflicts which are alleged.

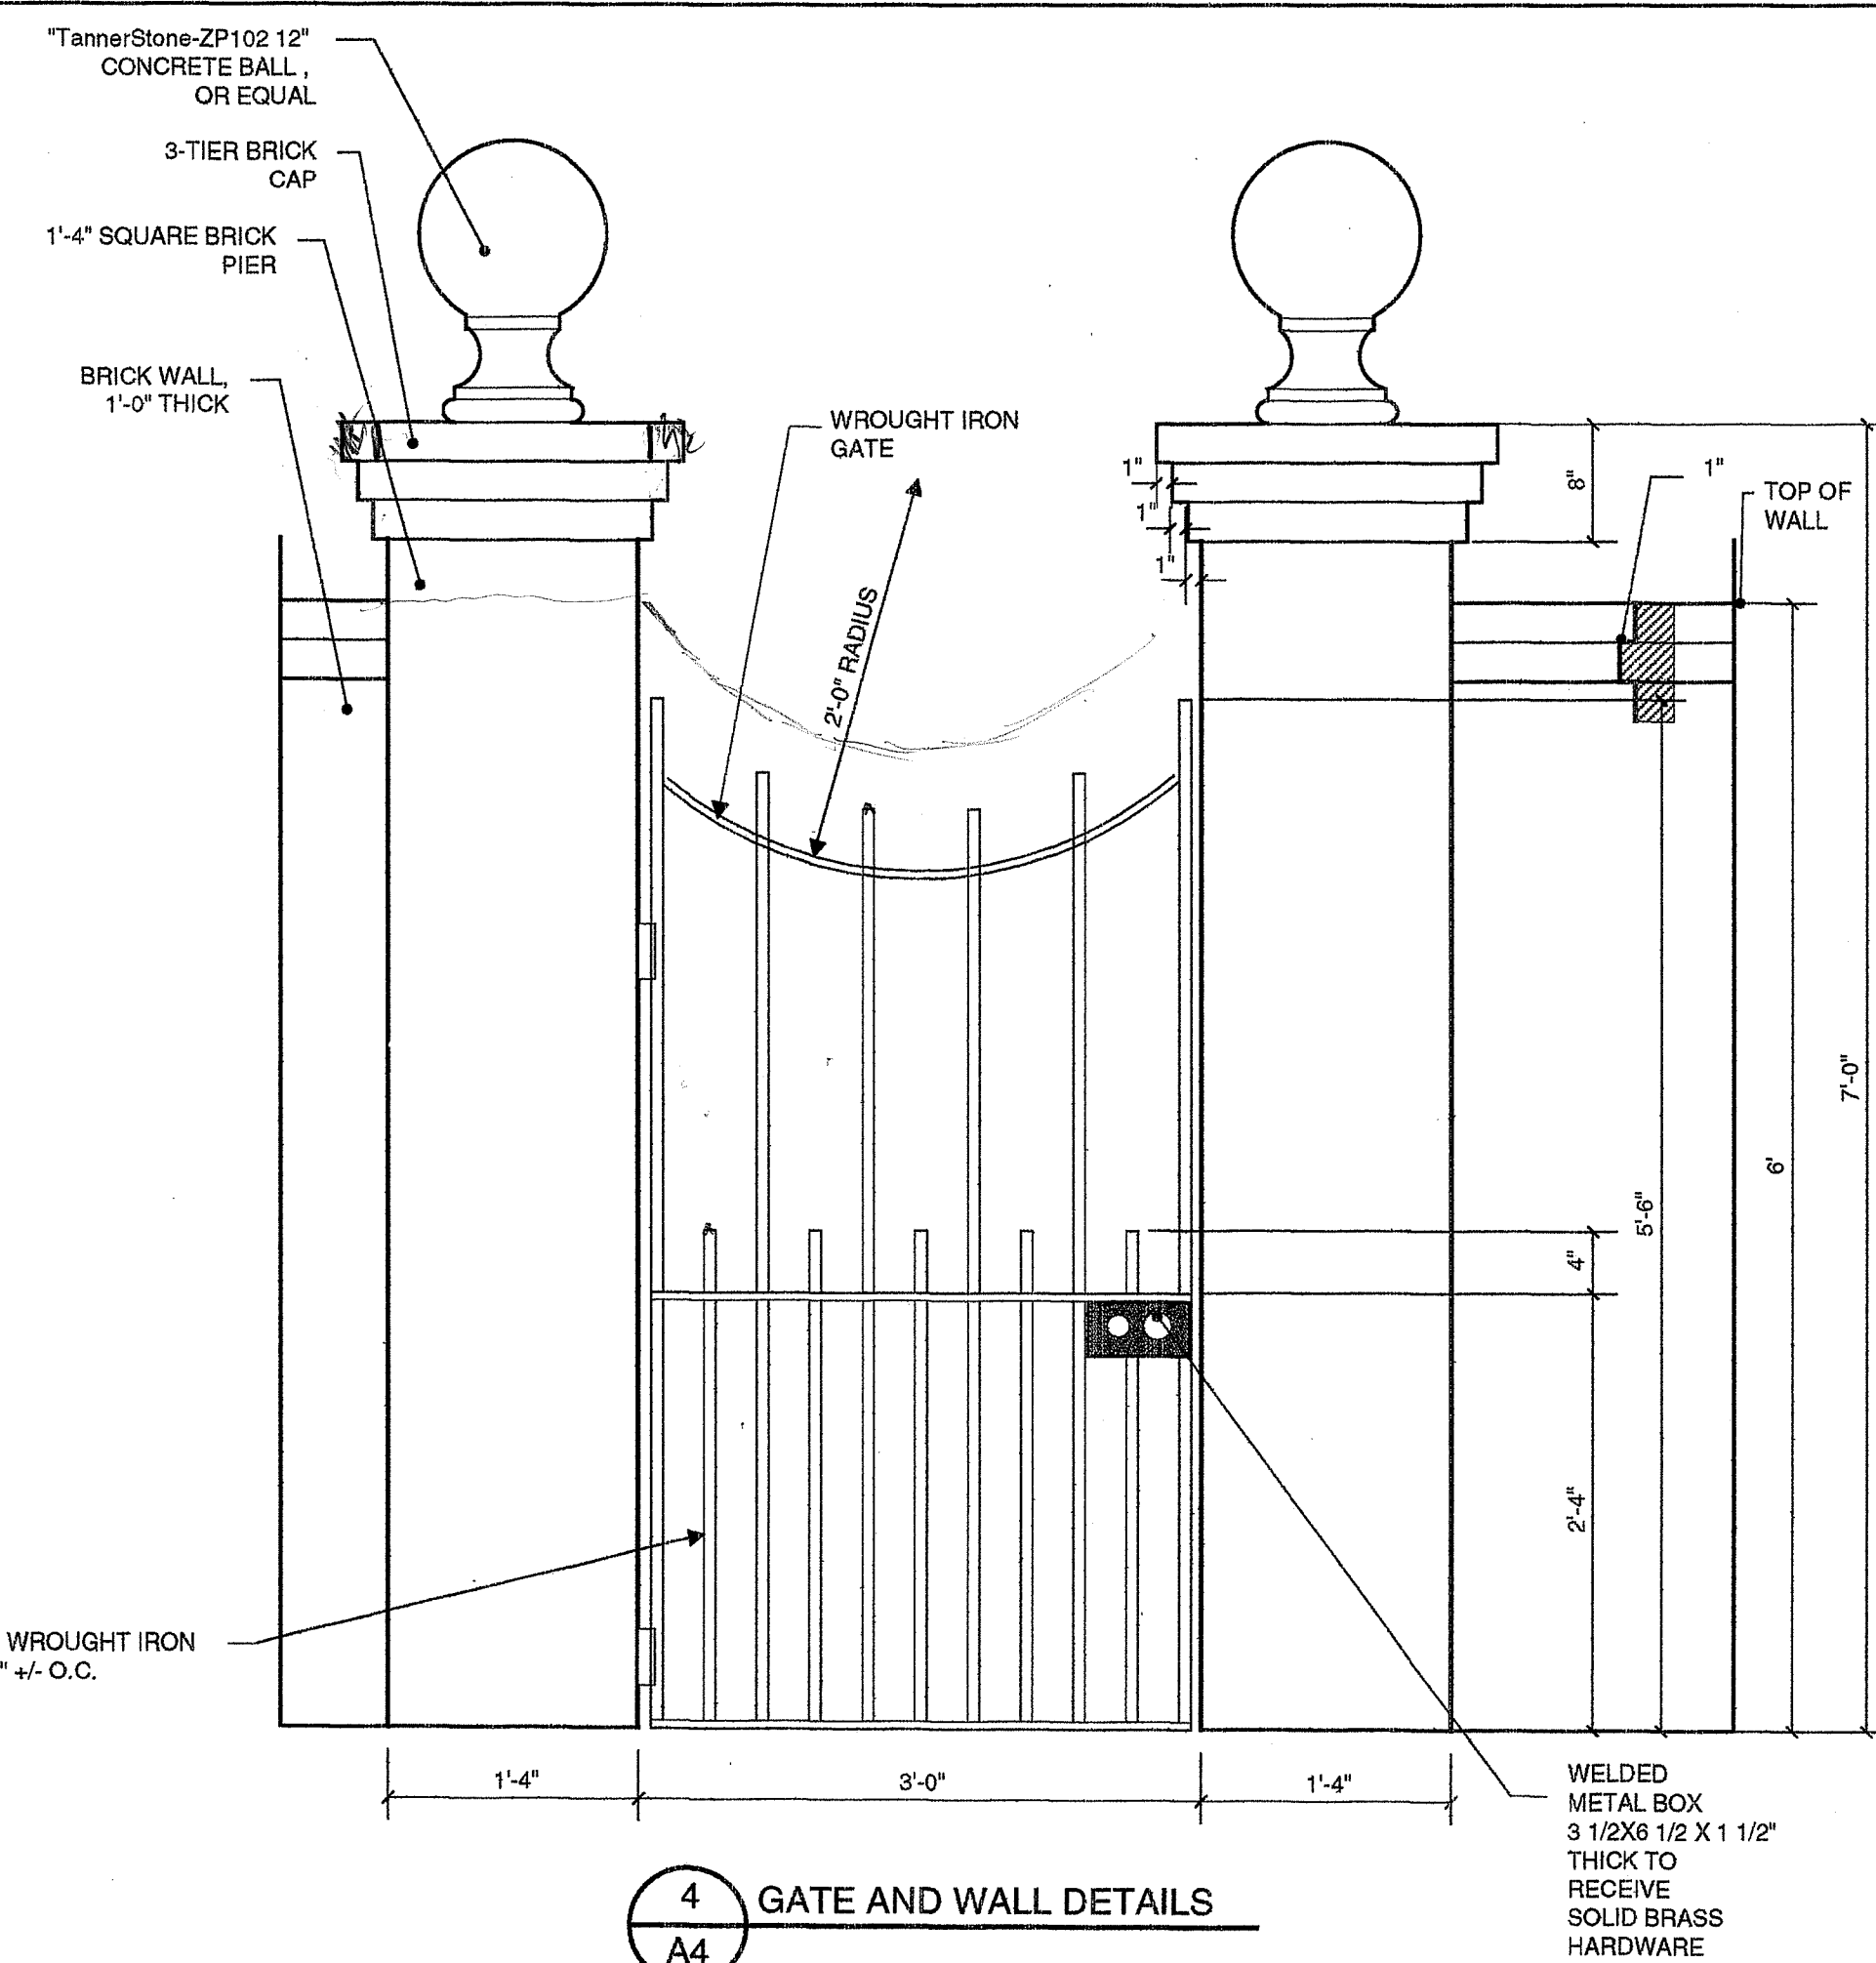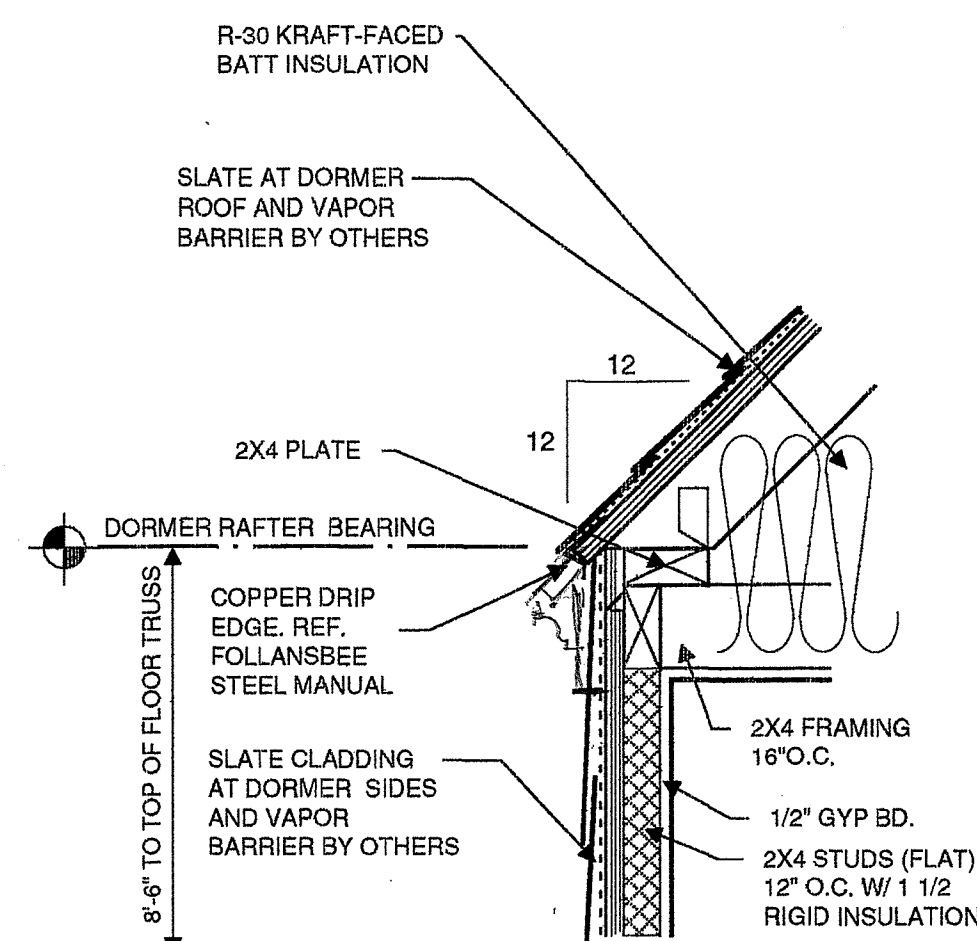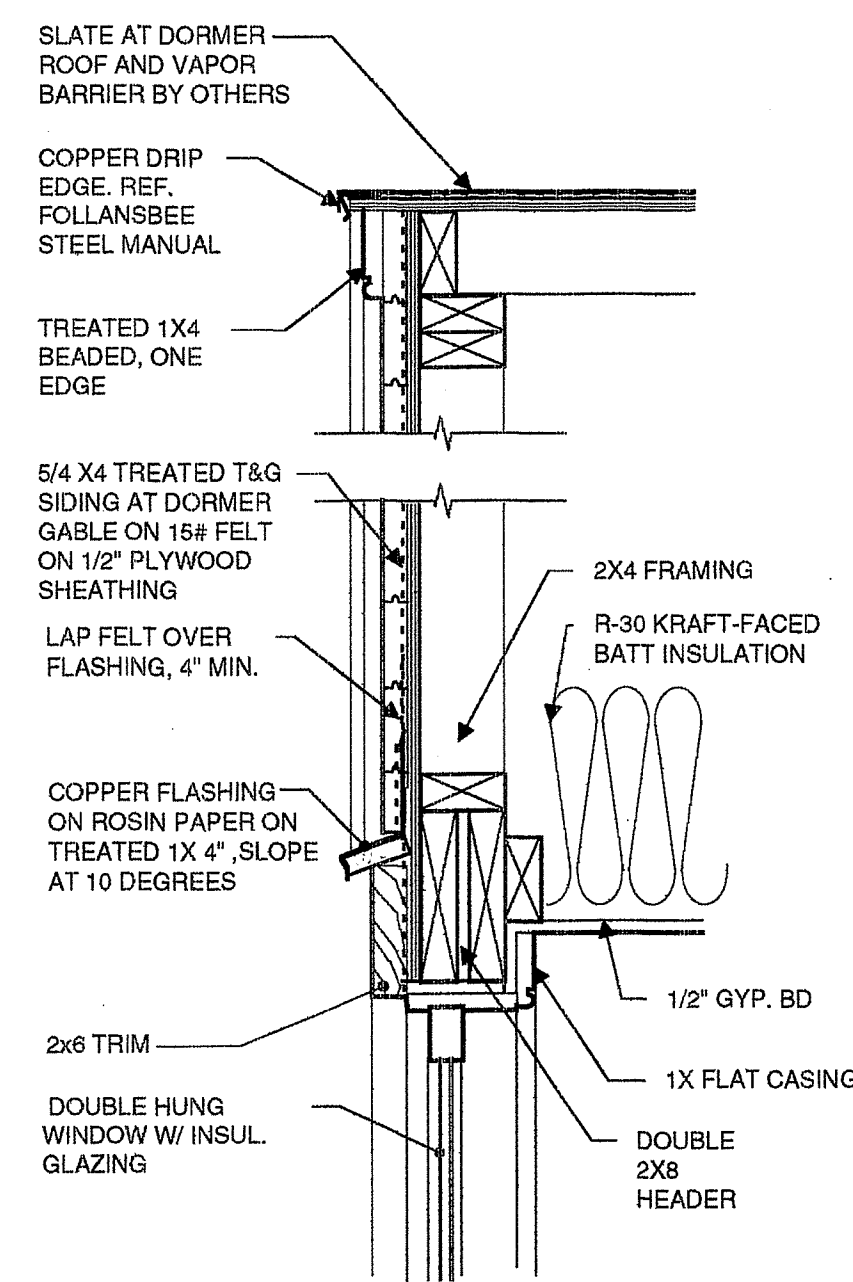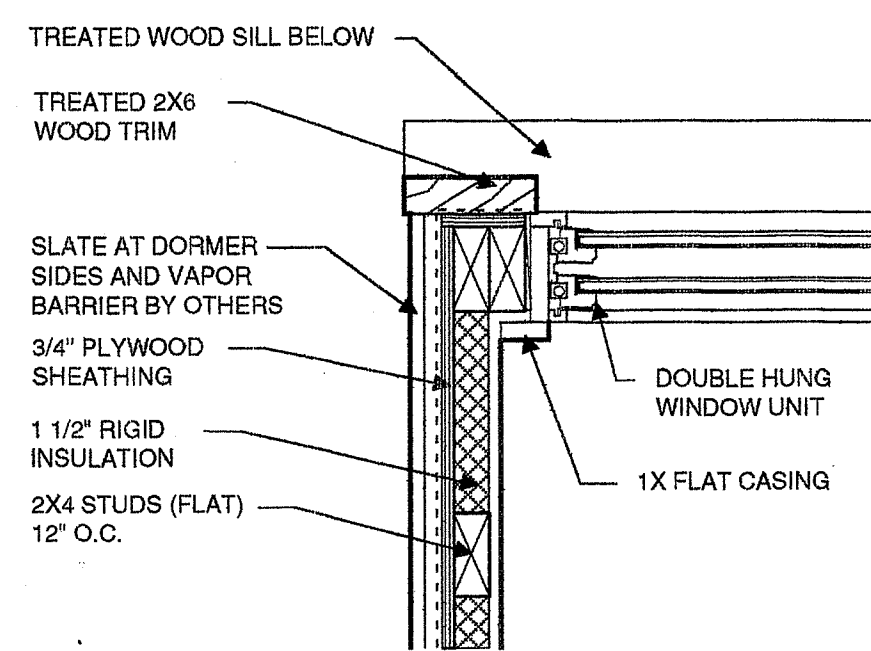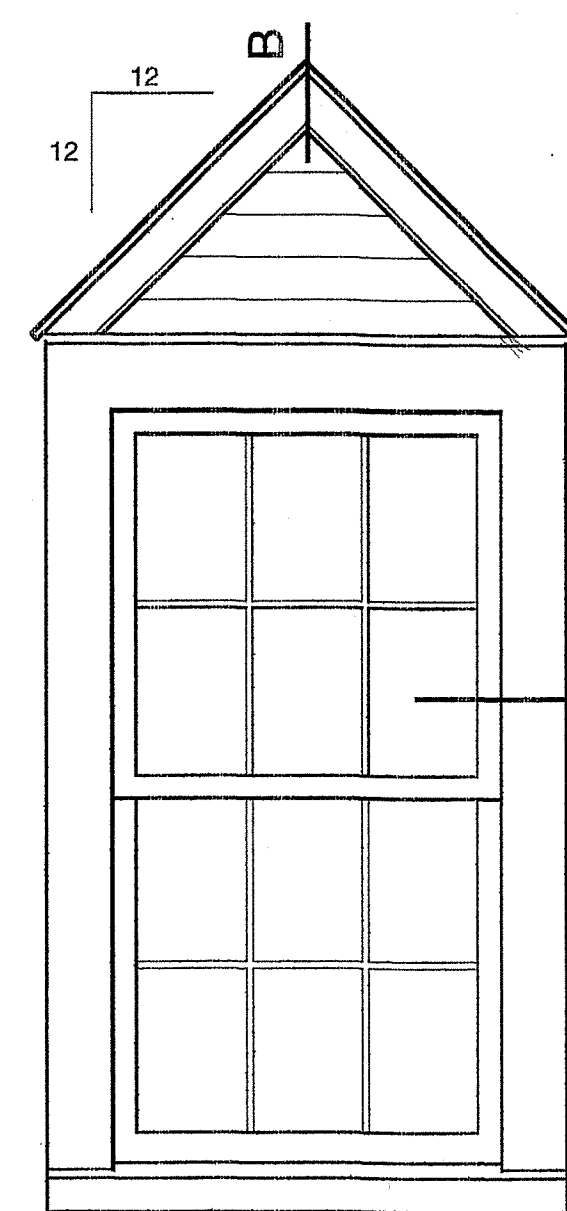

Dufford / Young Architects

143 Wentworth Street
Charleston, SC 29401
803 577 0737

MOORE RESIDENCE
Wragborough Square
Charleston, South Carolina

date
11/10/97

drawn
JLY/PHD

comm. no.





revisions

ELEVATIONS

A4

Copyright © 1997
John L. Young, F.A.
in association with
Philip H. Dufford, F.A.
143 Wentworth Street
Charleston, S.C. 29401
803 577 0737
All rights reserved.
The reproduction or use
of this drawing or the
design herein without the
written consent of the
Architect is prohibited.

Architect waives all
responsibility and liability for
failure to follow these plans
and design they convey or
problems which arise from
other's failure to obtain and
follow the architect's
guidance with respect to any
inconsistencies, errors,
omissions, ambiguities or
conflicts which are alleged.

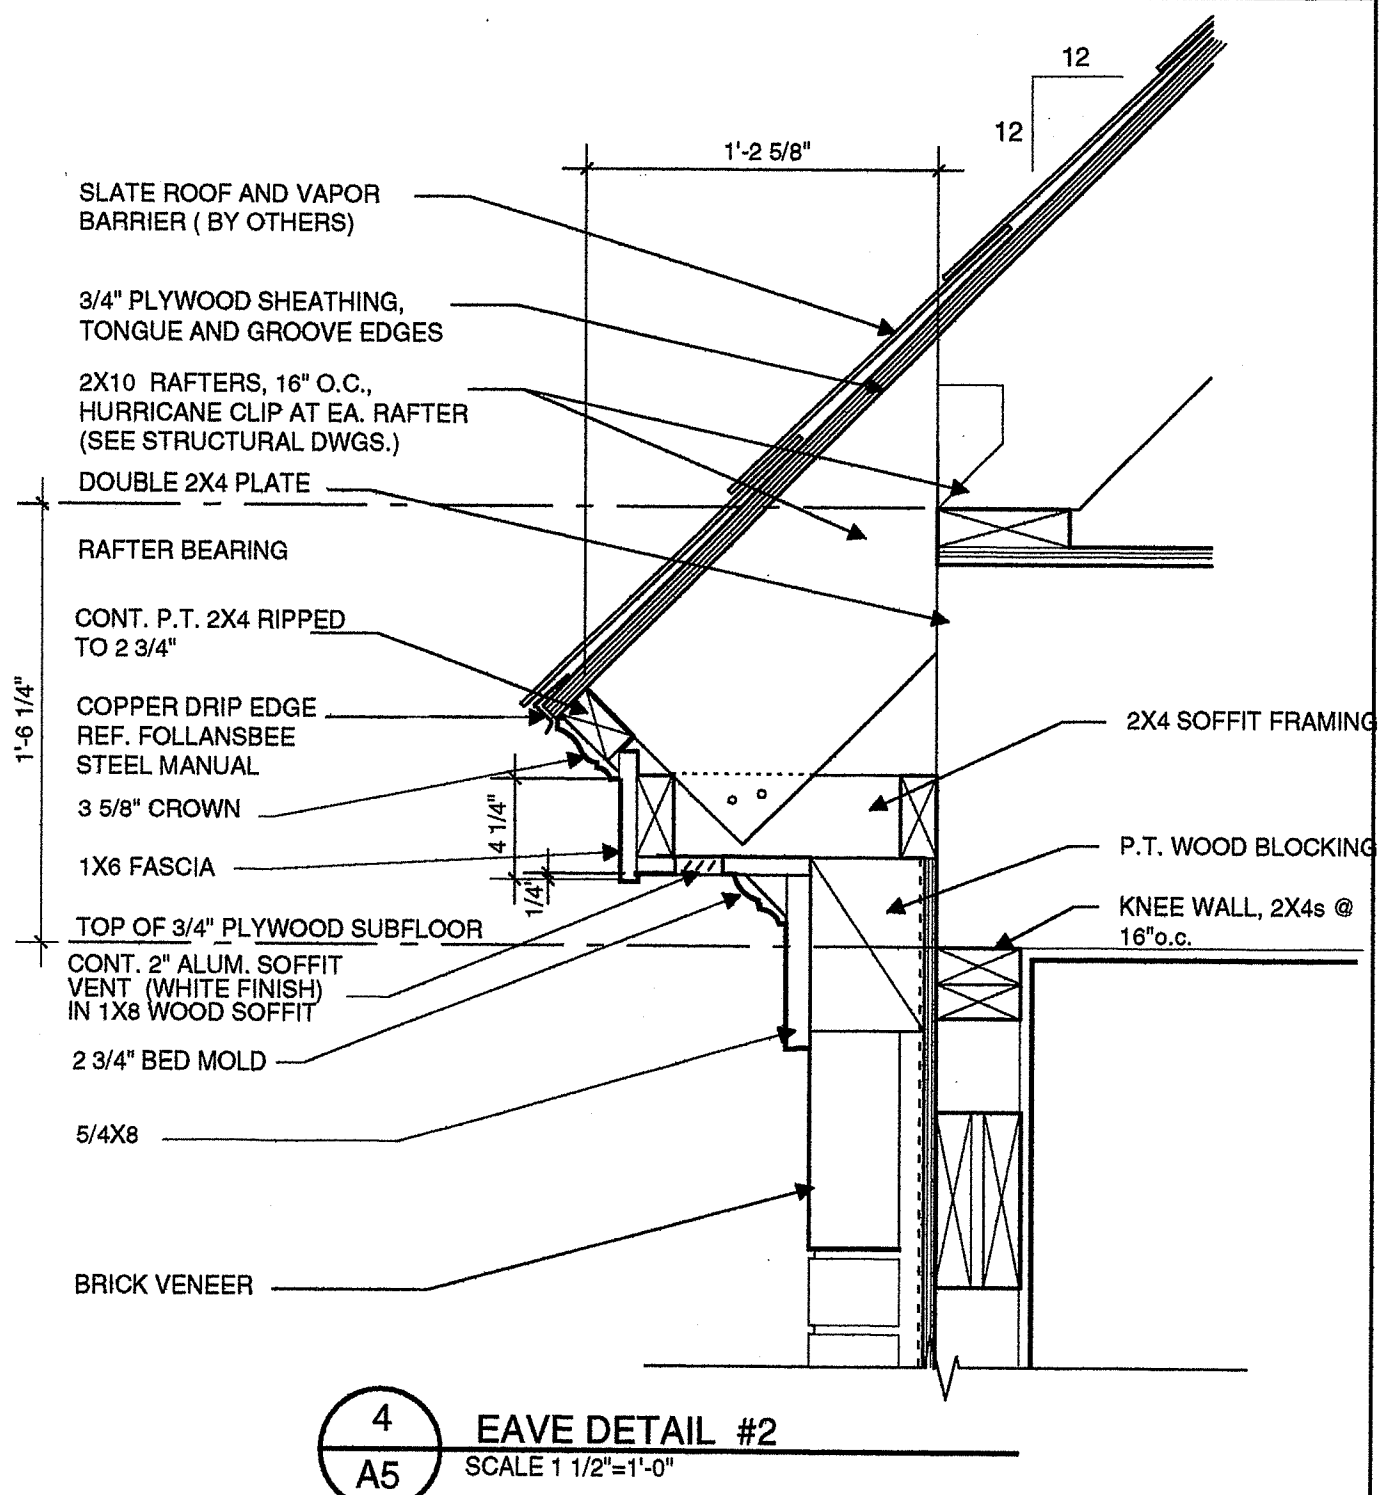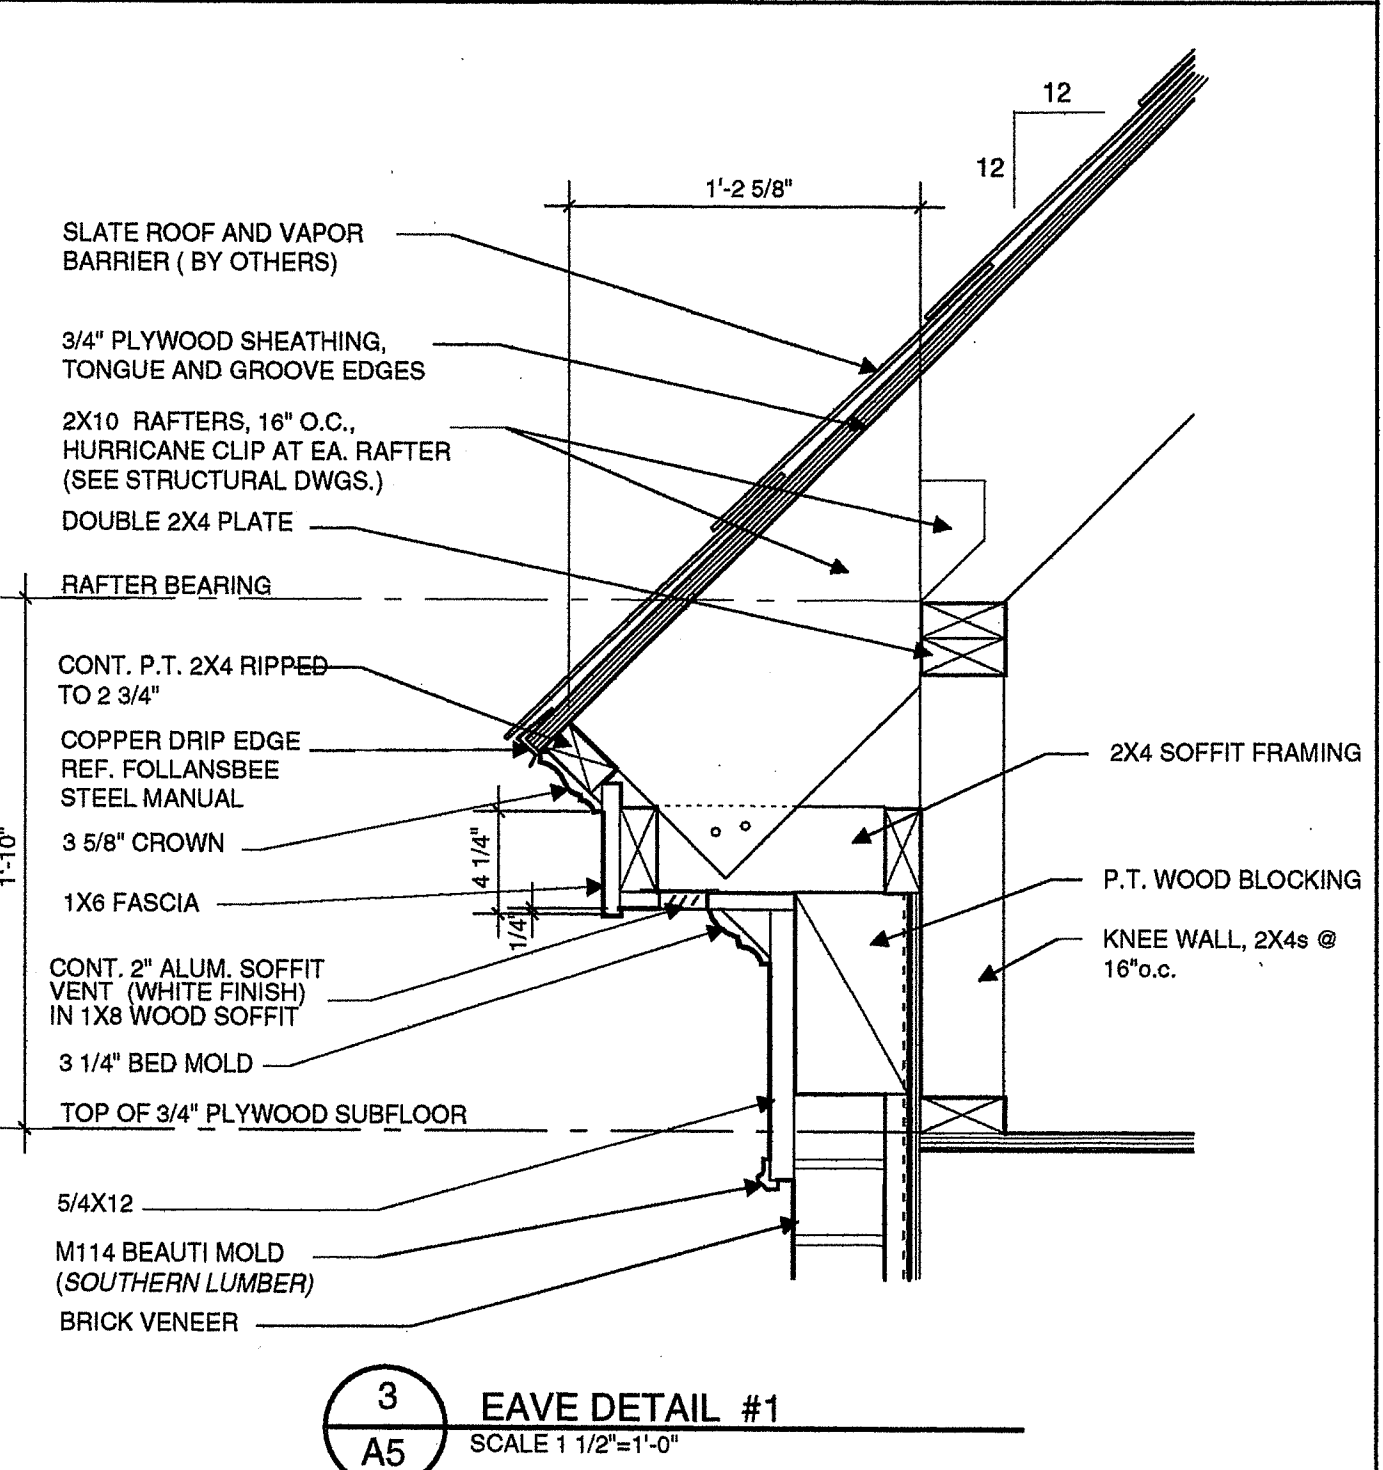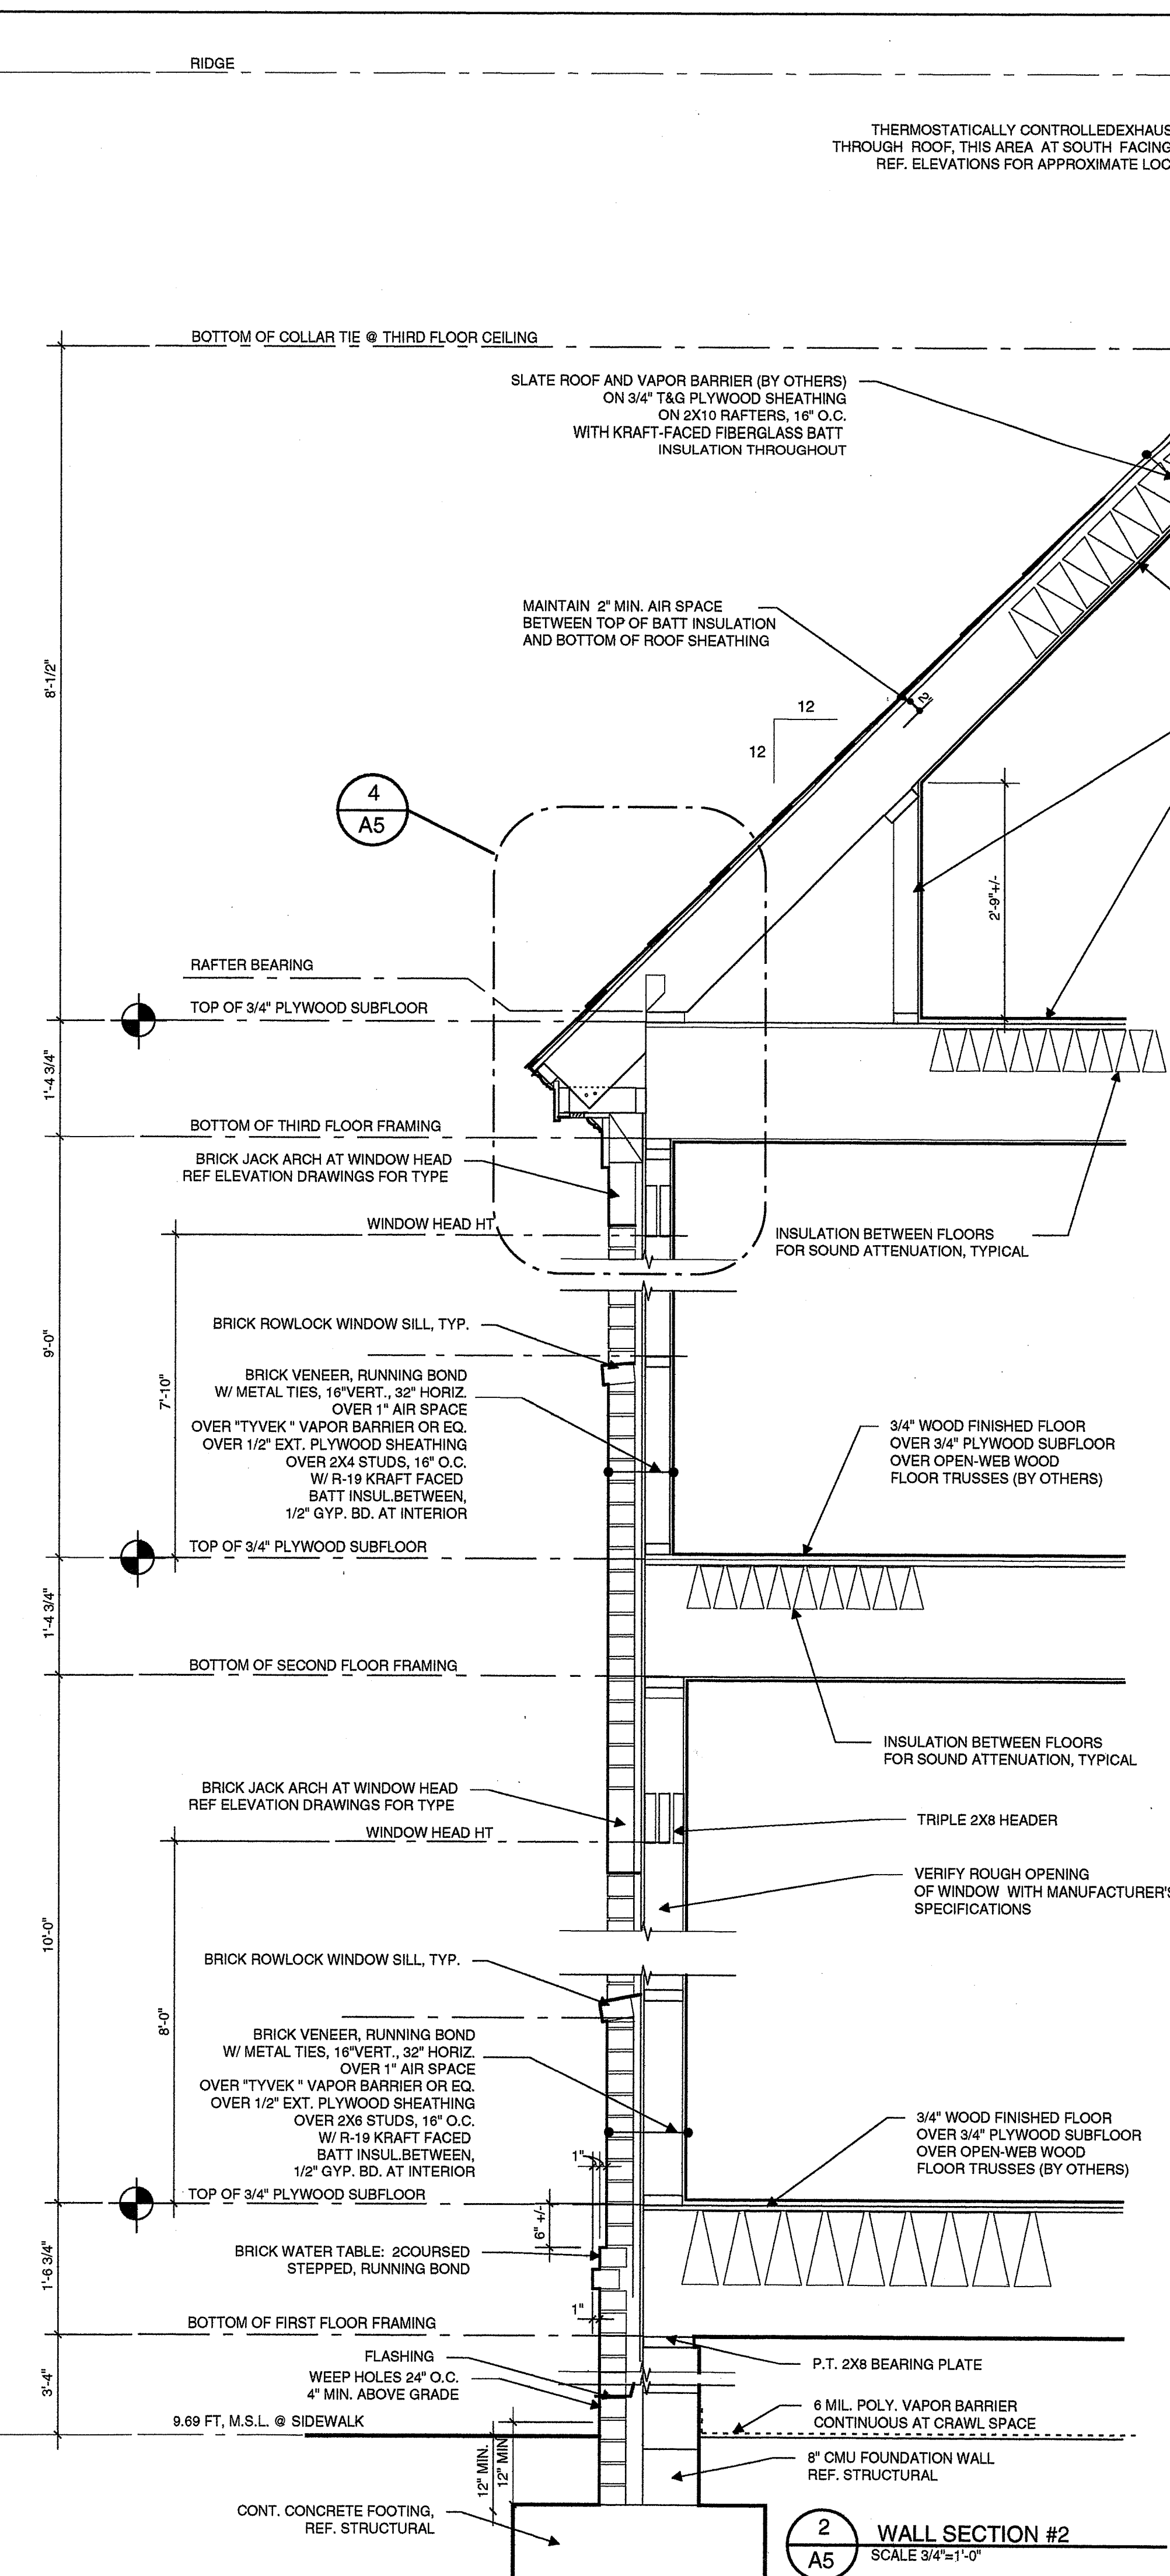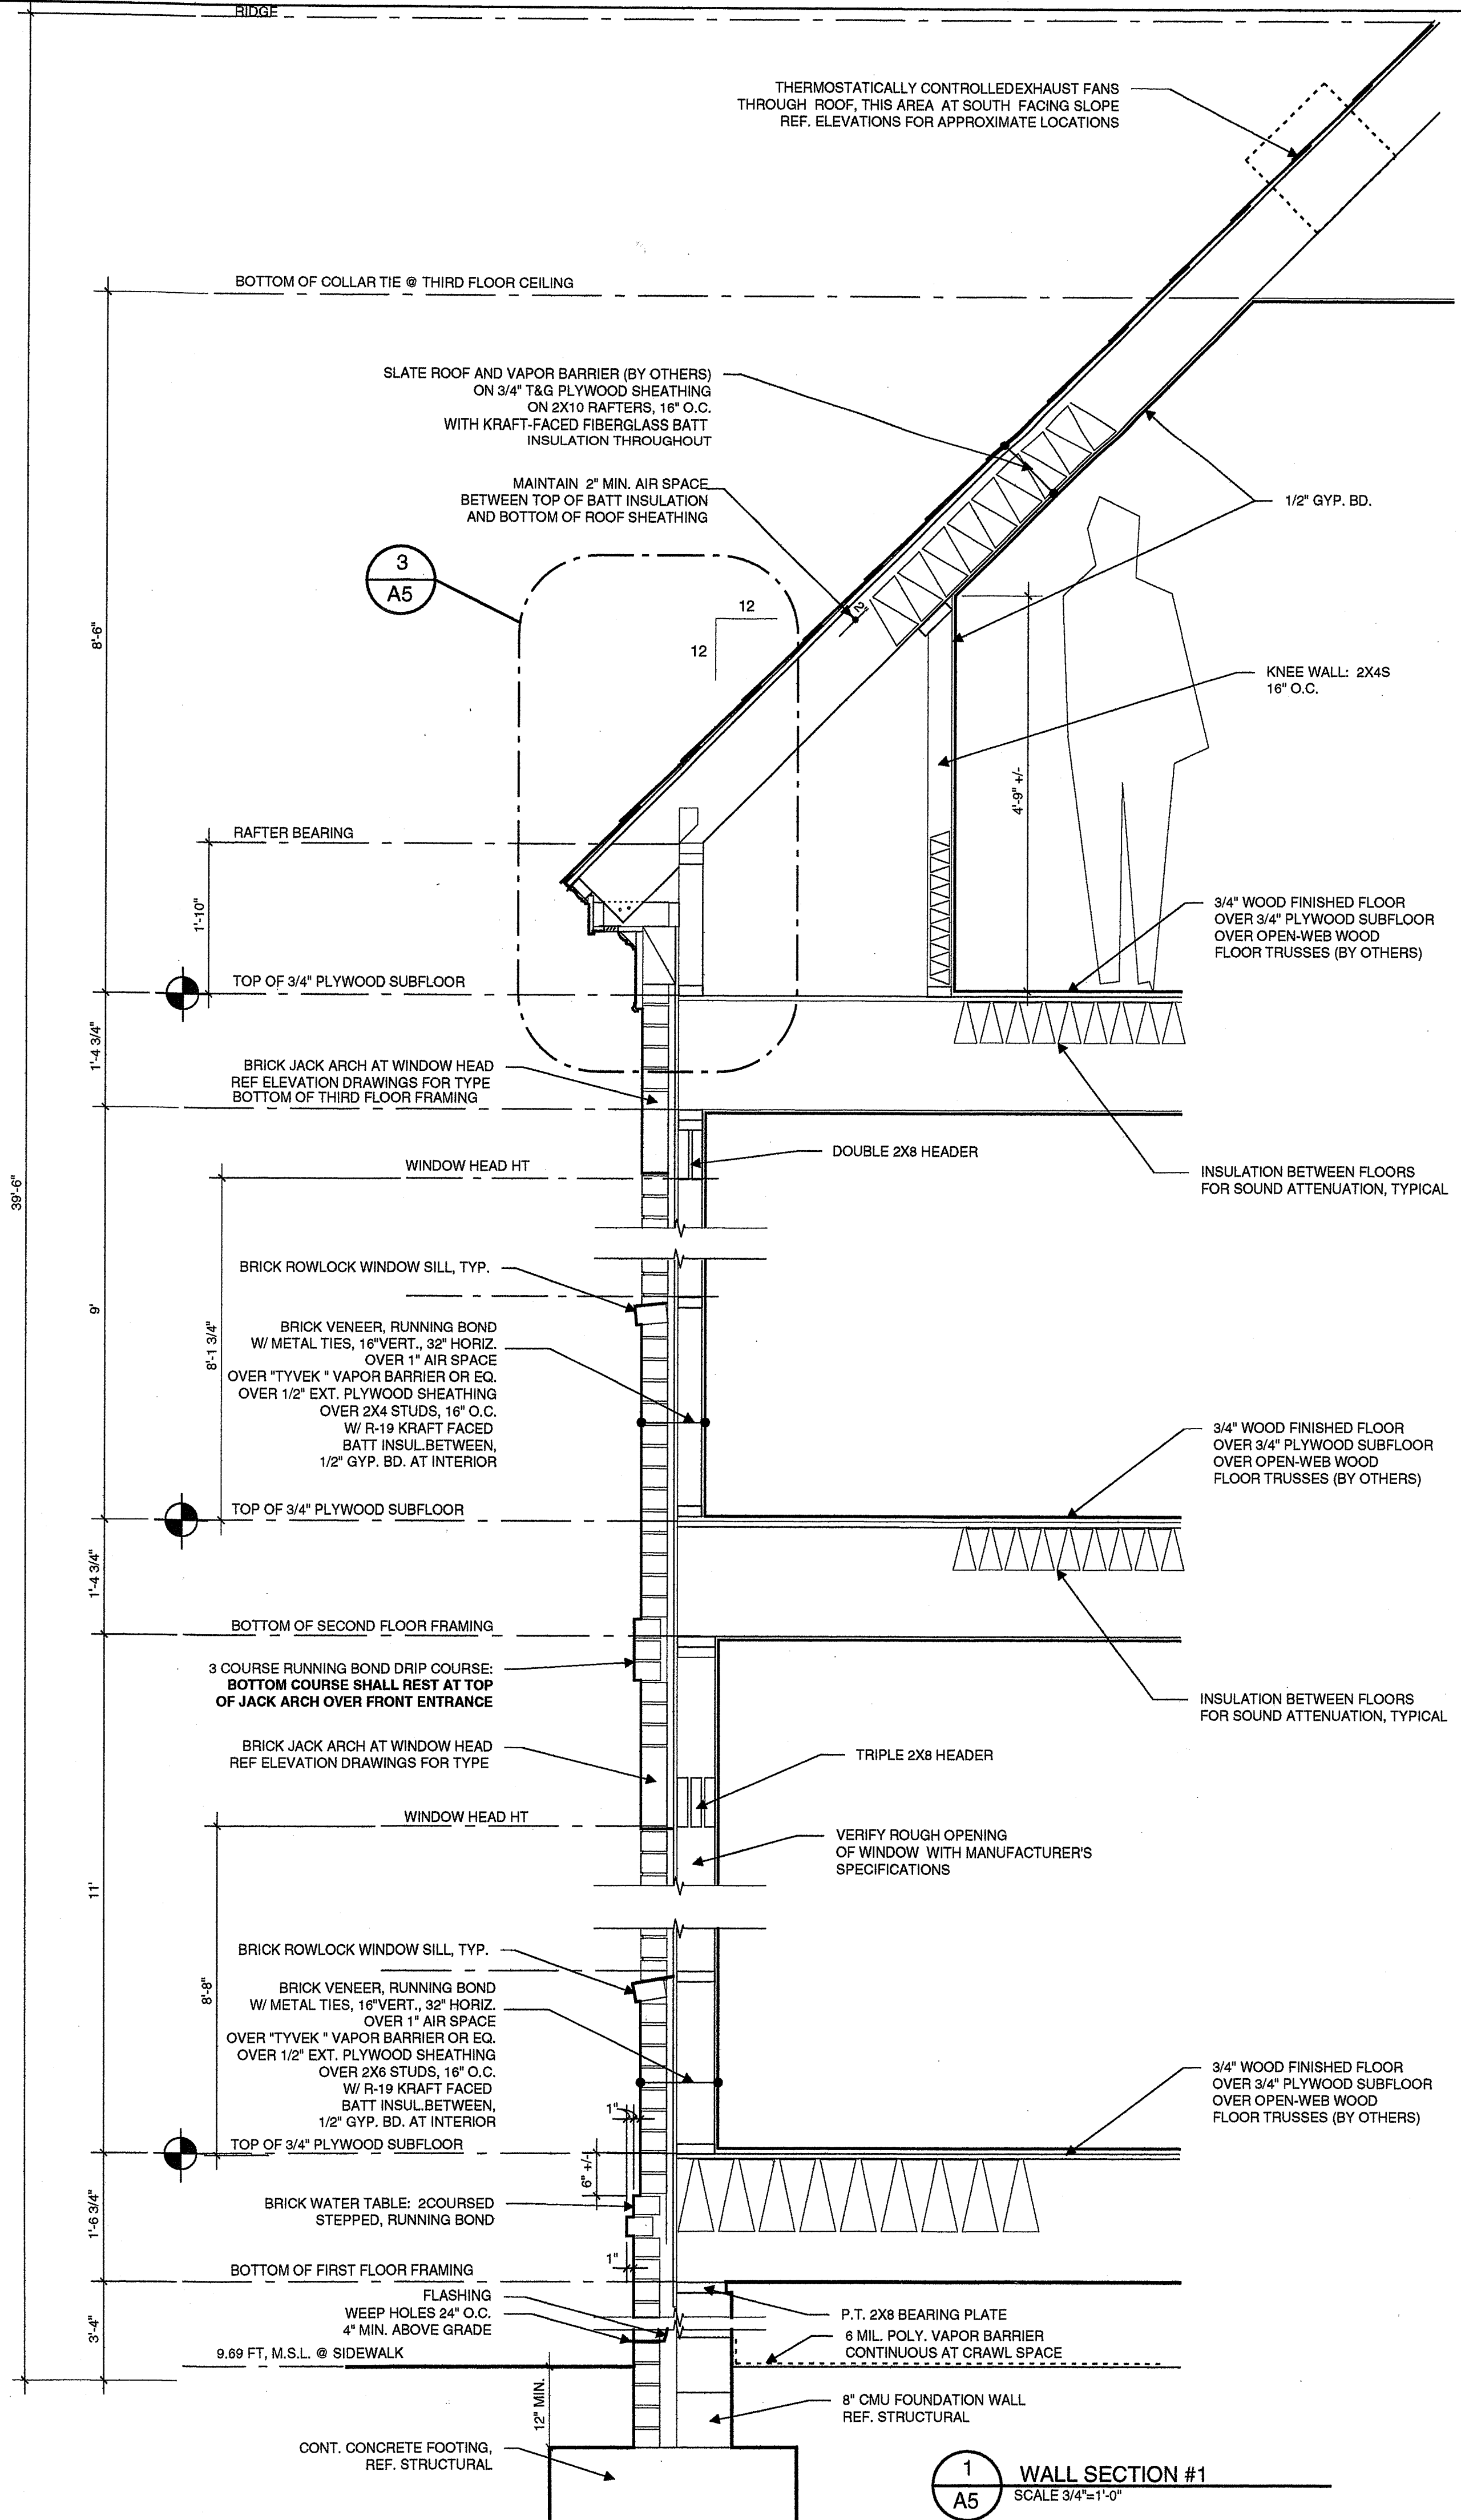

Dufford / Young Architects

143 Wentworth Street
Charleston, SC 29401
803 577 0737

MOORE RESIDENCE
Wraggborough Square
Charleston, South Carolina

 
date
11/10/97

drawn
JLY/PHD

comm. no.

revisions

WALL SECTIONS A5




Architectural cross-section drawing of a window assembly, showing exterior and interior details. The drawing includes the following components and labels:

- VER (TIED 16" VERT. Z., WEEP HOLES 24" O.C.), SPACE
- ON 1/2" EXT. PLYWOOD SHEATHING
- UDS, 16" O.C.
- FT FACED BATT INSULATION HED WITH 1/2" GYP. BD.
- FINISHED FIRST FLOOR
- WOOD FLOOR TRUSSES BY OTHERS
- TREATED SILL PLATE, REF. WALL SECTION
- 6" CMU BOND BEAM
- BOTTOM OF FLOOR FRAMING
- THREE COURSE BRICK JACK ARCH (RICHTEX AR1)
- FLASHING
- RUNNING BOND WATER TABLE
- 2" C
- 1"
- 3"
- TREATED 1X2 AT HEAD AND JAMBS
- 5/4X4 TREATED WOOD LOUVERS @ 45 degrees
- P.T. 5/4X6 SILL, SLOPED
- ROWLOCK SILL
- INSECT SCREEN
- TREATED 2X6 FRAME AT HEAD AND JAMBS. ANCHOR TO CMU
- P.T. 2X4 BLOCKING
- 1-9" +/-
- 2'-0" M. O.

FOUNDATION VENT SECTION
SCALE: 1 1/2"=1'-0"



6 FOUNDATION VENT. DETAILS
A6

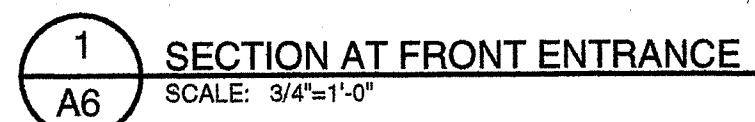


SECTION / DETAILS A6


FINISH SCHEDULE									
NO.	ROOM NAME	FLOOR	BASE	WALLS		CEILING			REMARKS
				MAT'L	FINISH	MAT'L	FINISH	HT.	
01	STORAGE	CONCRETE	WOOD/PT	PLYWD	PAINT	GWB	PAINT	VARIES	*SEE NOTE BELOW
101	LIVING ROOM	WOOD	WOOD/PT	GWB	PAINT	GWB	PAINT	11'-0"	
102	FOYER	WOOD	WOOD/PT	GWB	PAINT	GWB	PAINT	11'-0"	
103	DINING ROOM	WOOD	WOOD/PT	GWB	PAINT	GWB	PAINT	11'-0"	
104	BREAKFAST ROOM	WOOD	WOOD/PT	GWB	PAINT	GWB	PAINT	10'-0"	
105	KITCHEN	WOOD	WOOD/PT	GWB	PAINT	GWB	PAINT	10'-0"	
106	FIRST FLOOR REAR HALL	WOOD	WOOD/PT	GWB	PAINT	GWB	PAINT	10'-0"	
106A	PANTRY	WOOD	WOOD/PT	GWB	PAINT	GWB	PAINT	10'-0"	
106B	STORAGE	WOOD	WOOD/PT	GWB	PAINT	GWB	PAINT	10'-0"	
107	FIRST FLOOR BATH	TILE	TILE	GWB/TILE	PAINT	GWB	PAINT	10'-0"	
108	MULTI-PURPOSE ROOM	WOOD	WOOD/PT	GWB	PAINT	GWB	PAINT	10'-0"	
201	BEDROOM #2	WOOD	WOOD/PT	GWB	PAINT	GWB	PAINT	9'-0"	
201A	CLOSET	WOOD	WOOD/PT	GWB	PAINT	GWB	PAINT	9'-0"	
202	SECOND FLOOR BATHROOM	WOOD/TILE***	WOOD/PT	GWB	PAINT	GWB	PAINT	9'-0"	***TILE FLOOR AND BASE IN SHOWER/TOILET RM ONLY
203	STAIR HALL	WOOD	WOOD/PT	GWB	PAINT	GWB	PAINT	9'-0"	
204	FAMILY ROOM	WOOD	WOOD/PT	GWB	PAINT	GWB	PAINT	9'-0"	
205	HALL TO MASTER BEDROOM	WOOD	WOOD/PT	GWB	PAINT	GWB	PAINT	9'-0"	
206	LAUNDRY	TILE	TILE	GWB	PAINT	GWB	PAINT	9'-0"	PROVIDE PAN & F.D.
207	MASTER BATH	WOOD	WOOD/PT	GWB	PAINT	GWB	PAINT	9'-0"	
208	STUDY	WOOD	WOOD/PT	GWB	PAINT	GWB	PAINT	9'-0"	
209	MASTER BEDROOM	WOOD	WOOD/PT	GWB	PAINT	GWB	PAINT	9'-0"	
209A	CLOSET	WOOD	WOOD/PT	GWB	PAINT	GWB	PAINT	9'-0"	
209B	CLOSET	WOOD	WOOD/PT	GWB	PAINT	GWB	PAINT	9'-0"	
301	BEDROOM #3	WOOD	WOOD/PT	GWB	PAINT	GWB	PAINT	8'-6"	
301A	CLOSET	WOOD	WOOD/PT	GWB	PAINT	GWB	PAINT	8'-6"	
302	STAIR HALL	WOOD	WOOD/PT	GWB	PAINT	GWB	PAINT	8'-6"	
303	THIRD FLOOR BATH	TILE	TILE	GWB/TILE	PAINT	GWB	PAINT	8'-6"	
304	BEDROOM #4	WOOD	WOOD/PT	GWB	PAINT	GWB	PAINT	8'-6"	
304A	CLOSET	WOOD	WOOD/PT	GWB	PAINT	GWB	PAINT	8'-6"	
305	STORAGE	VINYL	WOOD/PT	GWB	PAINT	GWB	PAINT	7'-0"±	

* STORAGE ROOM 01- PLYWOOD TO BE EXTERIOR GRADE. ALL FRAMING AND TRIM TO BE PRESSURE TREATED. PROVIDE HYDROSTATIC VENTS AS REQ.


** ALL CEILINGS WITH SMOOTH PAINTED FINISH

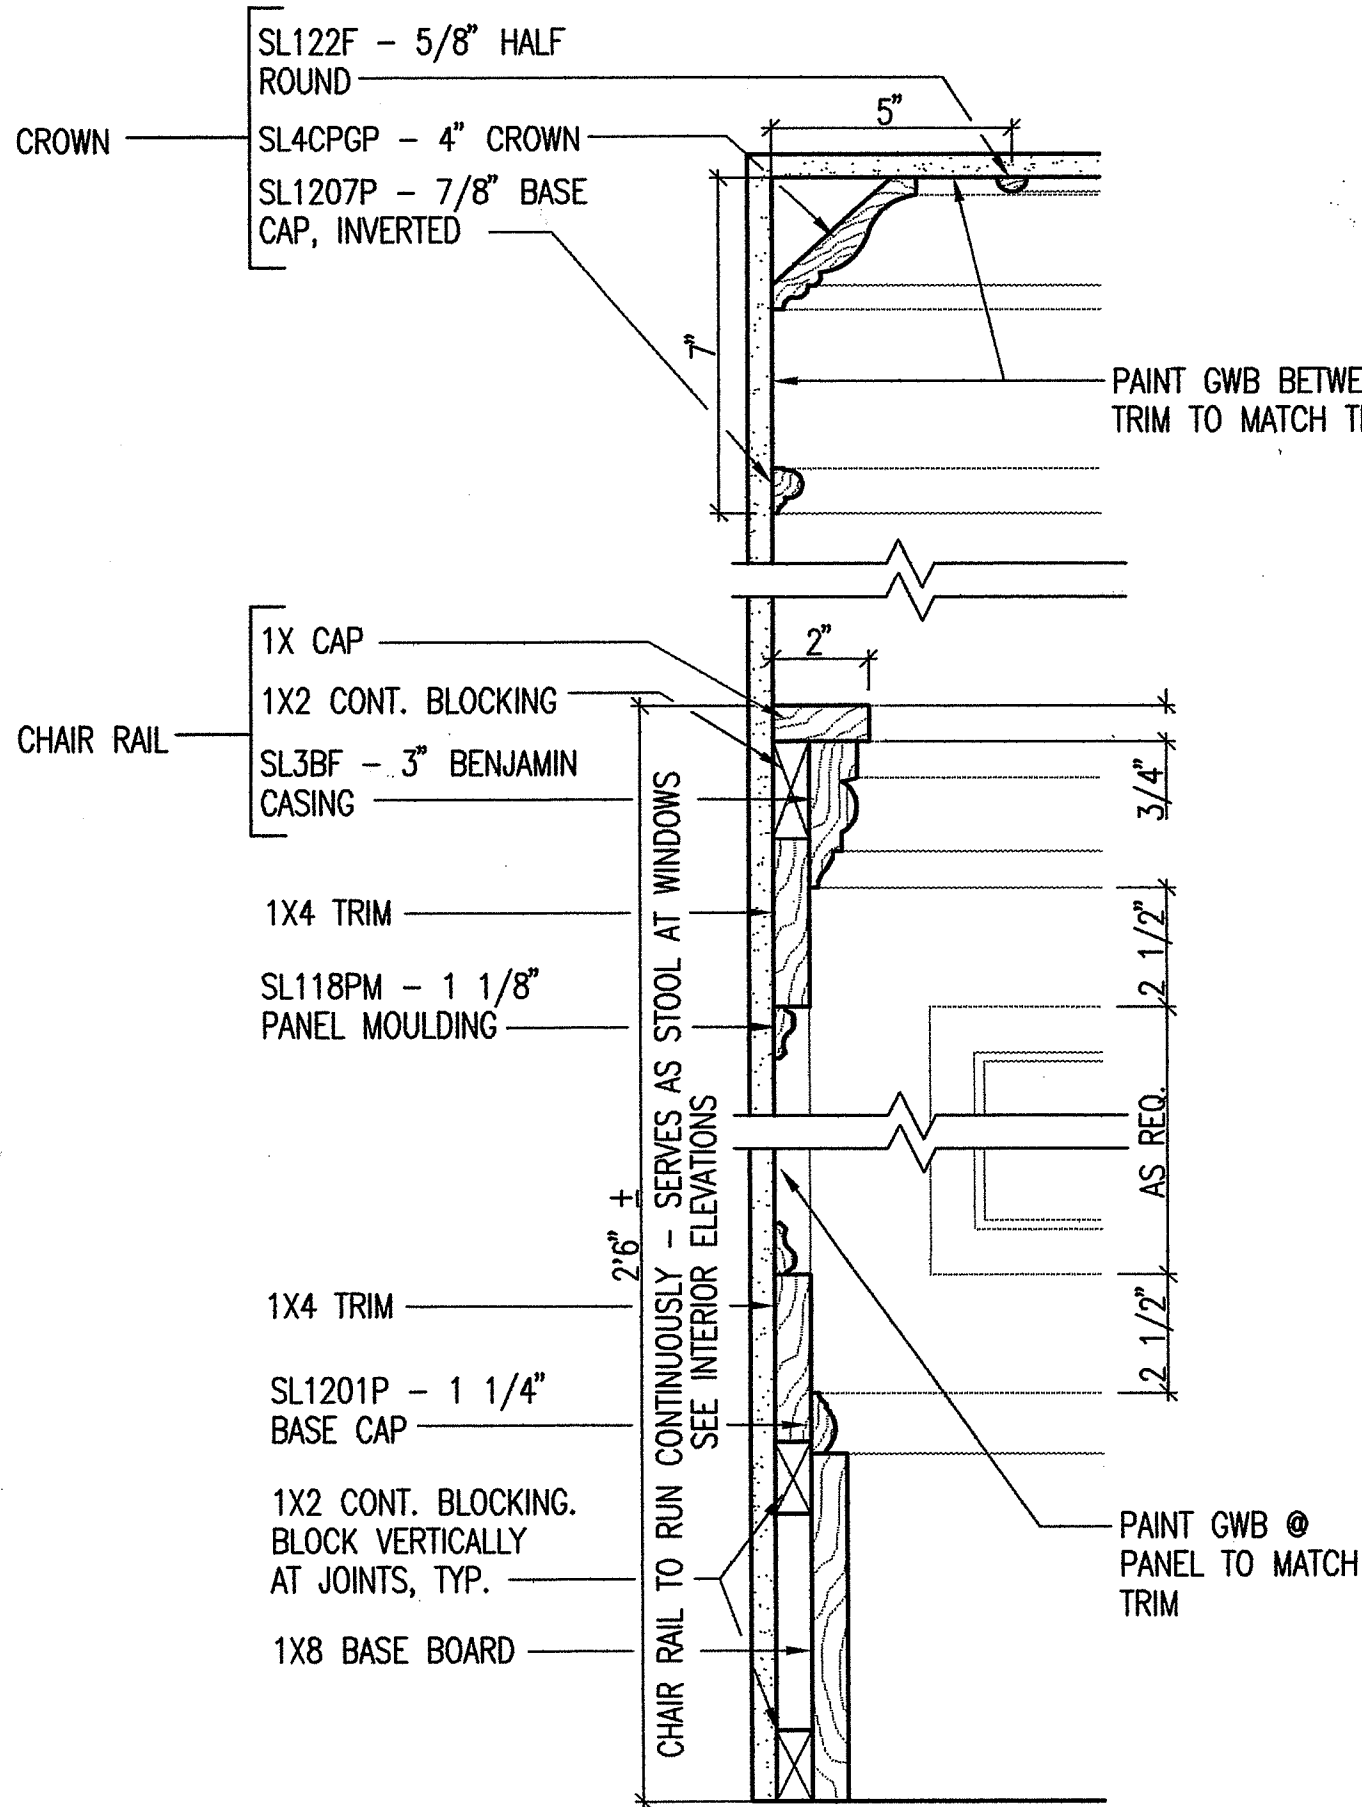

1 TRIM DETAILS- LIVING & DINING ROOMS
A7 3" = 1'-0" BASEBOARDS AND CROWN AT ENTRY/STAIR HALL TO MATCH LIVING/DINING ROOMS. (ALL TRIM #'S ARE SOUTHERN LUMBER)

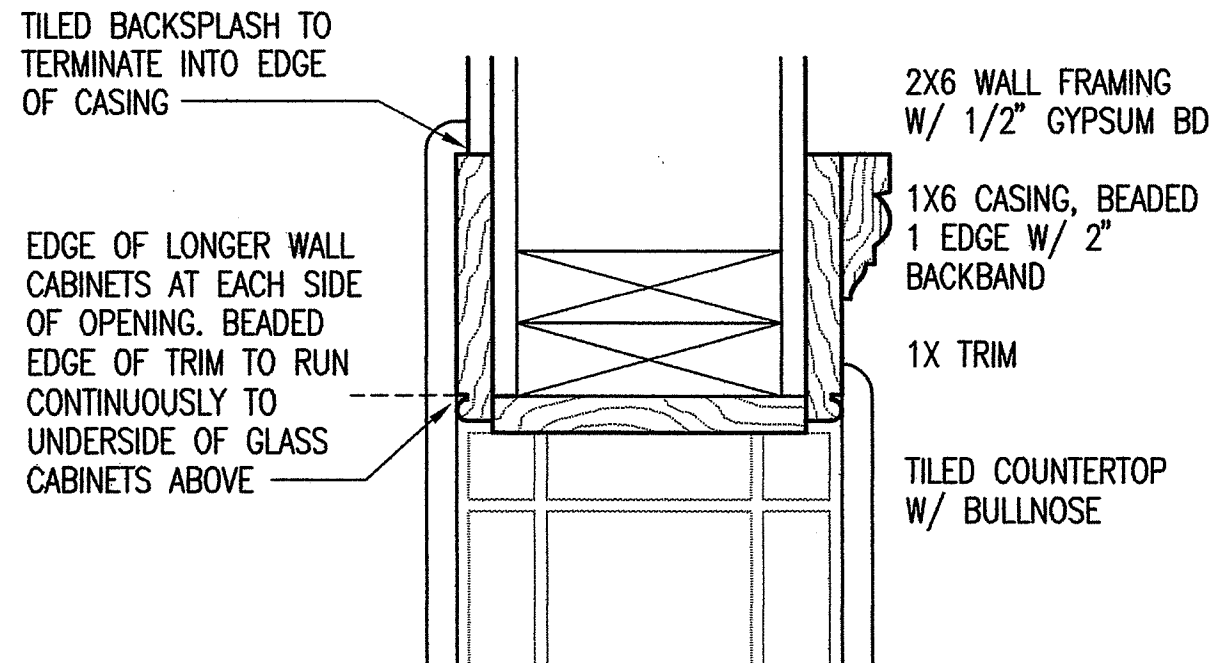

JAMB/PLAN DTL.

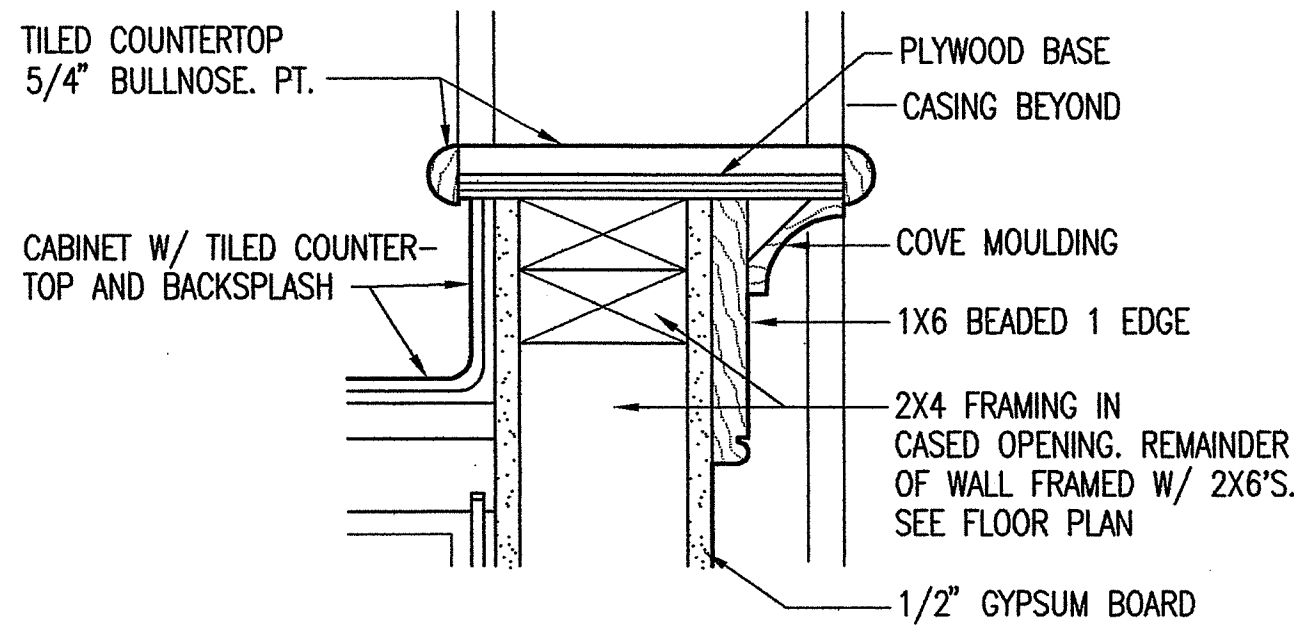

SECTION

2 DETAILS- PASS-THRU AT KITCHEN
A7 3" = 1'-0"

WINDOW SCHEDULE				
NO.	SIZE (ROUGH OPENING)	TYPE	MANUFACT.	DESCRIPTION
A	2'-10 1/8" X 6'-5 1/4"	SINGLE	ANDERSON	NARROLINE DOUBLE HUNG, #2862 9/9 LITE CONFIGURATION (8'-8" HD. HT.)
B	2'-10 1/8" X 7'-10 1/4"±	SINGLE	ANDERSON	CUSTOM SINGLE HUNG WINDOW W/ ARCHED TOP SASH. TRUE DIVIDED LITE. SEE ELEVATIONS FOR LITE DIVISION. MANU. SHOP DWGS TO BE SUBMITTED PRIOR TO FRAMING AND INSTALLATION (4'-9" HD. HT. ABOVE SECOND FLOOR)
C	2'-10 1/8" X 5'-5 1/4"	SINGLE	ANDERSON	NARROLINE DOUBLE HUNG, #2852 6/6 LITE CONFIGURATION (8'-0" HD. HT.)
D	2'-10 1/8" X 5'-5 1/4"	SINGLE	ANDERSON	NARROLINE DOUBLE HUNG, #2852 6/6 LITE CONFIGURATION (9'-2" HD. HT.)
E	2'-6 1/8" X 7'-2 5/8"	SINGLE	ANDERSON	COMBINATION UNIT *
F	2'-10 1/8" X 7'-2 5/8"	SINGLE	ANDERSON	COMBINATION UNIT **
G	2'-10 1/8" X 5'-5 1/4"	SINGLE	ANDERSON	NARROLINE DOUBLE HUNG, #2852 6/6 LITE CONFIGURATION (8'-1 3/4" HD. HT.)
H	2'-10 1/8" X 5'-5 1/4"	SINGLE	ANDERSON	NARROLINE DOUBLE HUNG, #2852 6/6 LITE CONFIGURATION (7'-10" HD. HT.)
I	2'-2 1/8" X 2'-5 7/8"	SINGLE	ANDERSON	TRANSOM #DHT2023 4 LITE CONFIGURATION (8'-1 3/4" HD. HT.)
J	2'-2 1/8" X 2'-5 7/8"	SINGLE	ANDERSON	TRANSOM #DHT2023 4 LITE CONFIGURATION (7'-10" HD. HT.)
K	2'-2 1/8" X 4'-9 1/4"	SINGLE	ANDERSON	NARROLINE DOUBLE HUNG, #2046 6/6 LITE CONFIGURATION (7'-10" HD. HT.)
L	2'-10 1/8" X 5'-5 1/4"	SINGLE	ANDERSON	NARROLINE DOUBLE HUNG, #2852 6/6 LITE CONFIGURATION (SEE DORMER DTL FOR HD. HT.)
M	2'-10 1/8" X 4'-9 1/4"	SINGLE	ANDERSON	NARROLINE DOUBLE HUNG, #2846 6/6 LITE CONFIGURATION (7'-5" HD. HT.)
N	2'-10 1/8" X 4'-9 1/4"	SINGLE	ANDERSON	NARROLINE DOUBLE HUNG, #2846 6/6 LITE CONFIGURATION (6'-9" HD. HT.)


ALL WINDOWS CLAD WOOD (WHITE FINISH), INSULATED GLASS, SIMULATED DIVIDED LITE (INTERIOR AND EXTERIOR GRILLS) WITH INSECT SCREEN.

*NARROLINE DOUBLE HUNG #DC2446, 6/6 LITE CONFIGURATION, WITH TRANSOM #DHT2423, 6 LITE CONFIGURATION (9'-2" HD. HT.)


**NARROLINE DOUBLE HUNG #DC2846, 6/6 LITE CONFIGURATION, WITH TRANSOM #DHT2823, 6 LITE CONFIGURATION (9'-2" HD. HT.)

DOOR SCHEDULE			
NO.	SIZE	MATERIAL	DESCRIPTION
00	3'0" X 7'0" X 1 3/4"	WOOD	6 PANEL/TRANSOM ABOVE. SEE SHT A6
01	3'0" X 6'8" X 1 3/4"	WOOD	6 PANEL/6 LITE TRANSOM @ HD. HT. 9'-2"
02	3'0" X 6'8" X 1 3/8"	WOOD	6 PANEL *
03	3'0" X 6'8" X 1 3/8"	WOOD	6 PANEL *
04	2'6" X 6'8" X 1 3/8" (PAIR)	WOOD	6 PANEL (POCKET) *
05	2'0" X 6'8" X 1 3/8"	WOOD	6 PANEL
06	2'0" X 6'8" X 1 3/8"	WOOD	6 PANEL
07	3'0" X 6'8" X 1 3/4"	WOOD	6 PANEL
08	2'4" X 6'8" X 1 3/8"	WOOD	6 PANEL
09	2'8" X 6'8" X 1 3/8"	WOOD	6 PANEL
10	3'0" X 6'8" X 1 3/8"	WOOD	6 PANEL (BI-FOLD)
11	2'4" X 6'8" X 1 3/8"	WOOD	6 PANEL
12	2'8" X 6'8" X 1 3/8"	WOOD	6 PANEL
13	2'8" X 6'8" X 1 3/8"	WOOD	6 PANEL
14	2'6" X 6'8" X 1 3/8"	WOOD	6 PANEL (POCKET)
15	3'0" X 6'8" X 1 3/8" (PAIR)	WOOD	6 PANEL (BI-FOLD)
16	2'0" X 6'8" X 1 3/8" (PAIR)	WOOD	6 PANEL (POCKET)
17	2'4" X 6'8" X 1 3/8"	WOOD	6 PANEL
18	2'8" X 6'8" X 1 3/8"	WOOD	6 PANEL
19	2'0" X 6'8" X 1 3/8" (PAIR)	WOOD	6 PANEL
20	2'0" X 6'8" X 1 3/8" (PAIR)	WOOD	6 PANEL
21	2'6" X 6'8" X 1 3/8"	WOOD	6 PANEL
22	2'6" X 6'8" X 1 3/8"	WOOD	SOLID FLUSH DR W/ ANGLED TOP. REF. 3/A9
23	2'4" X 6'8" X 1 3/8"	WOOD	6 PANEL (POCKET)
24	2'6" X 6'8" X 1 3/8"	WOOD	6 PANEL
25	2'6" X 6'8" X 1 3/8"	WOOD	SOLID FLUSH DR W/ ANGLED TOP. REF. 3/A9
26	3'0" X 6'8" X 1 3/4"	WOOD	6 PANEL

* WOOD DOOR WITH TRANSOM HEAD AT 8'-8"

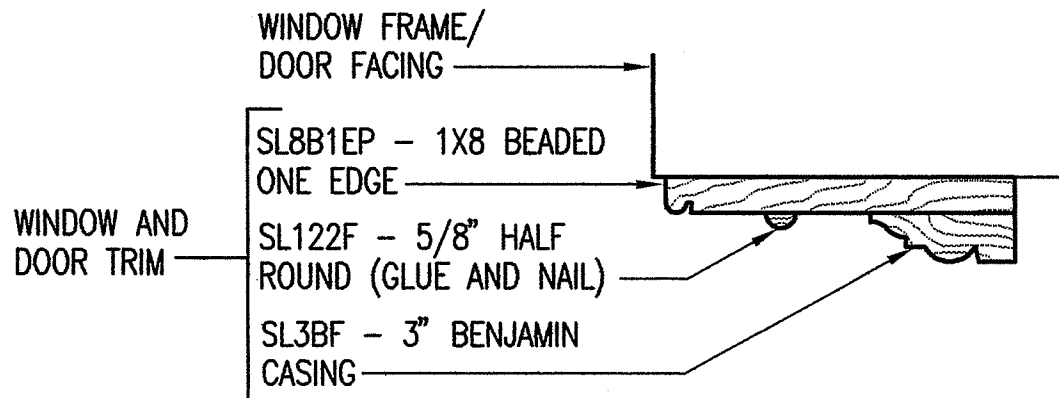


3 DOOR/WINDOW TRIM - FORMAL ROOMS
A7 3" = 1'-0"

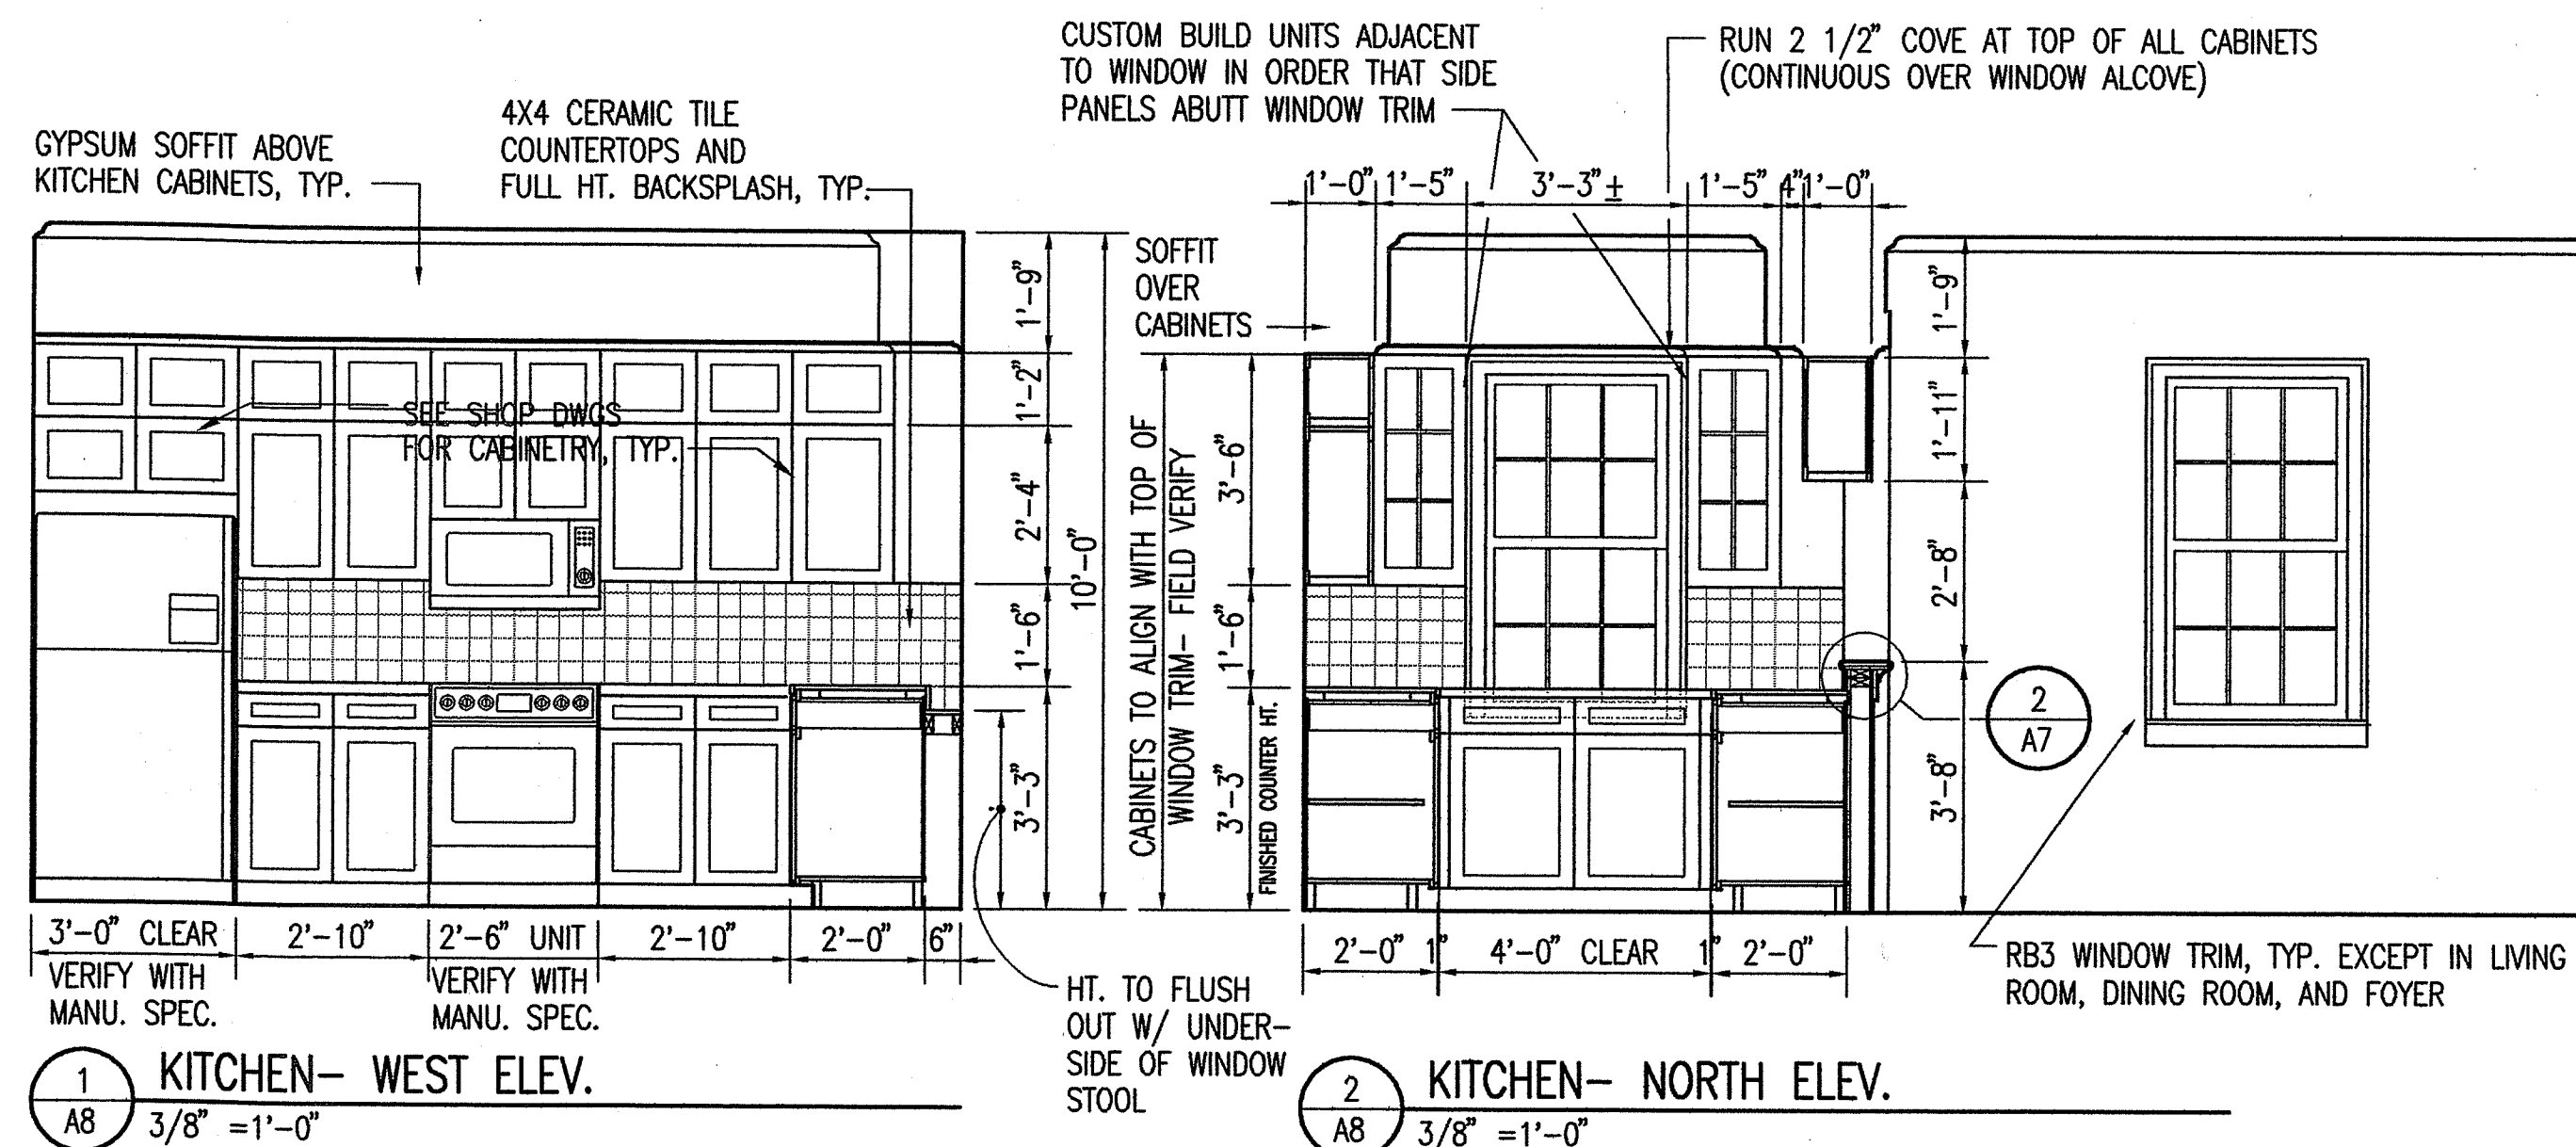










NOTE: COUNTERTOPS TO BE CERAMIC TILE. SET ROUGH CABINETRY COUNTER HT TO ACCOMMODATE TILE AND MORTAR BED.

2 KITCHEN- NORTH ELEV.
 3/8" = 1'-0"

NOTE: COUNTERTOPS TO BE CERAMIC TILE. SET ROUGH CABINETRY COUNTER HT TO ACCOMMODATE TILE AND MORTAR BED.

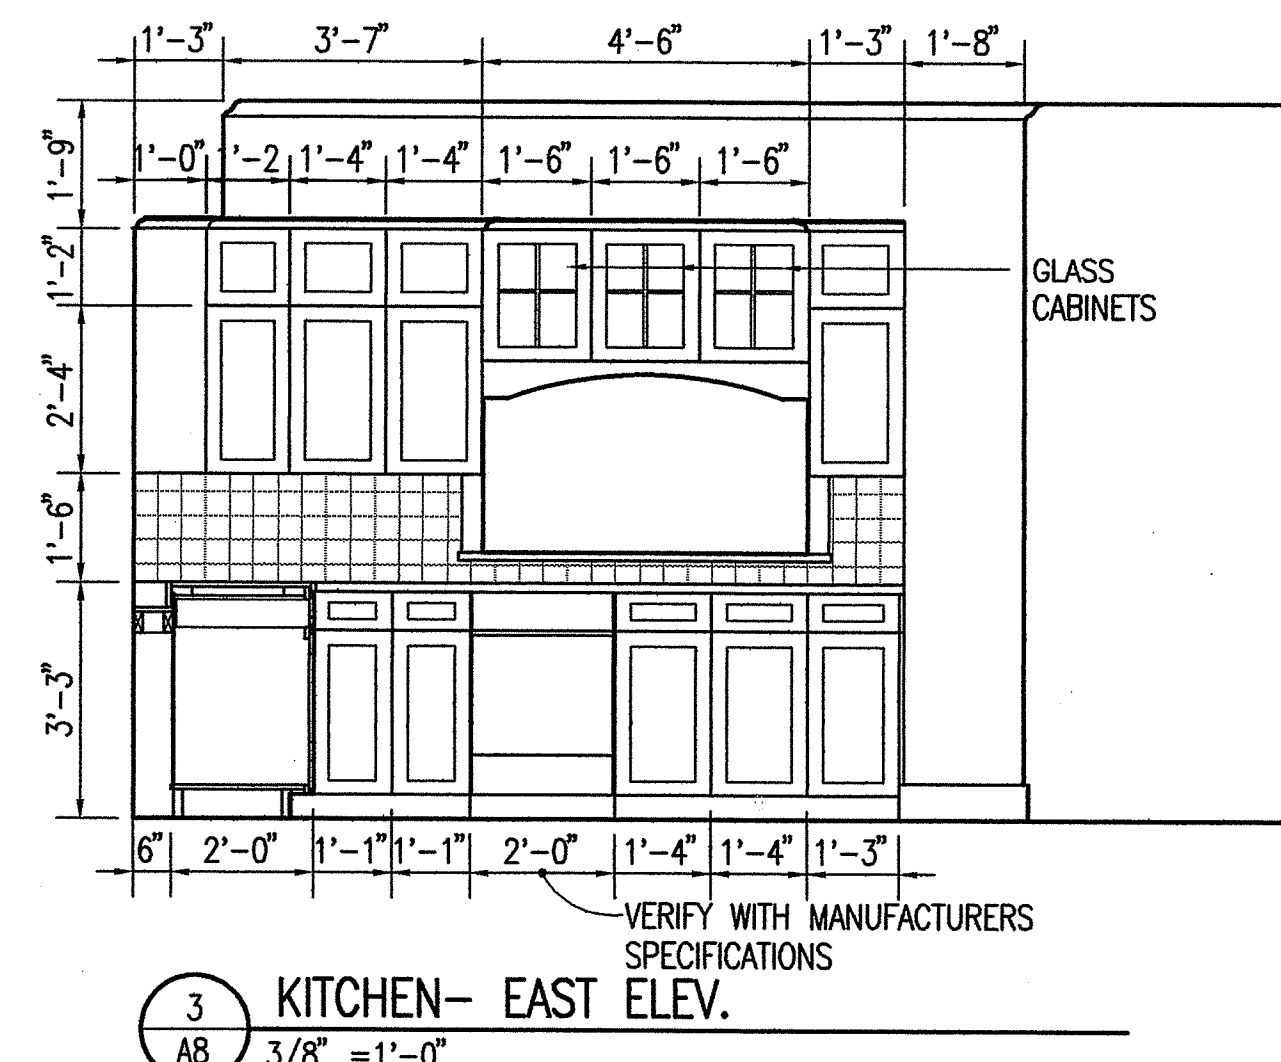

NOTE: COUNTERTOPS TO BE CERAMIC TILE. SET ROUGH CABINETRY COUNTER HT TO ACCOMMODATE TILE AND MORTAR BED.

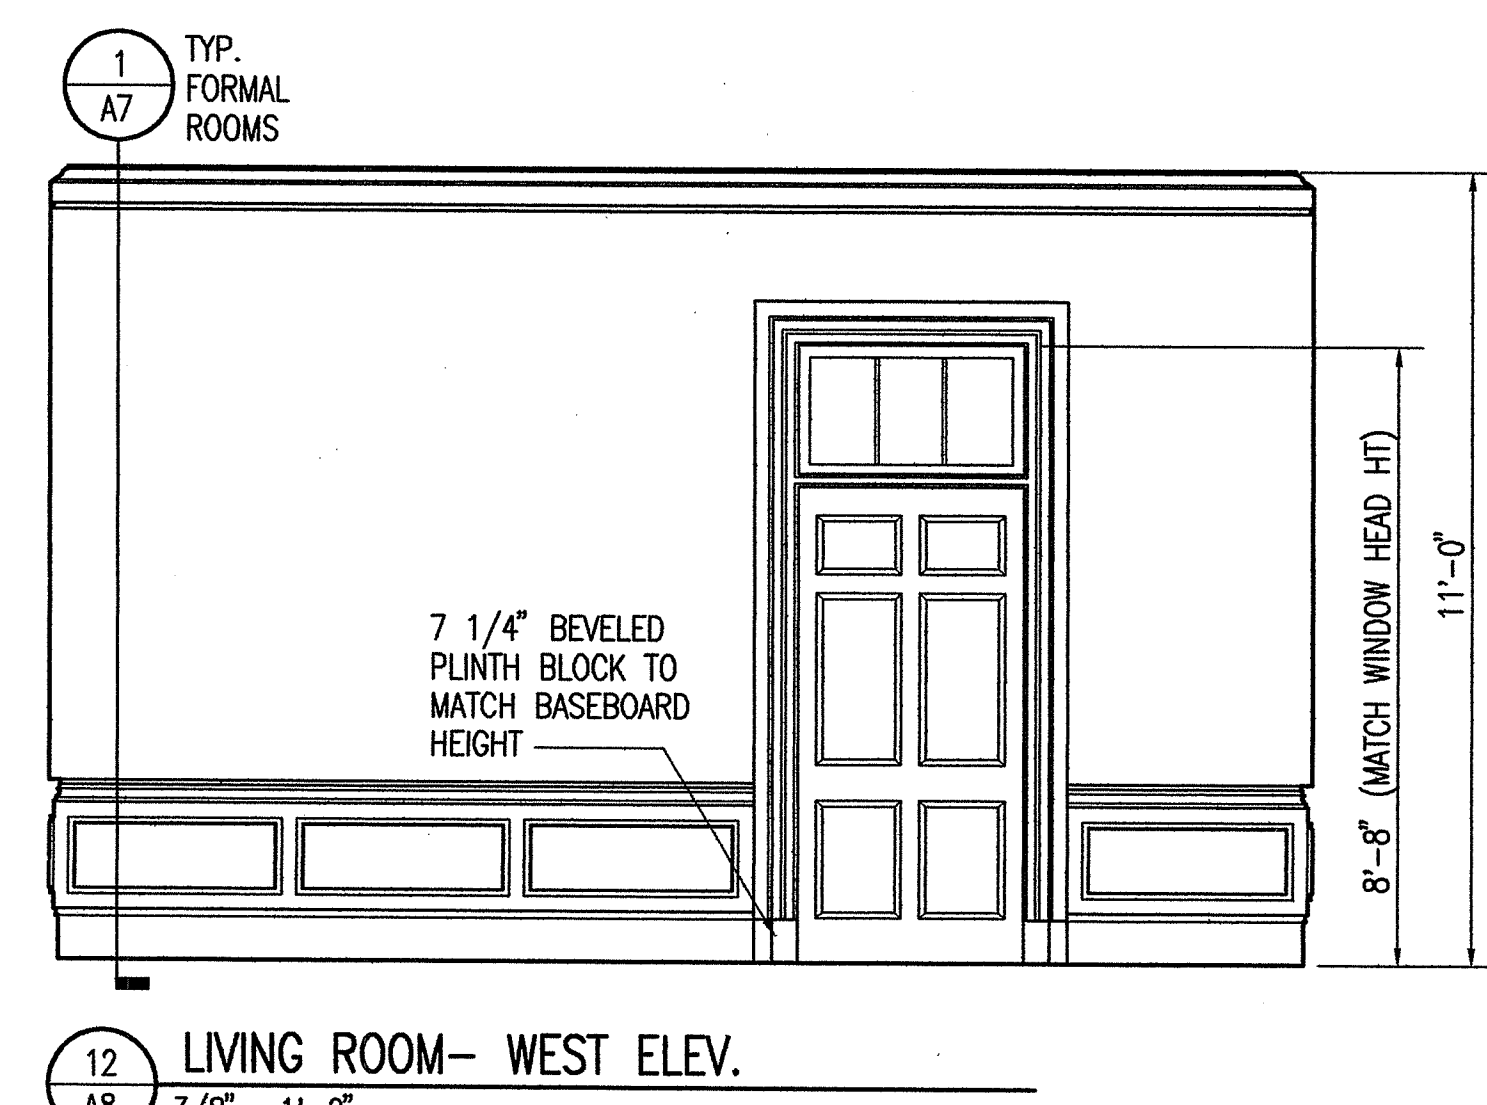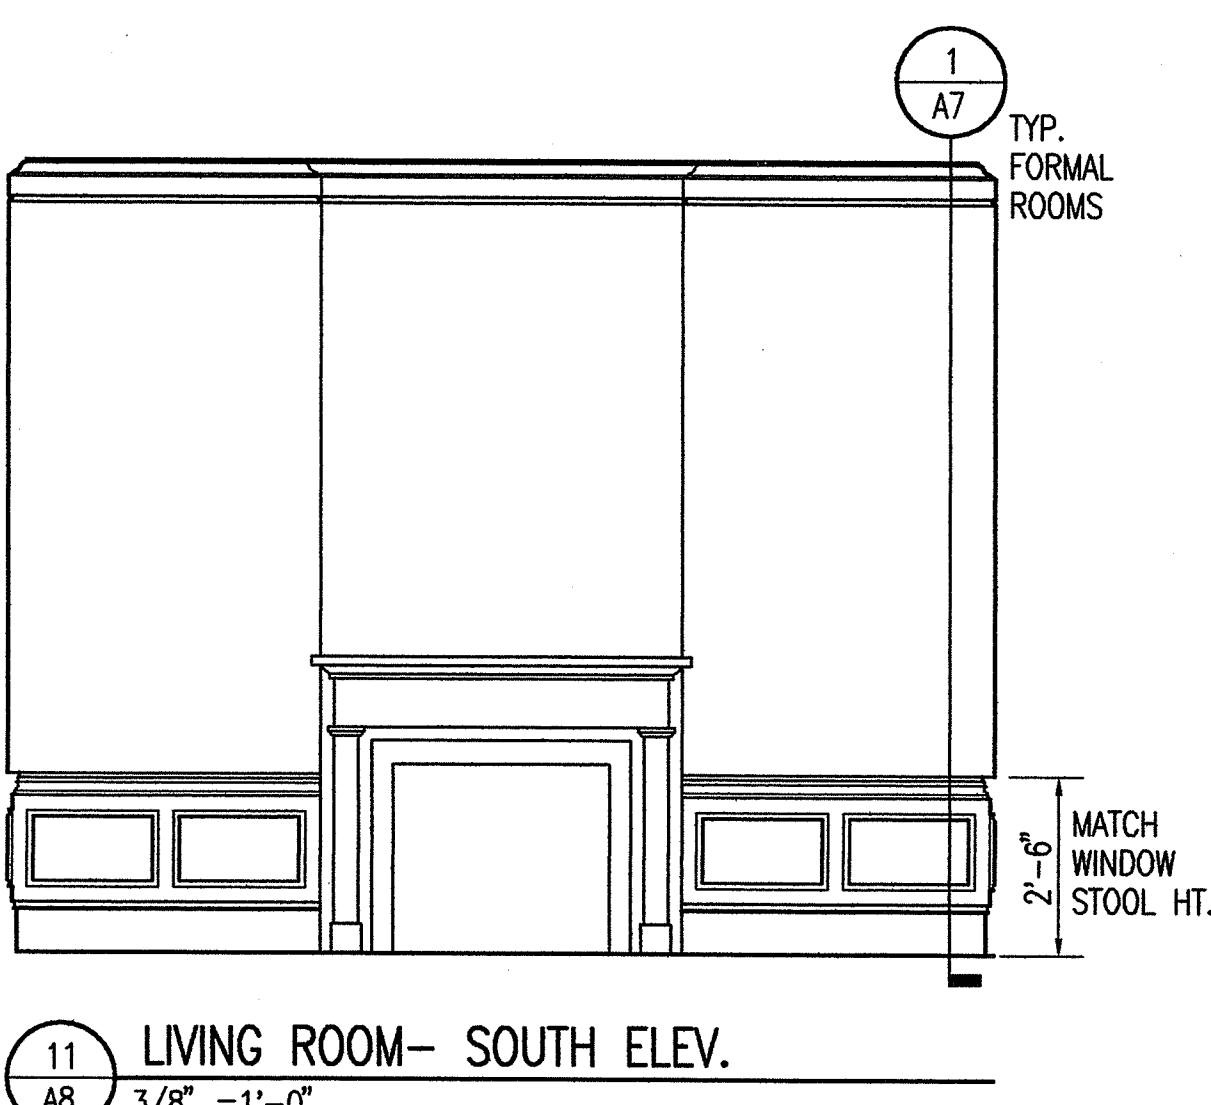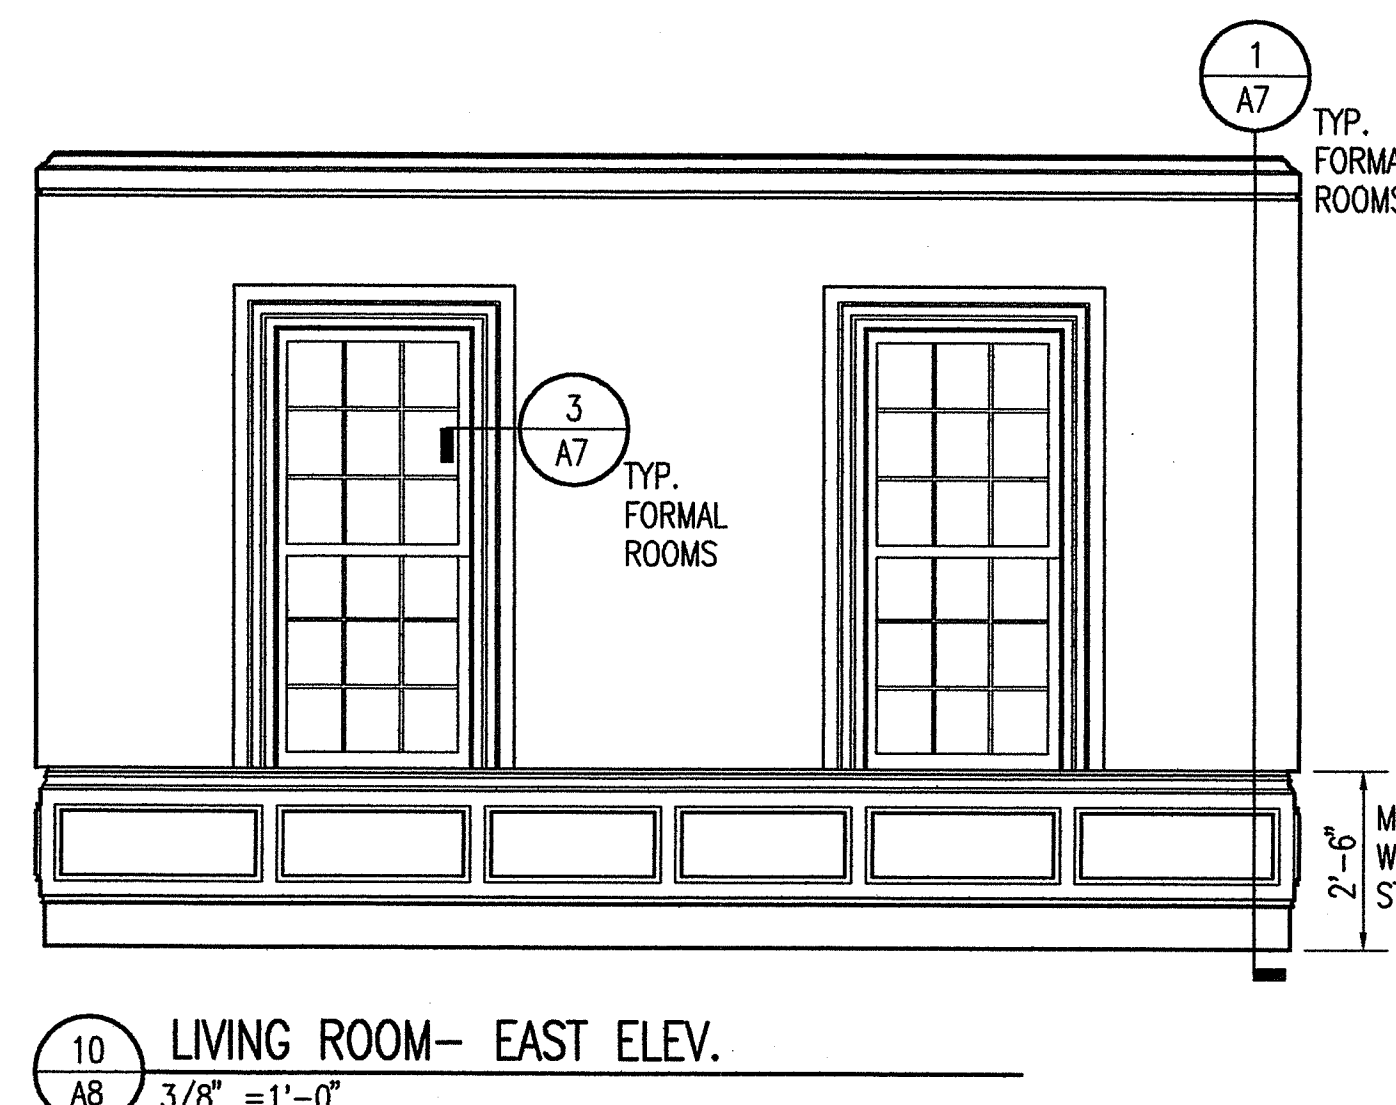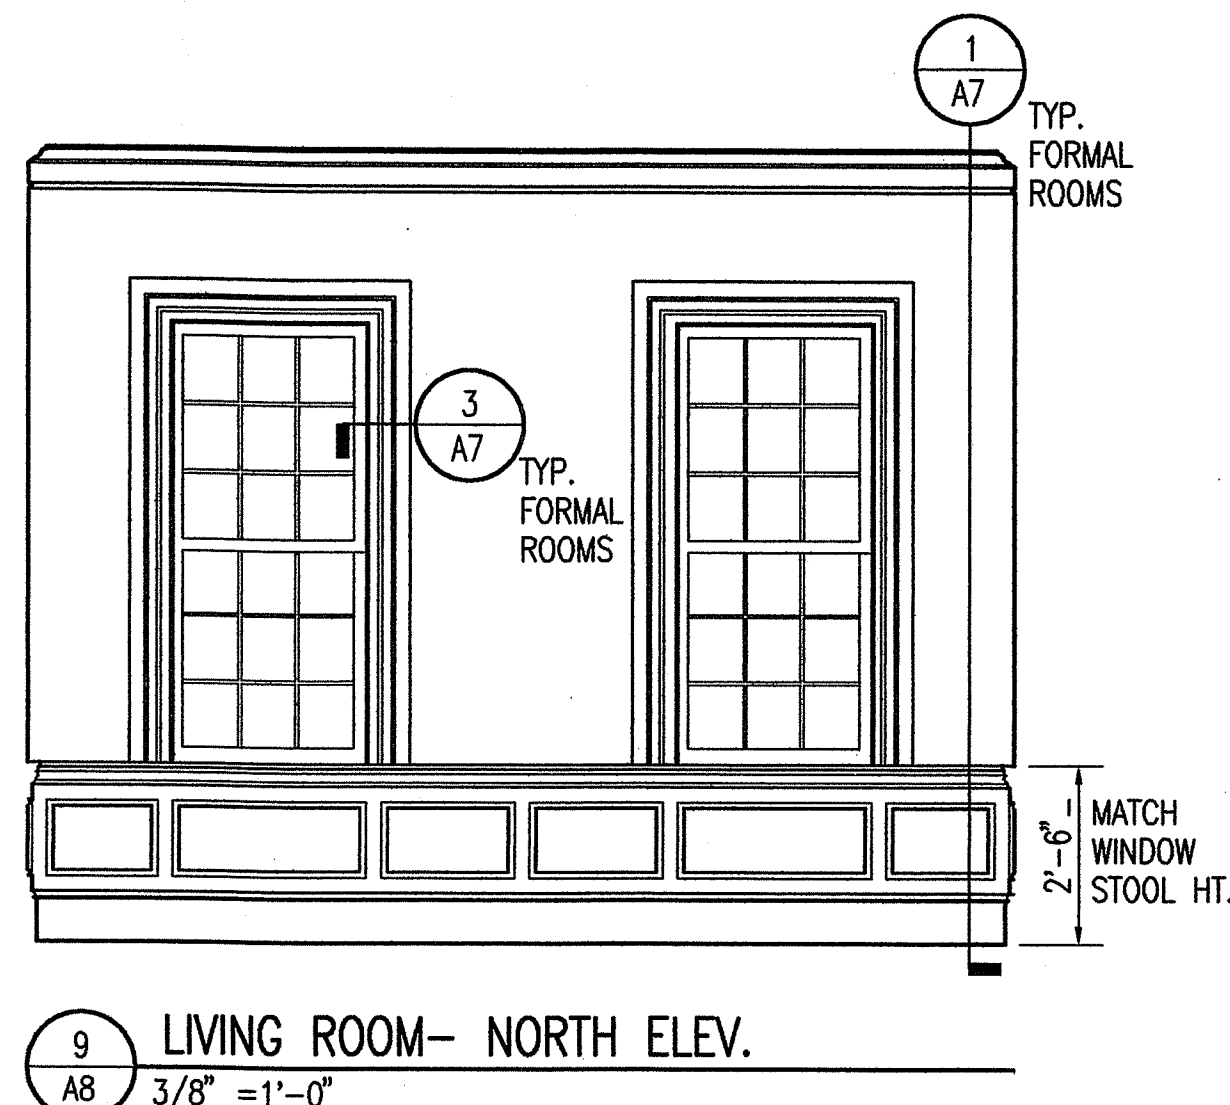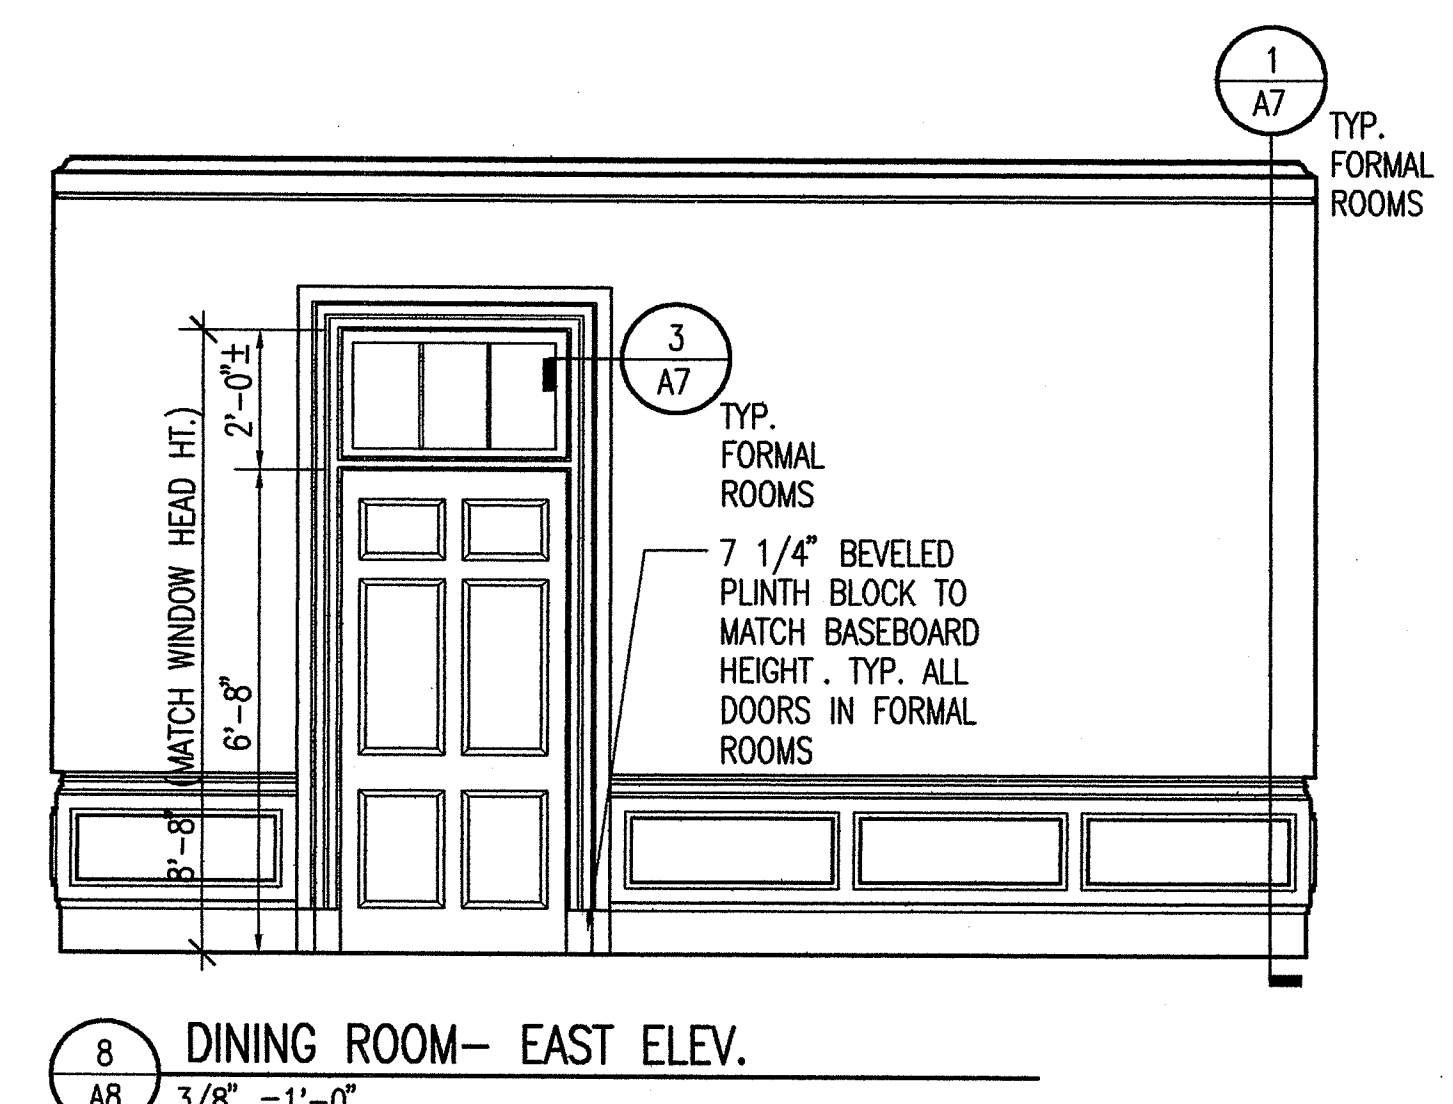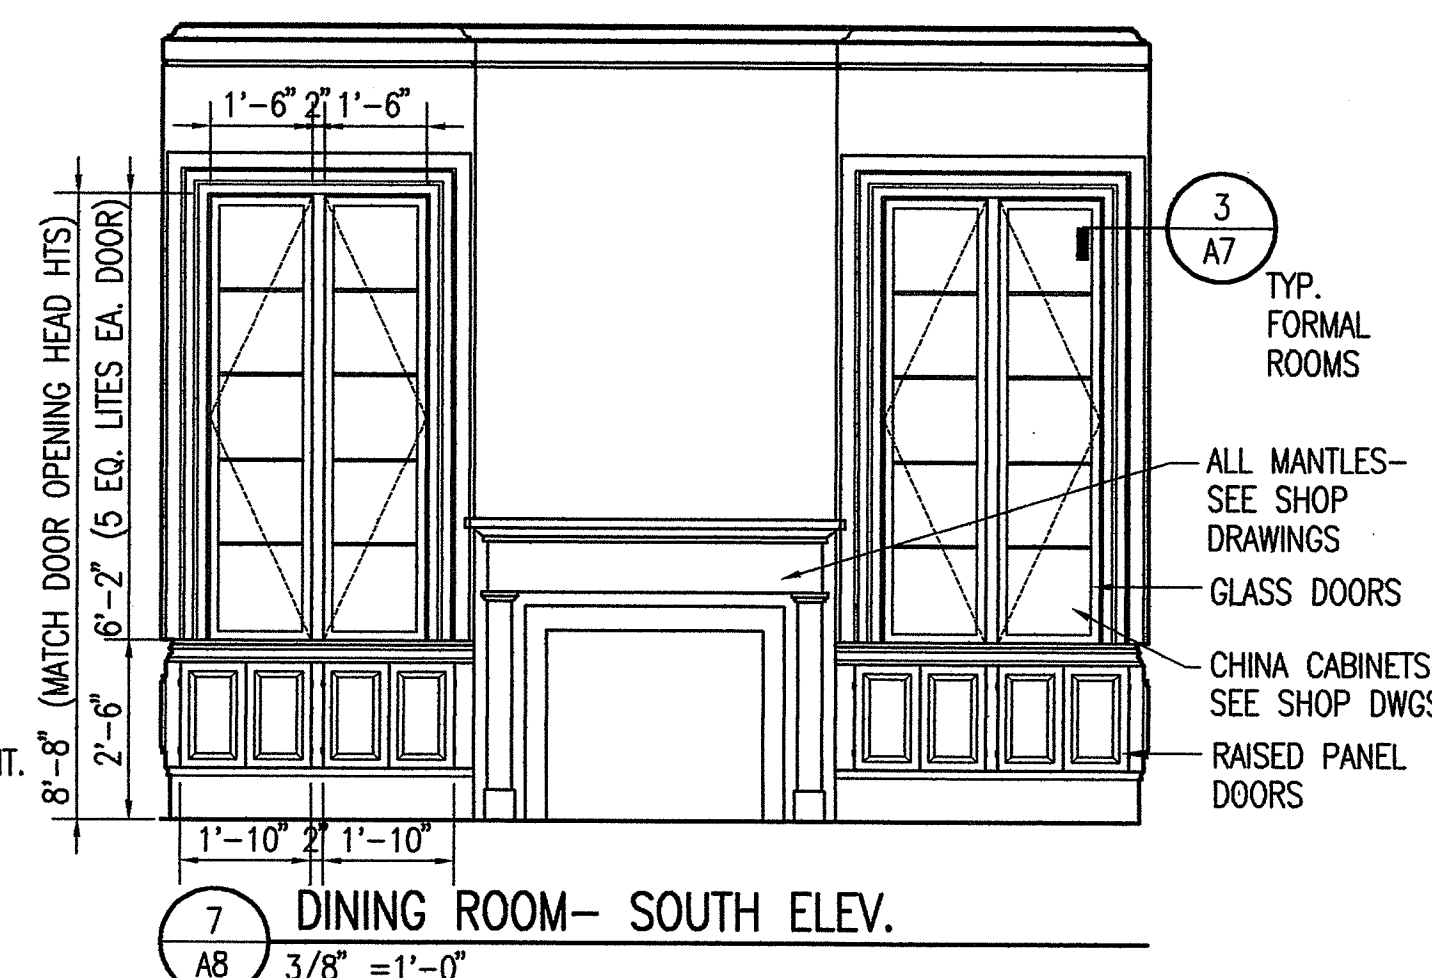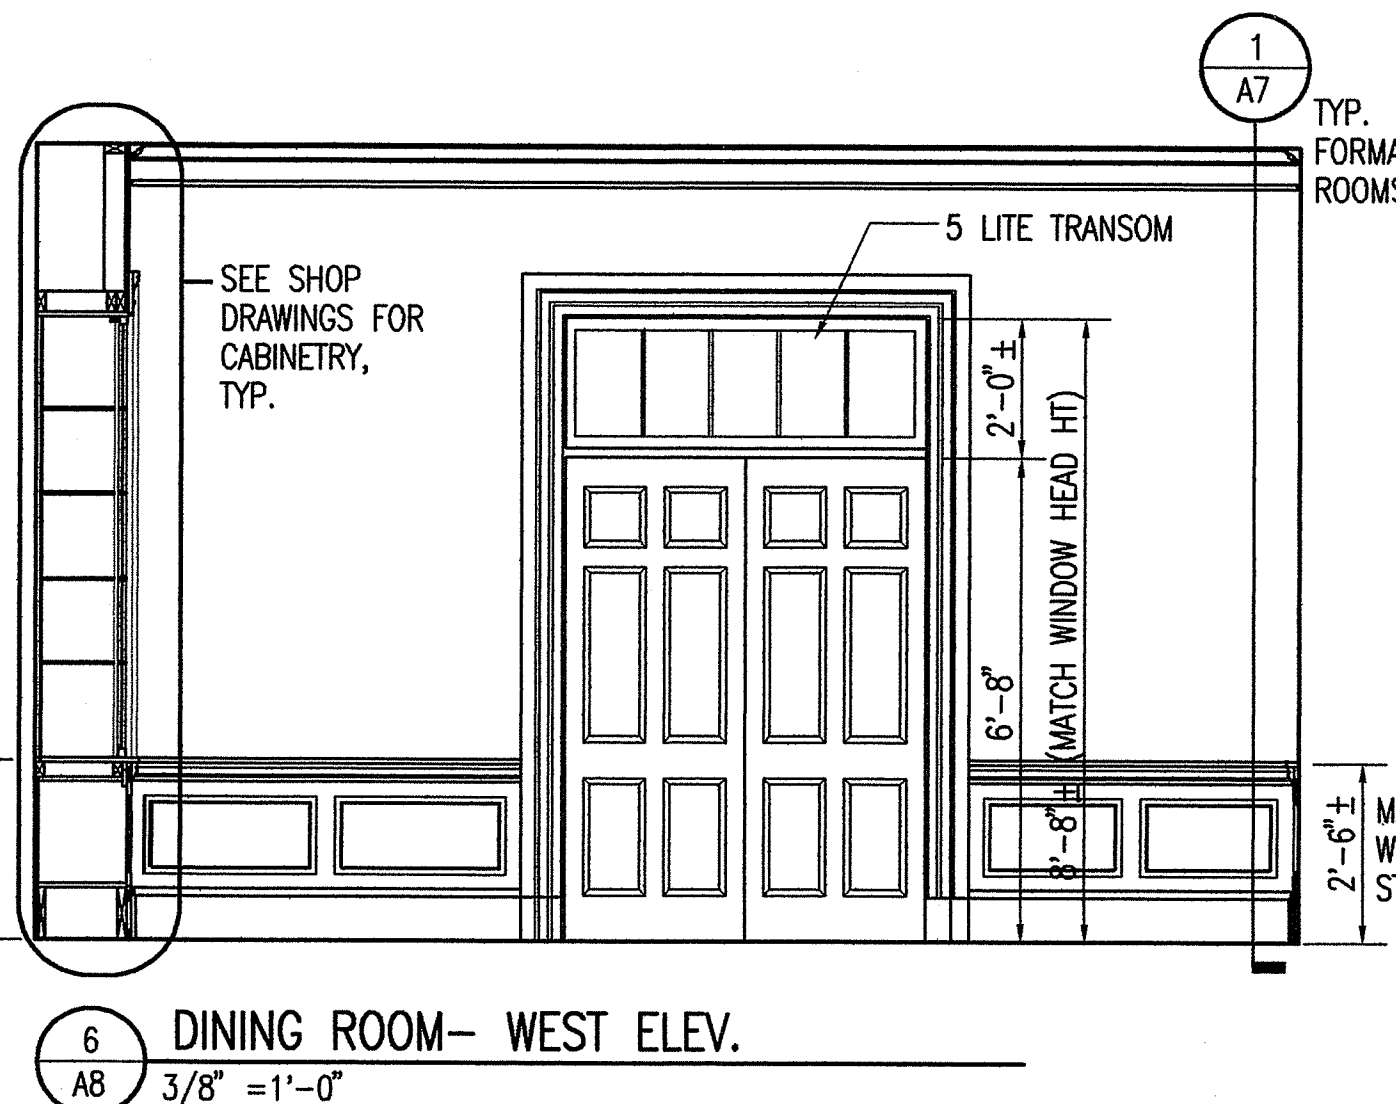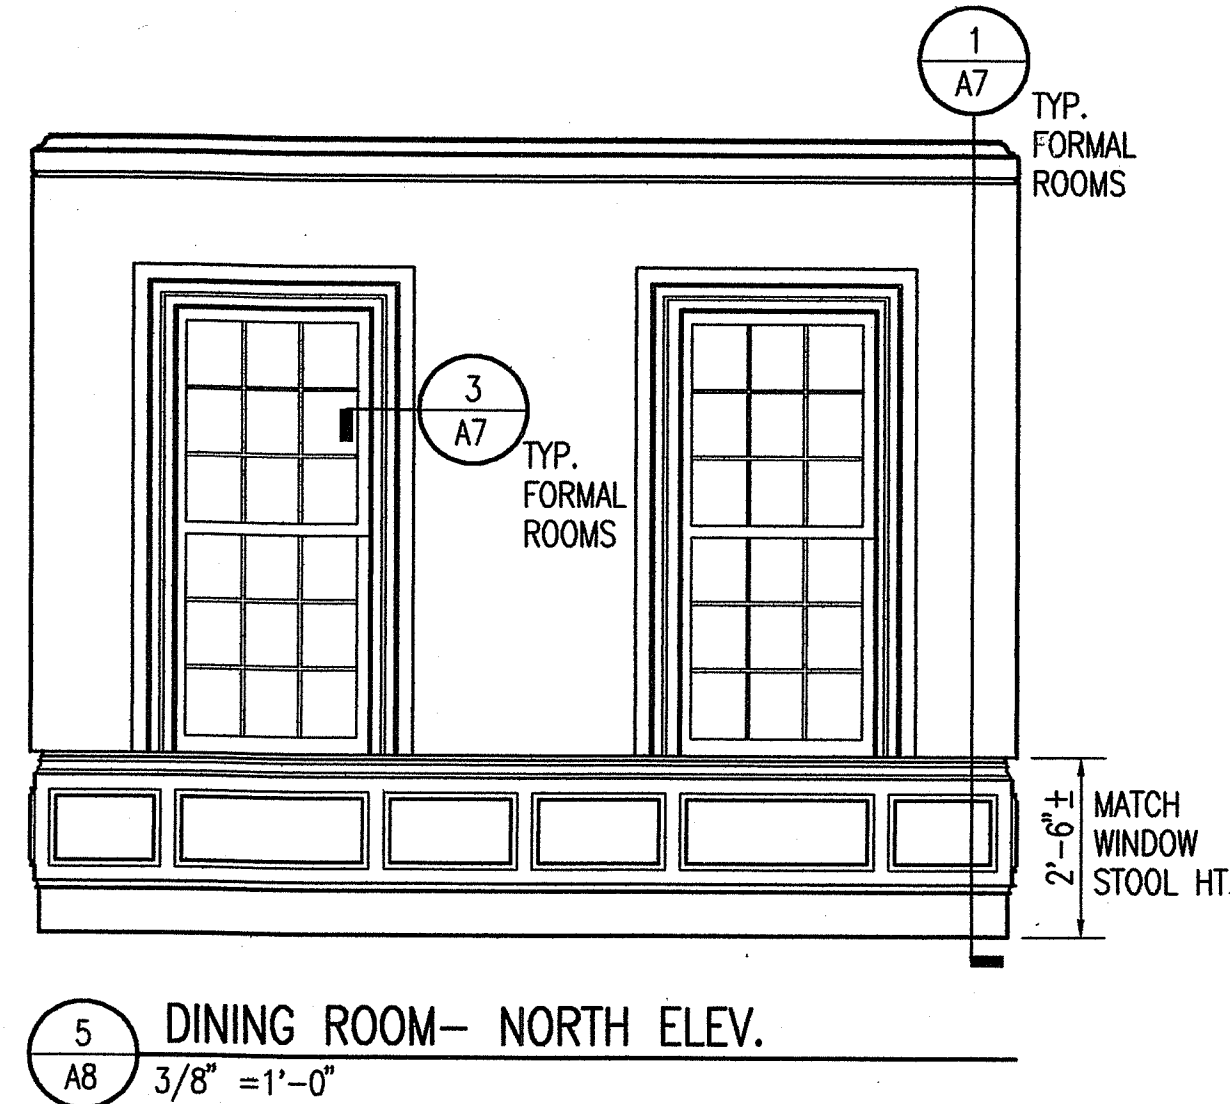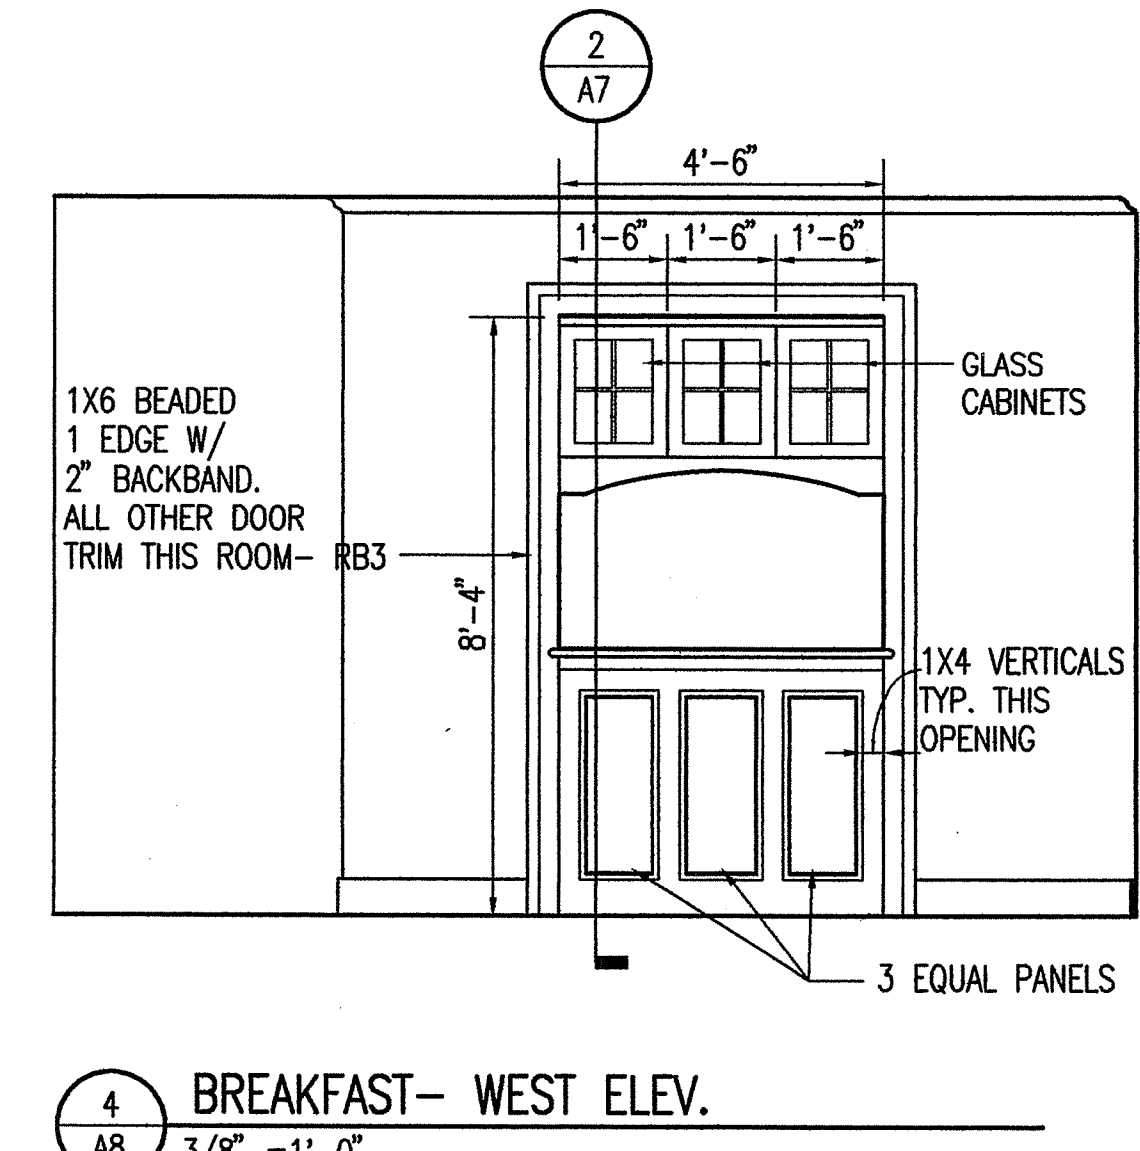

NOTE:
 MOULDING AND TRIM AS SPECIFIED THIS SHEET. ALL OTHER TRIM TO BE AS FOLLOWS:
 DOOR AND WINDOW TRIM- RB-3 3 1/2" TRIM W/ INTEGRAL BACKBAND
 *EXCEPTION- TRIM @ KITCHEN/BREAKFAST OPENING- SEE 4/A8
 BASEBOARDS- 1X6 WITH INTEGRAL BASE CAP
 CROWN- 5 1/2" REMAINING FIRST FLOOR ROOMS + SECOND FLOOR COMPLETE.

Dufford / Young Architects

143 Wentworth Street
 Charleston, SC 29401
 803 577 0737

MOORE RESIDENCE
 Wraggborough Square
 Charleston, South Carolina




date
 11/10/97

drawn
 JLY/PHD

comm. no.


revisions

INTERIOR ELEVATIONS A8

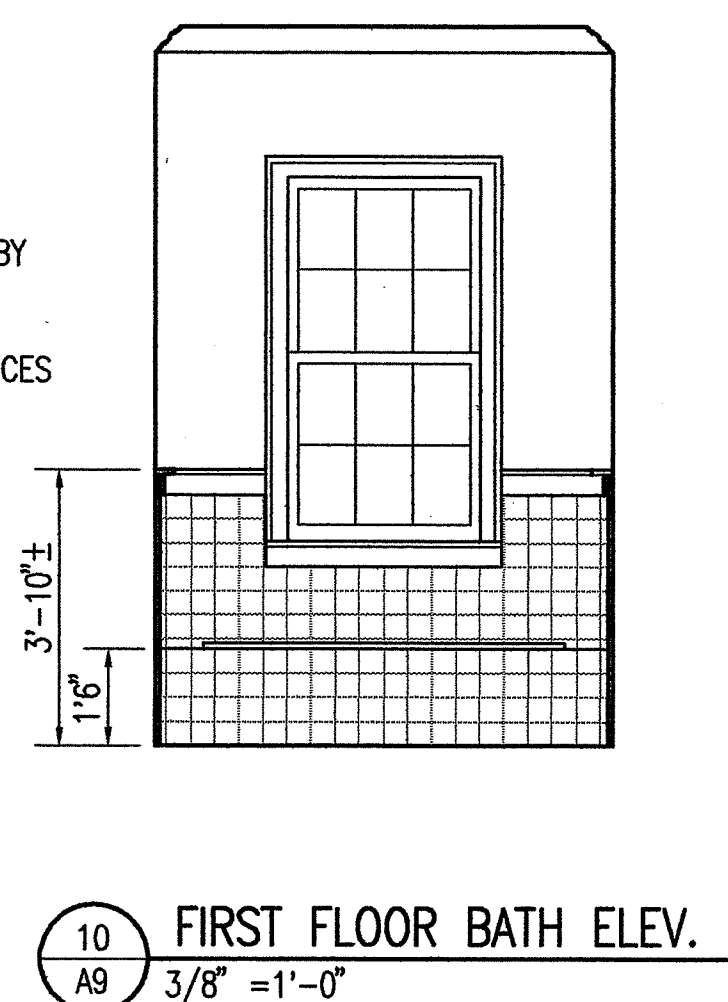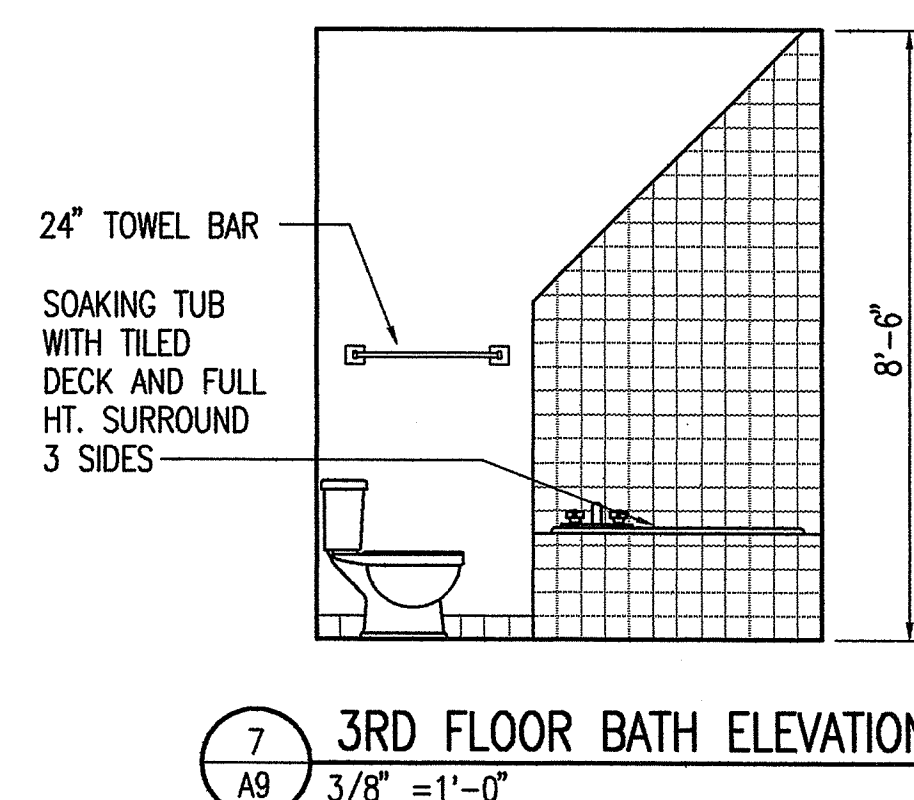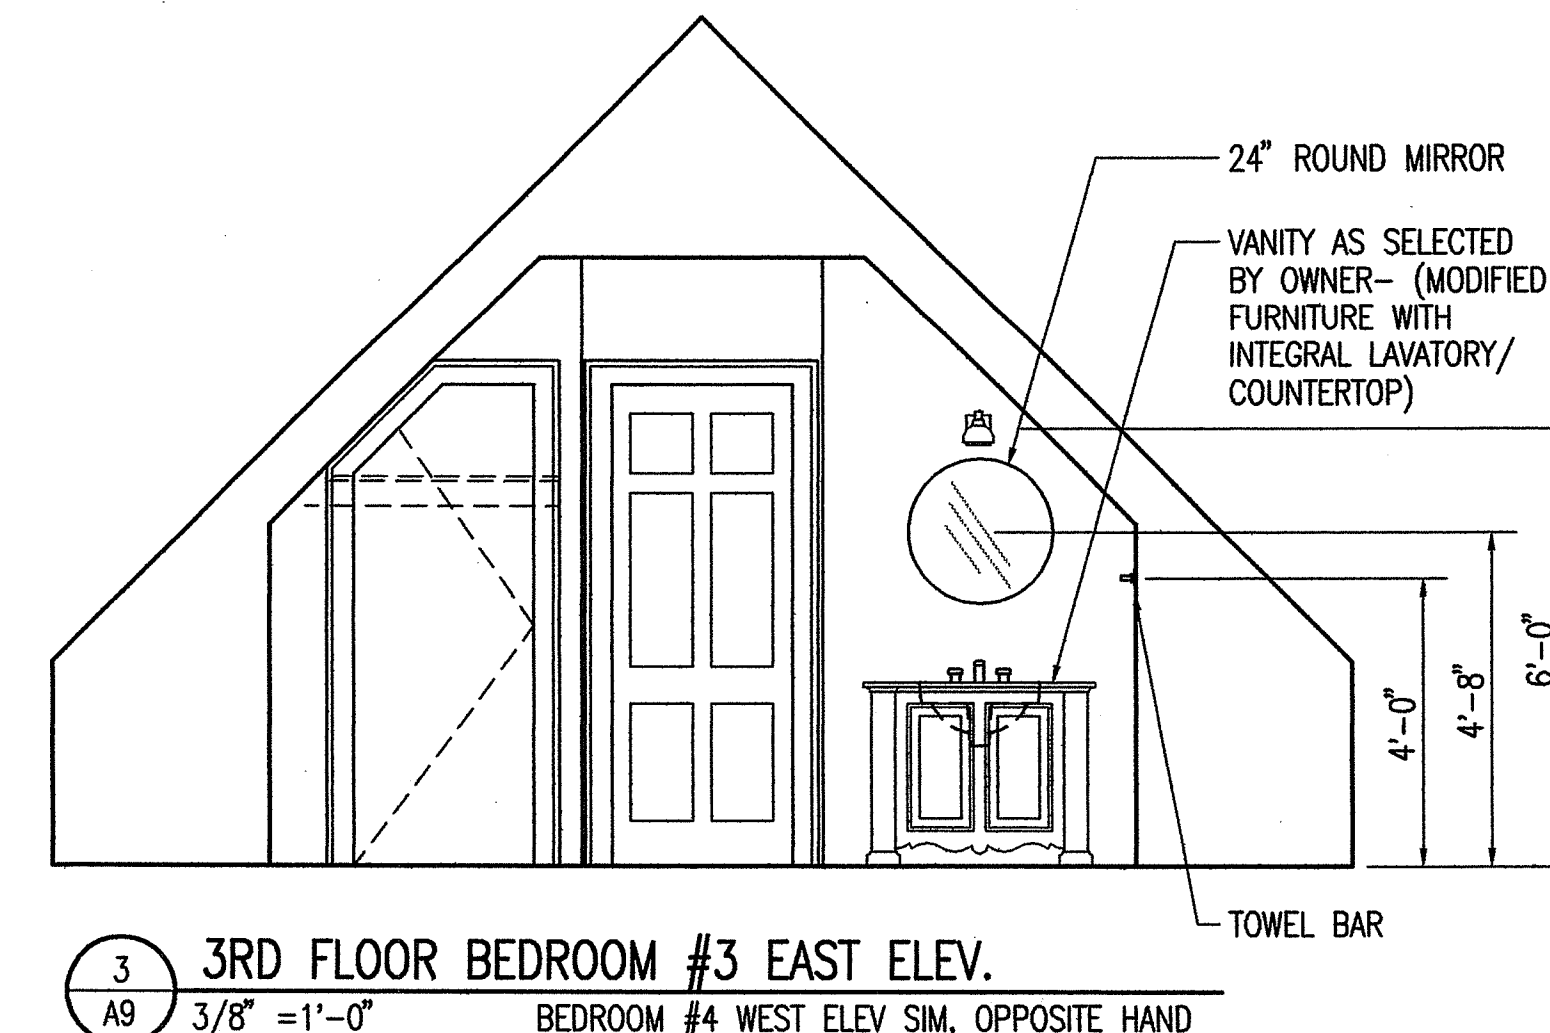

All rights reserved.
The reproduction or use
of this drawing or the
design hereon without the
written consent of the
Architect is prohibited.

 Architect waives all responsibility and liability for failure to follow these plans and design they convey or problems which arise from other's failure to obtain and follow the architect's guidance with respect to inconsistencies, errors, omissions, ambiguities or conflicts which are alleged



NOTES:

1. SWITCHES, RECEPTACLES AND PLATE COVERS SHALL BE WHITE UNLESS NOTED OTHERWISE.
2. INSTALL SIX EQUALLY SPACED FIXTURES AT CRAWL SPACE, SWITCHED AT CRAWL SPACE ACCESS.

1
E1

FIRST FLOOR ELECTRICAL PLAN

SCALE: 1/4"=1'-0"

CABINET MOUNTED
FLUORESCENT FIXTURE

CEILING MOUNTED
FLUORESCENT FIXTURE

CEILING FAN-((#)#)=FAN DIA.

CEILING SURFACE MOUNTED
INCANDESCENT LIGHT FIXTURE

 WALL SURFACE MOUNTED
INCANDESCENT LIGHT FIXTURE

RECESSED INCANDESCENT
FIXTURE

 **RECESSED INCANDESCENT
EYEBALL FIXTURE**

PUSH BUTTON

CHIMES

TELEPHONE OUTLET

3  3-WAY SWITCH

 SINGLE POLE SWITCH

^D
~~6~~ DIMMER SWITCH

 110 V DUPLEX RECEPTICAL

110 V QUADRAPLEX RECEPTICAL

110 V RECEPTICAL ABOVE
COUNTER HT.

 110 V RECEPTICAL GROUND FAULT INTERRUPTER

 110 V RECEPTICAL, FLOOR MTD

 110 V RECEPTICAL, WEATHERPROOF

 220 V RECEPTICAL

J JUNCTION BOX

 SOFFIT MOUNTED SECURITY LIGHT

 CEILING MOUNTED EXHAUST FAN / LIGHT

 CEILING MOUNTED EXHAUST FAN

◀ CABLE TV OUTLET

COM DEDICATED COMPUTER LINE

FAX DEDICATED FAX LINE

1 SPECIALTY FIXTURE: CONTRACTOR TO PROVIDE ALLOWANCE

ELECTRIC PANEL

METER
 ELECTRIC METER

NOTE: INSTALLATION OF ALL WIRING AND FIXTURES SHALL IN COMPLIANCE W/ GOVERNING BUILDING CODES

143 Wentworth Street
Charleston, SC 29401
803 577 0737

MOORE RESIDENCE
Wraggborough Square
Charleston, South Carolina


date
11/10/97

drawn
JLY/PHD

comm. no.


revisions

FIRST FLOOR
ELECTRICAL PLAN

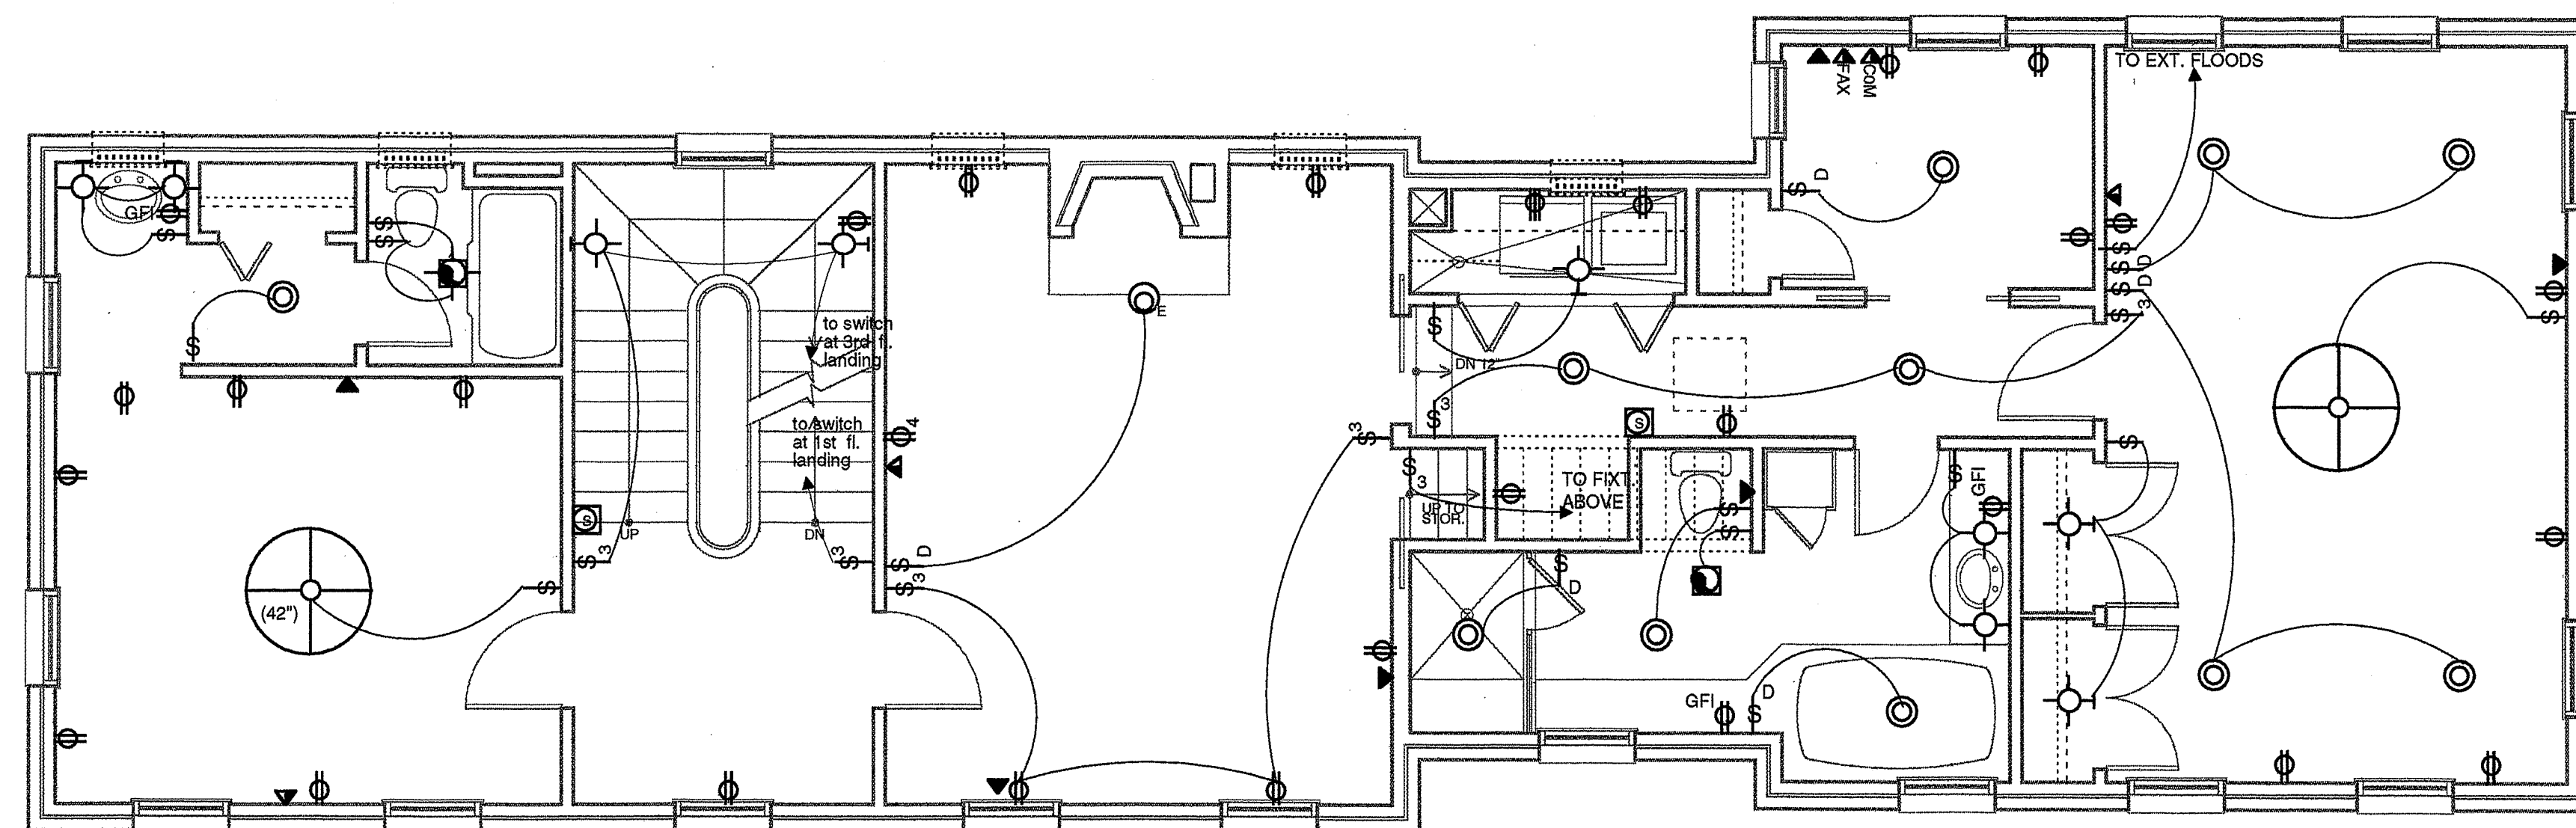

NOTE: SWITCHES, RECEPTACLES AND PLATE COVERS
SHALL BE WHITE UNLESS NOTED OTHERWISE

1
E2
SECOND FLOOR ELECTRICAL PLAN
SCALE: 1/4"=1'-0"

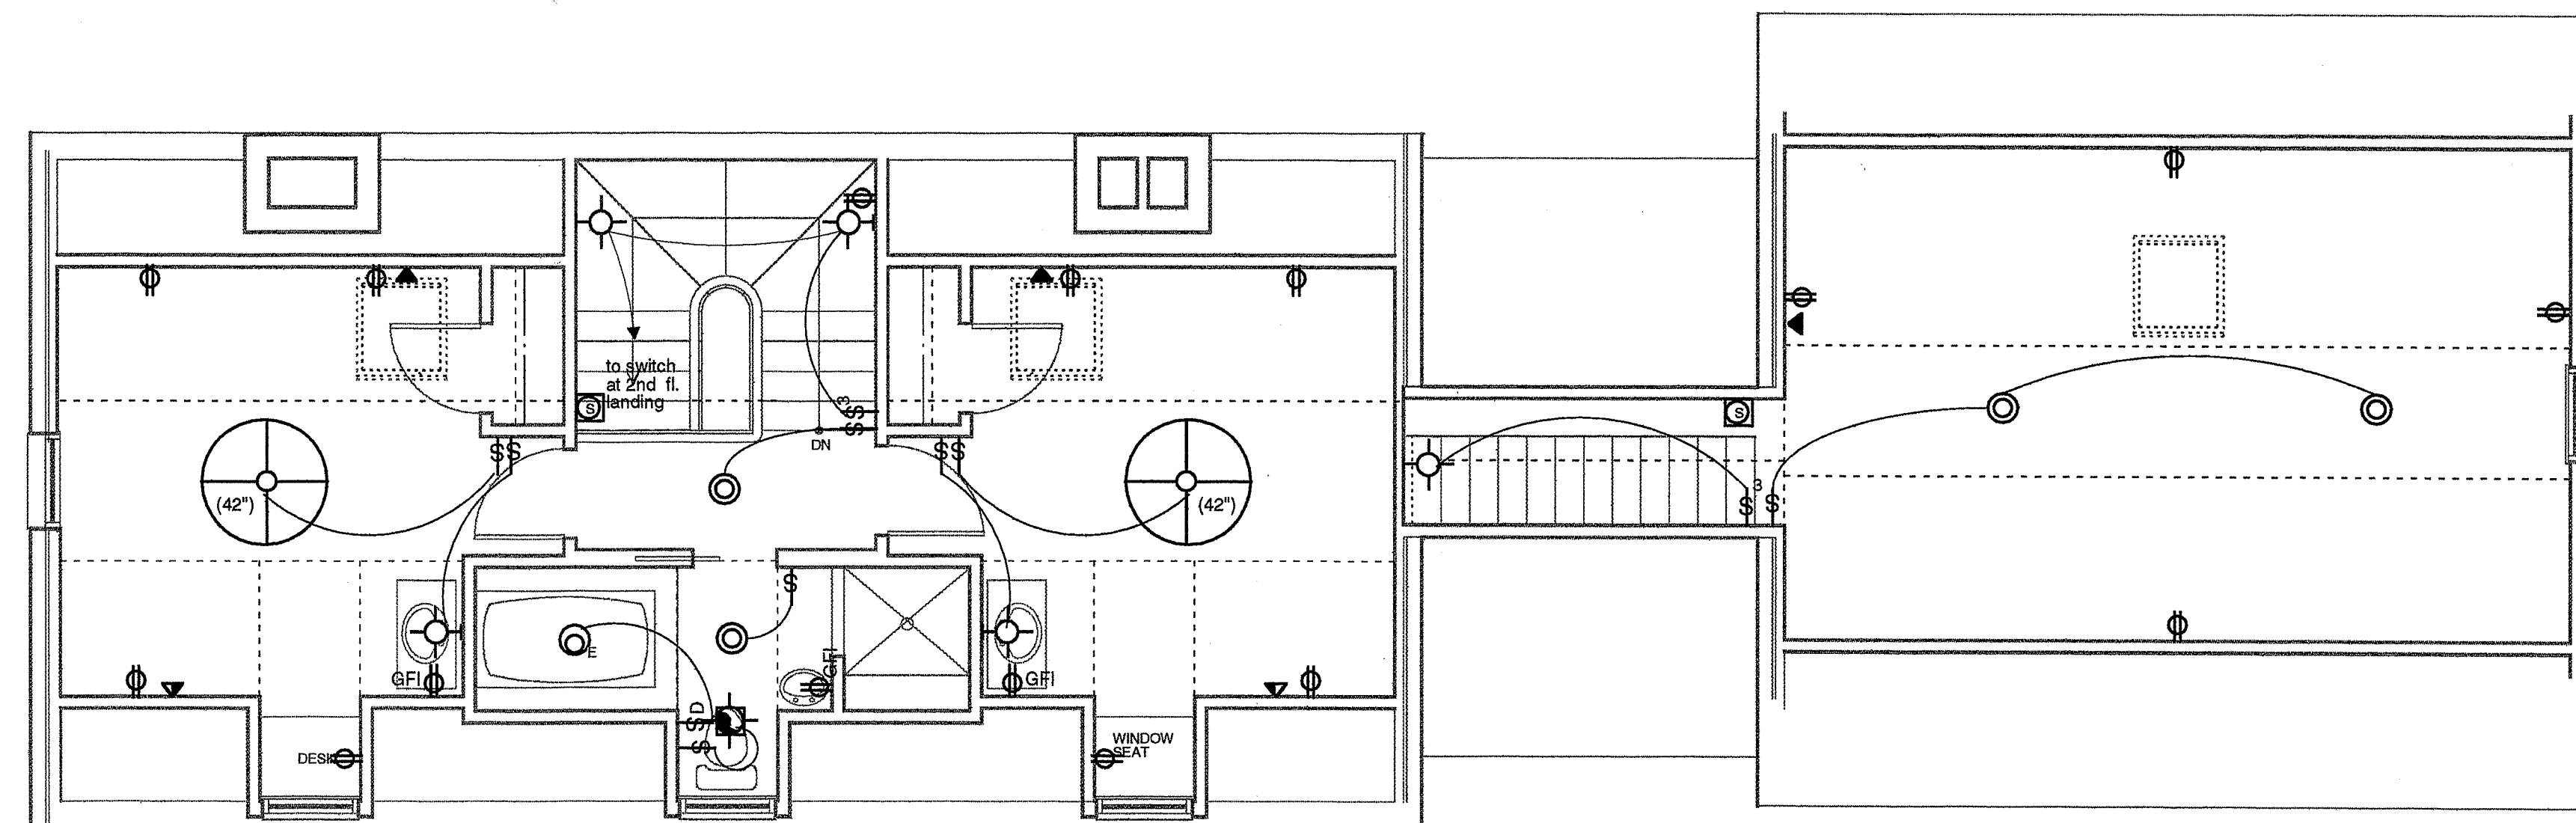

NOTE: SWITCHES, RECEPTACLES AND PLATE COVERS
SHALL BE WHITE UNLESS NOTED OTHERWISE

2
E2
THIRD FLOOR ELECTRICAL PLAN
SCALE: 1/4"=1'-0"

ELECTRICAL SYMBOLS LEGEND	
	SMOKE DETECTOR
	CABINET MOUNTED FLUORESCENT FIXTURE
	CEILING MOUNTED FLUORESCENT FIXTURE
	CEILING FAN-(#") =FAN DIA.
	CEILING SURFACE MOUNTED INCANDESCENT LIGHT FIXTURE
	WALL SURFACE MOUNTED INCANDESCENT LIGHT FIXTURE
	RECESSED INCANDESCENT FIXTURE
	RECESSED INCANDESCENT EYEBALL FIXTURE
	PUSH BUTTON
	CHIMES
	TELEPHONE OUTLET
	3-WAY SWITCH
	SINGLE POLESWITCH
	DIMMER SWITCH
	110 V DUPLEX RECEPTICAL
	110 V QUADRUPLEX RECEPTICAL
	110 V RECEPTICAL ABOVE COUNTER HT.
	110 V RECEPTICAL GROUND FAULT INTERRUPTER
	110 V RECEPTICAL, FLOOR MTD.
	110 V RECEPTICAL, WEATHERPROOF
	220 V RECEPTICAL
	JUNCTION BOX
	SOFFIT MOUNTED SECURITY LIGHT
	CEILING MOUNTED EXHAUST FAN / LIGHT
	CEILING MOUNTED EXHAUST FAN
	CABLE TV OUTLET
	DEDICATED COMPUTER LINE
	DEDICATED FAX LINE
	SPECIALTY FIXTURE: CONTRACTOR TO PROVIDE ALLOWANCE
	ELECTRIC PANEL
	ELECTRIC METER
NOTE: INSTALLATION OF ALL WIRING AND FIXTURES SHALL IN COMPLIANCE W/ GOVERNING BUILDING CODES	

143 Wentworth Street
Charleston, SC 29401
803 577 0737

MOORE RESIDENCE
Wraggborough Square
Charleston, South Carolina


date
11/10/97

drawn
JLY/PHD


comm. no.

revisions

SECOND & THIRD FLOOR
ELECTRICAL PLANS E2

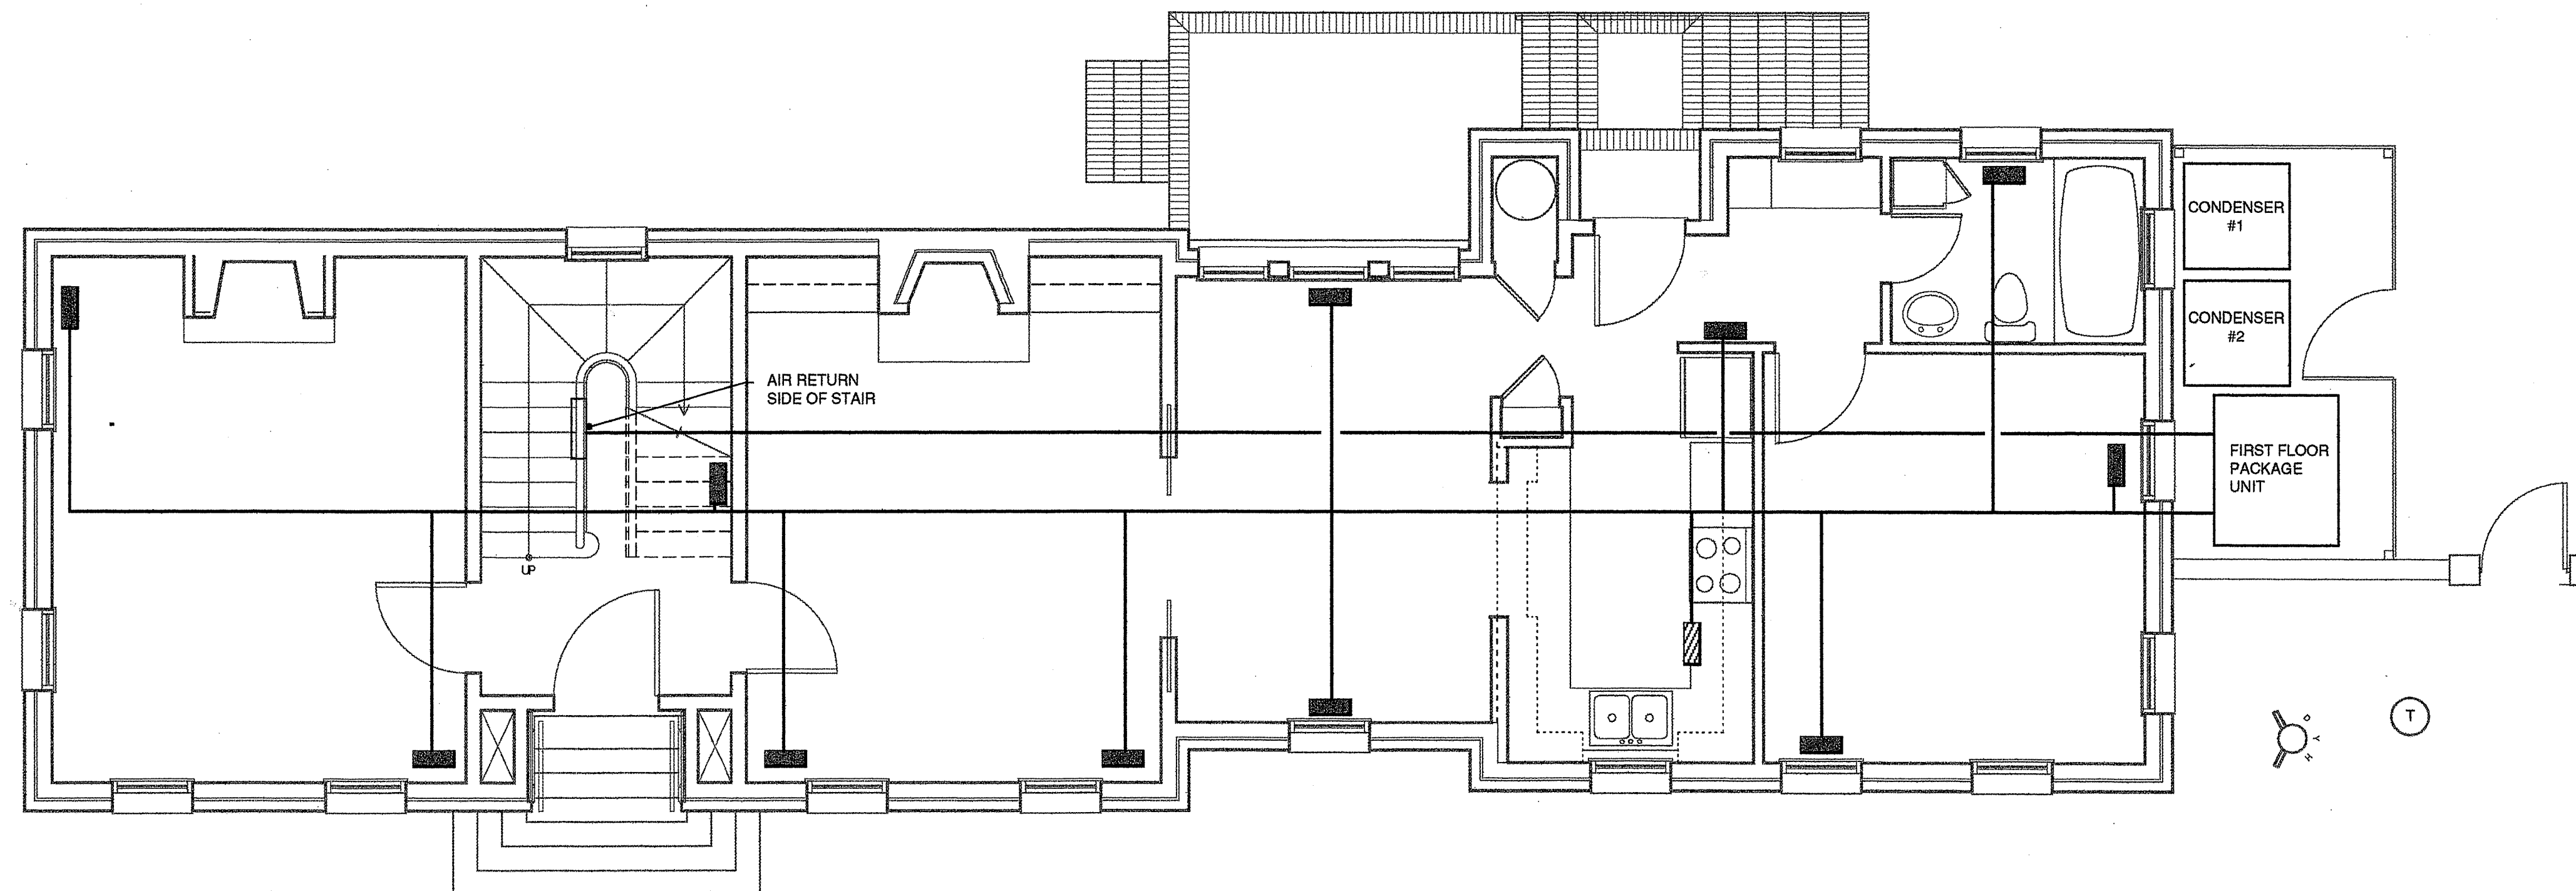

1
M1
FIRST MECHANICAL LAYOUT
SCALE: 1/4"=1'-0"

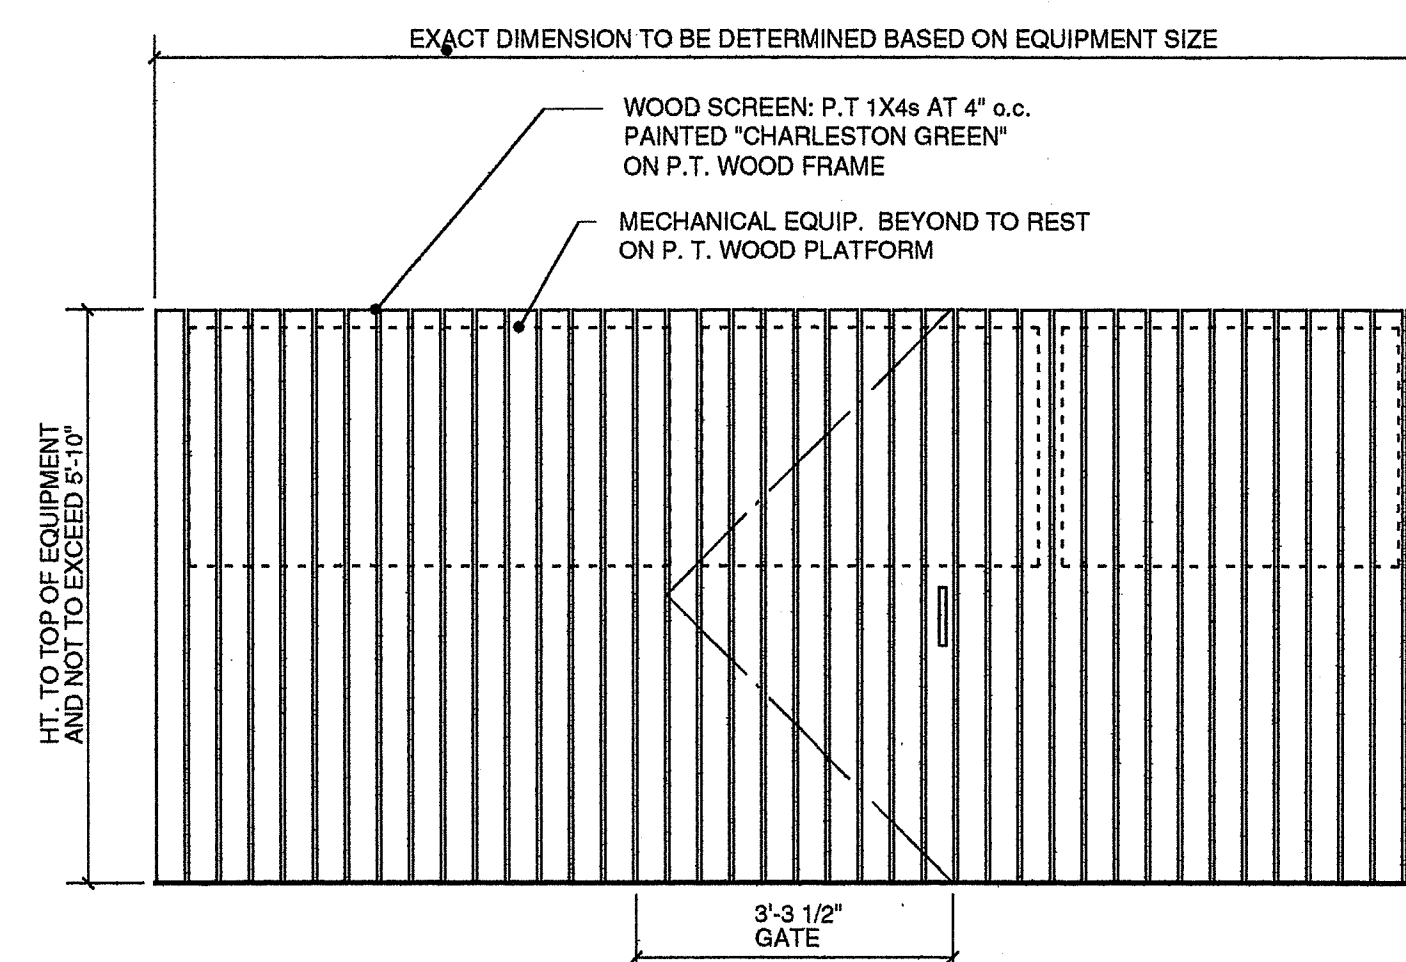

2
M1
ELEVATION: WOOD SCREEN AT MECHANICAL EQUIPMENT
SCALE: 1/4"=1'-0"

MECHANICAL SYMBOLS LEGEND

- FLOOR MOUNTED SUPPLY DIFFUSER
□ WALL MOUNTED SUPPLY DIFFUSER
▨ BASE MOUNTED SUPPLY DIFFUSER

NOTE: MECHANICAL LAYOUT SHOWN IS A PROPOSED LAYOUT. MECHANICAL SYSTEM SHALL BE DESIGNED AND SPECIFIED BY OTHERS AND INSTALLED ACCORDING TO GOVERNING BUILDING CODES. ARCHITECT SHALL REVIEW SHOP DRAWINGS BY MECHANICAL CONTRACTOR PRIOR TO INSTALLATION.

143 Wentworth Street
Charleston, SC 29401
803.577.0737

MOORE RESIDENCE
Wraggborough Square
Charleston, South Carolina

date
11/10/97

drawn
J.L.Y./PHD


comm. no.

revisions


FIRST FLOOR
MECHANICAL

M1

Copyright © 1997
John L. Young, F.A.
in association with
Philip H. Dufford, F.A.
143 Wentworth Street
Charleston, S.C. 29401
803 577 0737
All rights reserved.
The reproduction or use
of this drawing or the
design herein without the
written consent of the
Architect is prohibited.
Architect waives all
responsibility and liability for
failure to follow these plans
and design they convey or
problems which arise from
others failure to obtain and
follow the architect's
guidance with respect to any
inconsistencies, errors,
omissions, ambiguities or
conflicts which are alleged.

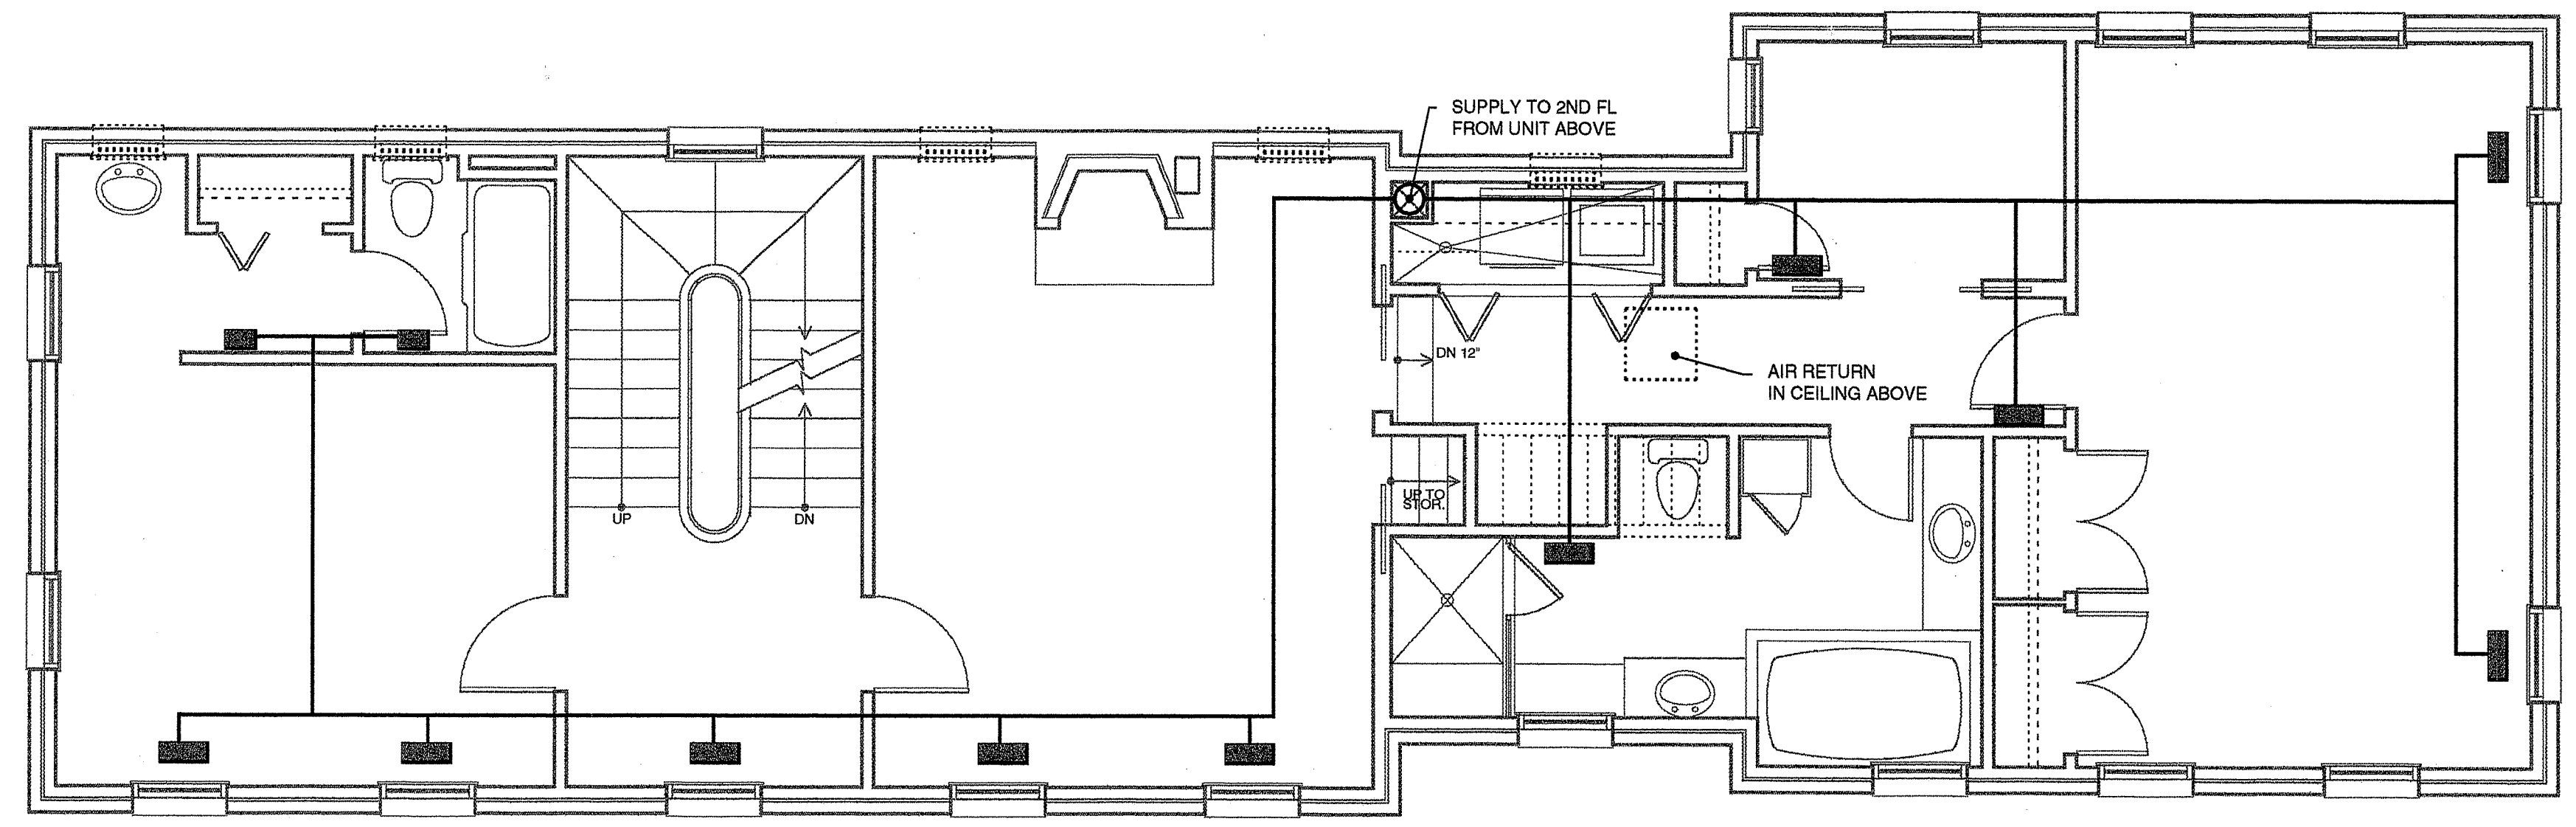

1
M2
SECOND MECHANICAL LAYOUT
SCALE: 1/4"=1'-0"

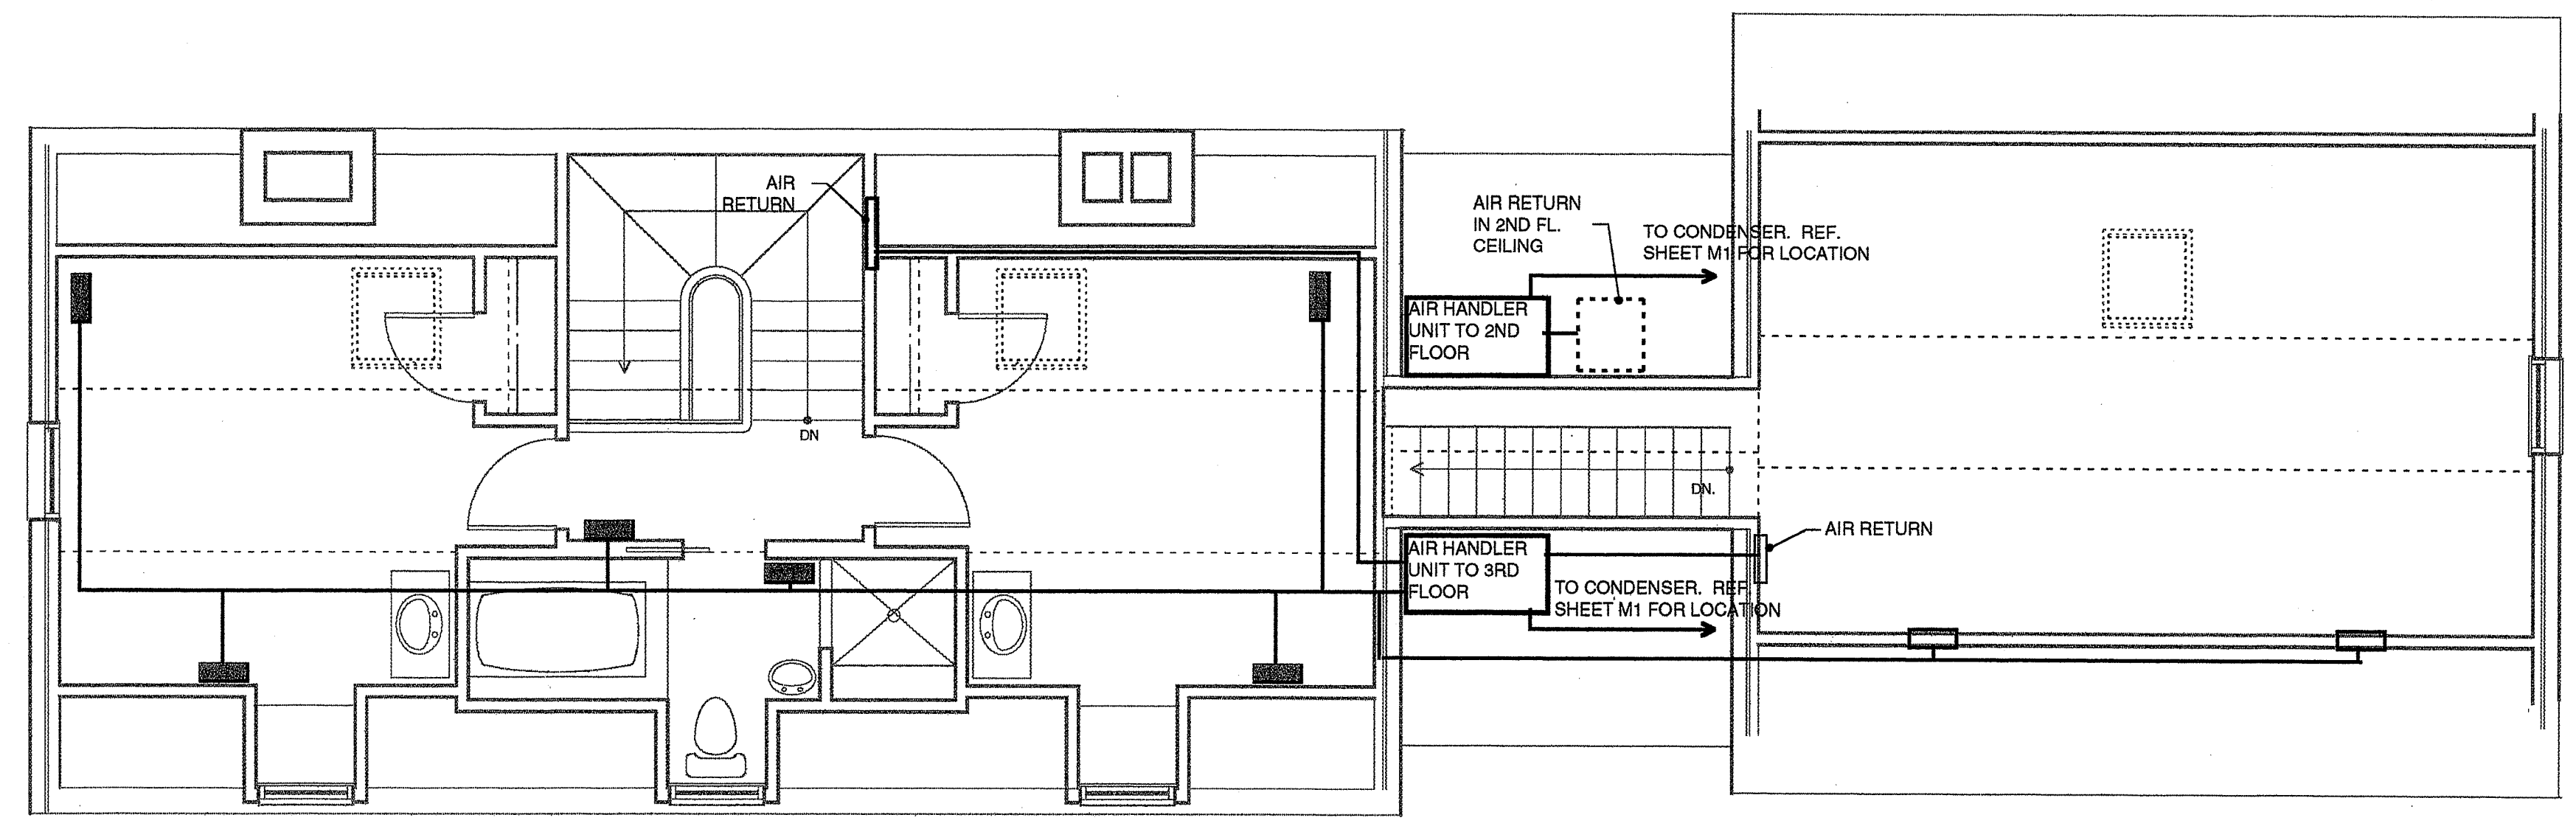

2
M2
THIRD MECHANICAL LAYOUT
SCALE: 1/4"=1'-0"



MECHNAICAL SYMBOLS LEGEND

 FLOOR MOUNTED SUPPLY DIFFUSER



 WALL MOUNTED SUPPLY DIFFUSER

NOTE: MECHANICAL LAYOUT SHOWN IS A PROPOSED LAYOUT. MECHANICAL SYSTEM SHALL BE DESIGNED AND SPECIFIED BY OTHERS AND INSTALLED ACCORDING TO GOVERNING BUILDING CODES. ARCHITECT SHALL REVIEW SHOP DRAWINGS BY MECHANICAL CONTRACTOR PRIOR TO INSTALLATION.

143 Wentworth Street
Charleston, SC 29401
803 577 0737

MOORE RESIDENCE
Wraggborough Square
Charleston, South Carolina


date
11/10/97
drawn
JLY/PHD
comm. no.
revisions

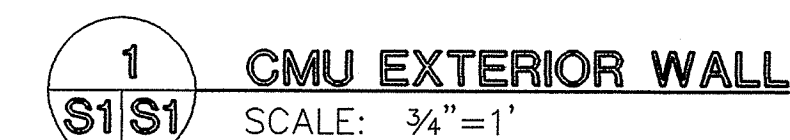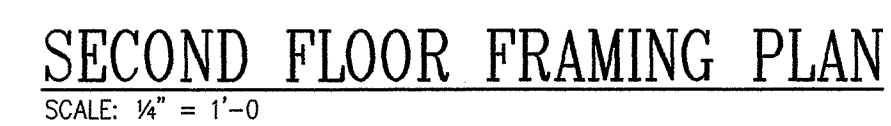

NOTE: ALTERNATE FOR TJI TRUSSES
TRUSS DESIGN BY A PROFESSIONAL ENGINEER
LICENSED IN THE STATE OF SOUTH CAROLINA.


S-1

C:\DWG\1997\97047\S1.dwg 10/09/97

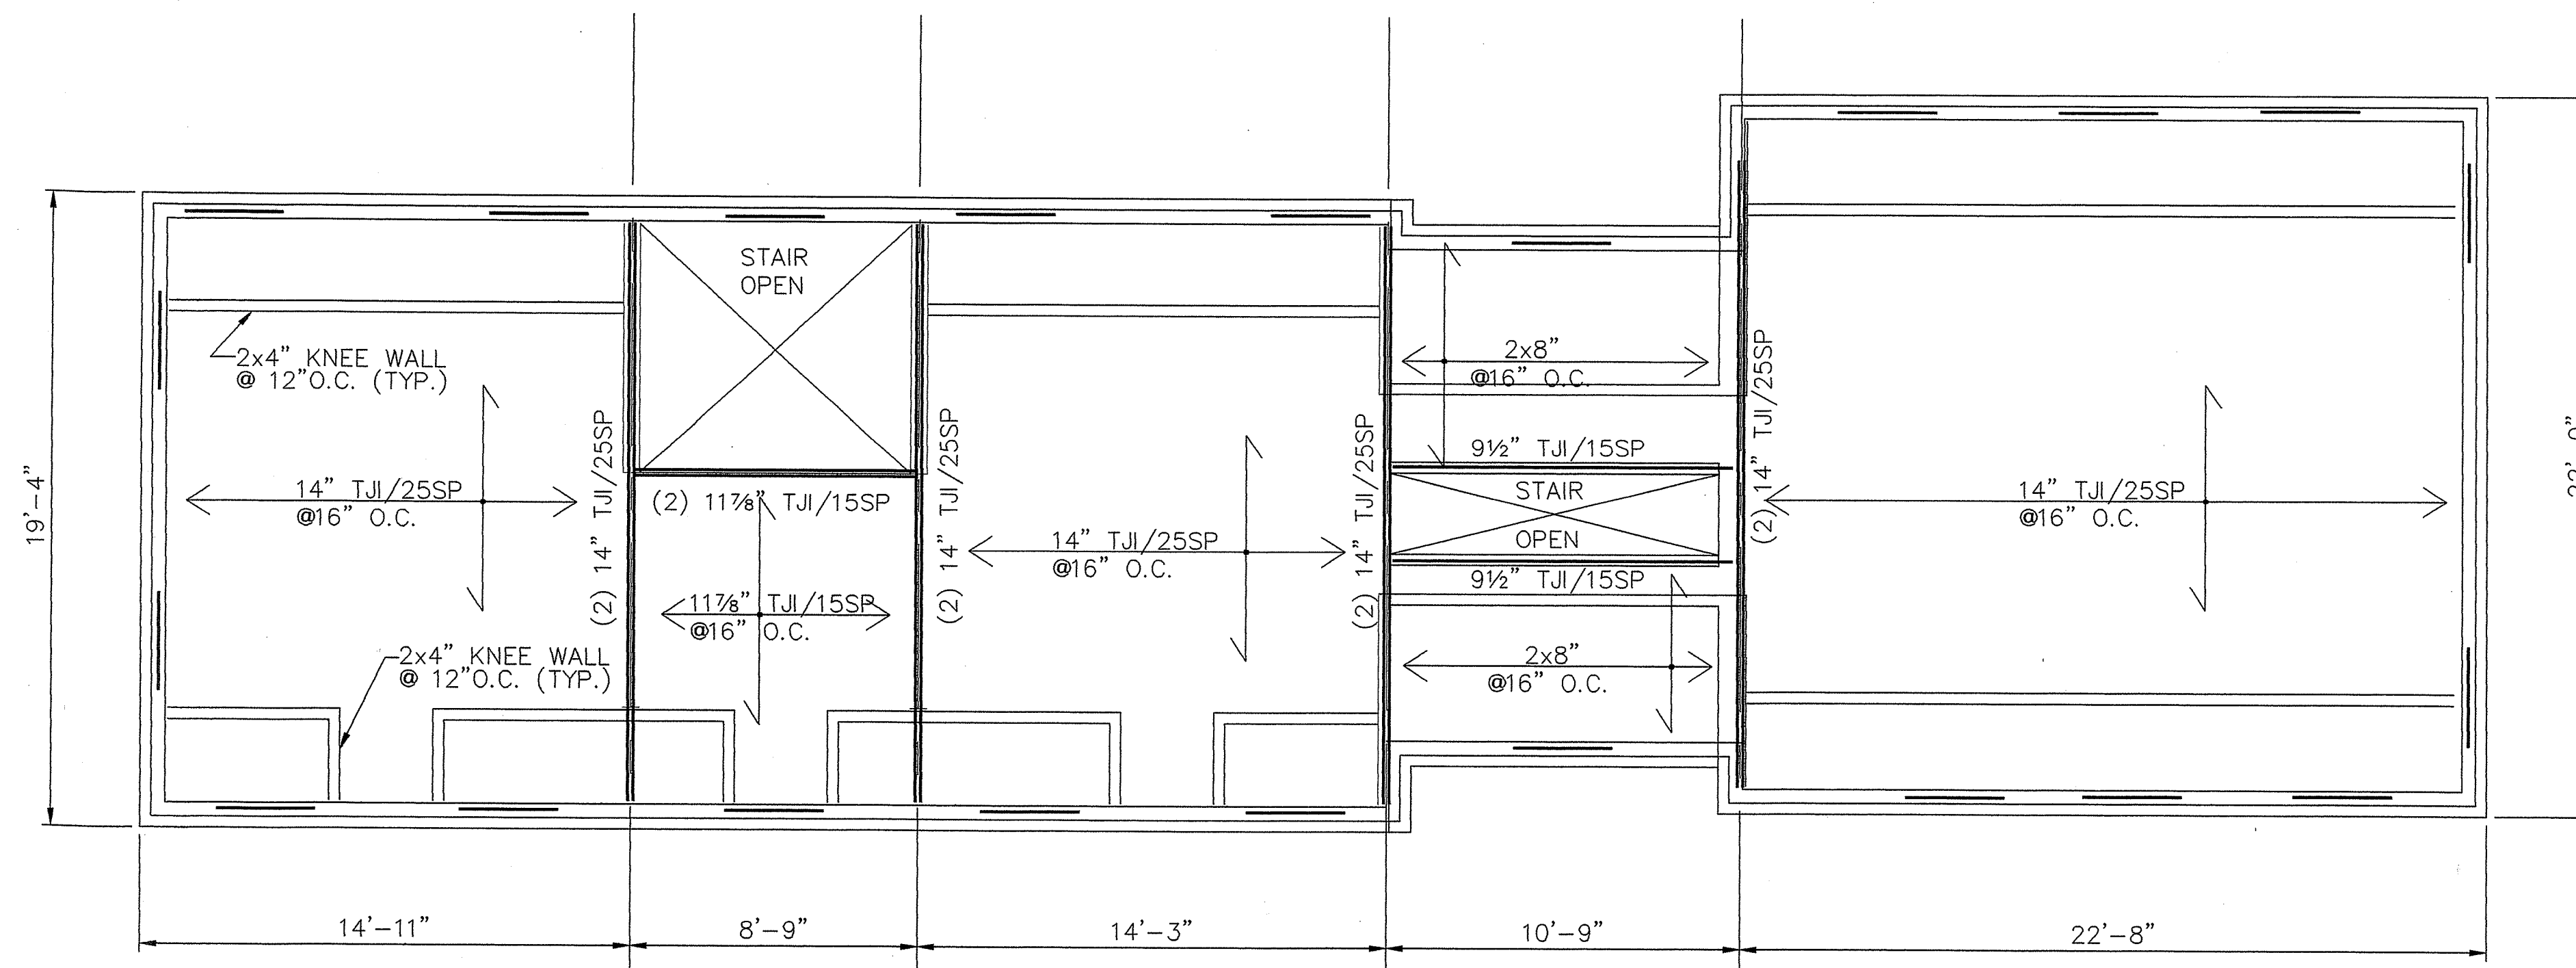


THIRD FLOOR FRAMING PLAN
SCALE: 1/4" = 1'-0"


NOTE: ALTERNATE FOR TJI TRUSSES
TRUSS DESIGN BY A PROFESSIONAL ENGINEER
LICENSED BY THE STATE OF SOUTH CAROLINA.

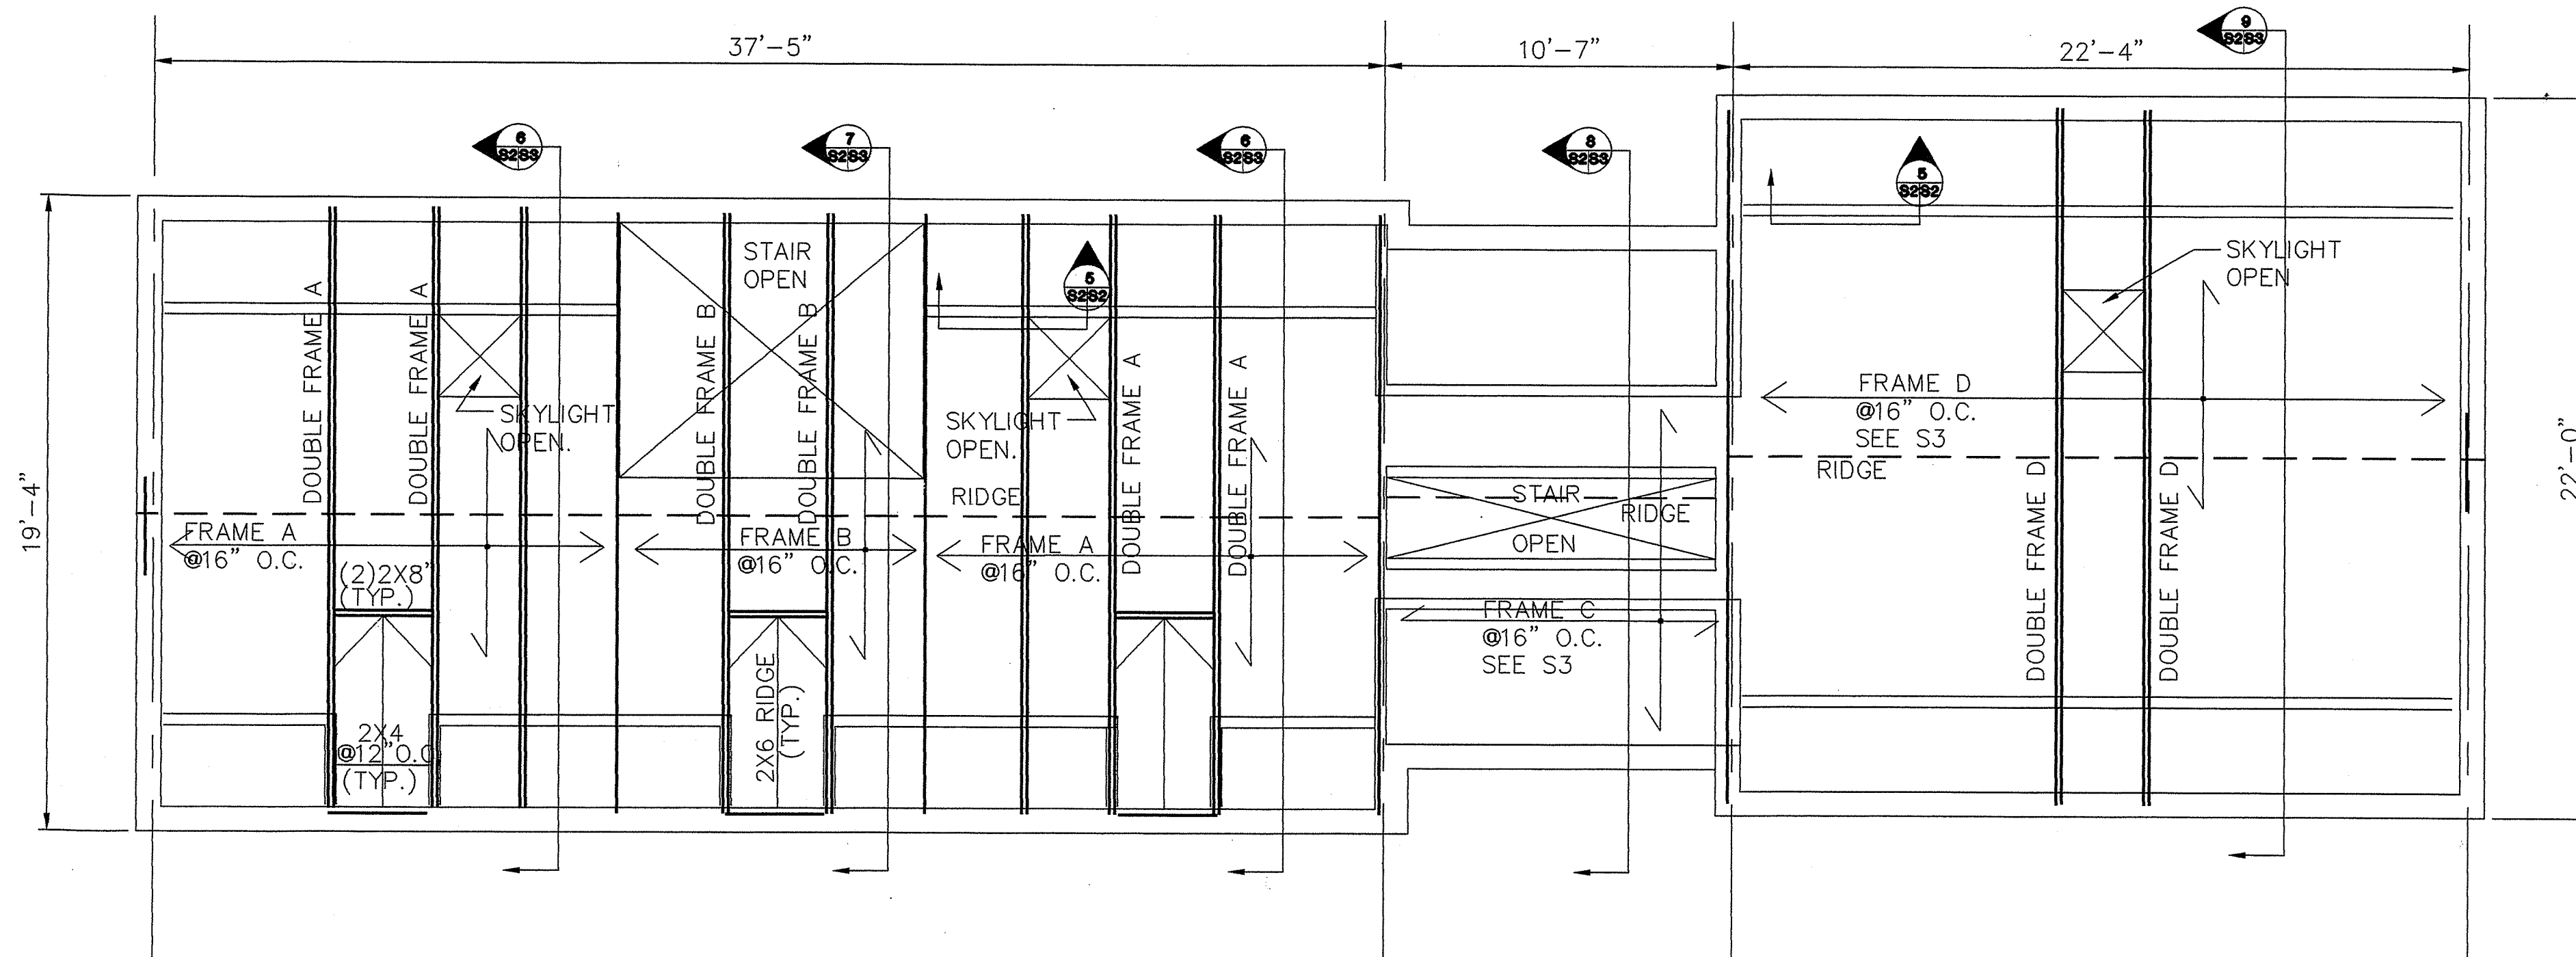


ROOFING PLAN
SCALE: 1/4" = 1'-0"

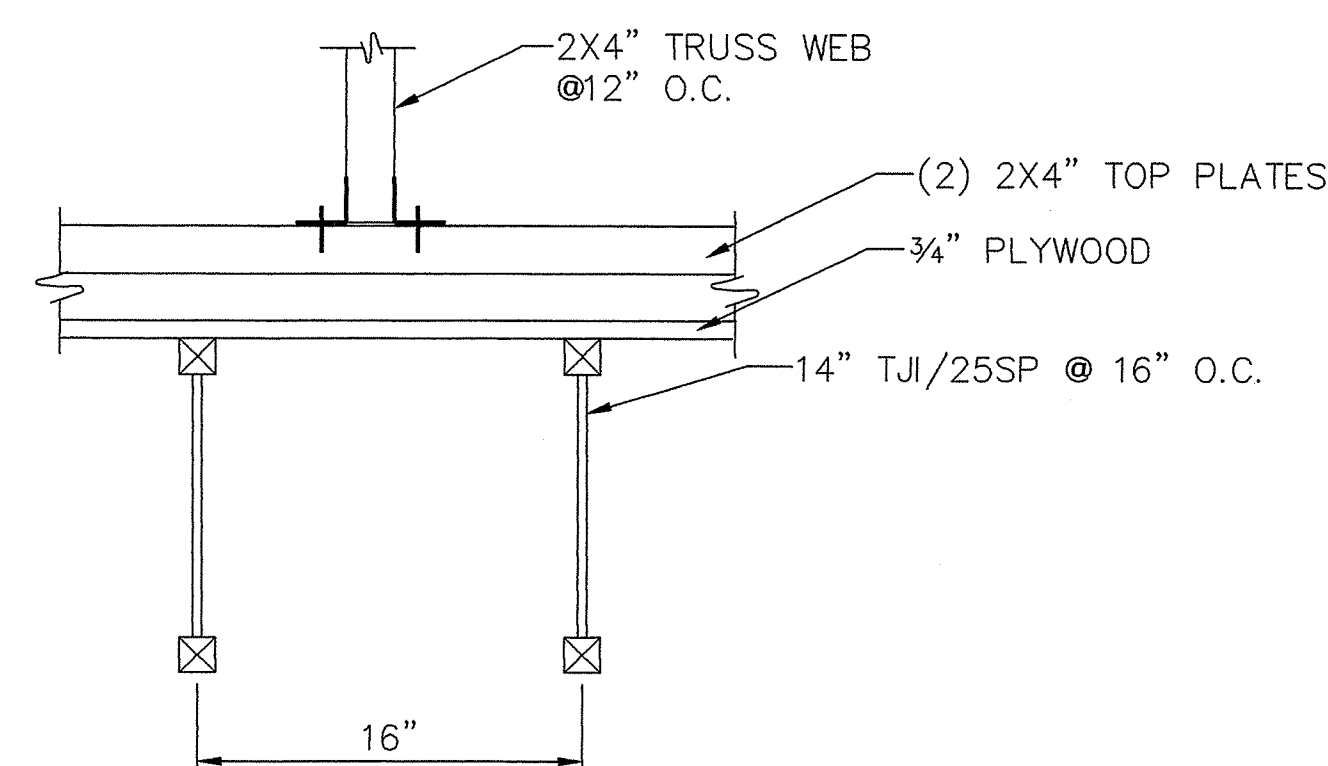


5 SECTION
SCALE: 1 1/2" = 1'

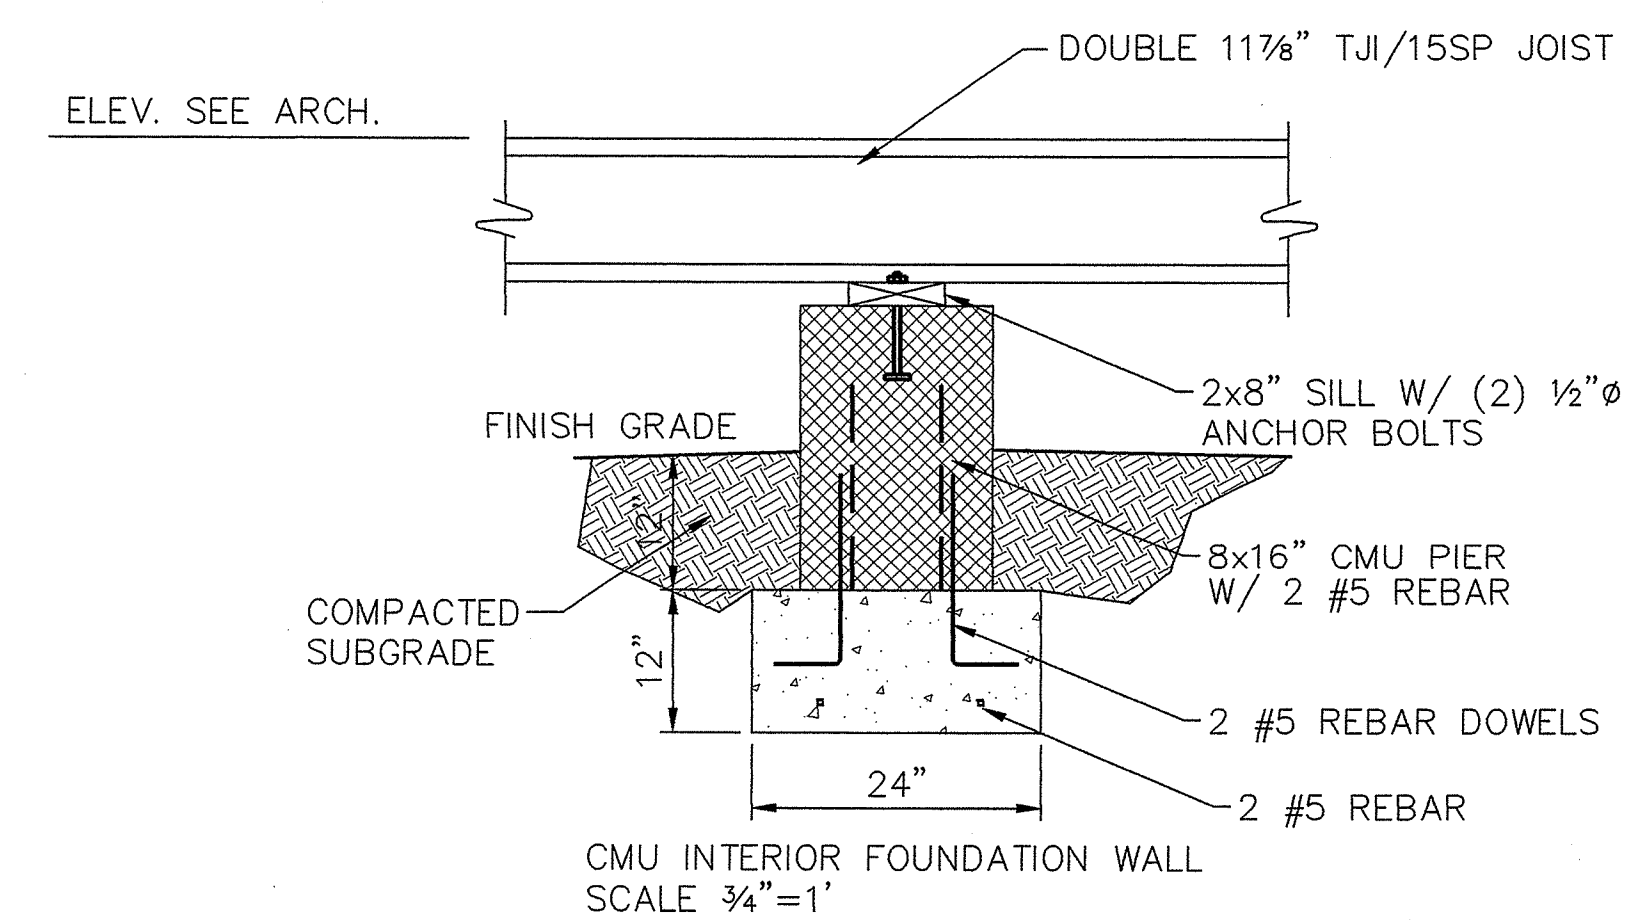


2 CMU INTERIOR FOUNDATION
SCALE: N.T.S.

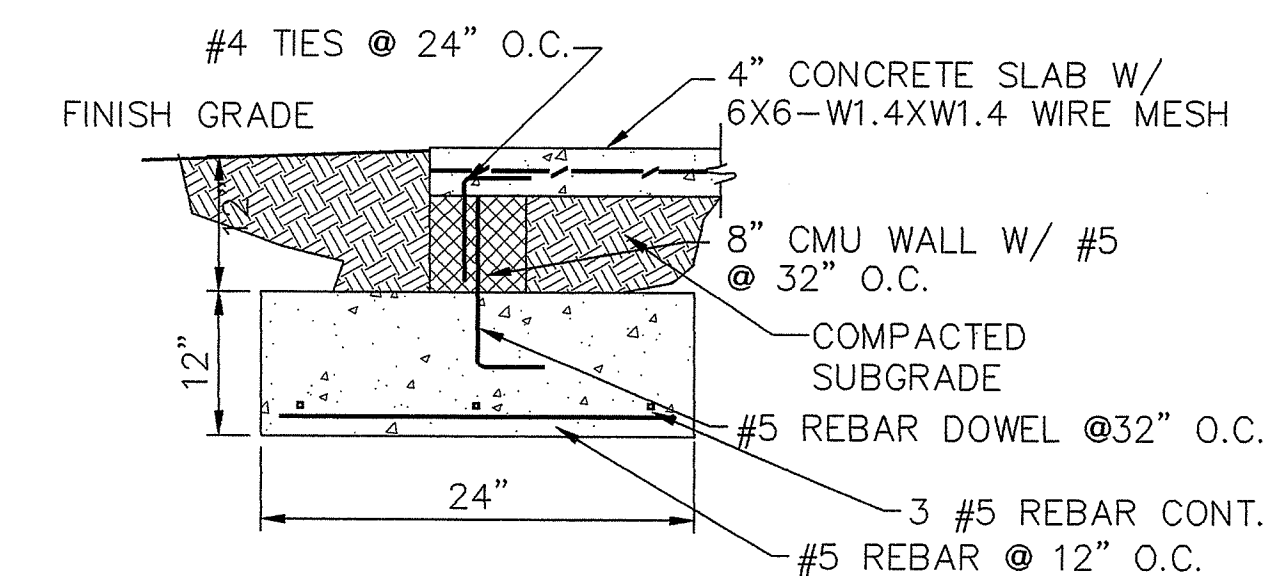

3 SECTION
SCALE: 3/4" = 1'

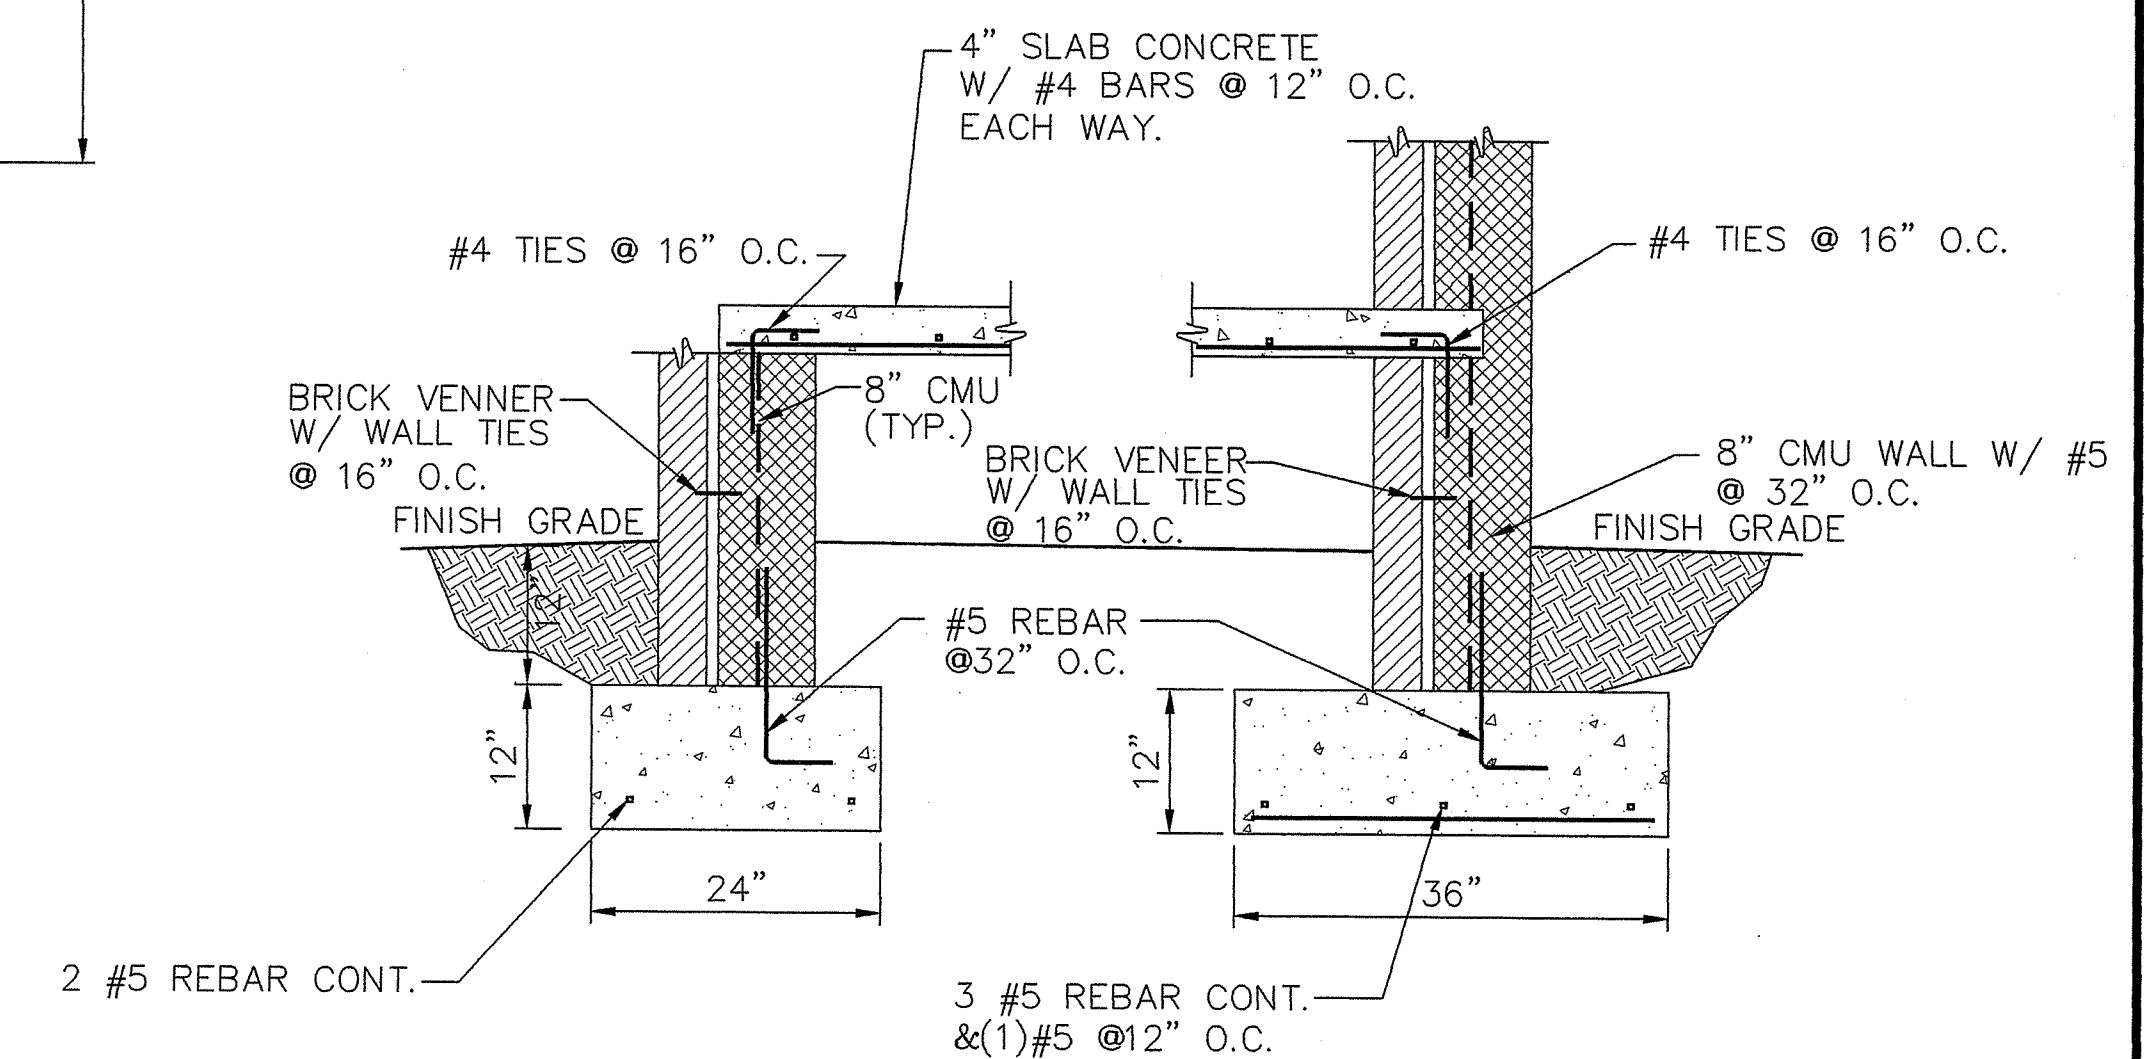

4 CMU EXTERIOR WALL
SCALE: N.T.S.

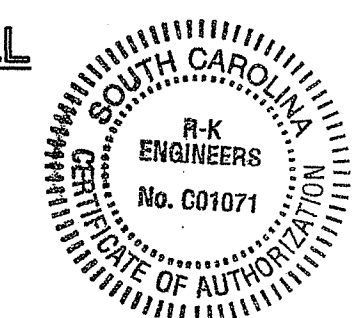

**2ND & 3RD FLOOR
FRAMING PLANS
MOORE RESIDENCE
CHARLESTON, SC**

JOB NUMBER: 97047
JOB NAME: MOORE RESIDENCE
DESIGNED BY: SE
DRAWN BY: SM
APPROVED: RKG

R - K ENGINEERS
CIVIL & STRUCTURAL ENGINEERING
59 WENTWORTH ST. CHARLESTON, SC 29401
(803) 577-2011

S-2

GENERAL NOTES & SPECIFICATIONS

DESIGN BASIS: SBCI CABO ONE & TWO FAMILY DWELLING CODE

DESIGN LOADS

FLOOR DEAD LOADS: LIVING AREAS: 10 PSF

FLOOR LIVE LOADS: LIVING AREAS: 40 PSF

ROOF LOADS: DEAD LOAD: 10 PSF
DEAD LOADS NOTED EXCLUDE TRUSS WEIGHTS
LIVE LOAD: 20 PSF TRUSS TOP CHORD

TYPICAL WALL

FIRST FLOOR LEVEL AND STAIR TOWER

EXTERIOR STUD WALLS TO BE SYP NO. 2 2x6'S @ 16" O.C. W/ A DOUBLE 2x6 TOP PLATE.

SEE SHEATHING BELOW FOR NAILING SPECIFICATIONS.

SECOND & THIRD FLOOR LEVELS

EXTERIOR STUD WALLS TO BE SYP NO. 2 (OR BETTER) 2x4'S @ 16" O.C. W/ A DOUBLE 2x4 TOP PLATE. SEE SHEATHING BELOW FOR NAILING SPECIFICATIONS.

ALL FLOOR LEVELS

DOUBLE STUDS REQUIRED AT EACH SIDE OF OPENINGS & ALL CORNERS.

WALL SHEATHING

THE 1/2" CDX PLYWOOD ACTS AS A TENSION TIE BETWEEN THE TOP PLATE AND THE TOE PLATE AS WELL AS A SHEAR WALL IF NAILED AS FOLLOWS:

1ST FLOOR WALLS

8D NAILS AT 4"O.C. EDGE AND 8"O.C. FIELD W/ ONE STAGGERED ROW @ 4"O.C. INTO TOP PLATES, ONE ROW @ 4"O.C. INTO TRUSS BOTTOM CHORD, AND ONE ROW @ 4"O.C. INTO TOE PLATE.

2ND & 3RD FLOOR WALLS

8D NAILS AT 4"O.C. EDGE AND 8"O.C. FIELD W/ TWO ROWS @ 4"O.C. INTO TOP PLATES, AND ONE ROW @ 4"O.C. INTO TOE PLATE.

FLOOR SHEATHING

3/4" T&G PLYWOOD NAILED & GLUED. NAILED @ 6" O.C. @ EDGES & 8" IN FIELD.

ROOF SHEATHING

5/8" CDX PLYWOOD NAILED @ 6"O.C. EDGE AND 12"O.C. FIELD; SPACE PANELS WITH PSCL PLYWOOD SHEATHING CLIP. EDGE PANELS (EAVE & GABLE) TO BE NAILED @ 3"O.C. EDGE AND 9"O.C. FIELD.

CONNECTION SCHEDULE

ANCHOR BOLT

1/2"Ø HOT DIPPED GALVANIZED BOLT 32" O.C. OR AS NOTED AND 12" FROM CORNERS, EMBEDDED 6", W/ 2"x2"x1/8" OVERSIZED PLATE WASHERS.

TOP PLATE-TO-ROOF RAFTER (EAVE)

ONE SIMPSON MTS8 PER FRAME.
INSTALL AS PER MANUFACTURER'S RECOMMENDATIONS.

LINTELS

ALL LINTELS TO BE (2) 2X10".

SPECIFICATIONS

STRUCTURAL TIMBER

- ALL TIMBER TO BE MIN. GRADE & SPECIES AS PER LATEST EDITION OF THE NATIONAL DESIGN SPECIFICATION FOR WOOD CONSTRUCTION: INTERIOR STUDS = HEM FIR-STUD GRADE, BEAMS AND HEADERS AS INDICATED ON THE PLANS.
- INSTALL TJI AS PER MANUFACTURER'S RECOMMENDATIONS.

CONCRETE


CONCRETE: STORAGE AREA & SLAB TO HAVE A COMPRESSIVE STRENGTH OF 3,000 PSI @ 28 DAYS PER ACI 318.
REBAR: GRADE 60, ASTM A615
WELDED WIRE FABRIC: ASTM 185

CONCRETE MASONRY


CMU TO COMPLY WITH ASTM C90 TYPE S MORTAR.
GALVANIZED METAL TIES FOR THE STONE OR BRICK VENEER TO COMPLY WITH CURRENT CABO CODE.
CMU WALLS TO BE GROUTED @ 32" O.C.

FOOTING


ASSUMED ALLOWABLE SOIL BEARING PRESSURE = 2000 P.S.F.
CONTRACTOR VERIFY SOIL BEARING CAPACITY.
CONTACT R-K ENGINEERS IF SPECIFIED SOIL BEARING CAPACITY CANNOT BE OBTAINED.

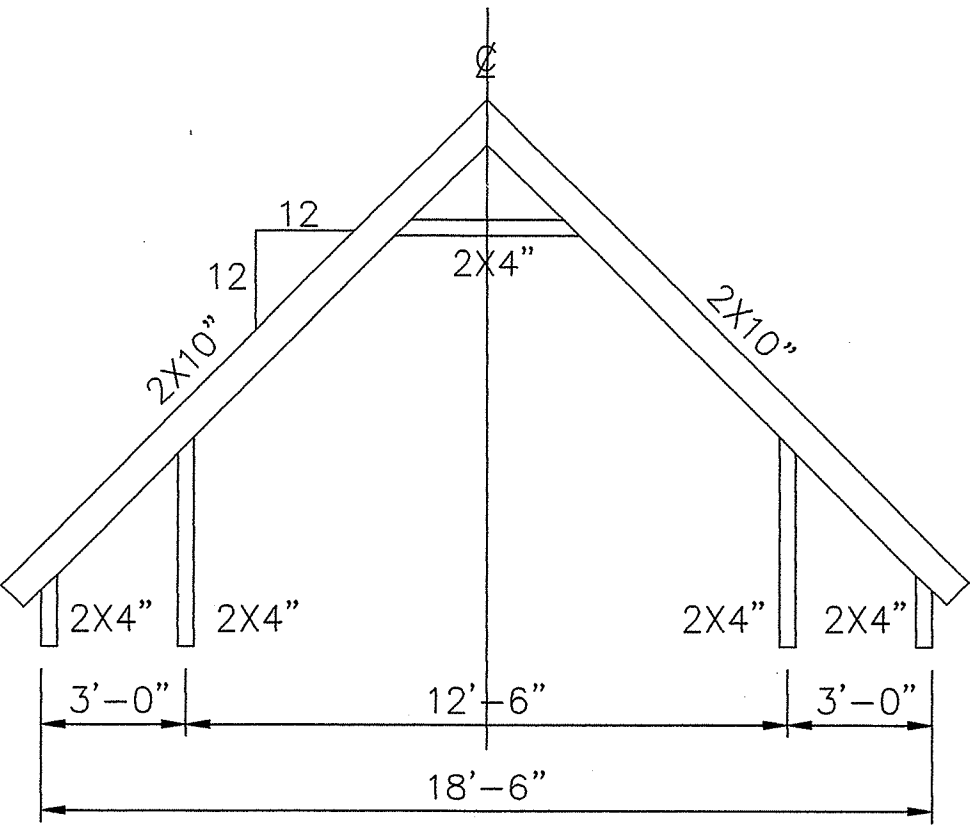


6 ROOF FRAME A
S2S3 SCALE: 1/4"=1.0'

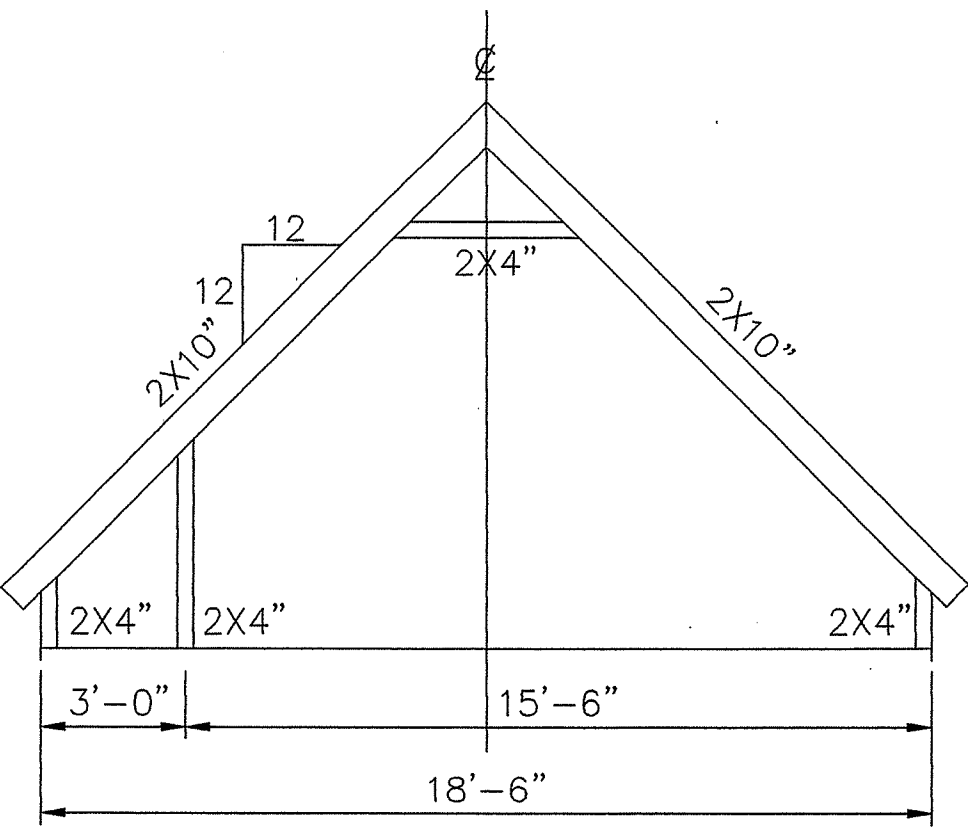


7 ROOF FRAME B
S2S3 SCALE: 1/4"=1.0'

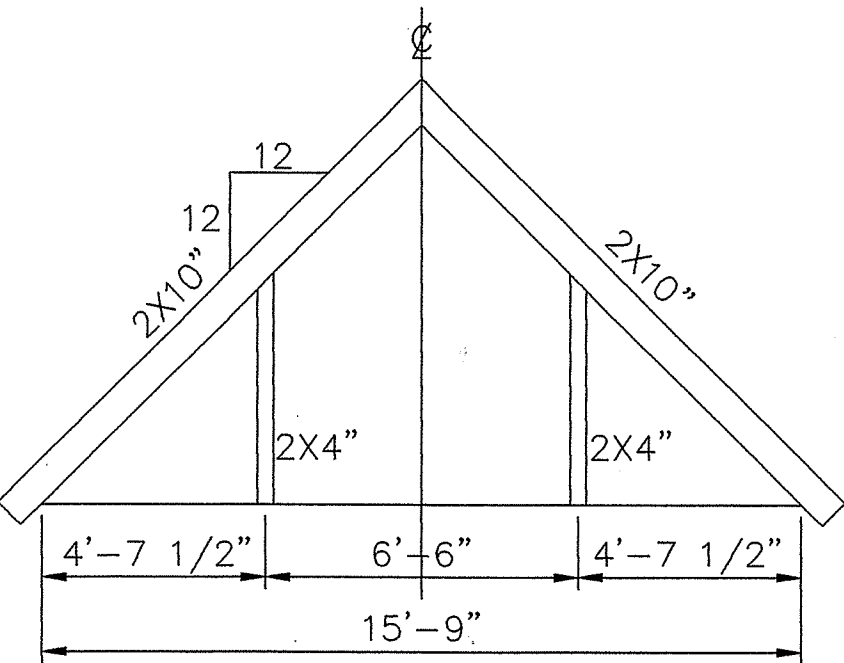


8 ROOF FRAME C
S2S3 SCALE: 1/4"=1.0'

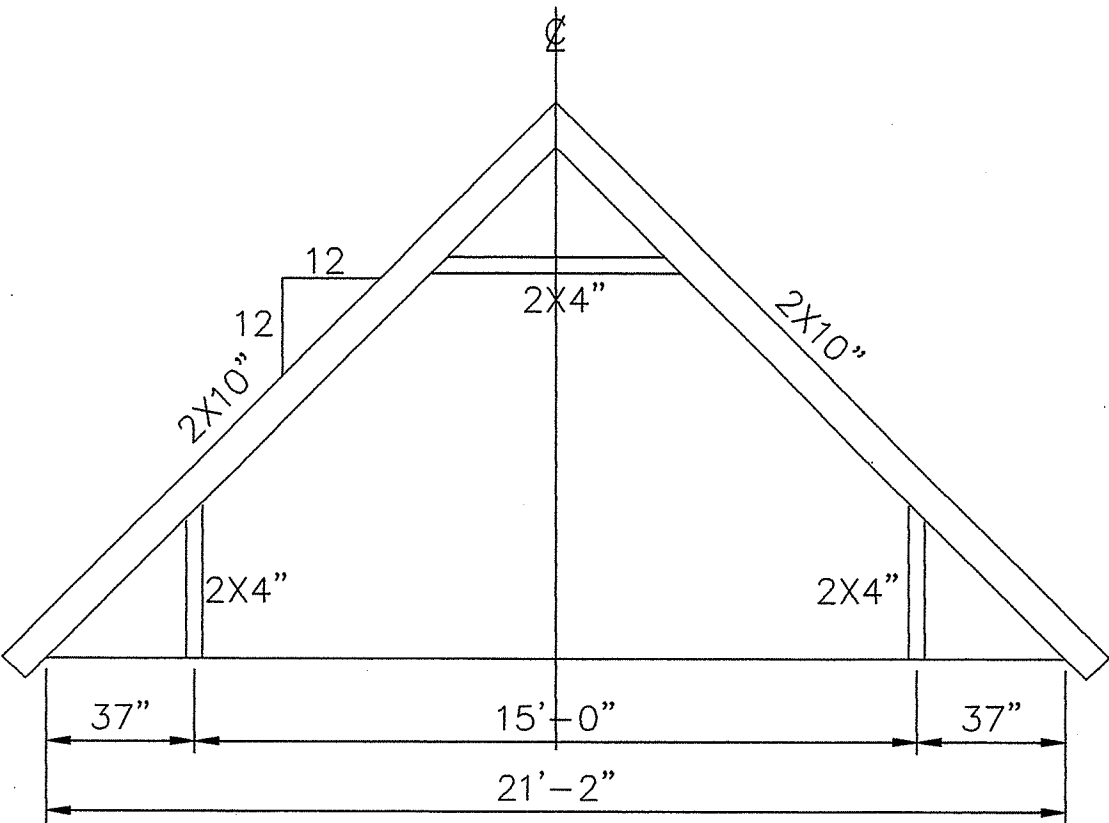

9 ROOF FRAME D
S2S3 SCALE: 1/4"=1.0'

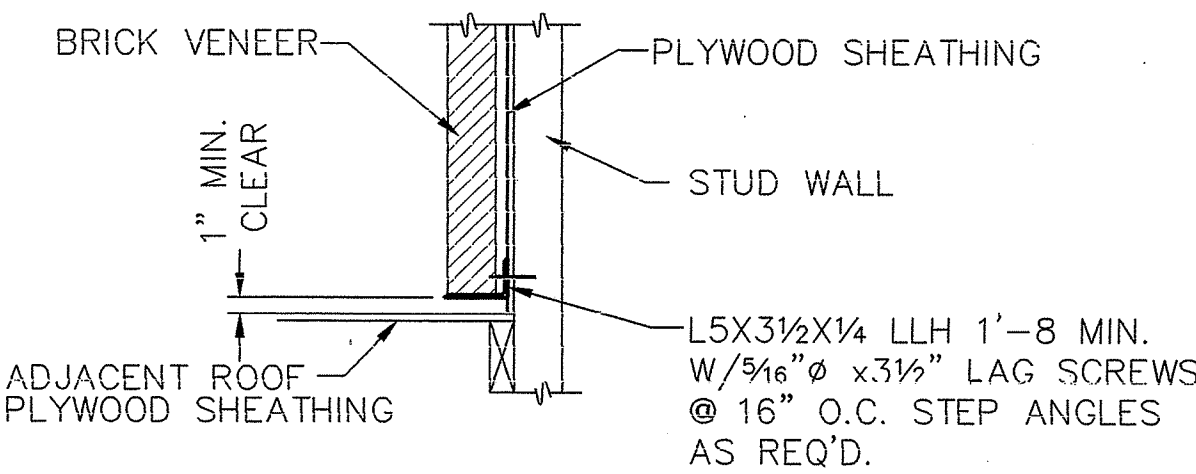

TYPICAL BRICK VENEER SUPPORT DETAIL
SCALE: 3/4" = 1'-0

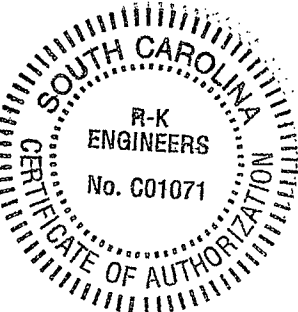

R - K ENGINEERS
CIVIL & STRUCTURAL ENGINEERING
59 WENTWORTH ST. CHARLESTON, SC 29401
(803) 577-2011

JOB NUMBER: 97047
JOB NAME: MOORE RESIDENCE
DESIGNED BY: SE
DRAWN BY: SM
APPROVED: RKG

ROOFING SECTIONS
& GENERAL NOTES
MOORE RESIDENCE
CHARLESTON, SC

R-K ENGINEERS
These documents and
drawings are the
exclusive property of
R-K ENGINEERS, and
are not to be
reproduced, copied,
or used in any way
without the written
consent of R-K
ENGINEERS. Any
violation of this
statement is
prohibited by law.

S3