

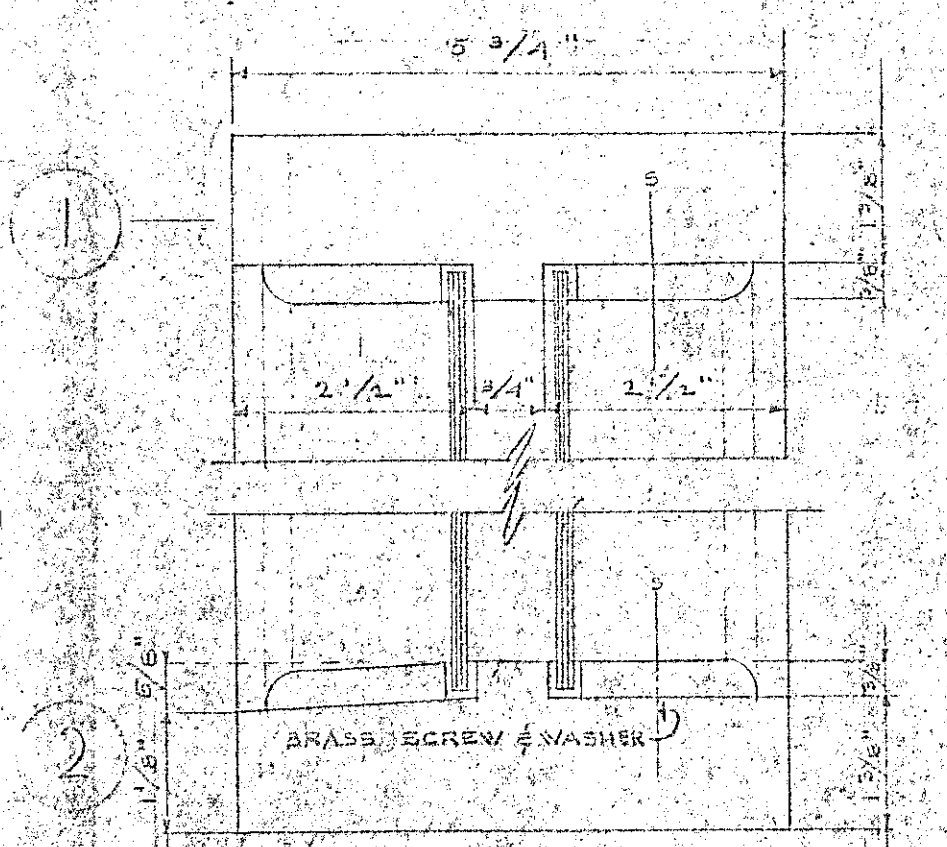
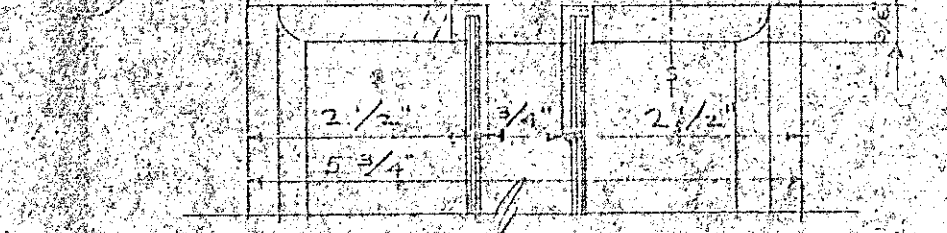
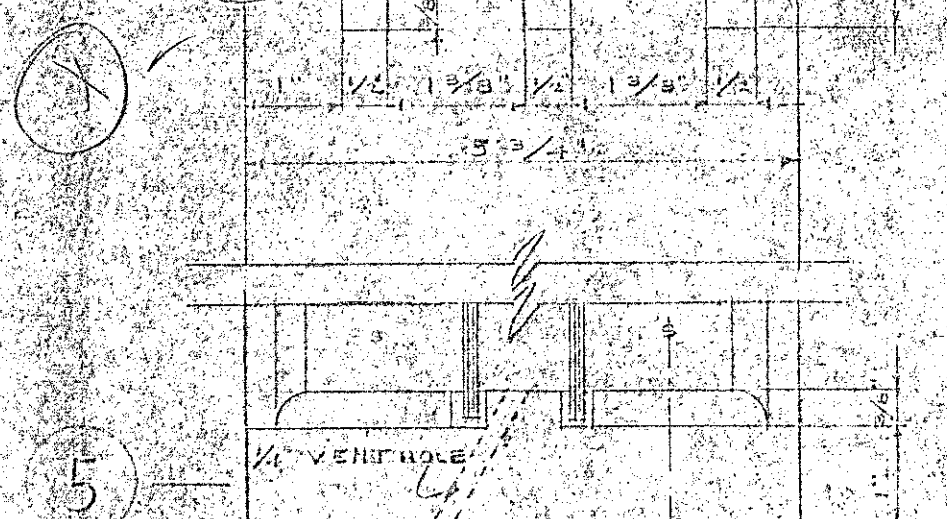










1A SAME AS 10, ADDING FRAME FOR D.H. SASH AS IN NUMBER 4

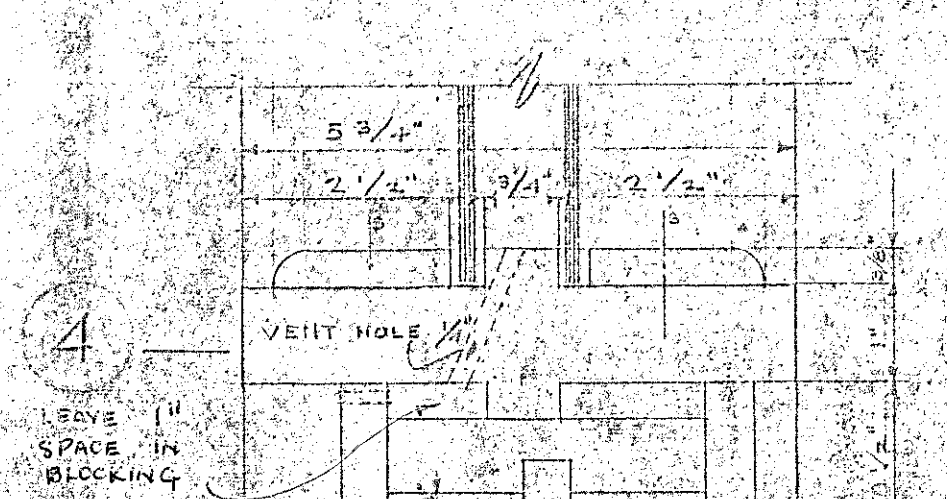


NOTE: INSIDE STOPS FOR FIXED GLASS TO BE FASTENED WITH BRASS SCREWS & WASHERS 3\"/>

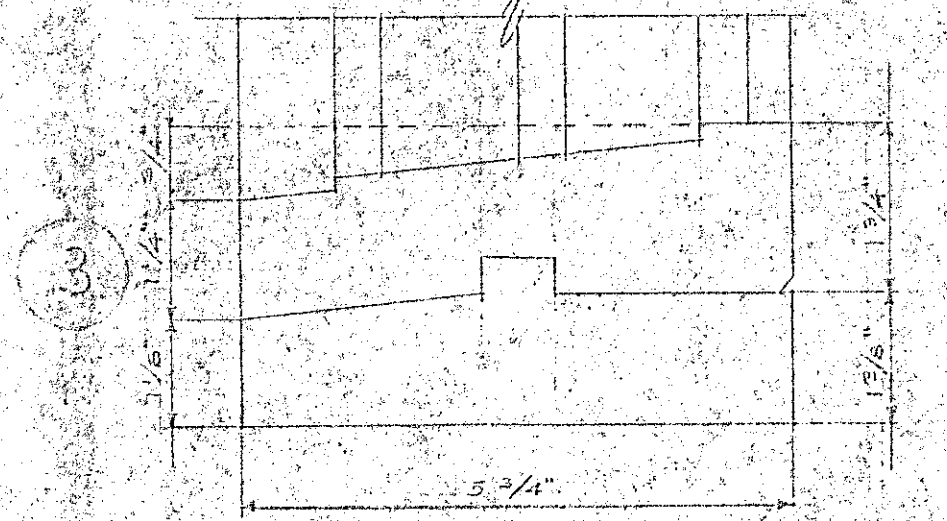




FRAME SECTIONS SCALE 1/4\"/>

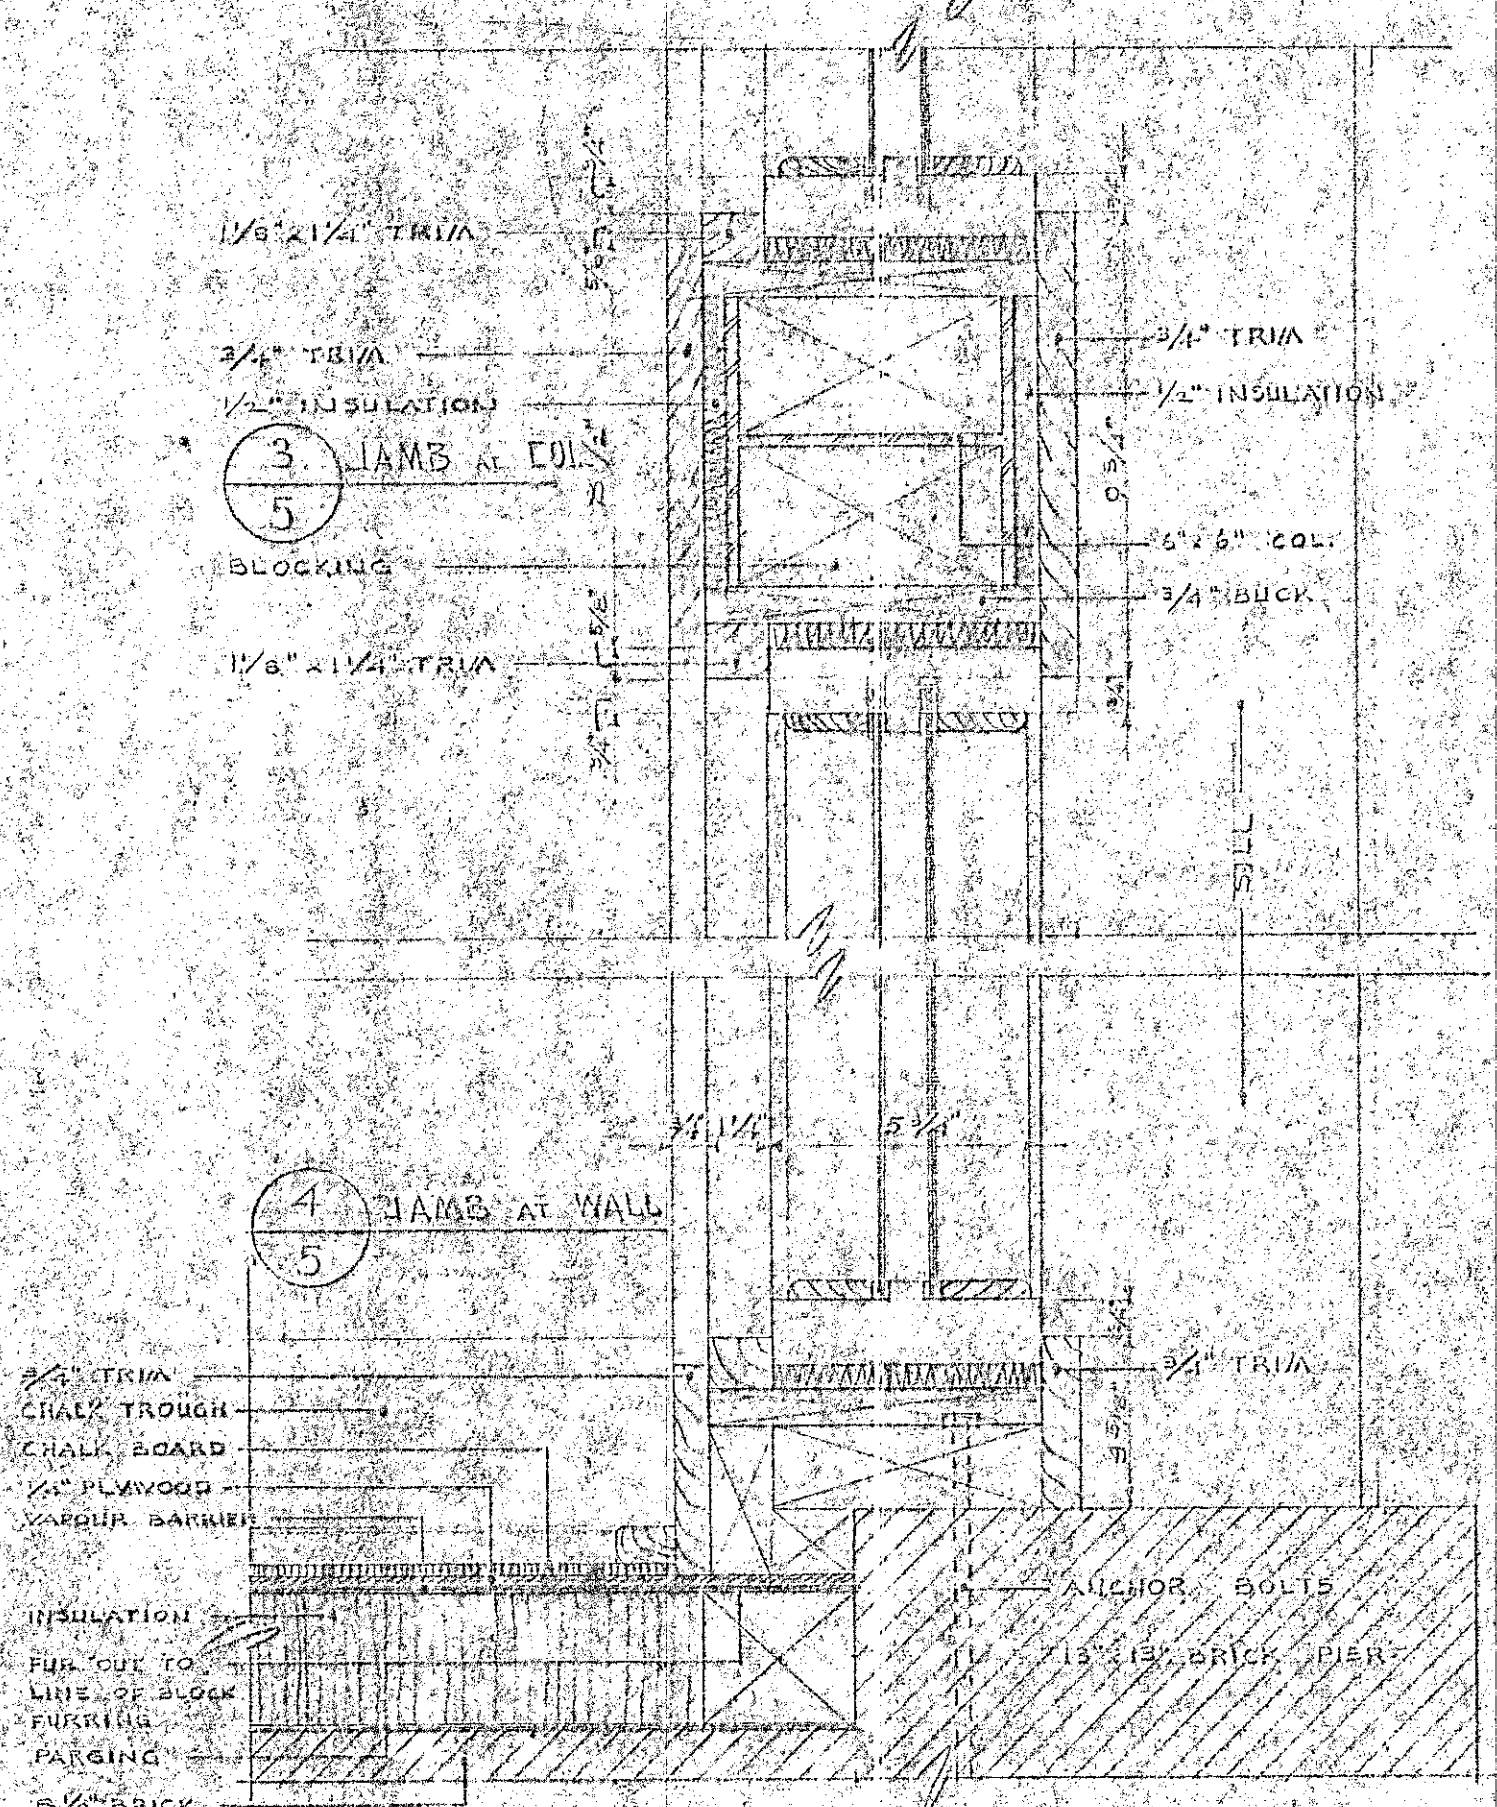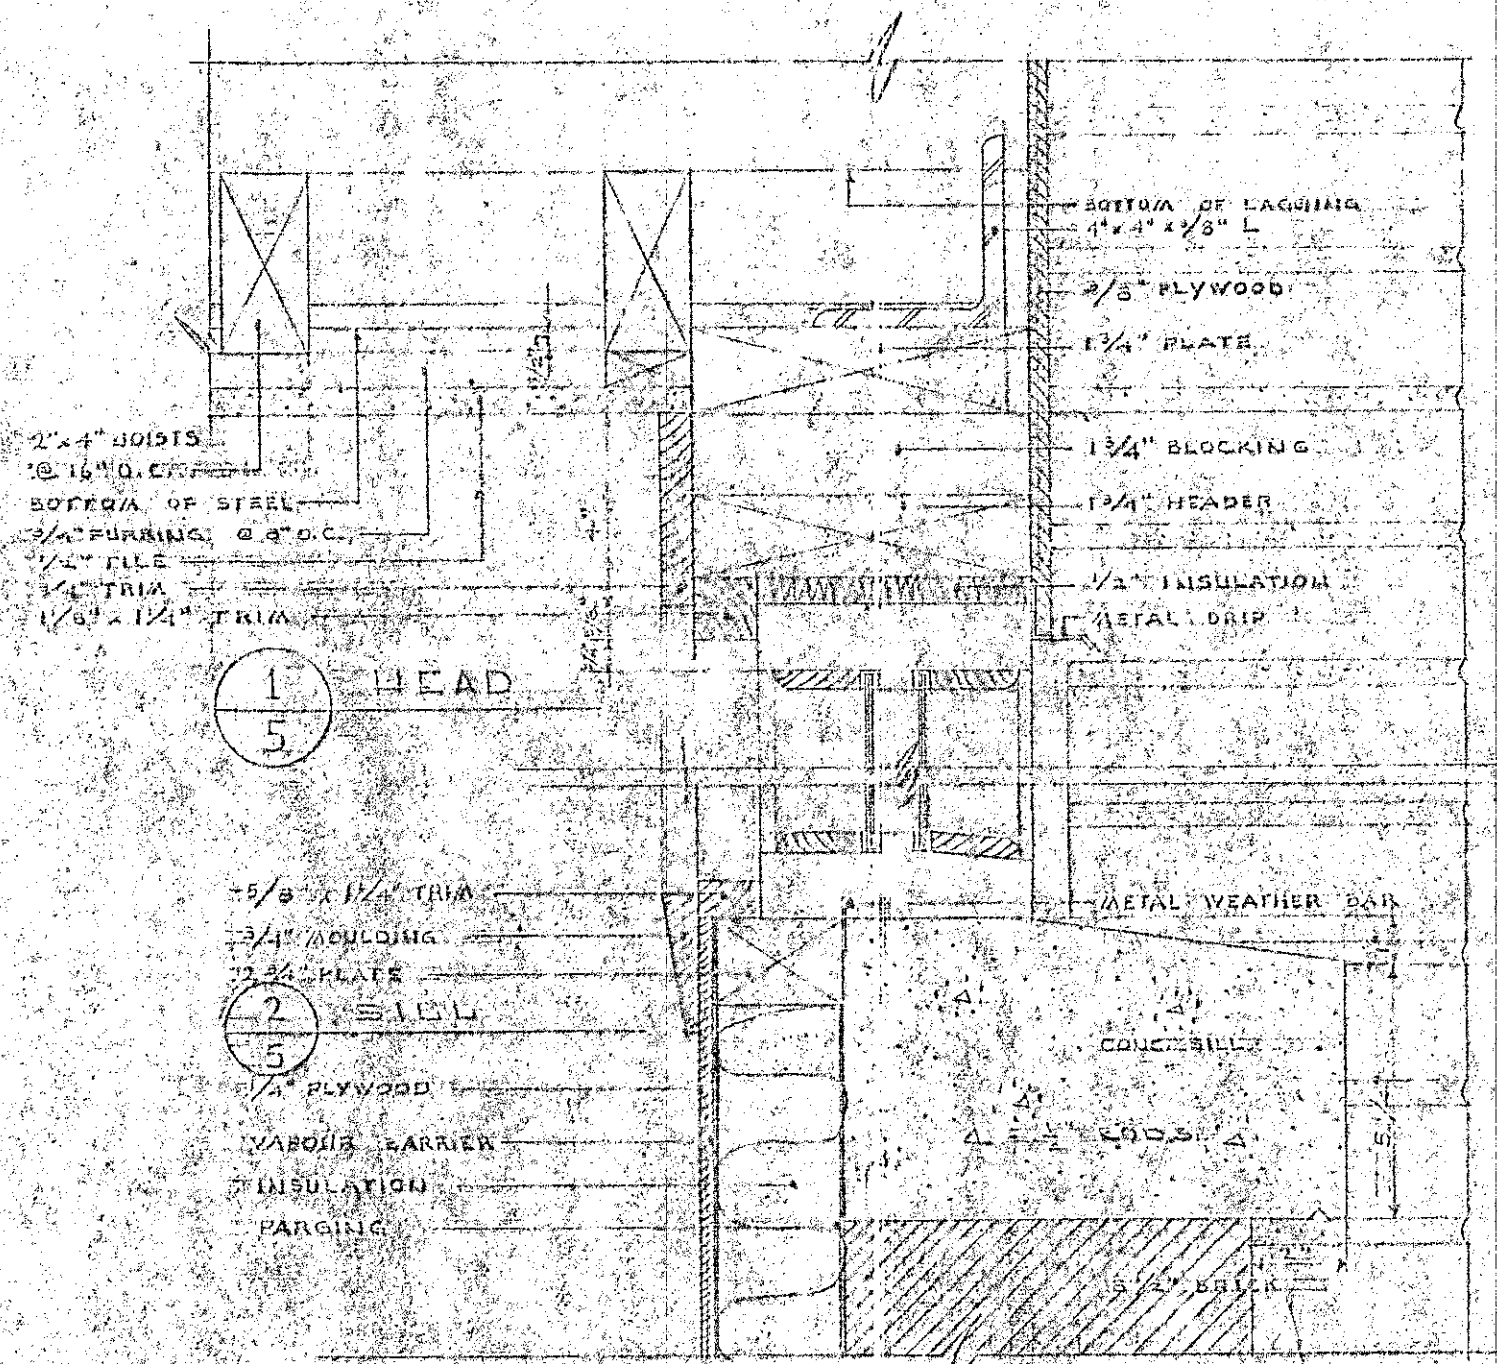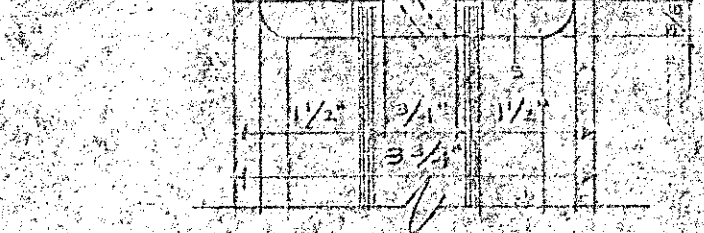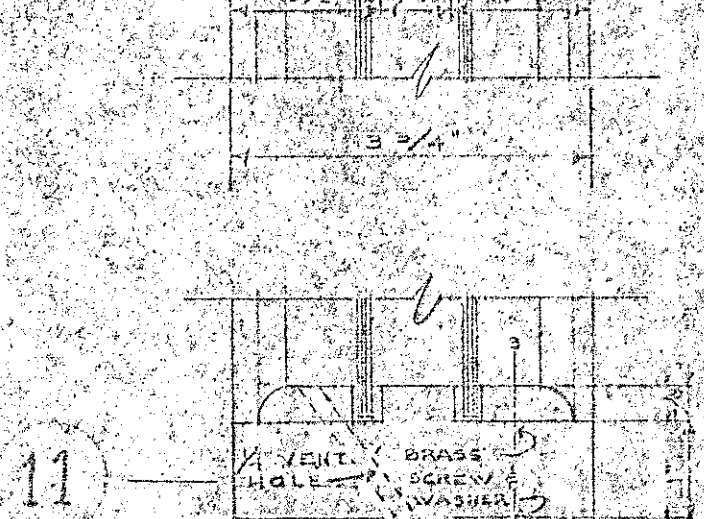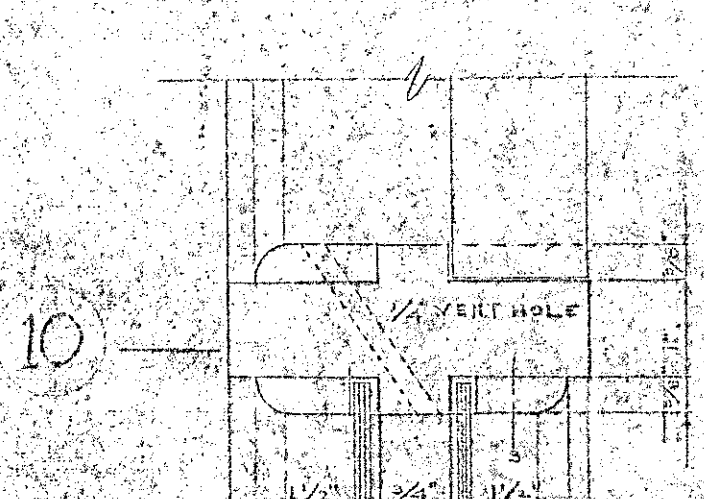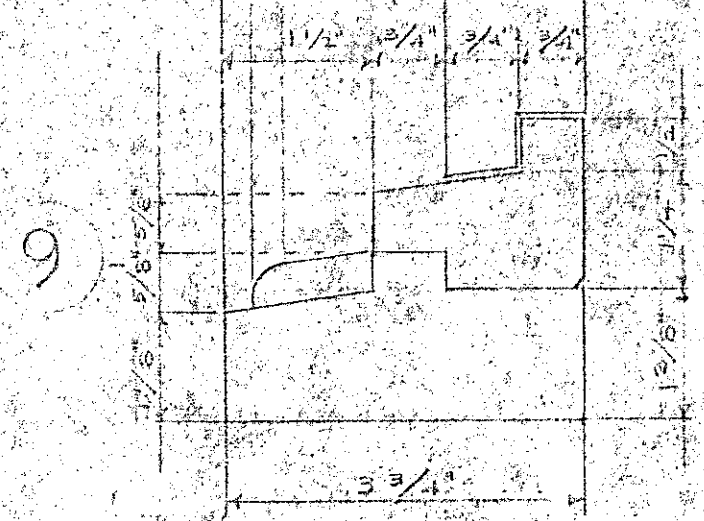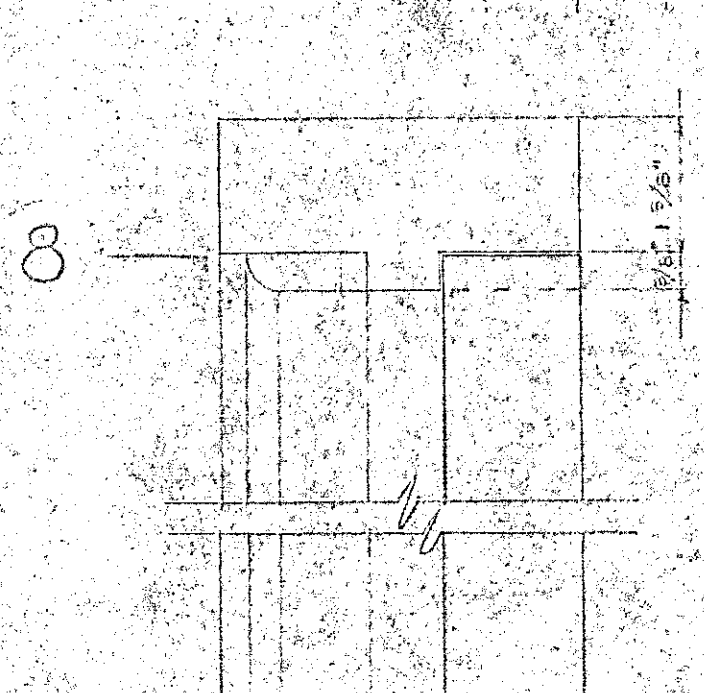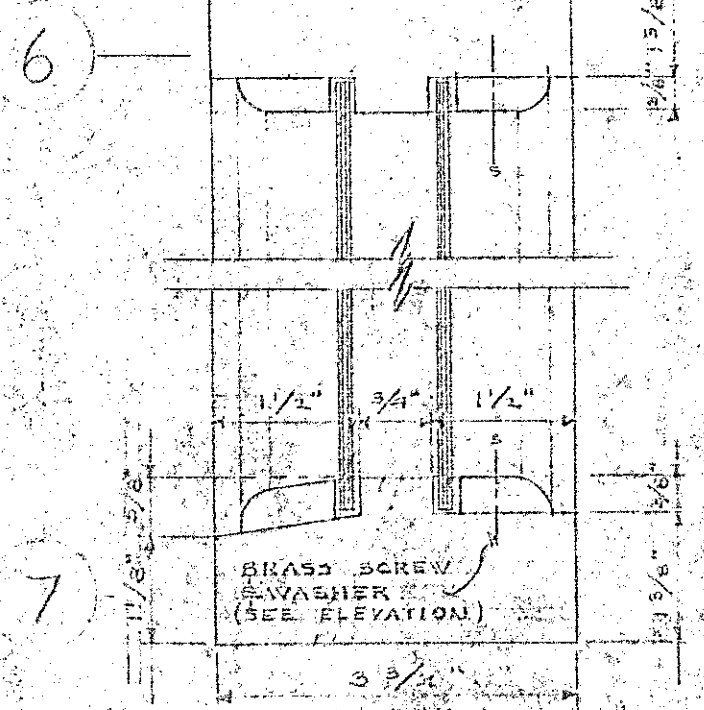


WINDOW SECTIONS SCALE 1/8\"/>

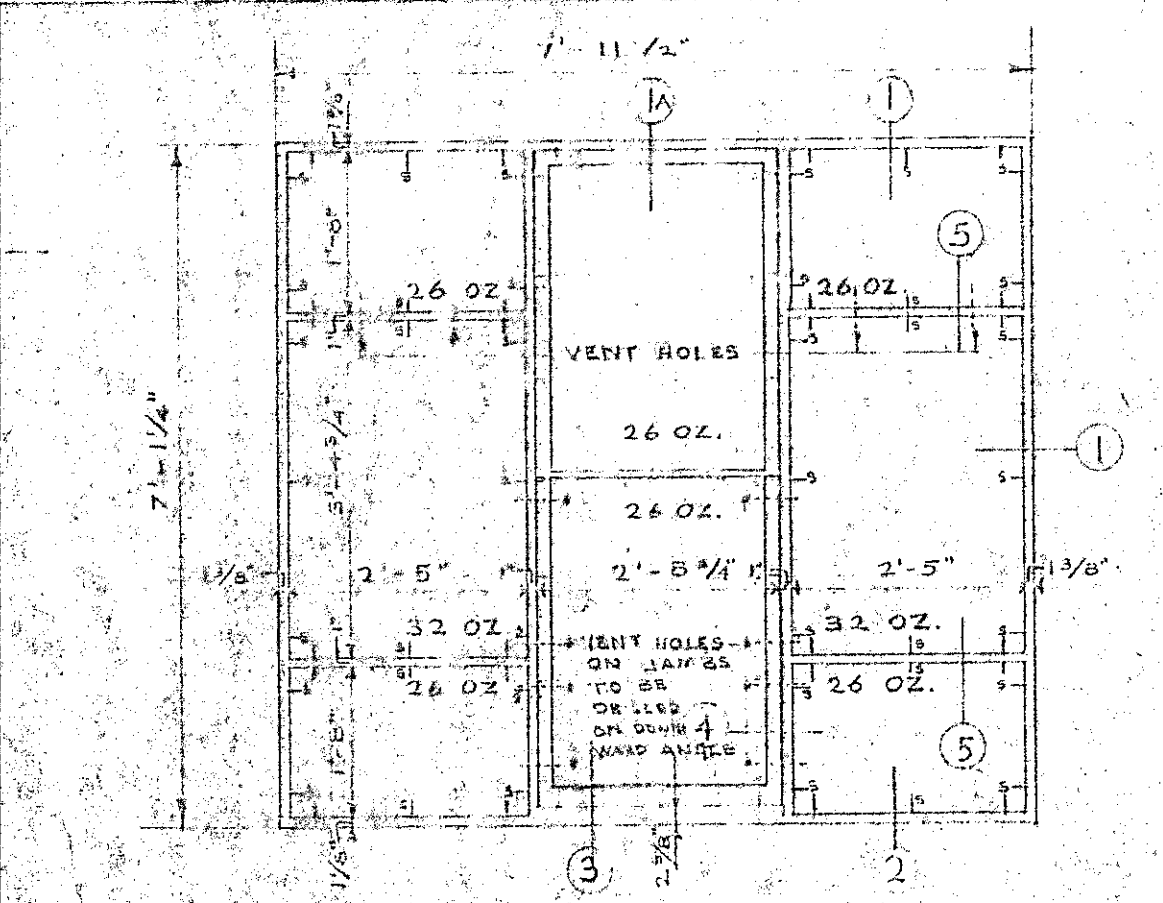


CLASSRM WINDOW ELEVATION SCALE 1/4\"/>

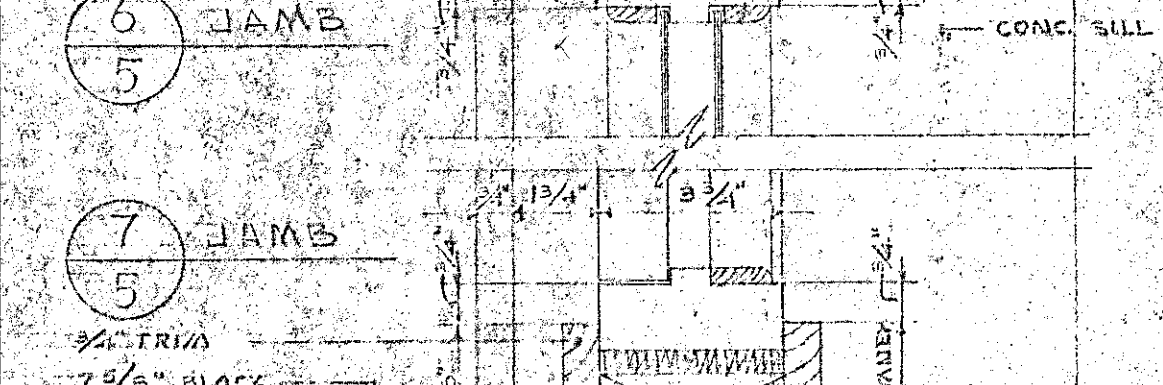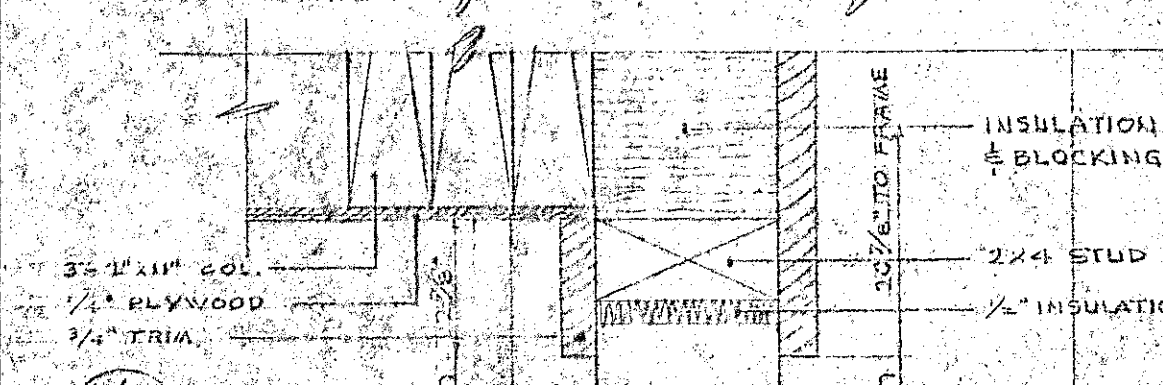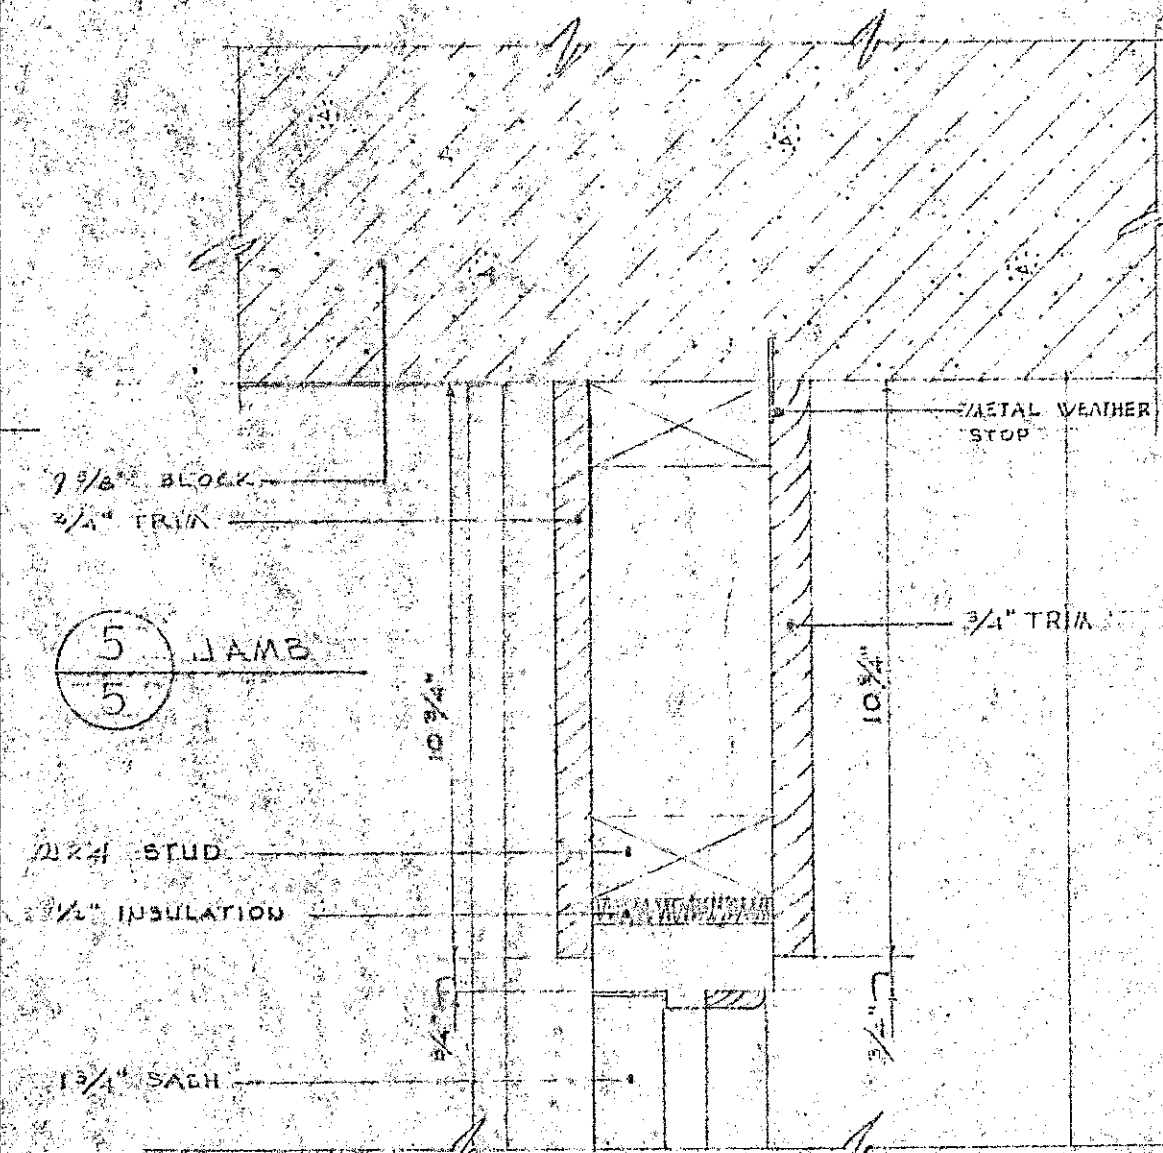

WINDOW SECTIONS SCALE 1/8\"/>

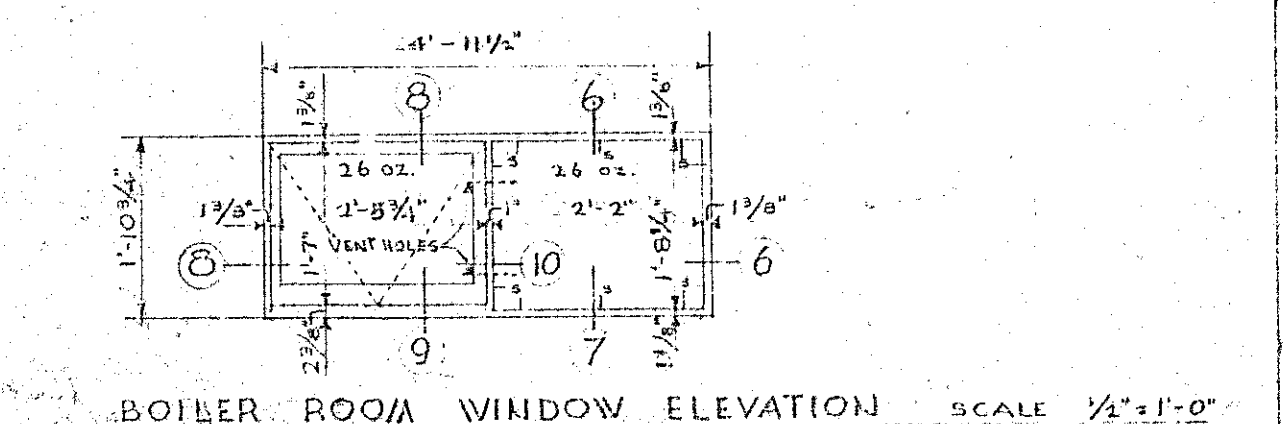


BOILER ROOM WINDOW ELEVATION SCALE 1/2\"/>

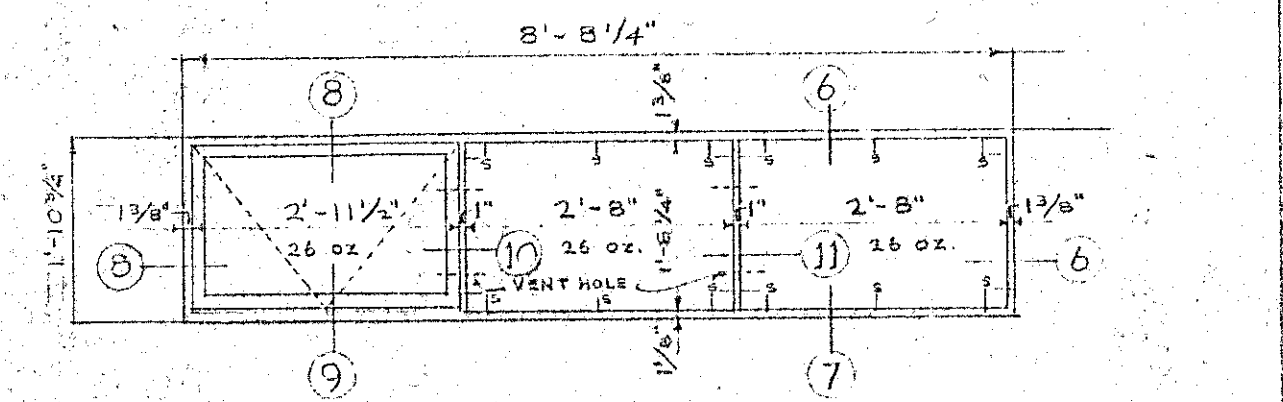


BOY'S WASHROOM WINDOW ELEVATION SCALE 1/2\"/>

NOTE: OPENING SASH CHANGED TO OTHER SIDE IN GIRL'S WASHROOM WINDOW ELEVATION SEE SOUTH ELEVATION SHEET NUMBER 2

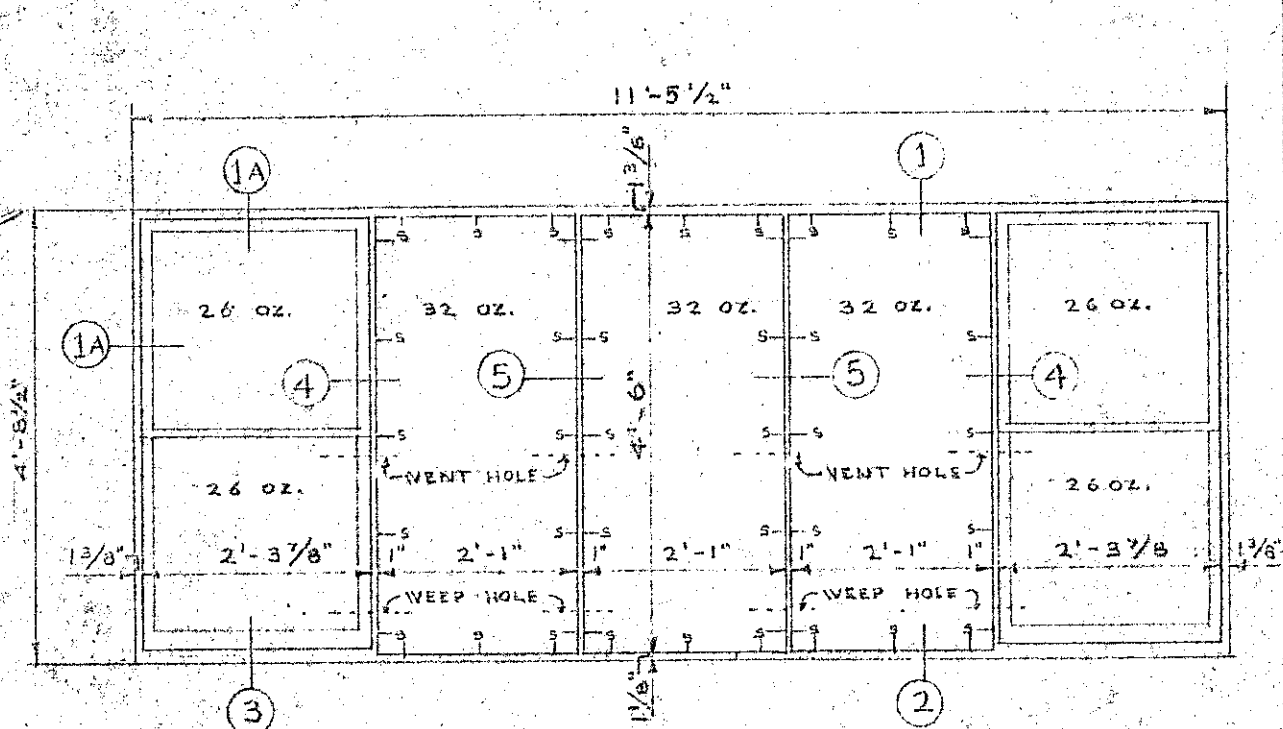

TEACHERS' RM. WINDOW ELEVATION SCALE 1/2\"/>







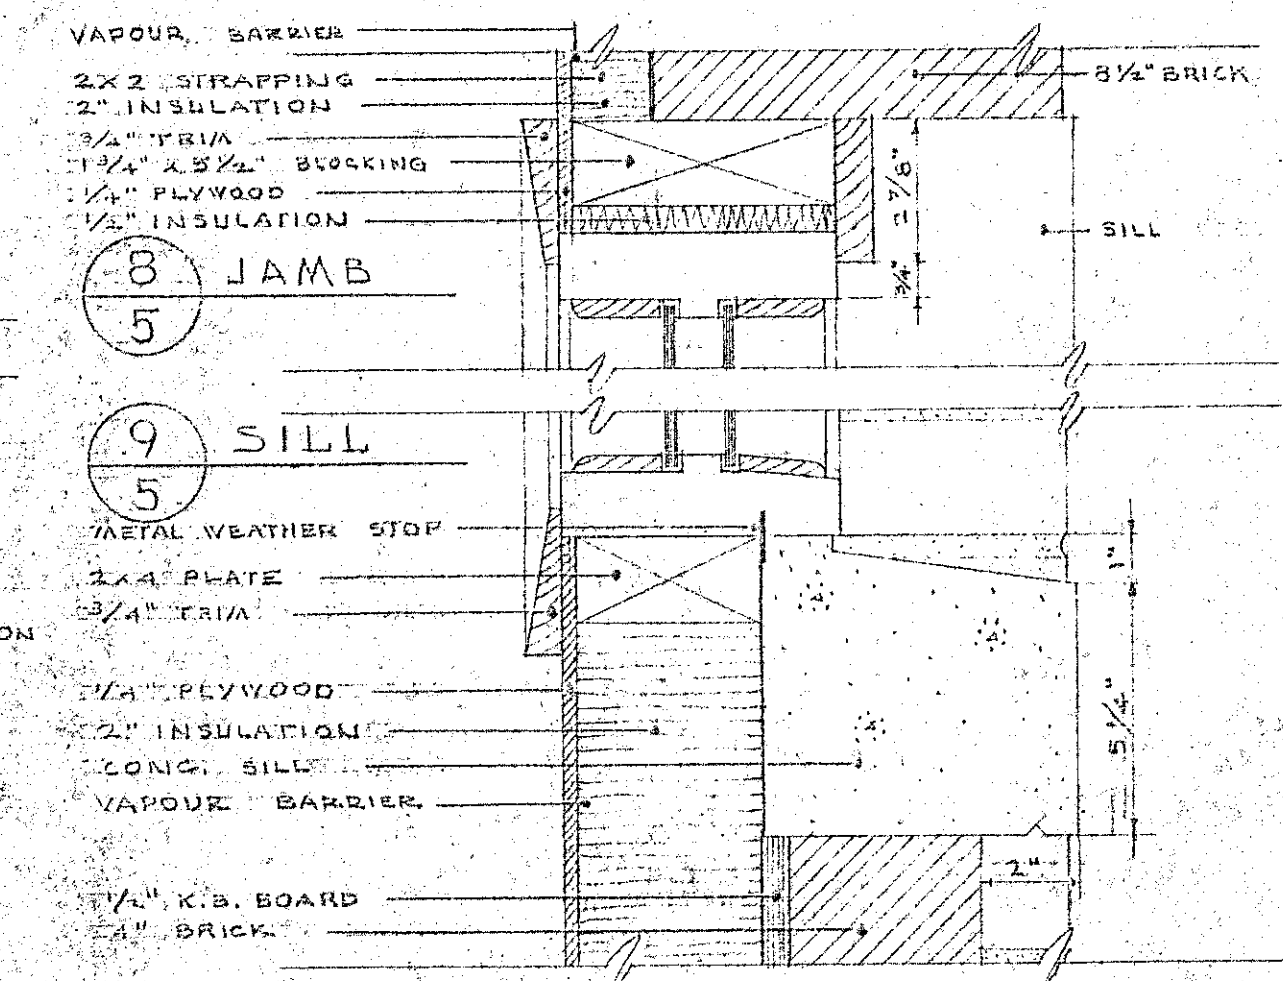


WINDOW SECTIONS SCALE 3/8\"/>

APPROVED: J. H. Wilson, OWNER; W. G. Watkins, CONTRACTOR

BYRNES AVE. SCHOOL, S.S. NO. 11, NOTTAWASAGA

WINDOW DETAILS			
W. J. CARSWELL, ARCHITECT, COLLINGWOOD, ONT.			
DRAWN K.M.S.	CHECK SCALE	PROJECT NUMBER	DRAWING NUMBER
DATE 7-6-55	NOTED	157	5

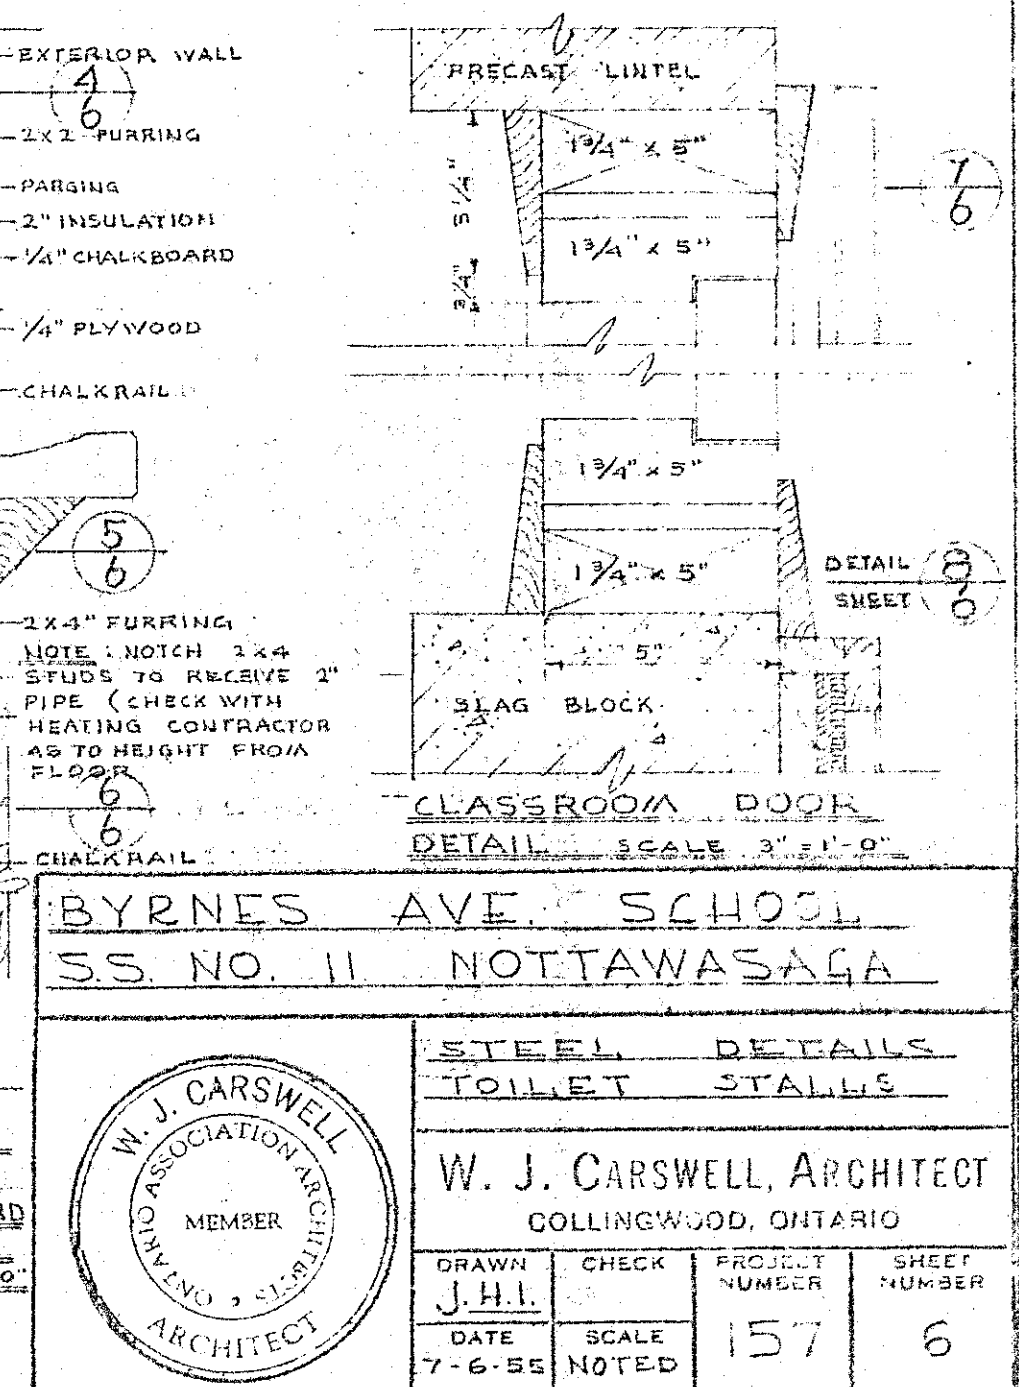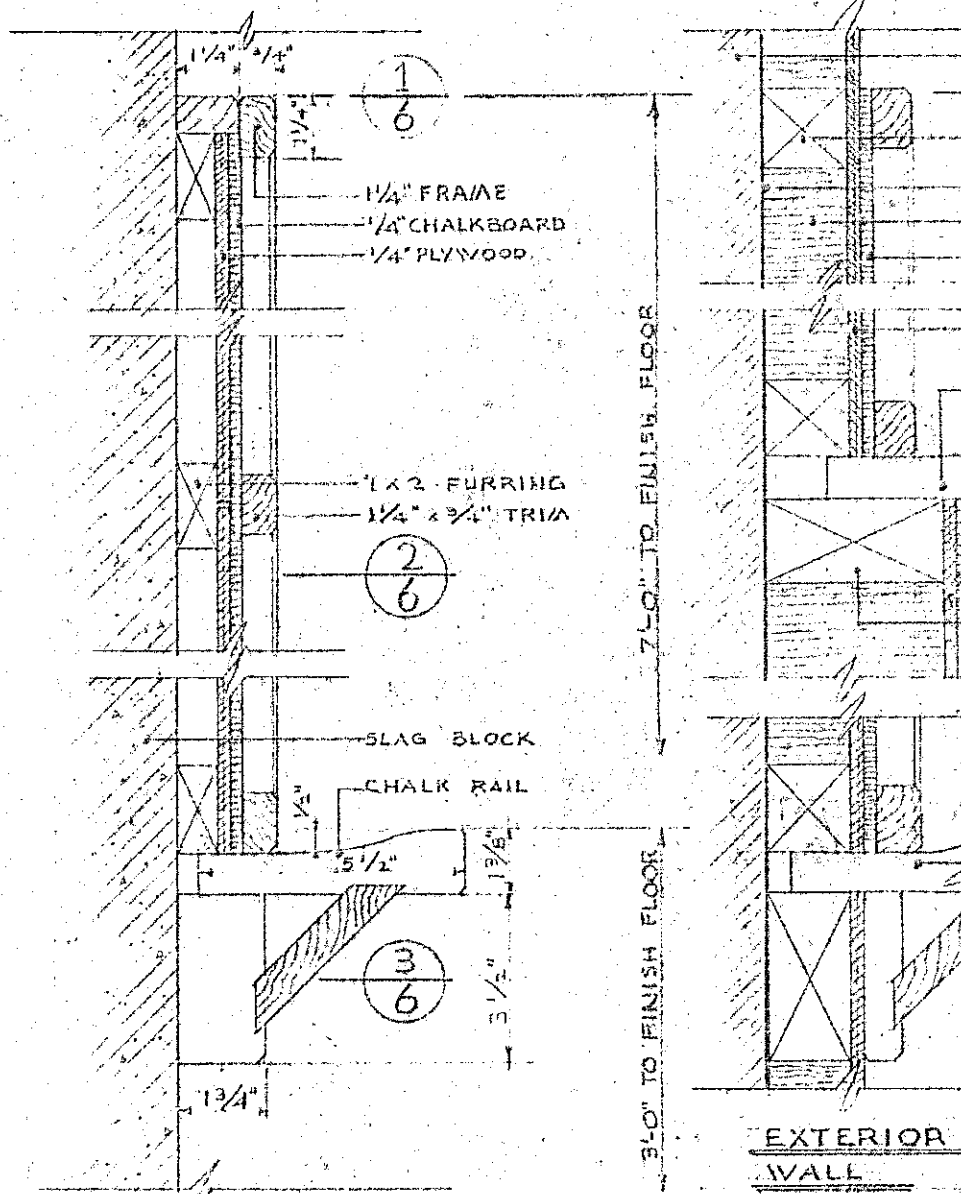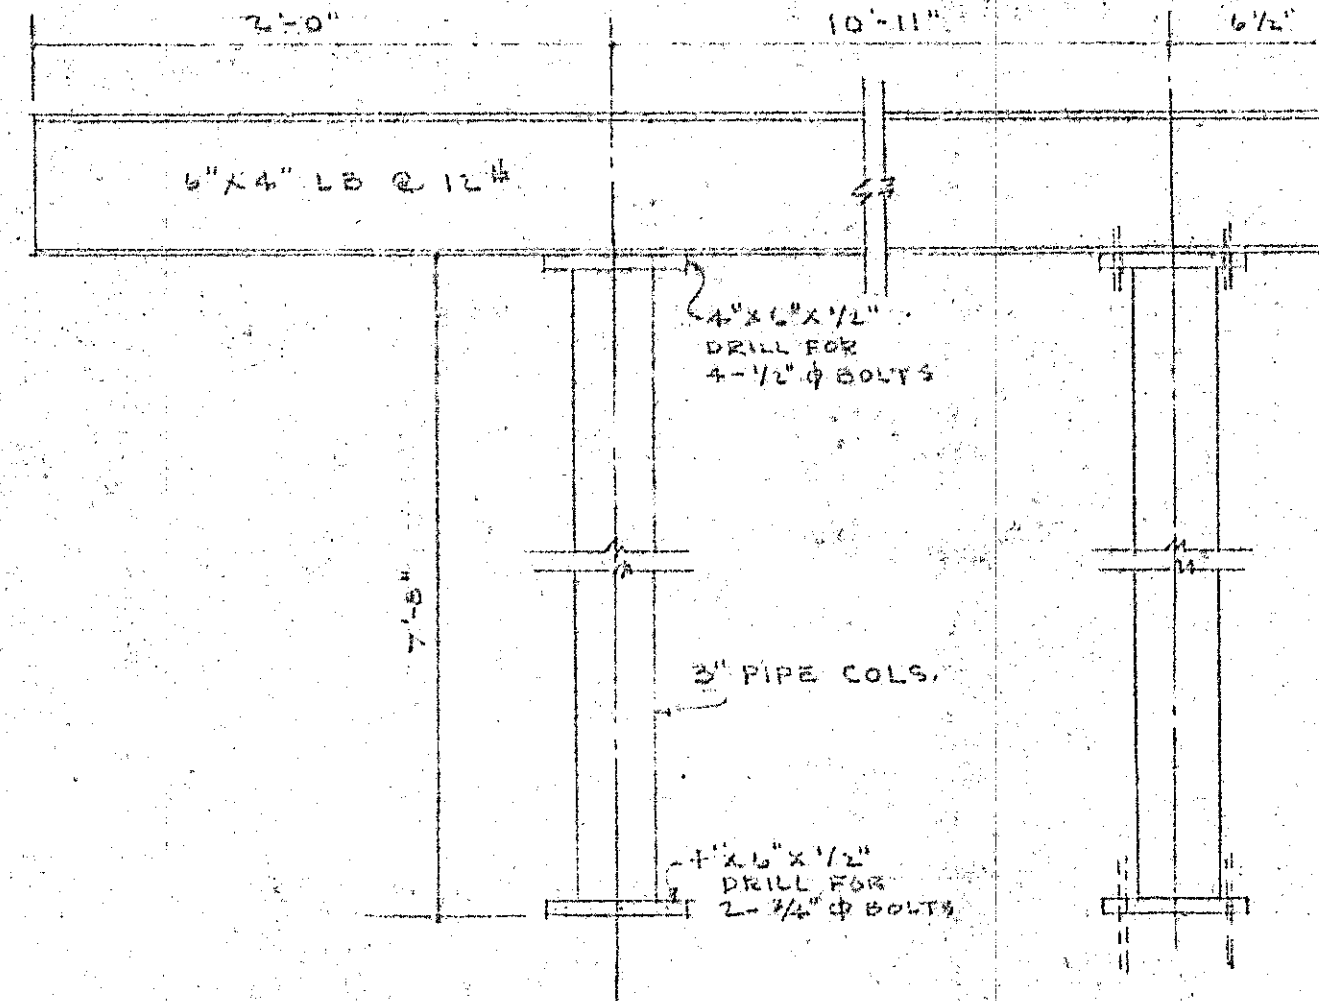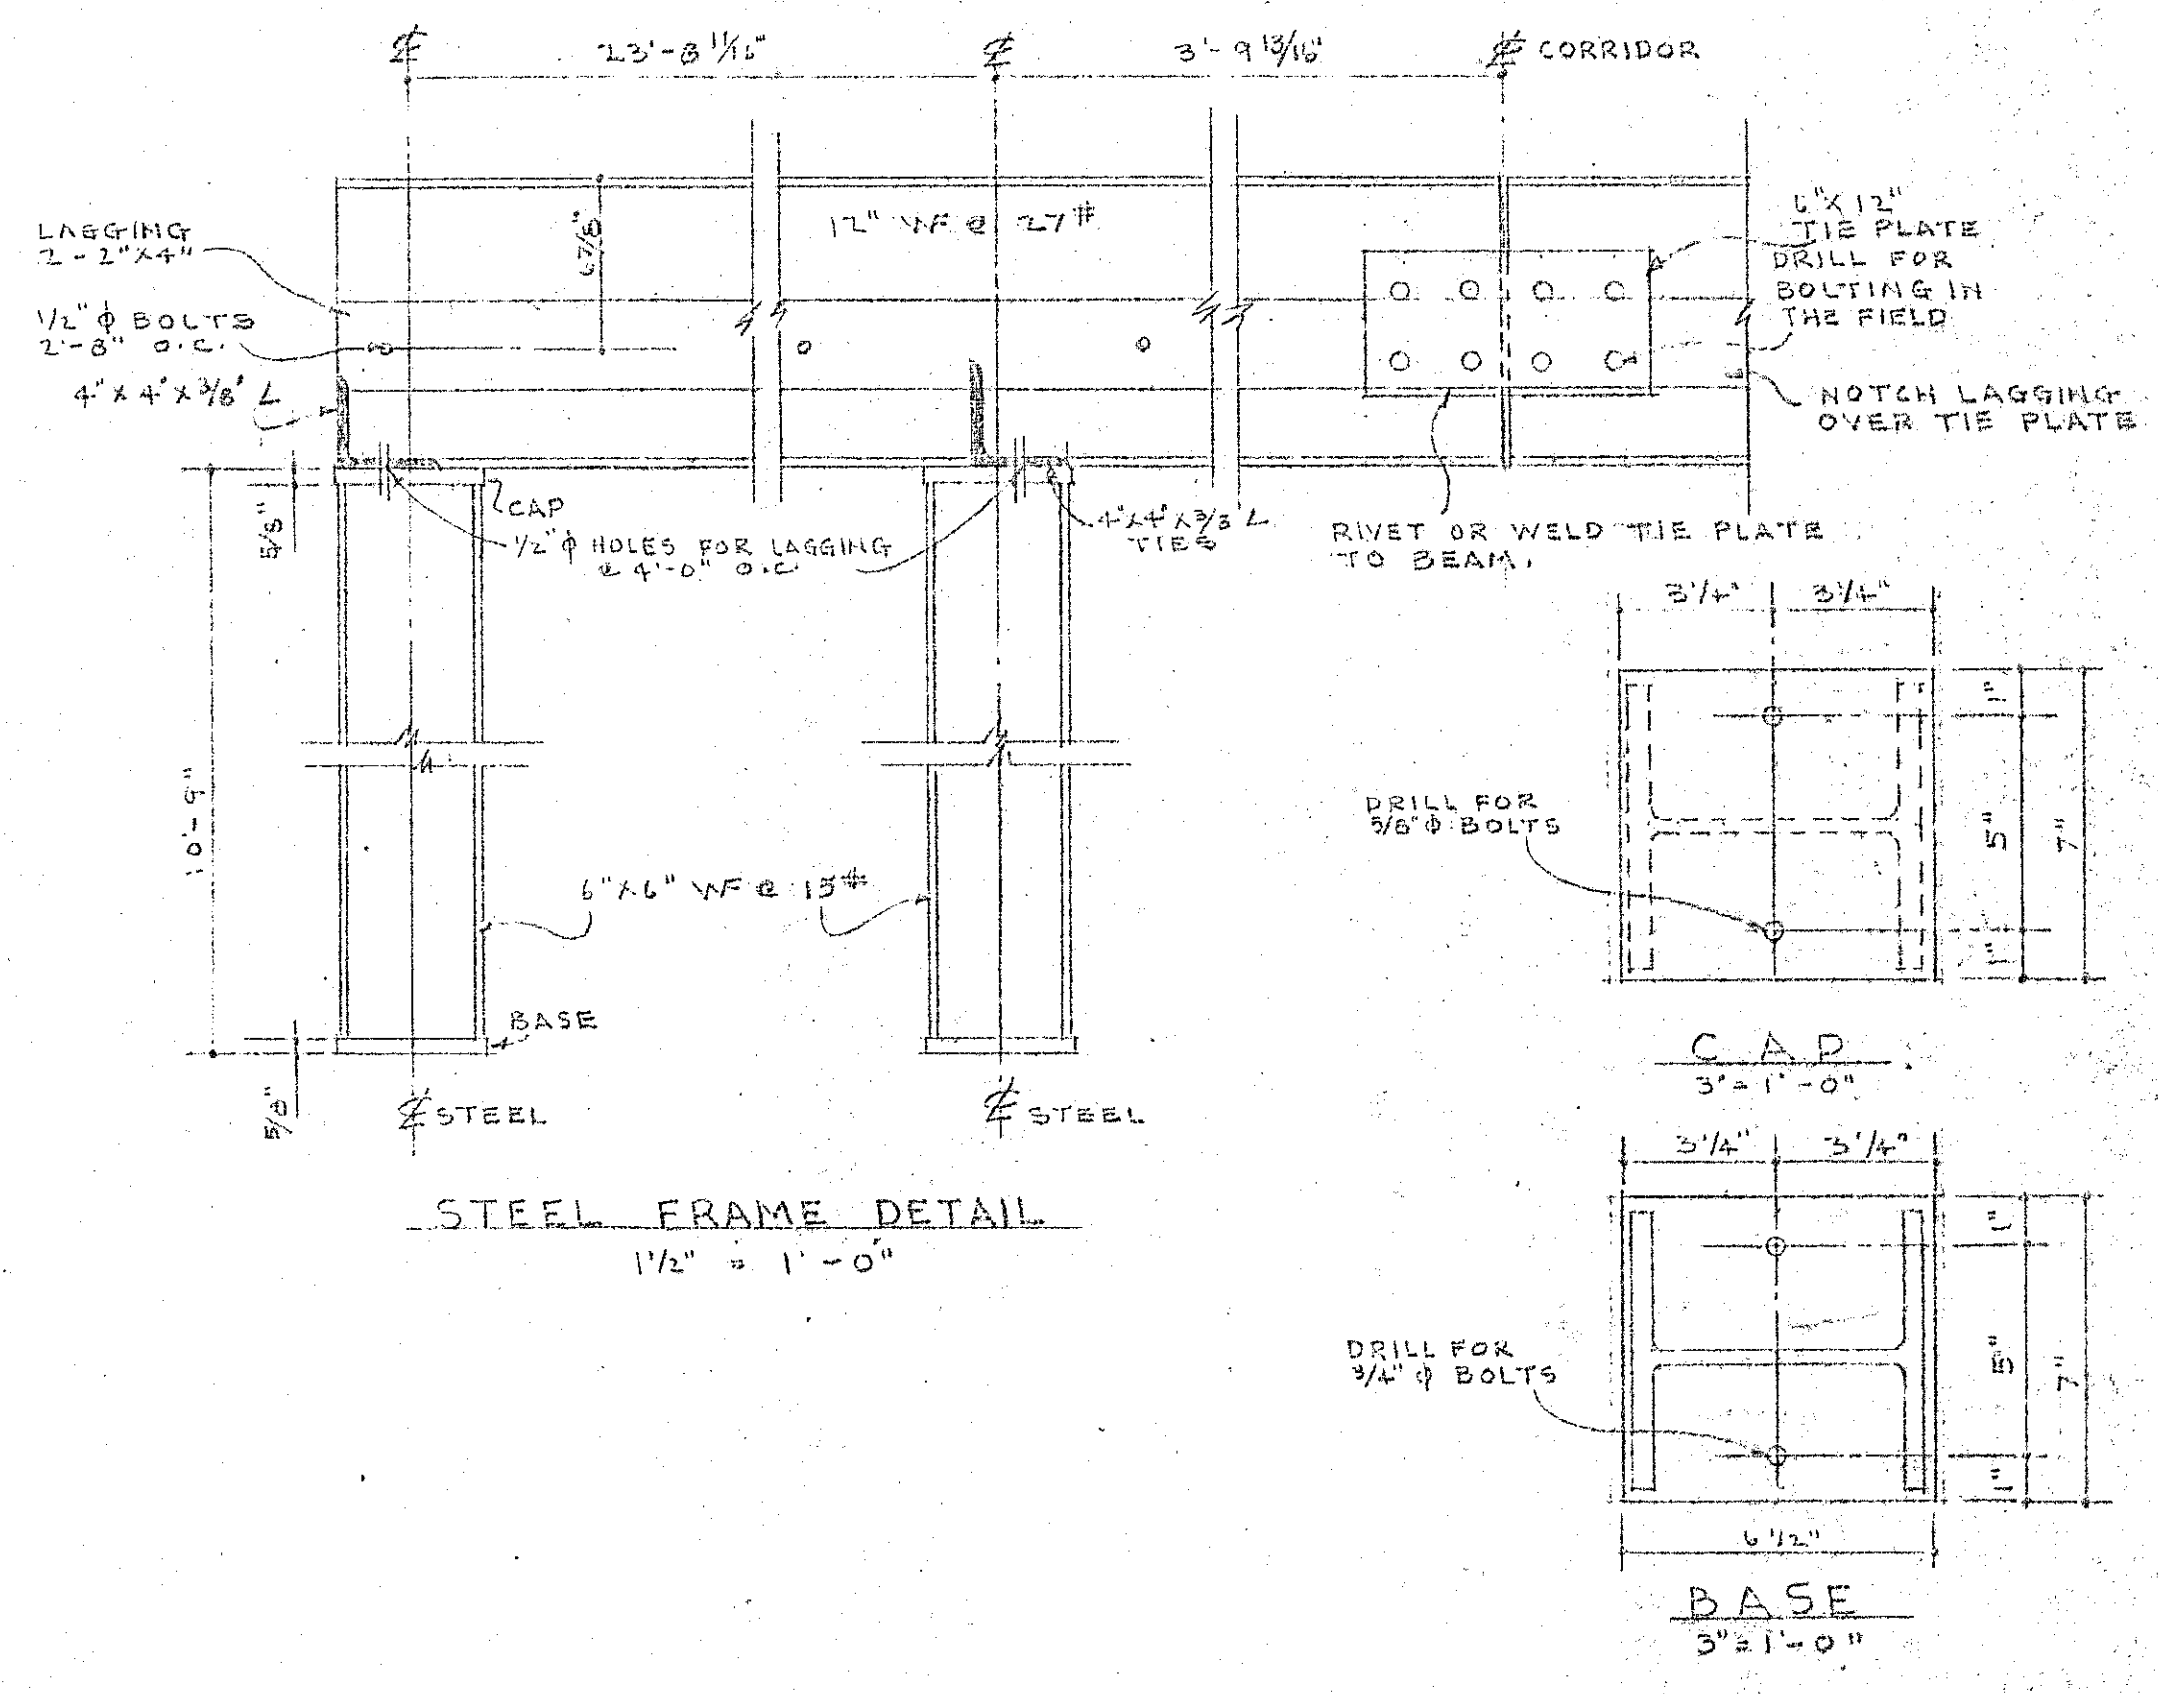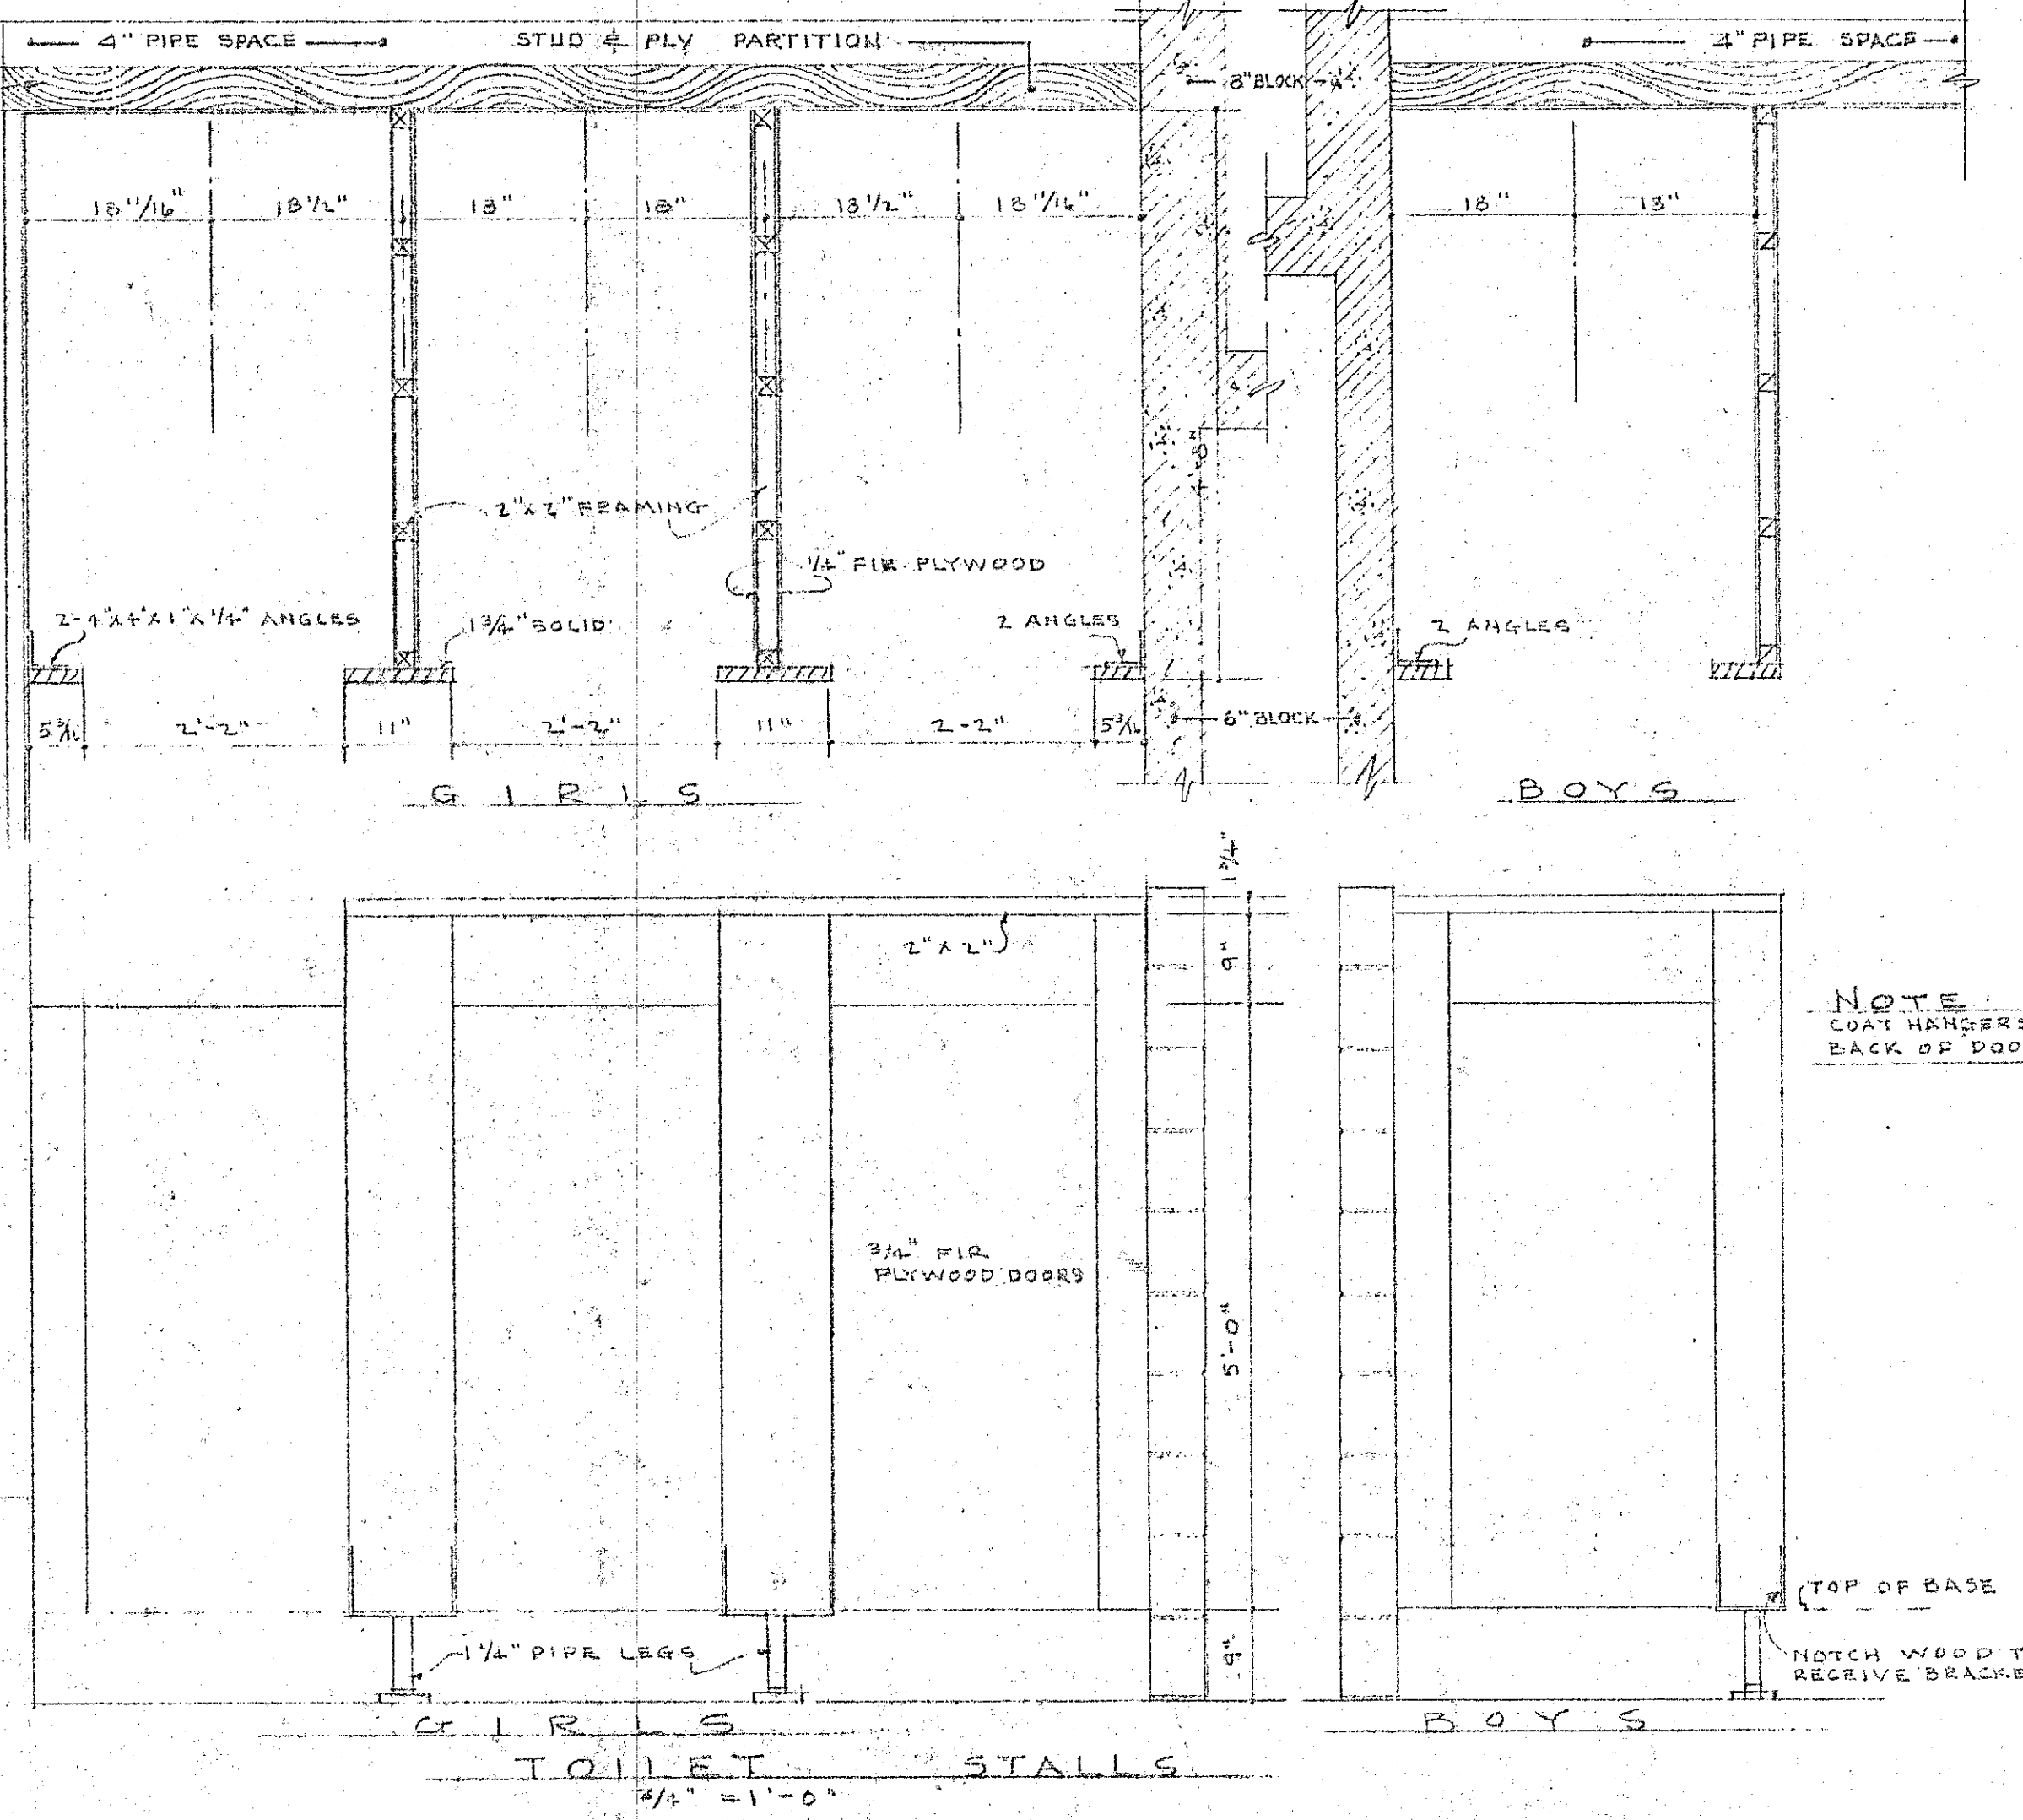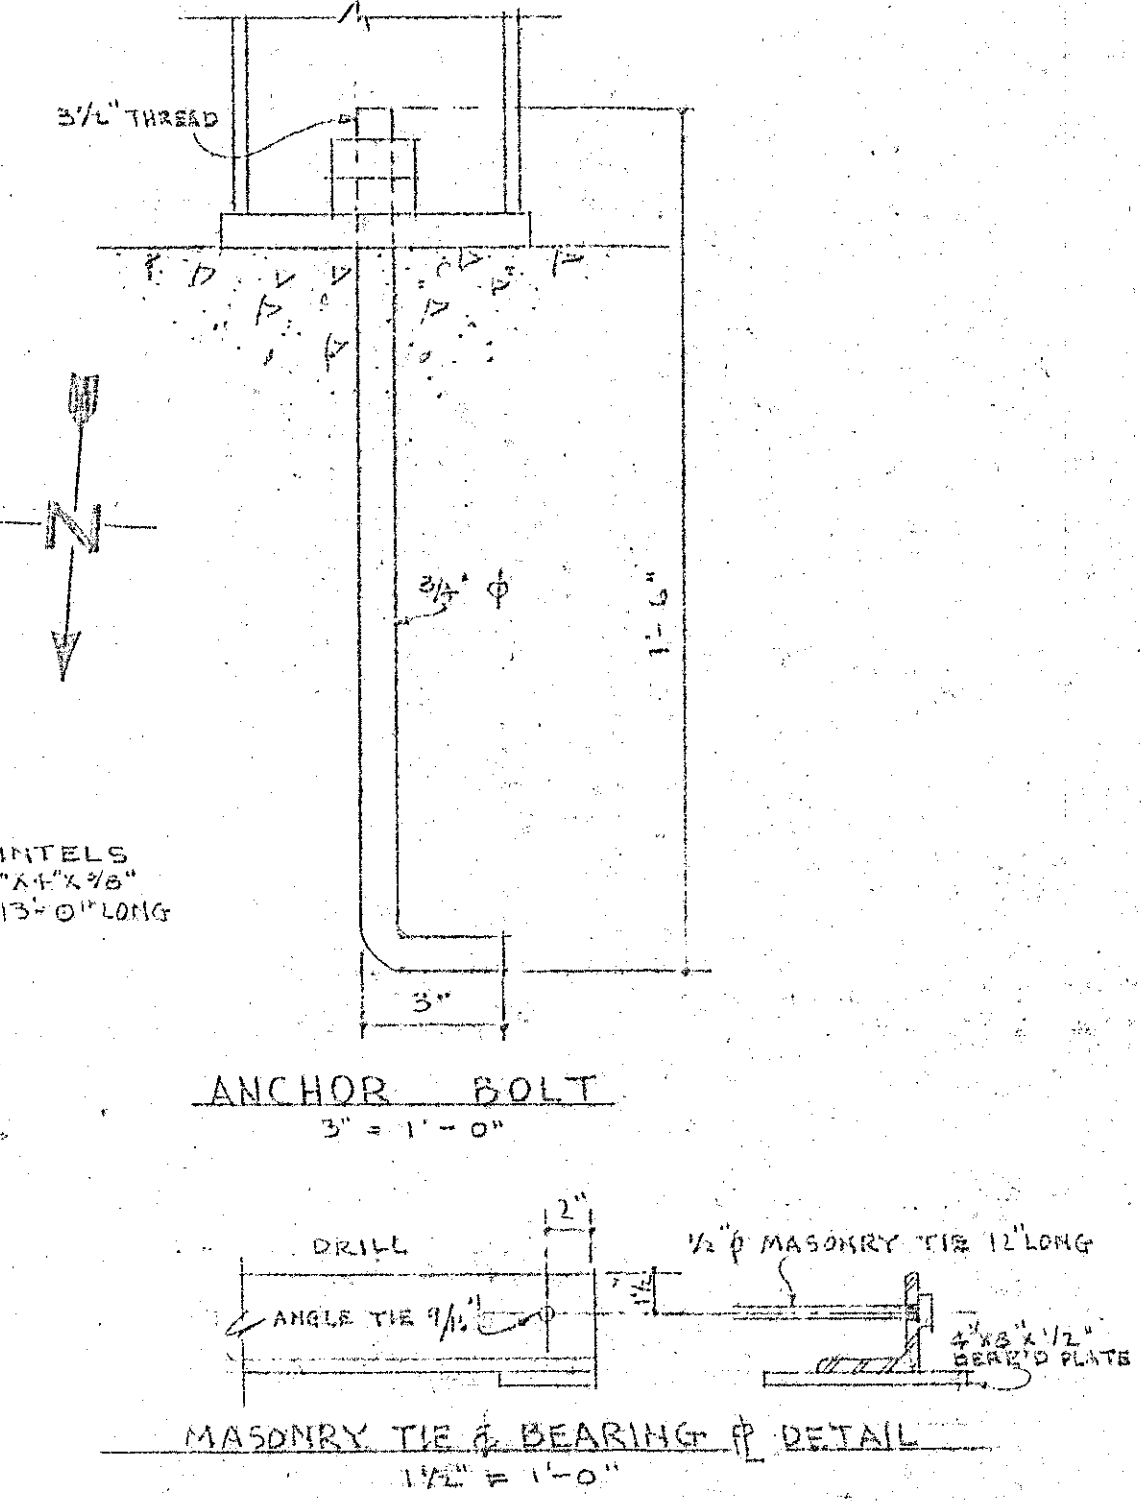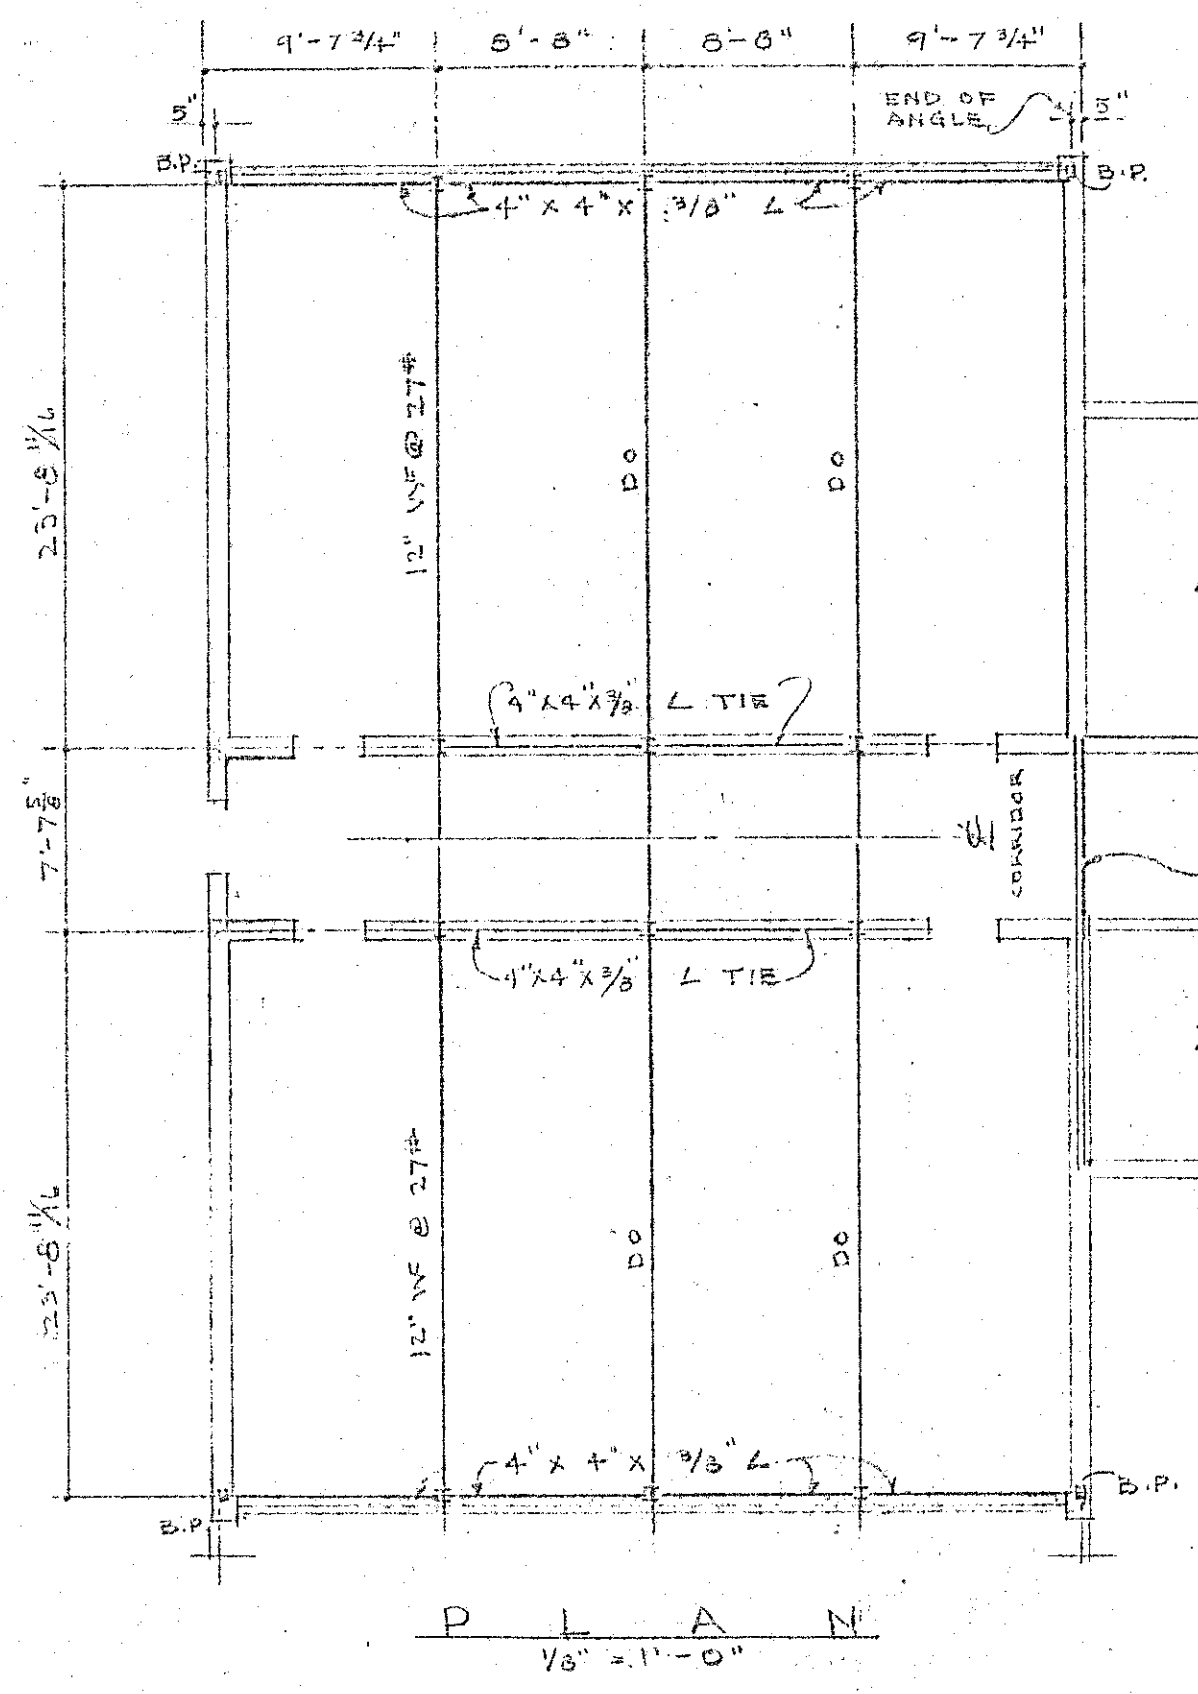

BYRNES AVE. SCHOOL
SS. NO. 11 NOTTAWASAGA


W. J. CARSWELL ARCHITECT
COLLINGWOOD, ONTARIO

STEEL DETAILS
TOILET STALLS


W. J. CARSWELL ARCHITECT
MEMBER
ON. ASSOCIATION OF ARCHITECTS

DRAWN J.H.I.	CHECK J.H.I.	PROJECT NUMBER 157	SHEET NUMBER 6
DATE 7-6-55	SCALE NOTED		


W. G. WATKINS LIMITED

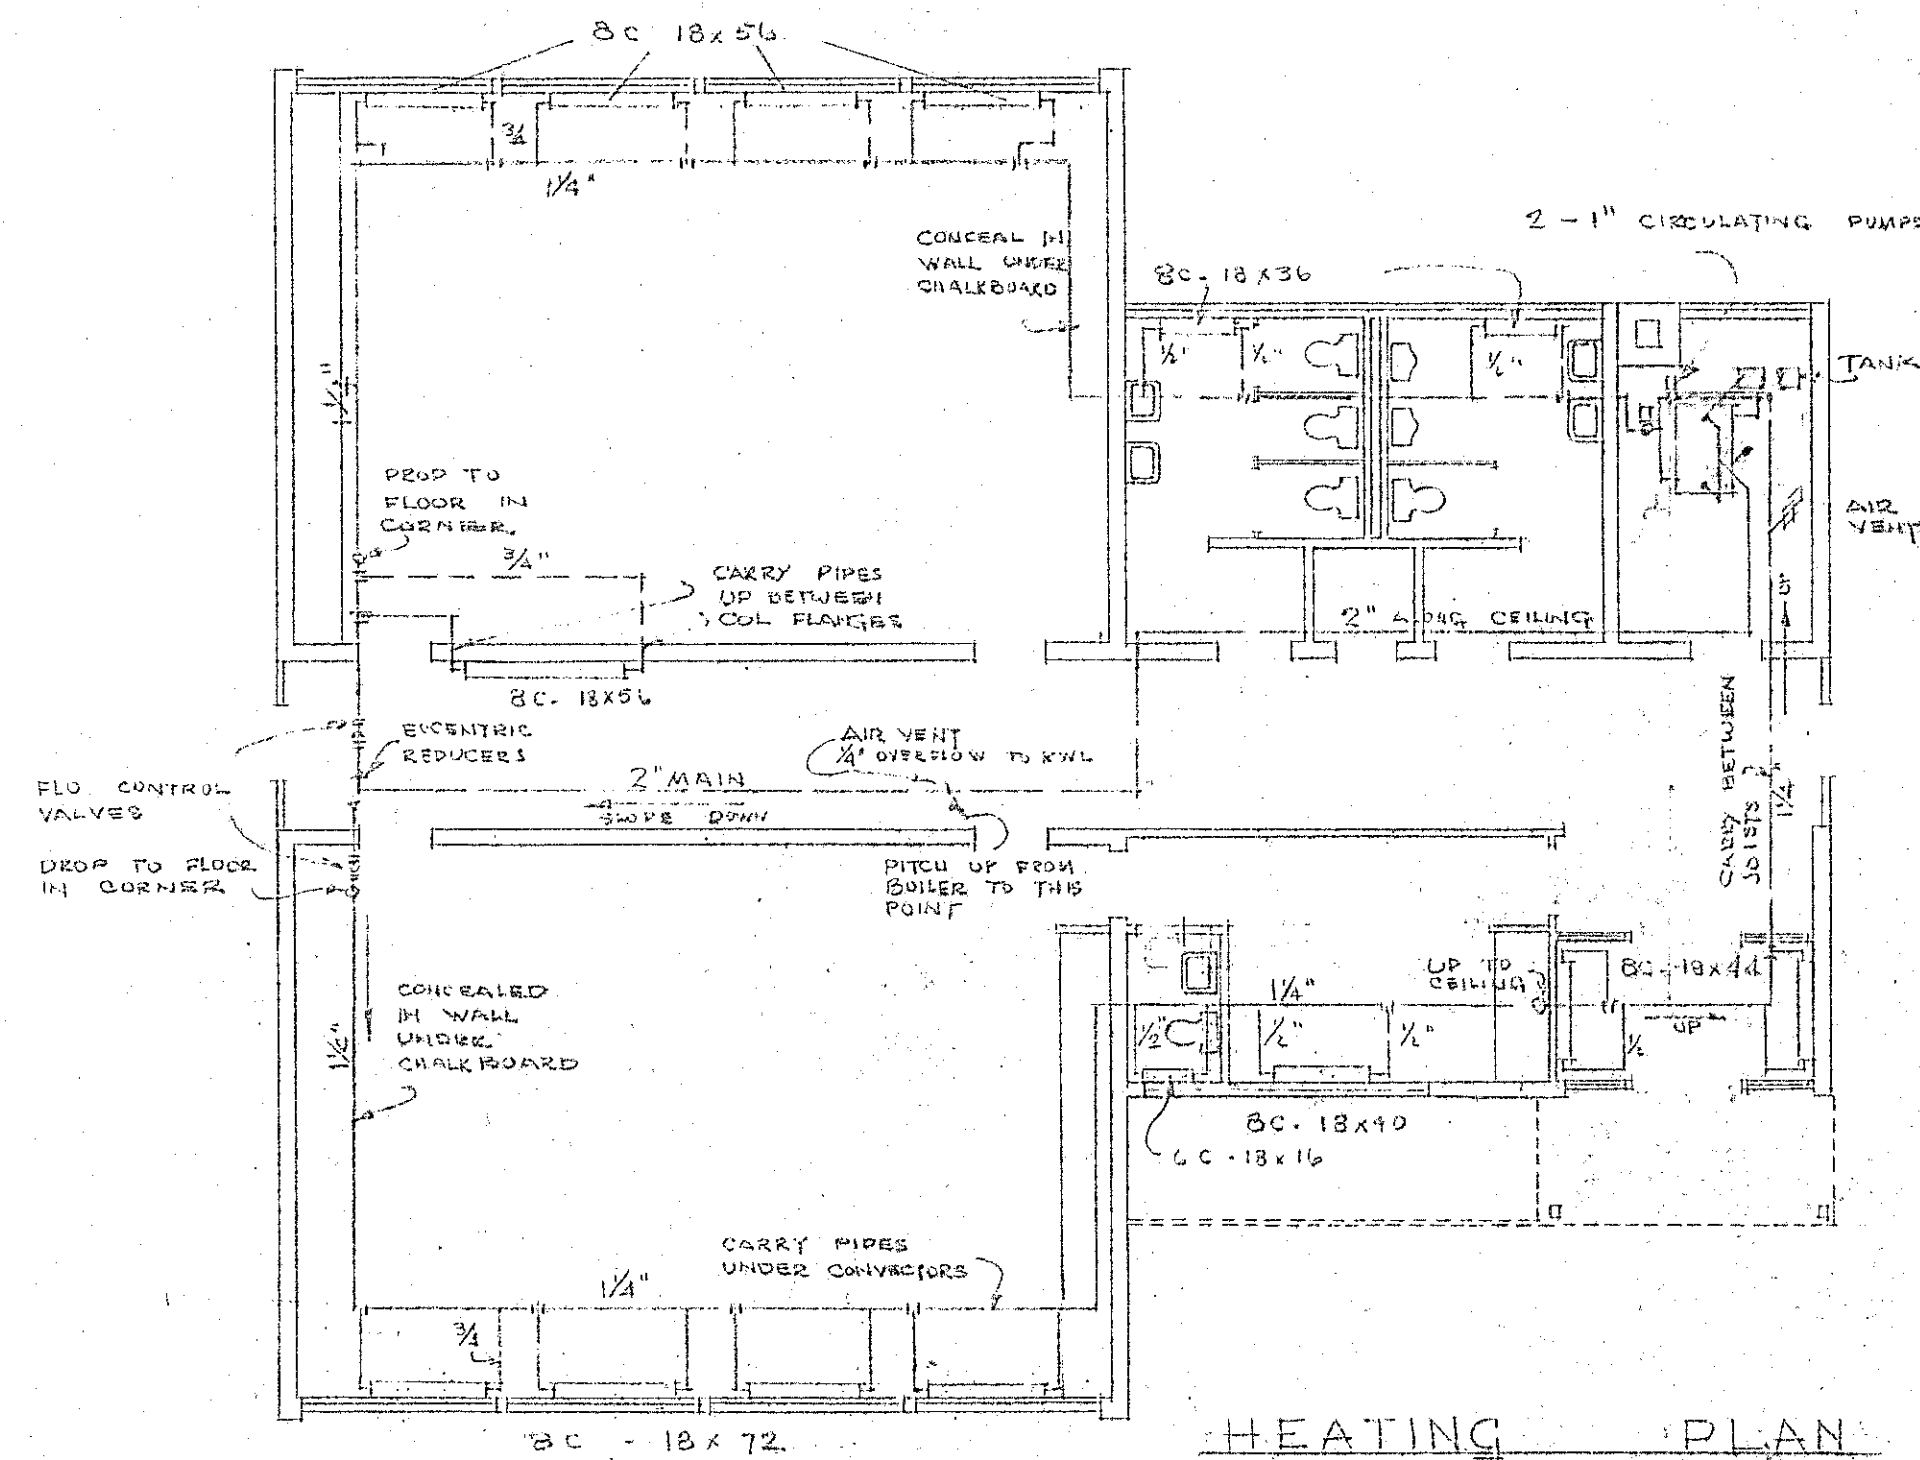


HEATING PLAN
SCALE $\frac{1}{8}'' = 1'-0''$

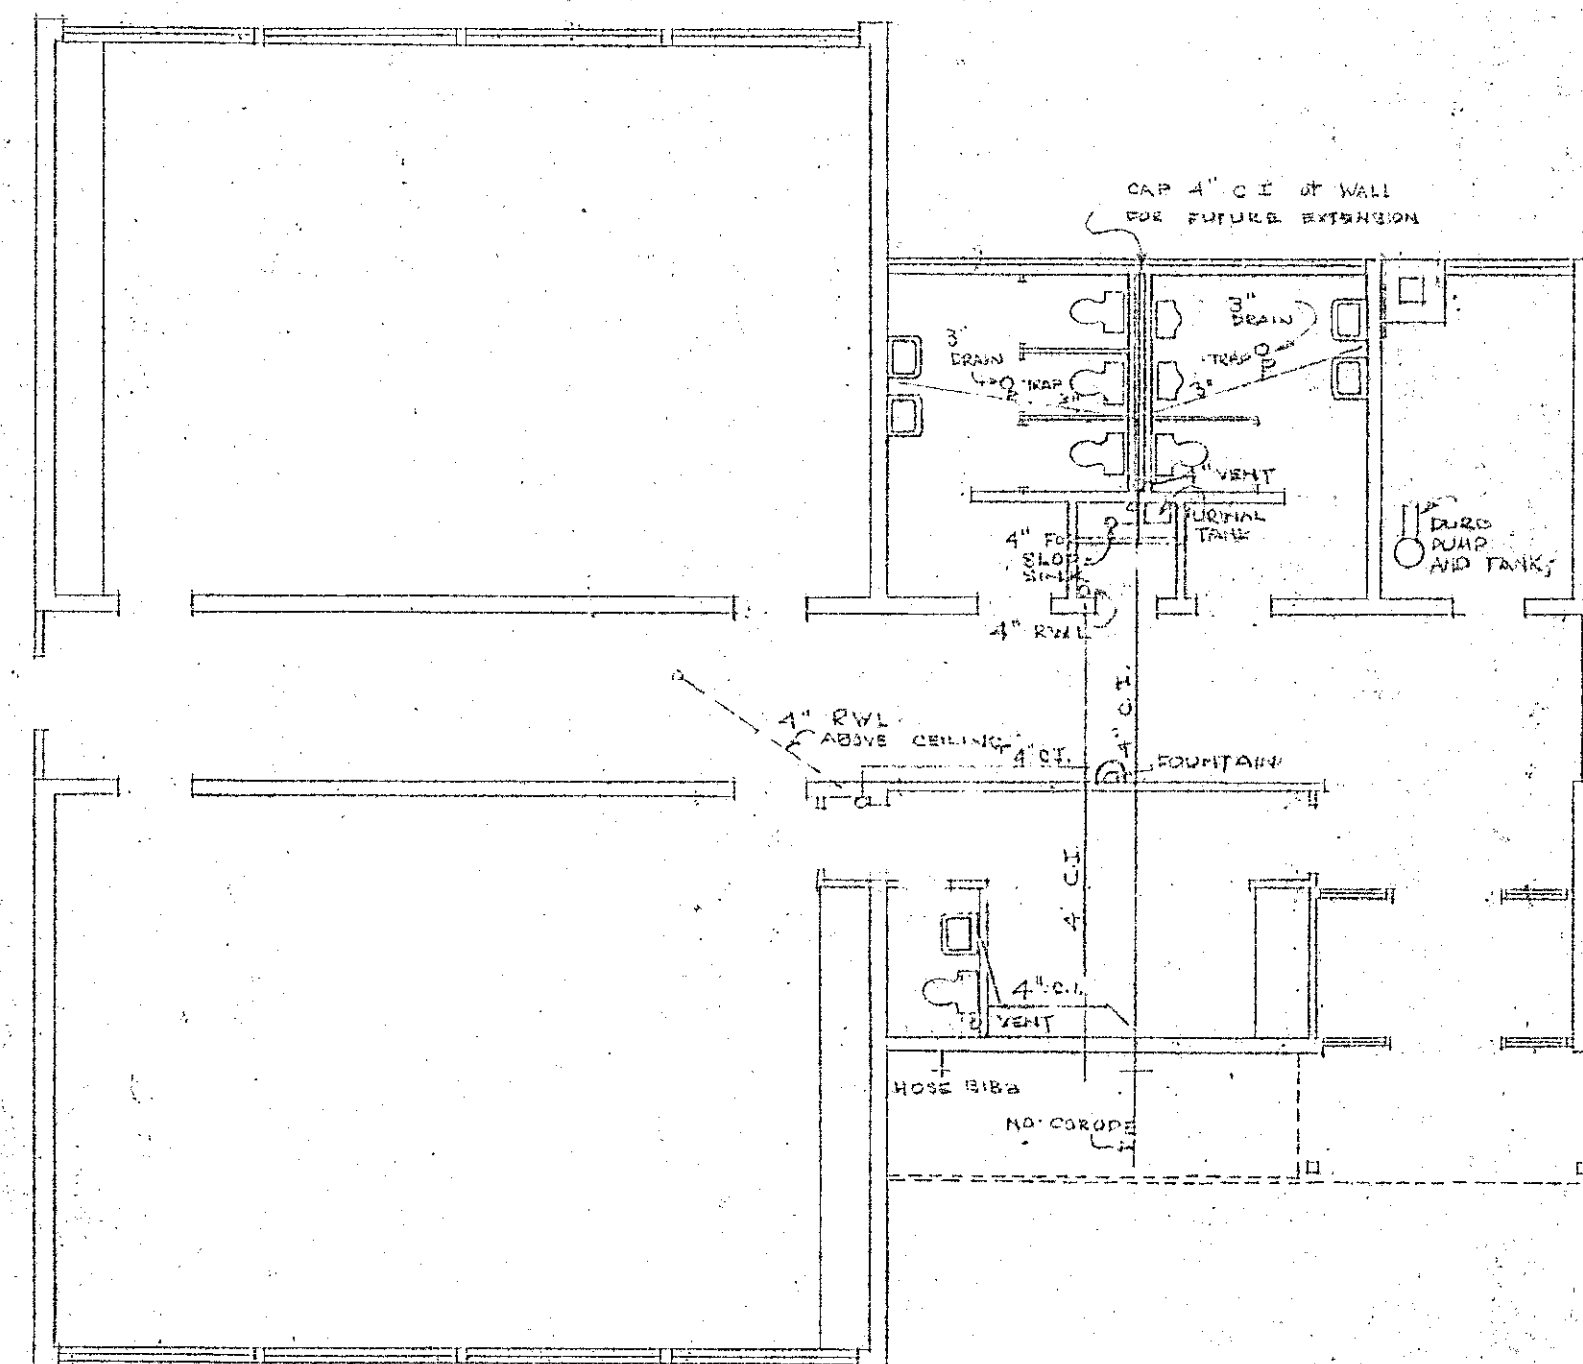


PLUMBING PLAN
SCALE $\frac{1}{8}'' = 1'-0''$

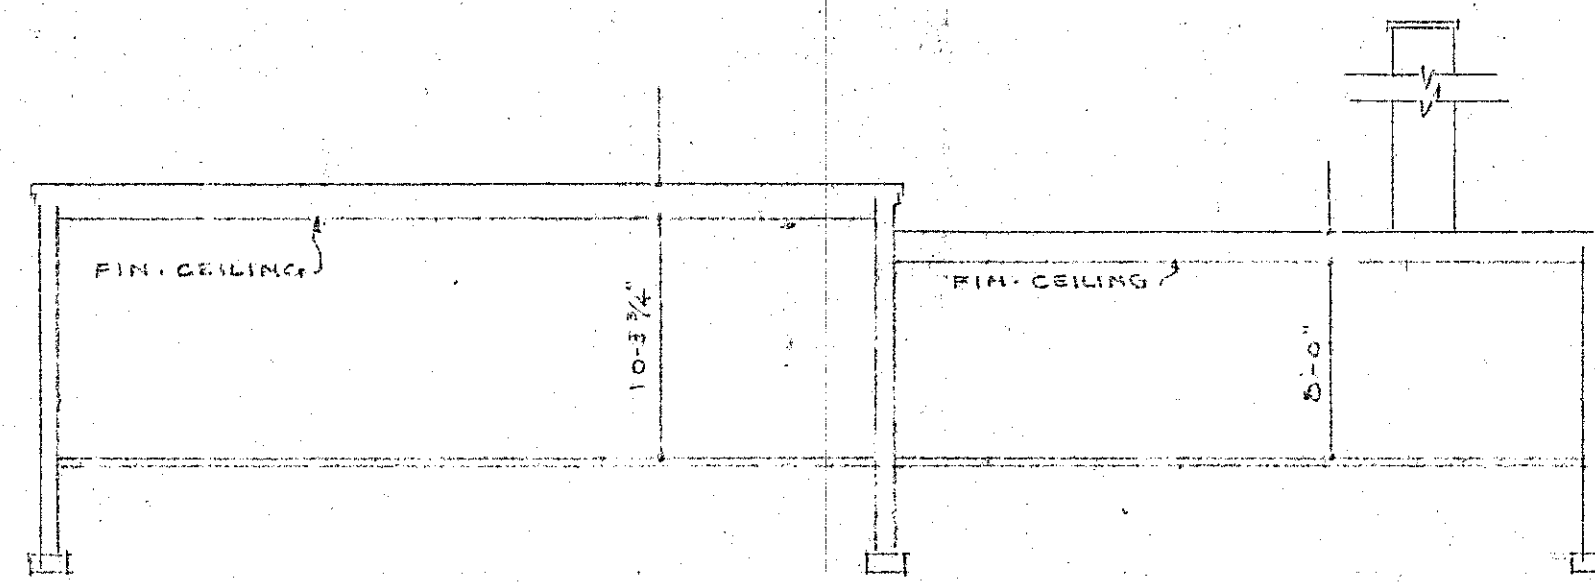


SECTION C-C
SCALE $\frac{1}{8}'' = 1'-0''$

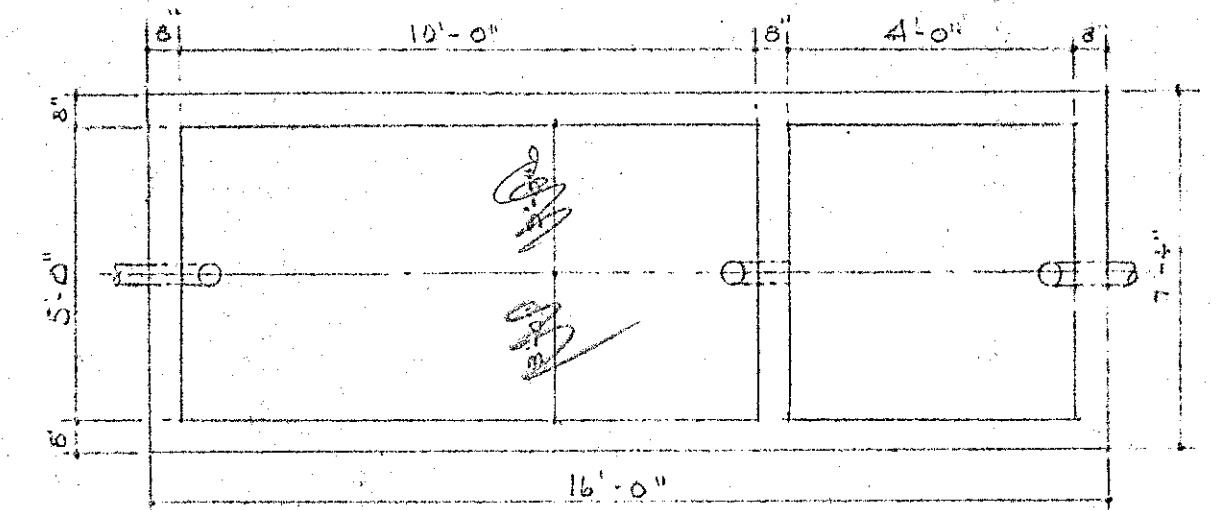


PLAN
SCALE $\frac{1}{4}'' = 1'-0''$

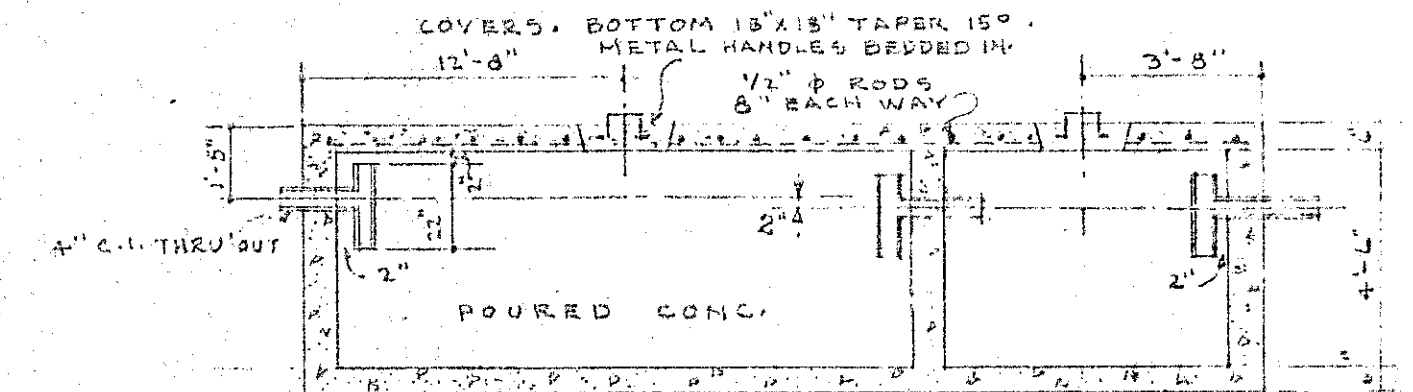

SECTION
SCALE $\frac{1}{4}'' = 1'-0''$

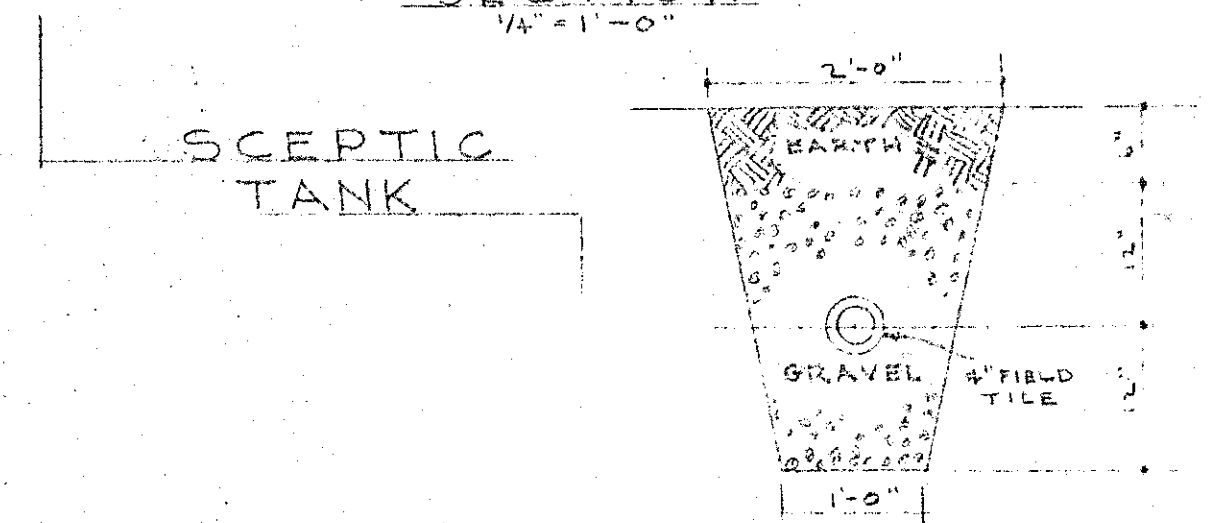


TYPICAL SECTION THRU DISPOSAL BED
SCALE $\frac{3}{4}'' = 1'-0''$

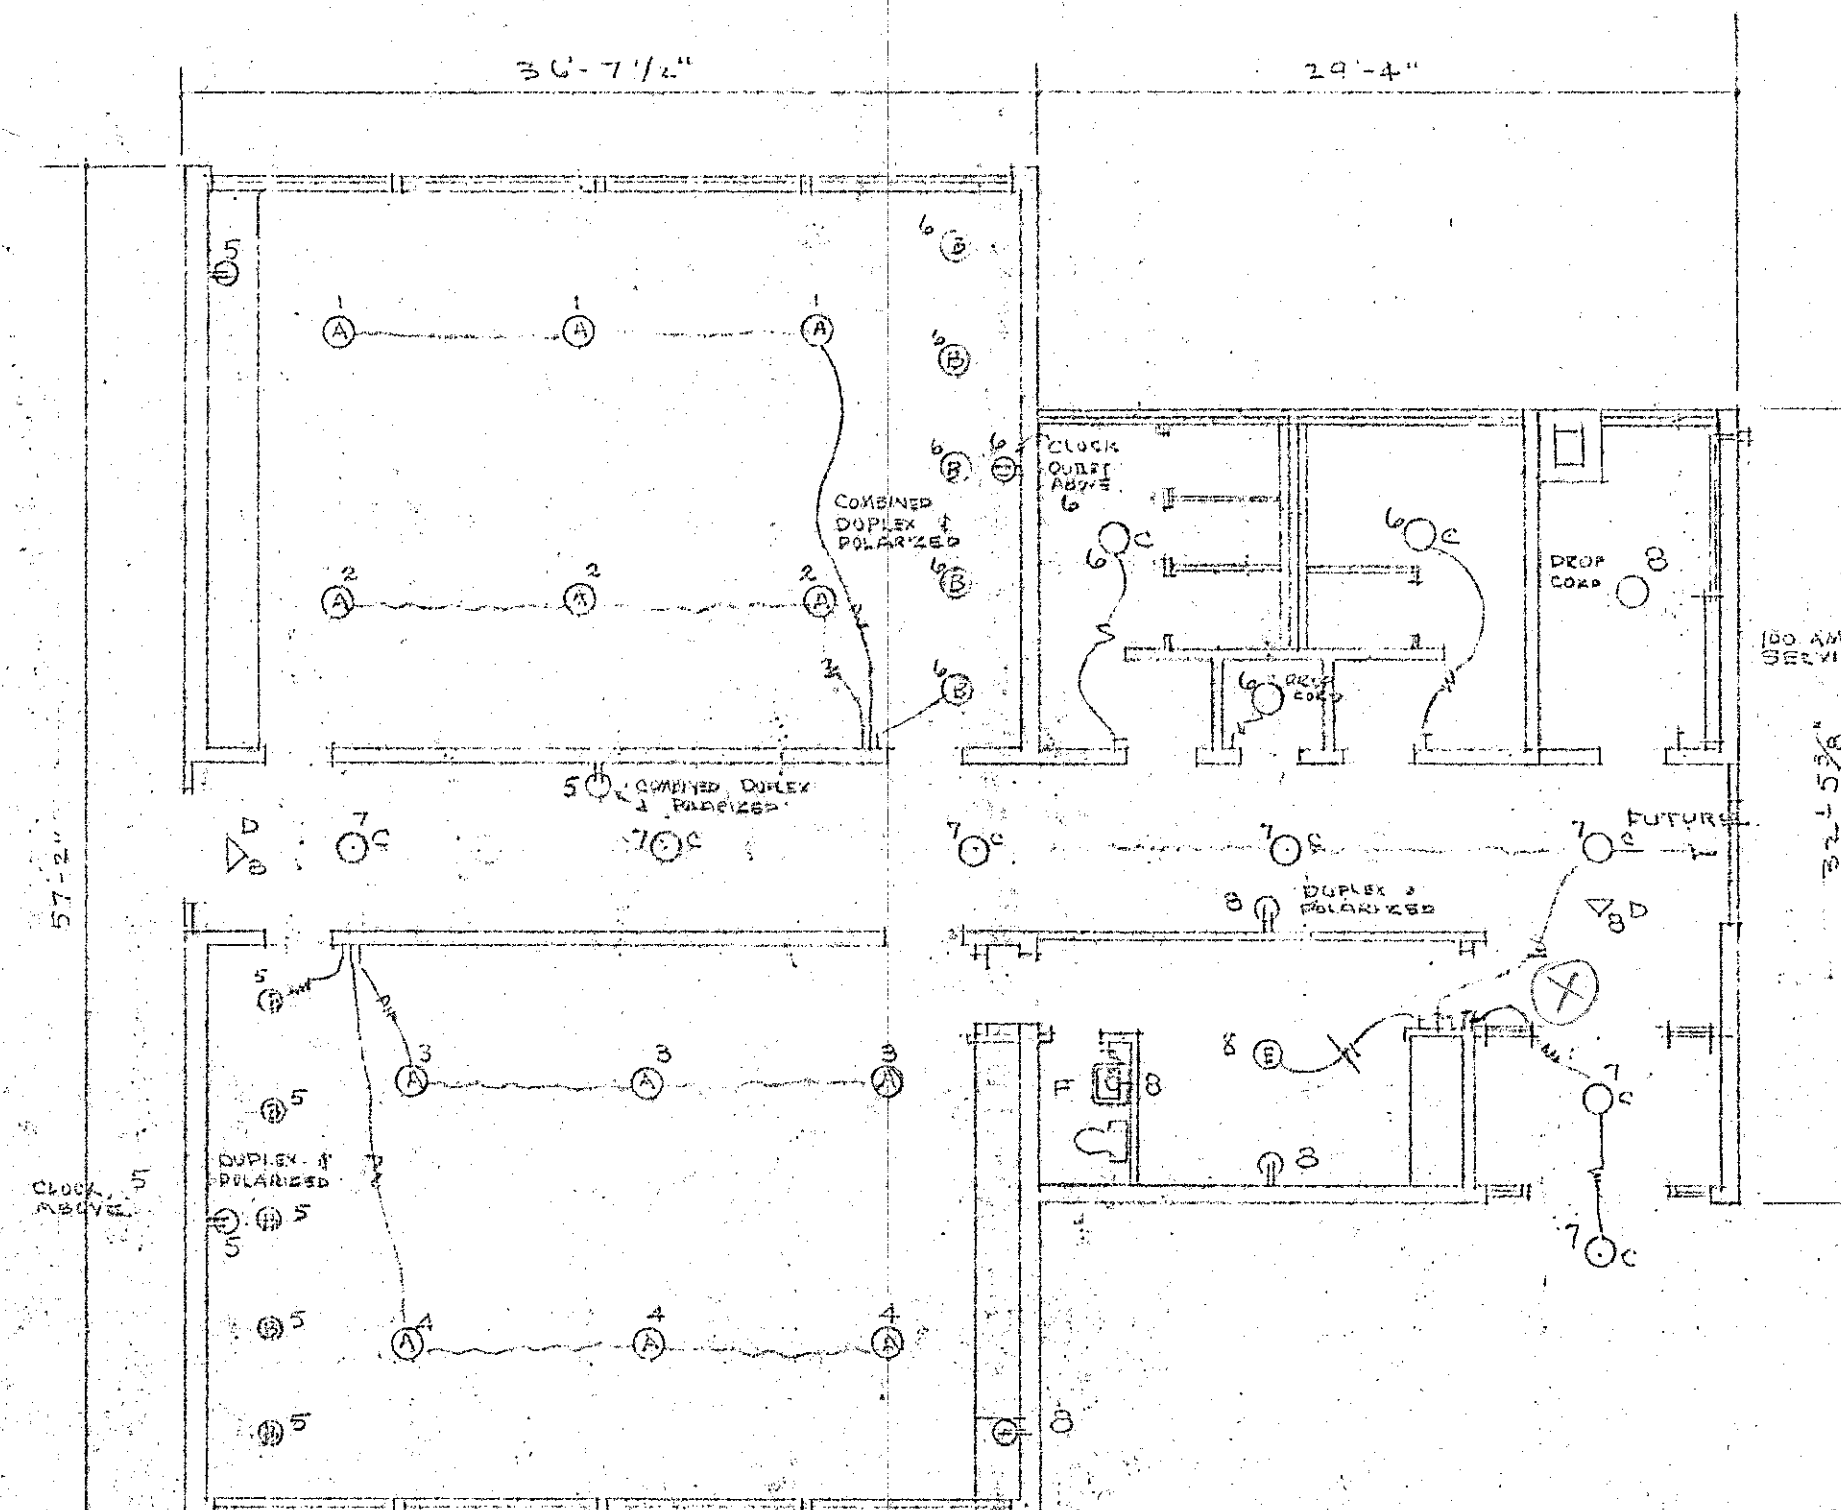

ELECTRICAL PLAN

CIRCUIT # 7 SHALL HAVE FUTURE CORRIDOR LIGHTS 400 WATTS
CIRCUITS 13, 14, 15 AND 16 SHALL BE FOR FUTURE ADDITION









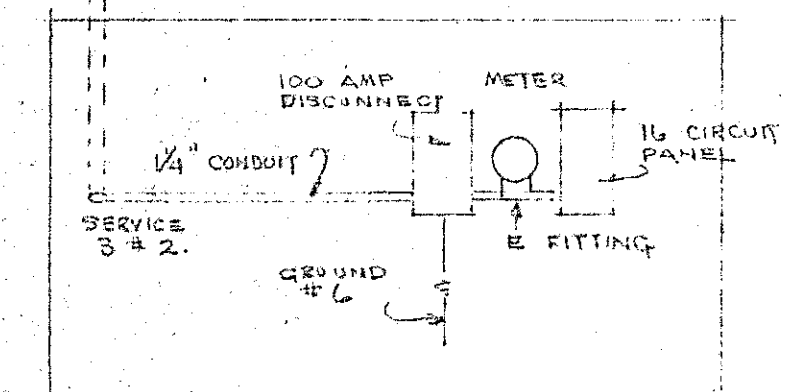


SERVICE

APPROVED
OWNER *W. J. Carswell*
CONTRACTOR *W. G. Watkins Limited*

BYRNES AVE SCHOOL			
SS NO. 11 NOTTANAWAGA			
PLUMBING AND HEATING			
W. J. CARSWELL ARCHITECT COLLINGWOOD, ONTARIO			
DRAWN G.H.F.	CHECK G.H.F.	PROJECT NUMBER 157	SHEET NUMBER 7
DATE 25-5-55	SCALE NOTED		

GENERAL REVISION JUNE 24 - 1955.

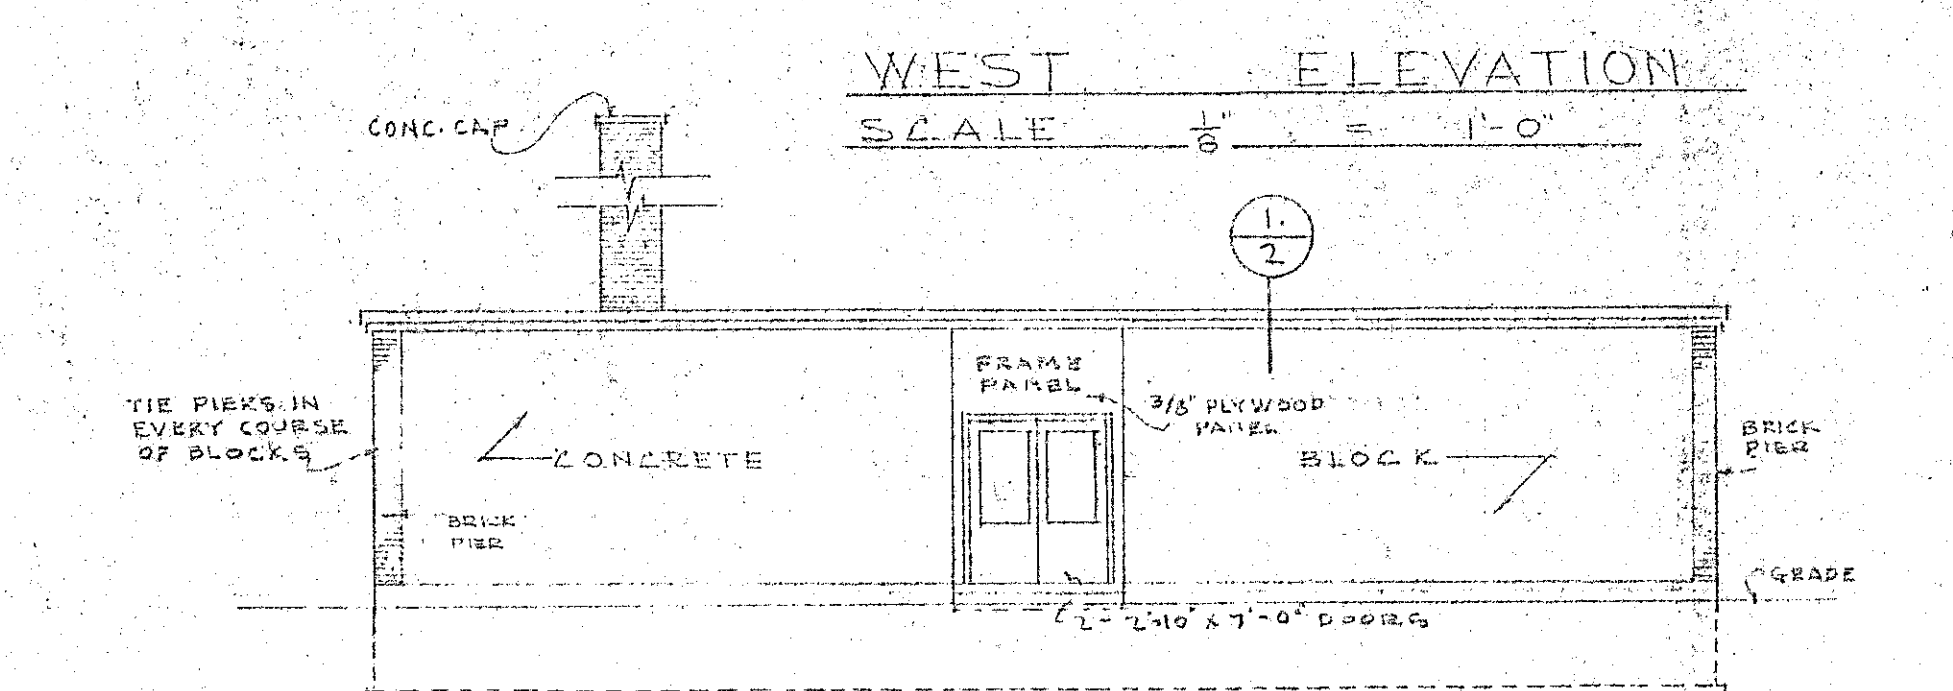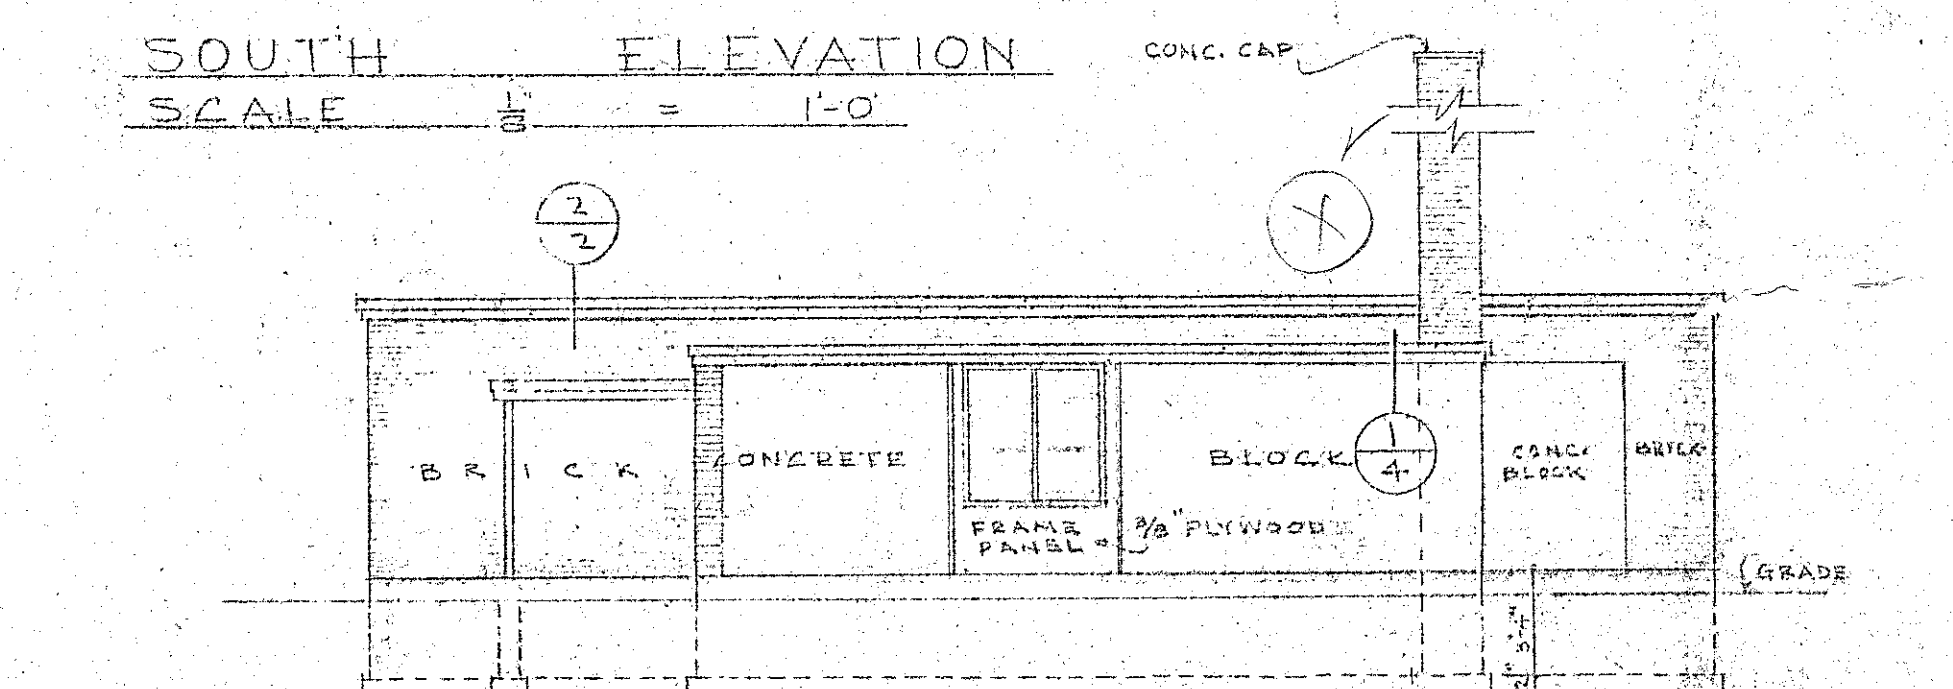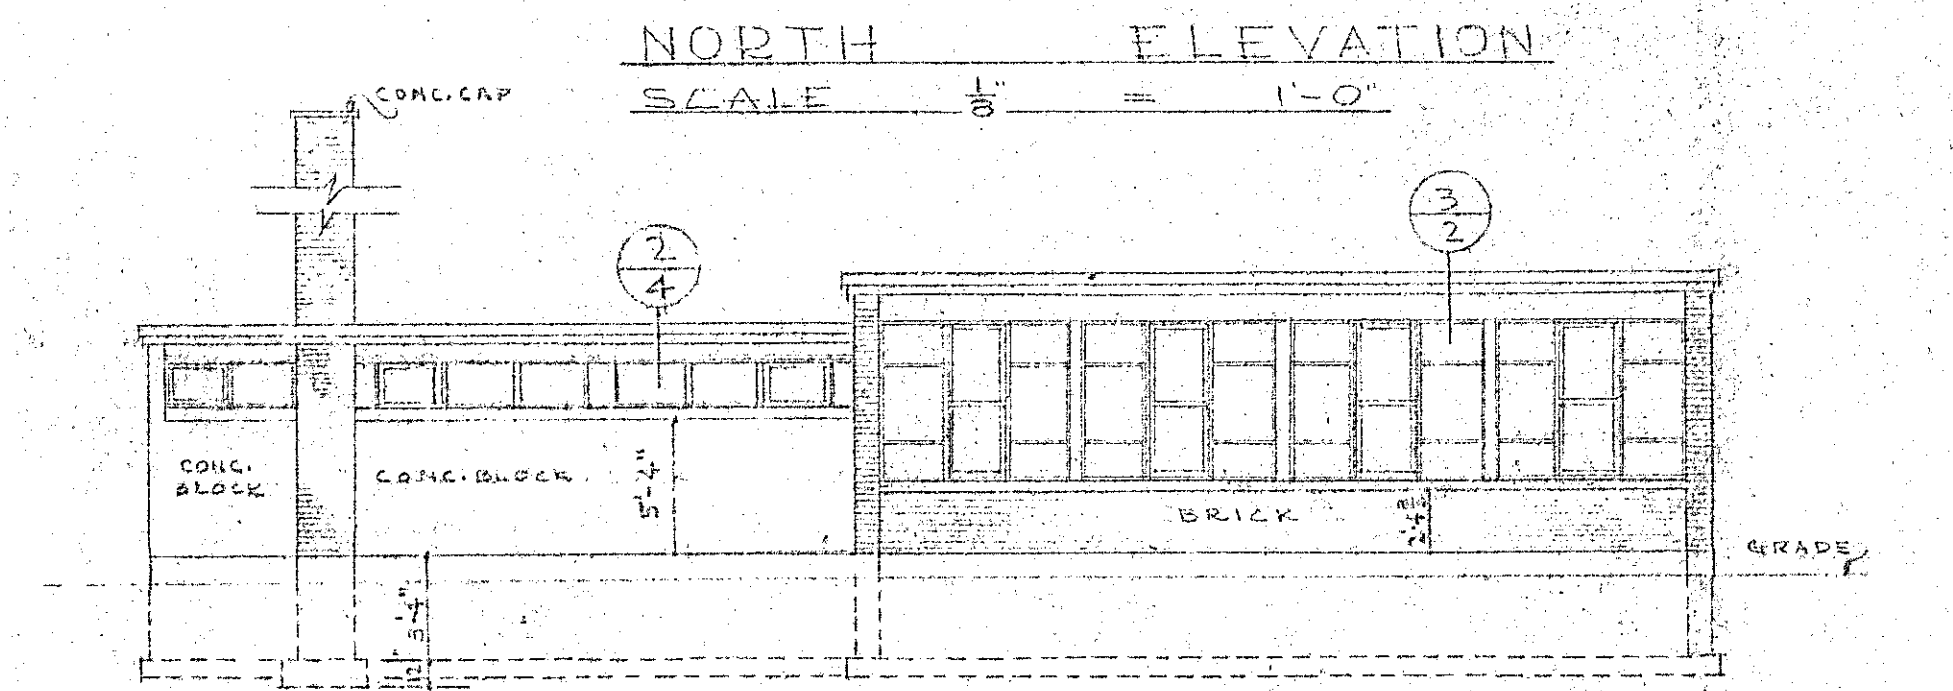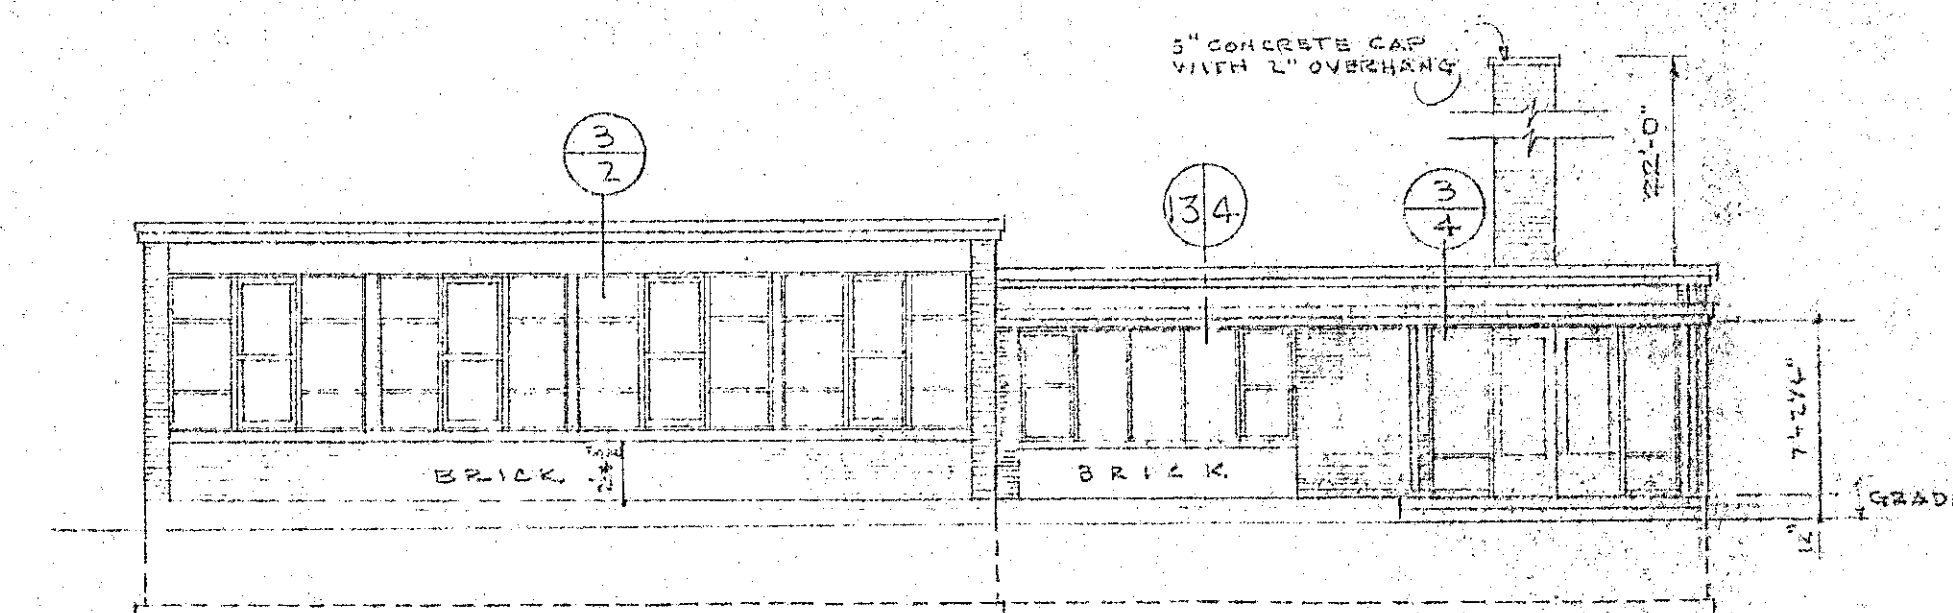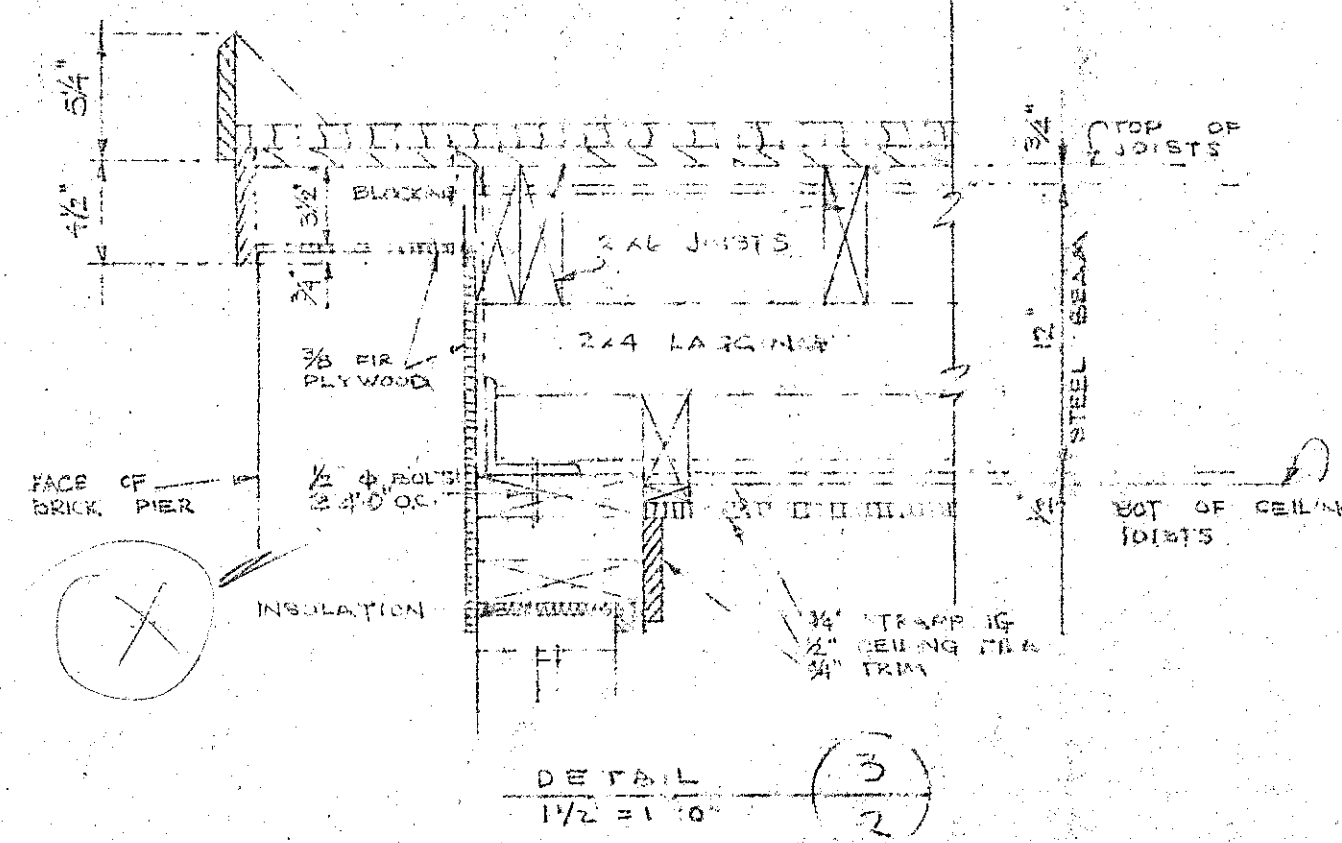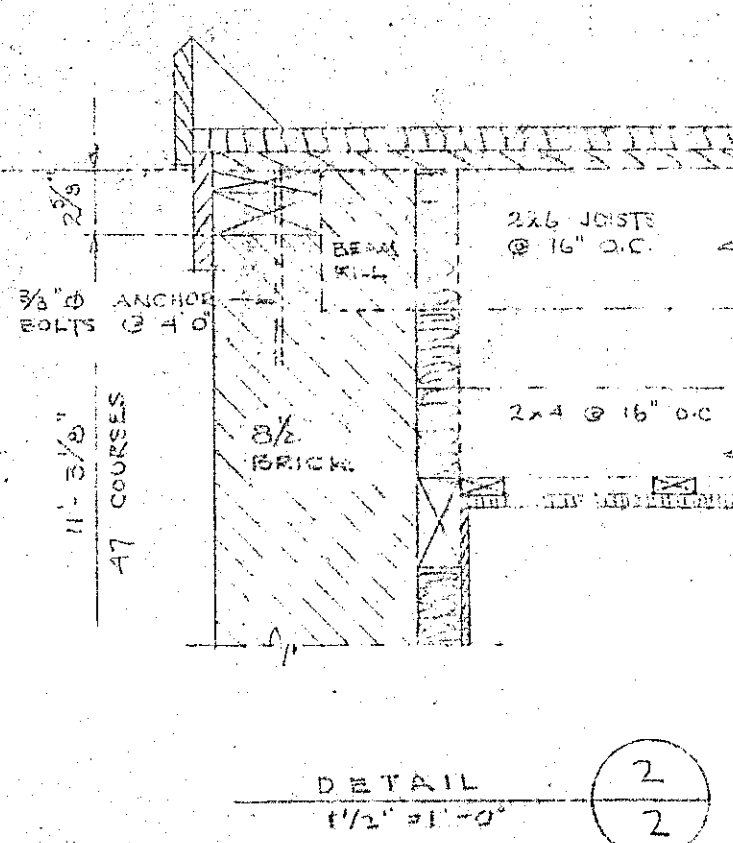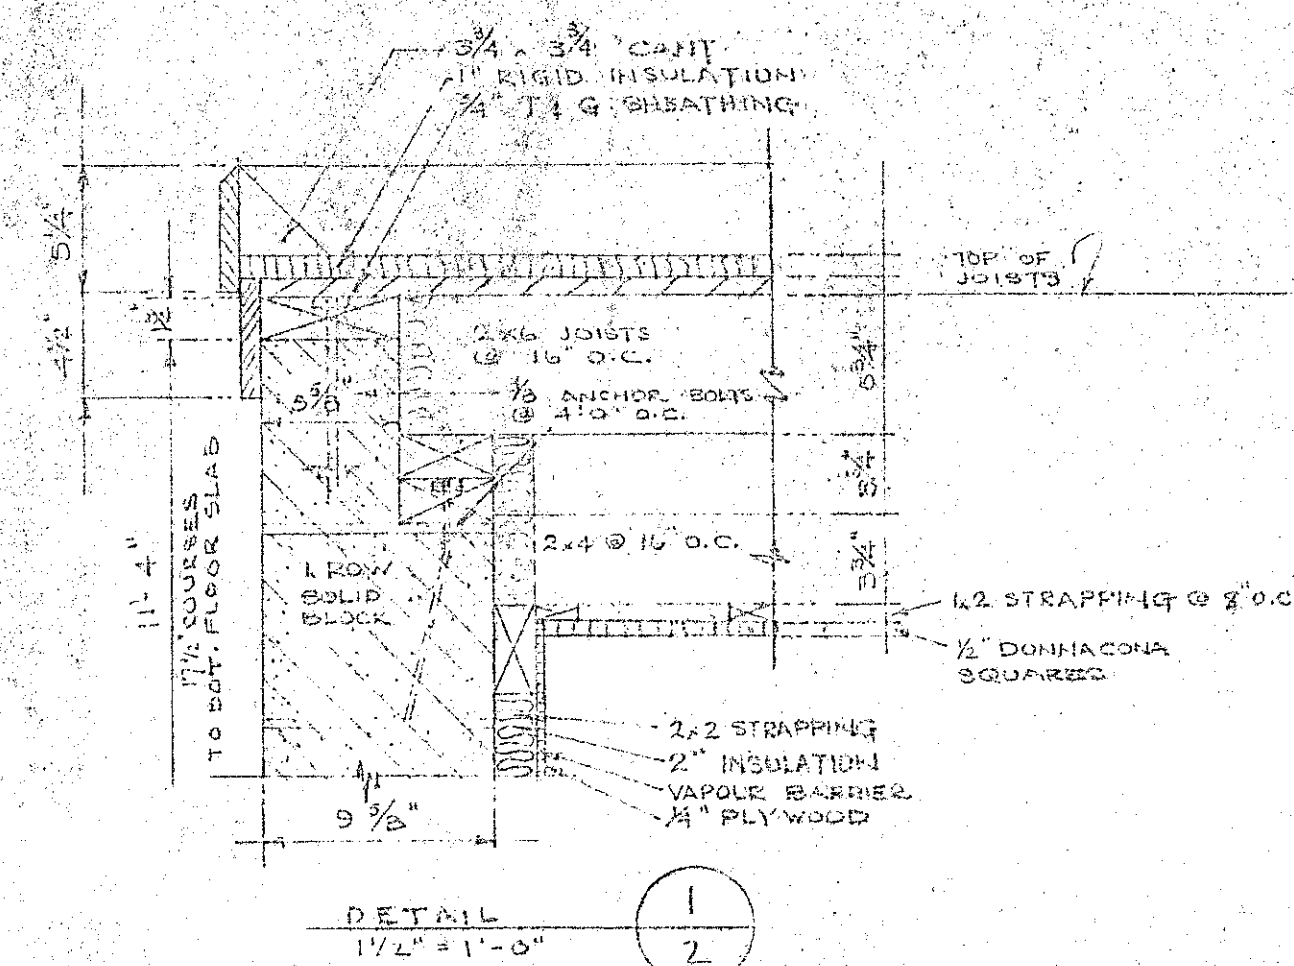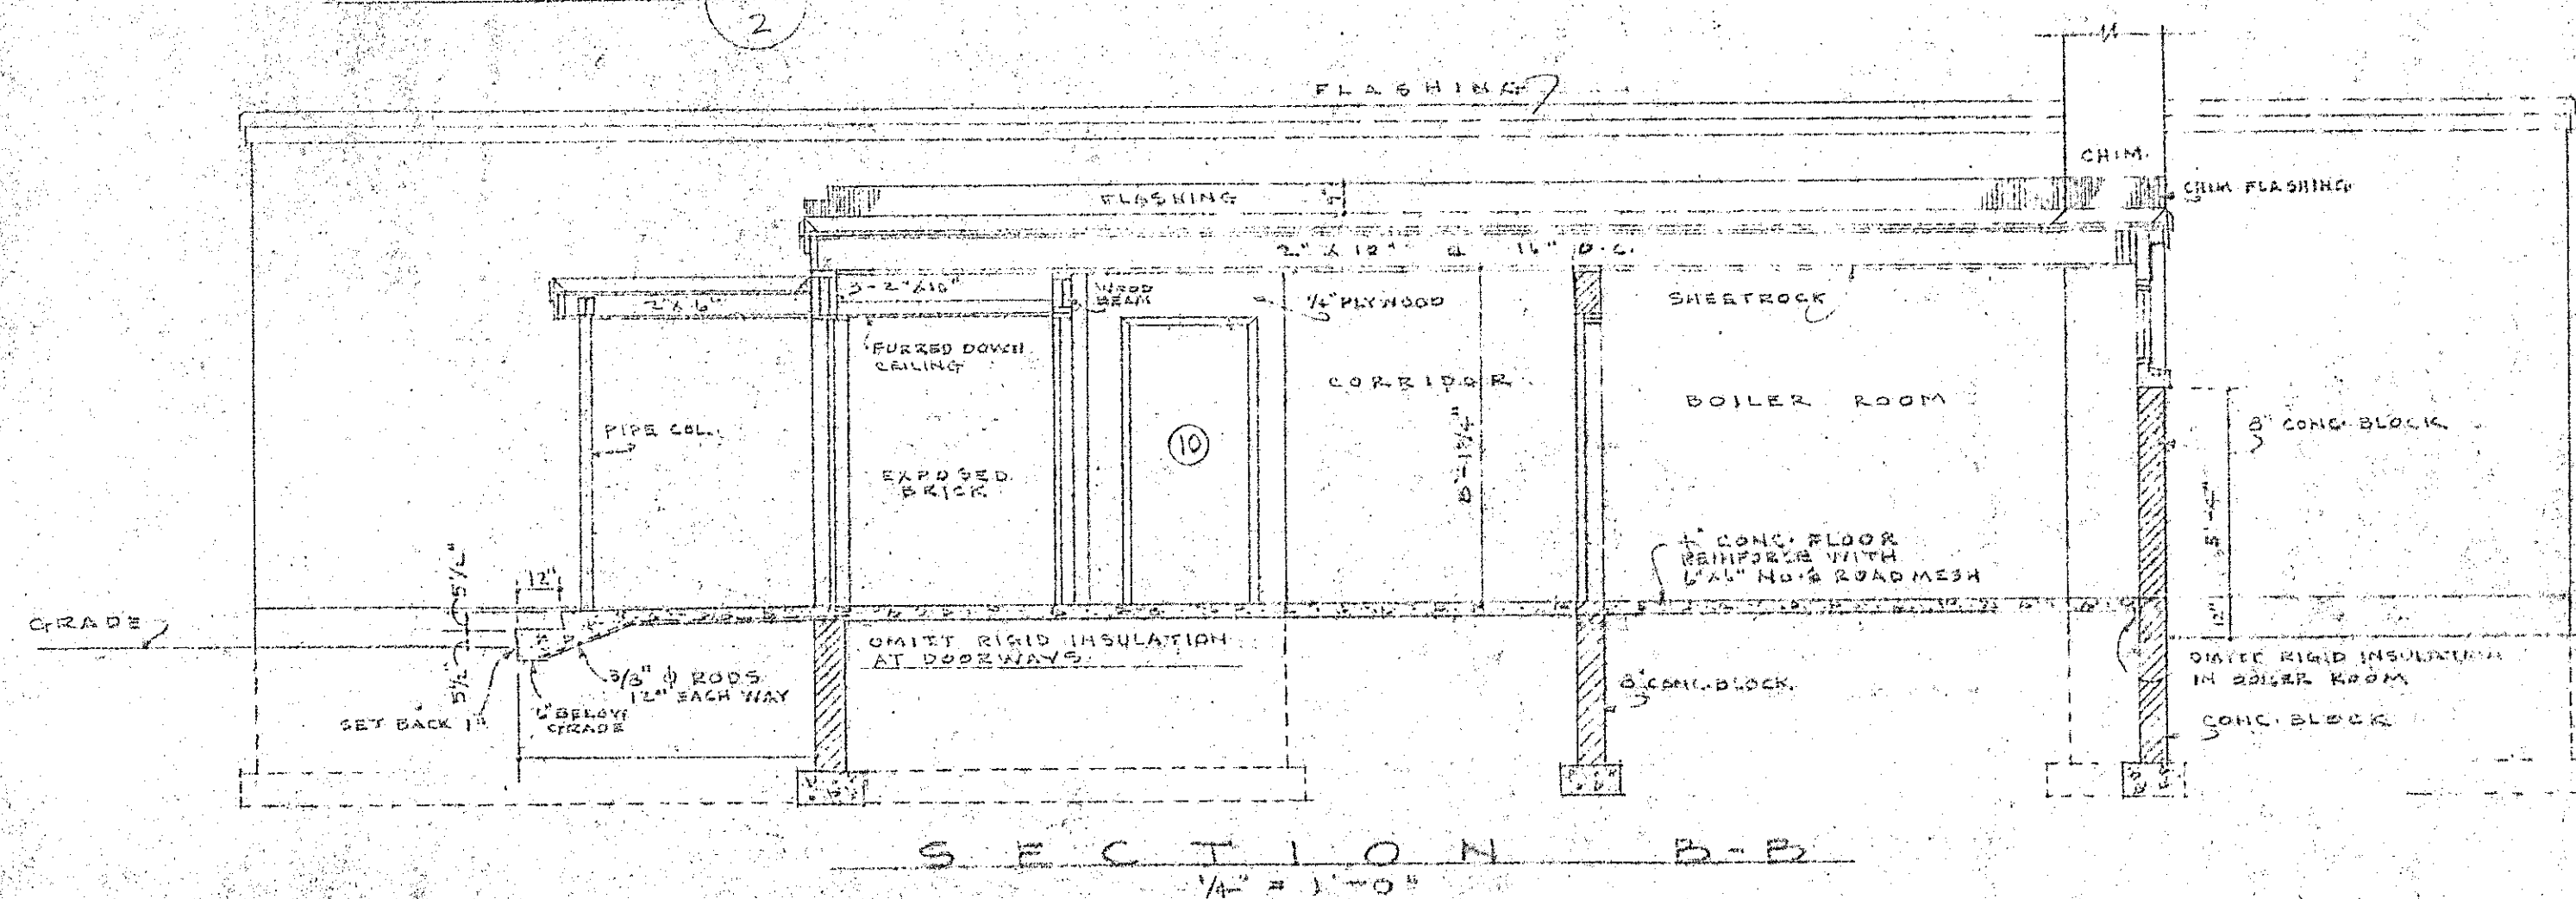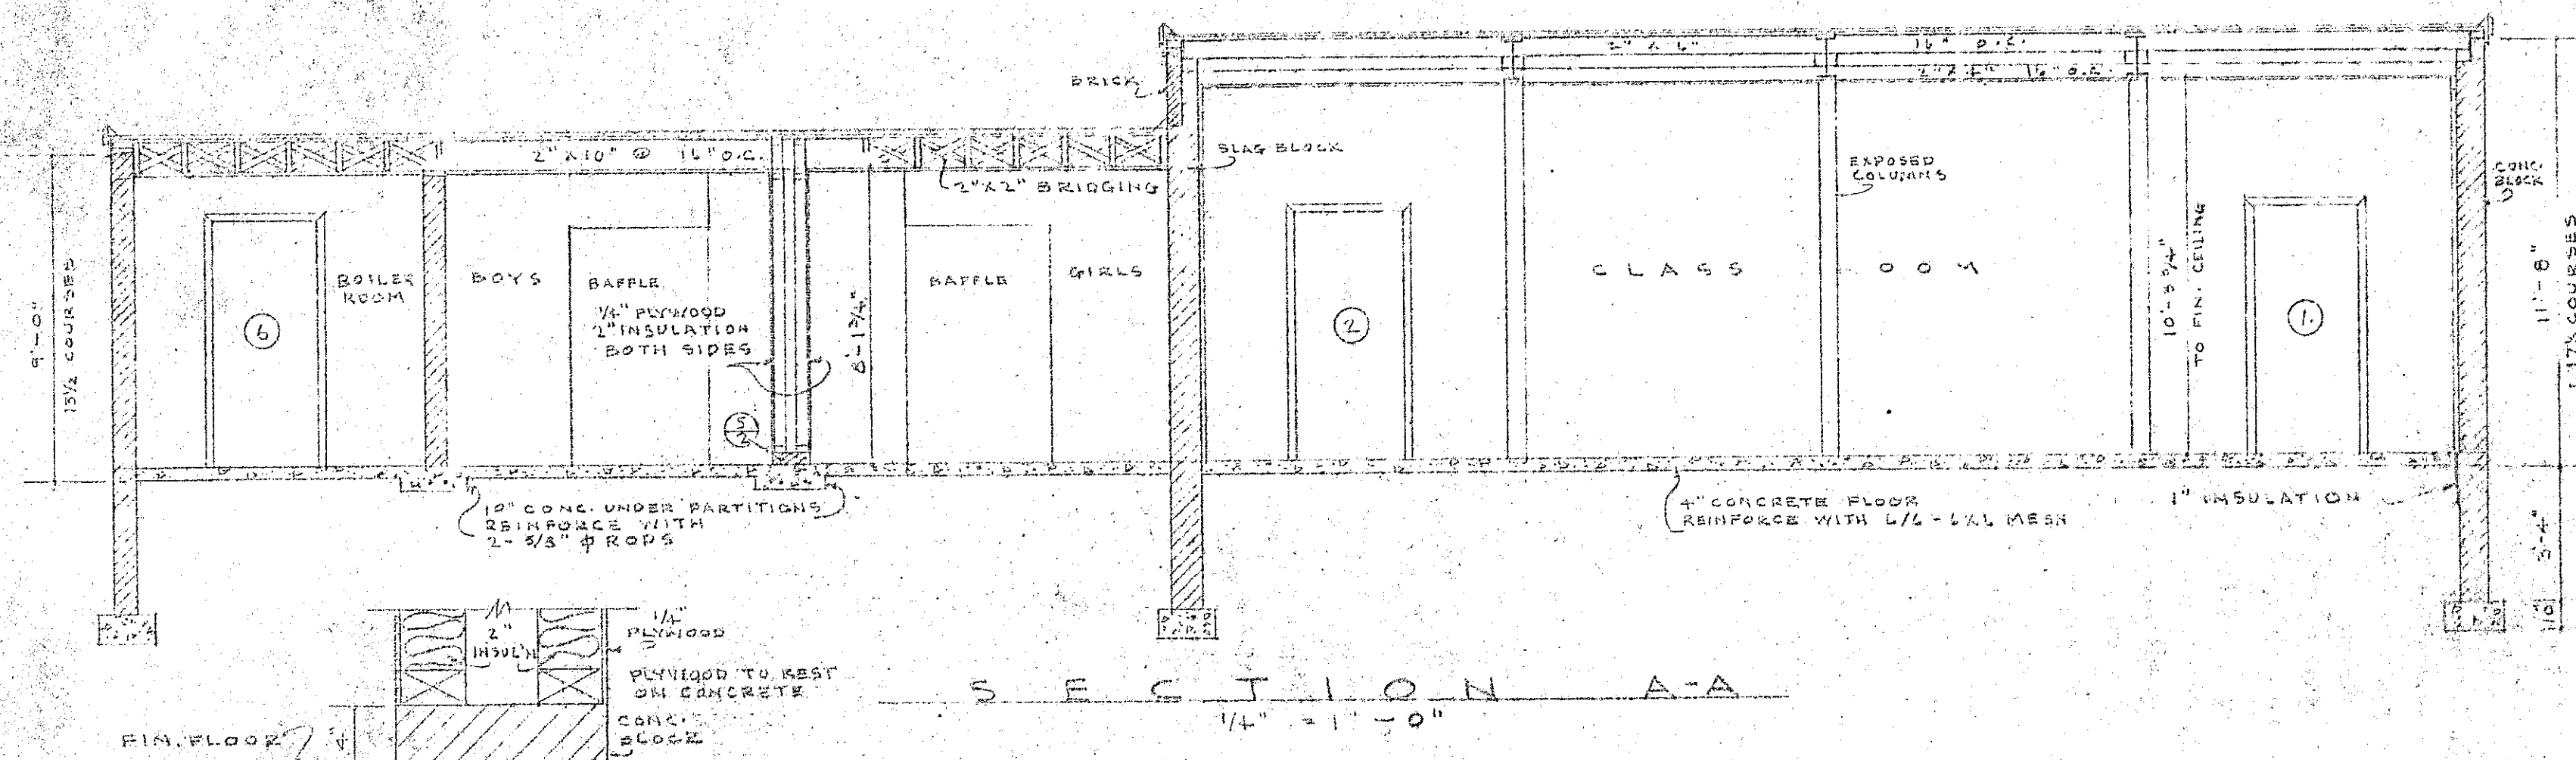

BYRNES AVE. SCHOOL
S.S. NO. 11 NOTTAWASAGA

BLOCK: MODULAR 15 3/8 x 7 3/8 3/8 JOINT
BRICK

GENERAL REVISION JUNE 24TH 1955
APPROVED *John H. Wilson*
OWNERS

APPROVED *Walter J. Watkins*
W. J. CARSWELL ARCHITECT
COLLINGWOOD, ONTARIO

DETAIL SHEET NO. 1

DRAWN	CHECK	PROJECT NUMBER	SHEET NUMBER
G.H.F.	W.J.C.	157	2
DATE	SCALE		
22-5-55	NOTED		