
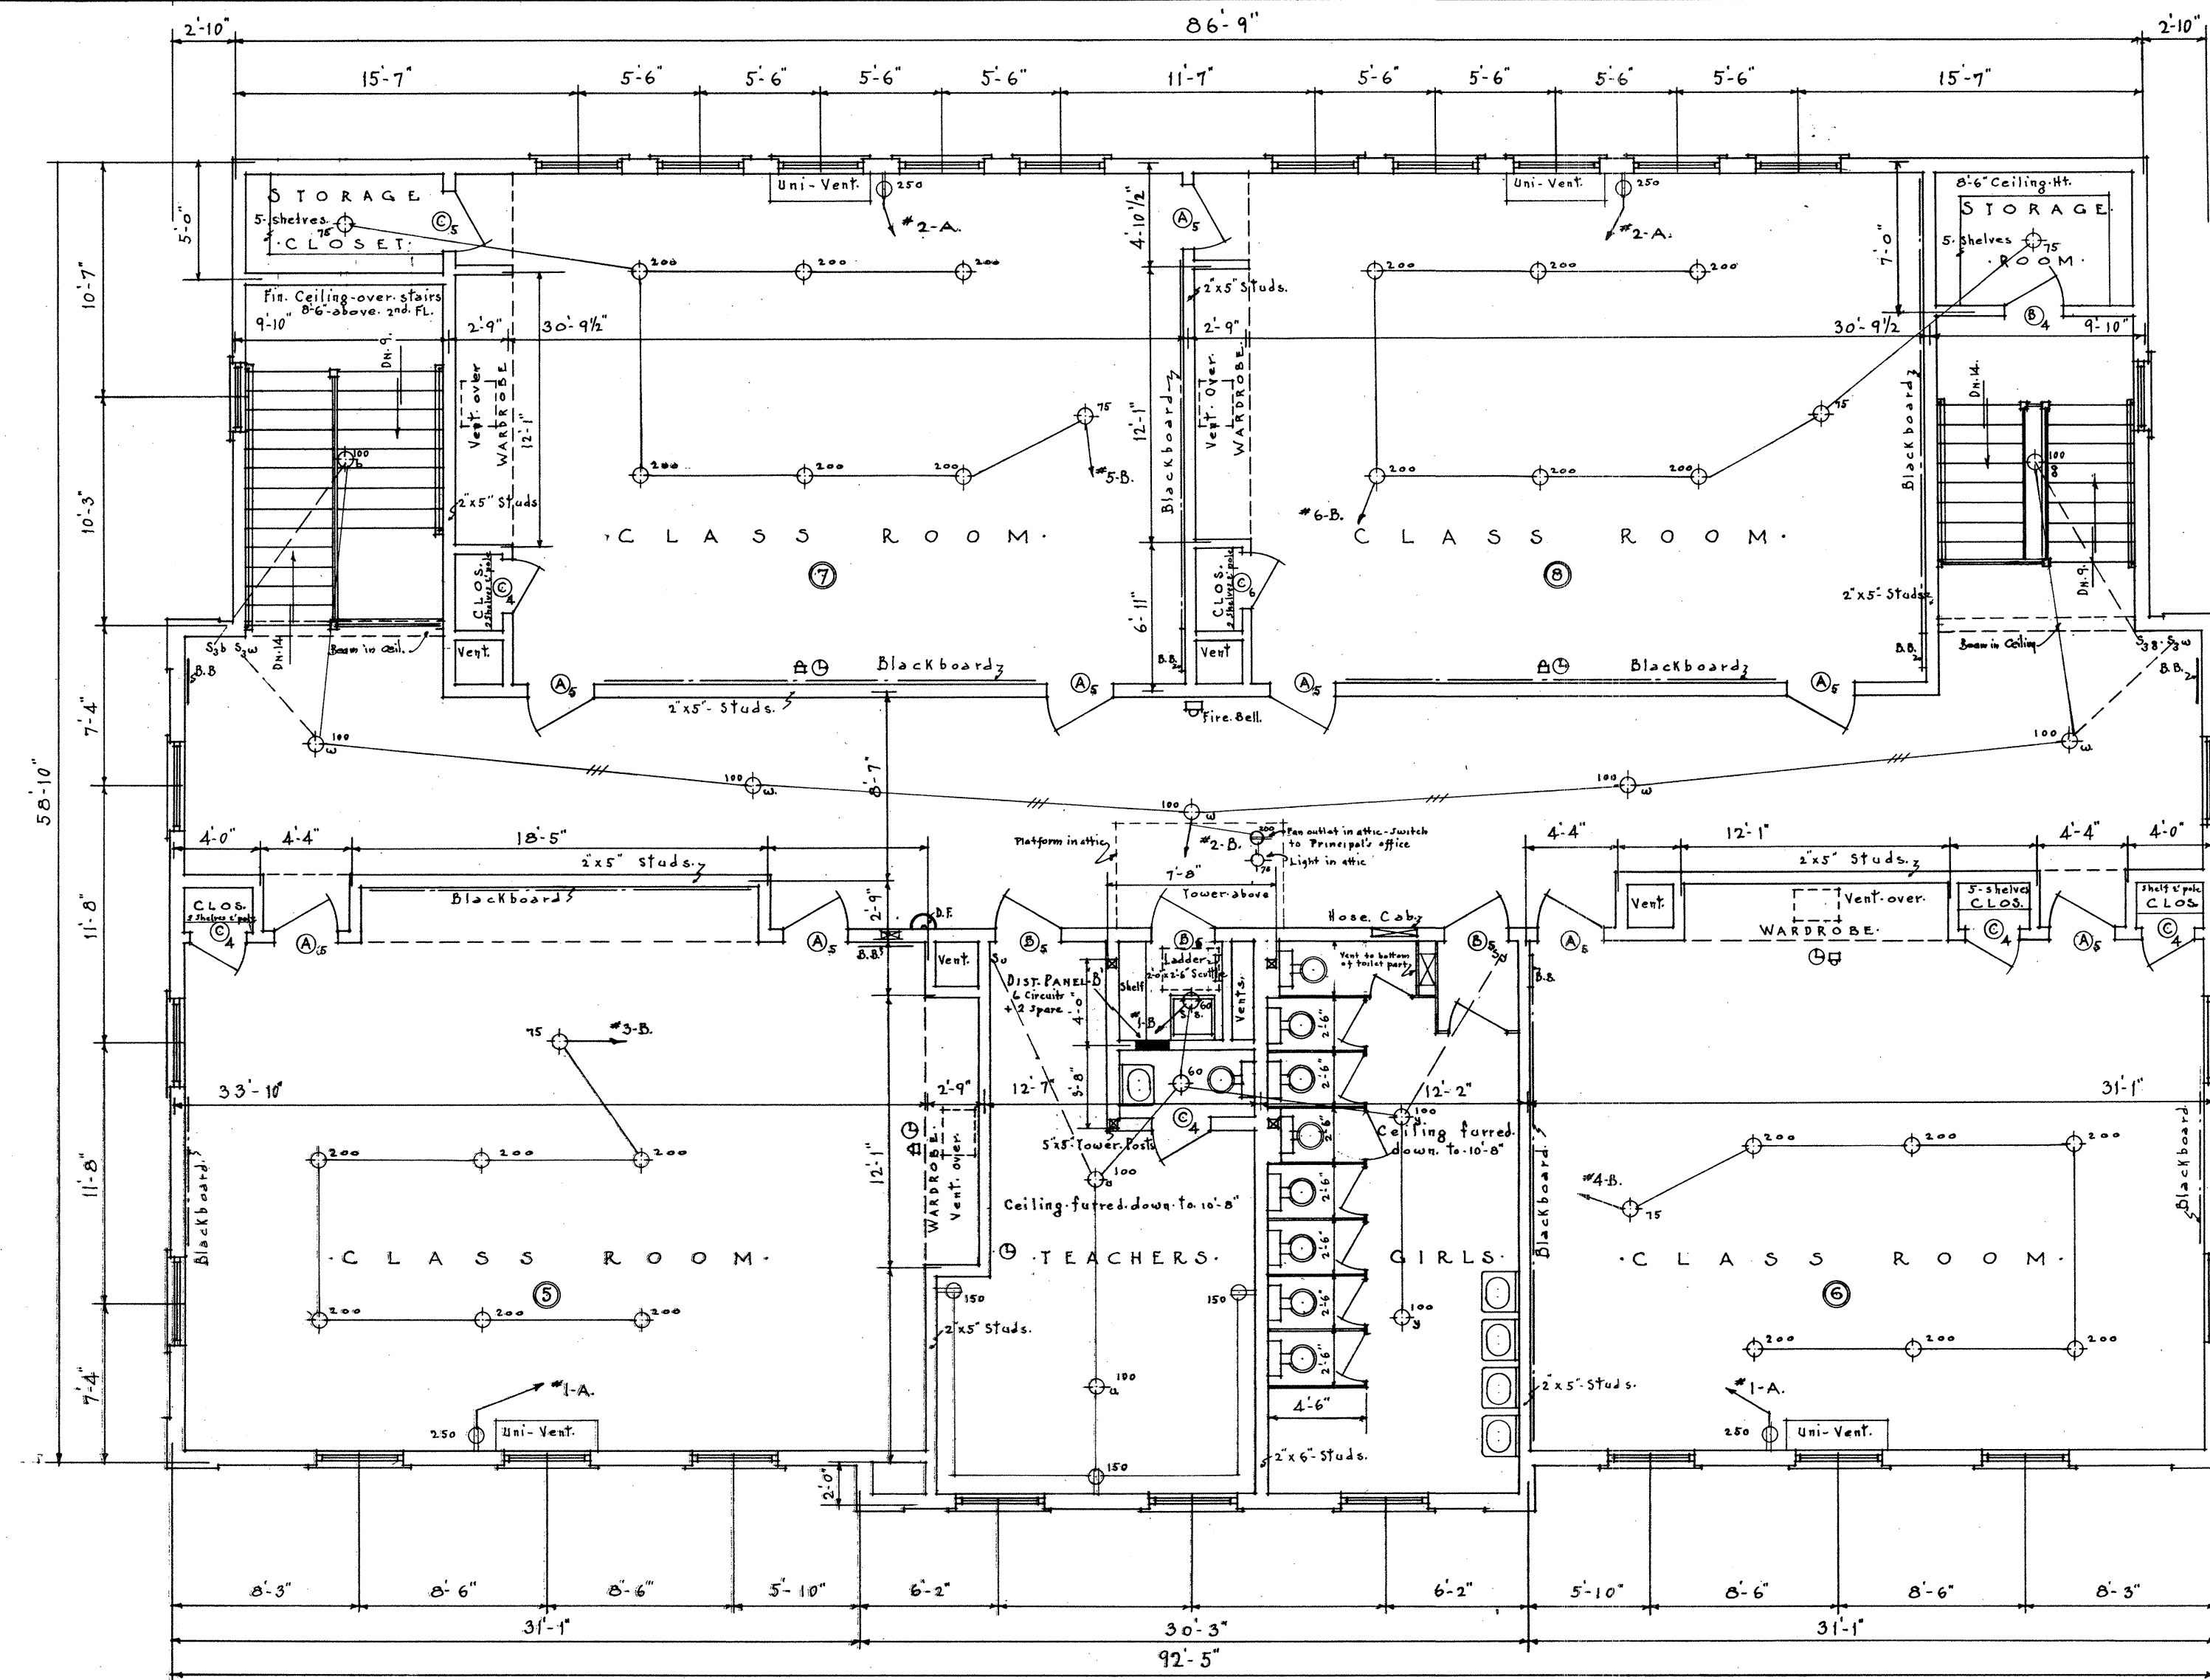


SYMBOL SCHEDULE

B. B. Bulletin Boards.

ELECTRICAL

- ⊕ Ceiling Outlet (Drop cord).
- ⊕ Base Receptacles (Duplex).
- ⊕ Wall Switch.
- ⊕ Ceiling light controlled by switch.
- Switch line.
- 2-Wire B.X.
- 3-Wire B.X.
- Circuit.
- ⊕ Distribution Panel.
- ⊕ Bell Outlets.
- ⊕ Clock Outlets.

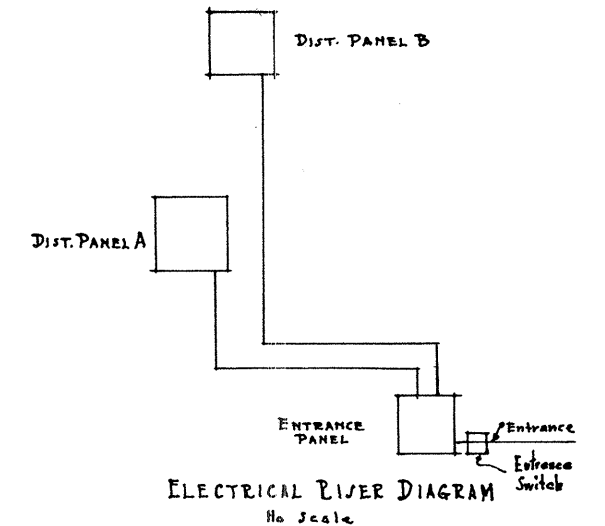

SECOND FLOOR PLAN

Scale 1/4" = 1'-0"

PASSAMAQUODDY BAY
TIDAL POWER DEVELOPMENT

TEMPORARY BUILDINGS

SCHOOL HOUSE

Sheet # 2 of 15 sheets Date Sept. 20, 35

UNITED STATES ENGINEER OFFICE

EASTPORT, MAINE

JOHN P. THOMAS, A. I. A.

ARCHITECT

Submitted by

Approved

Q-E-28/2