



 





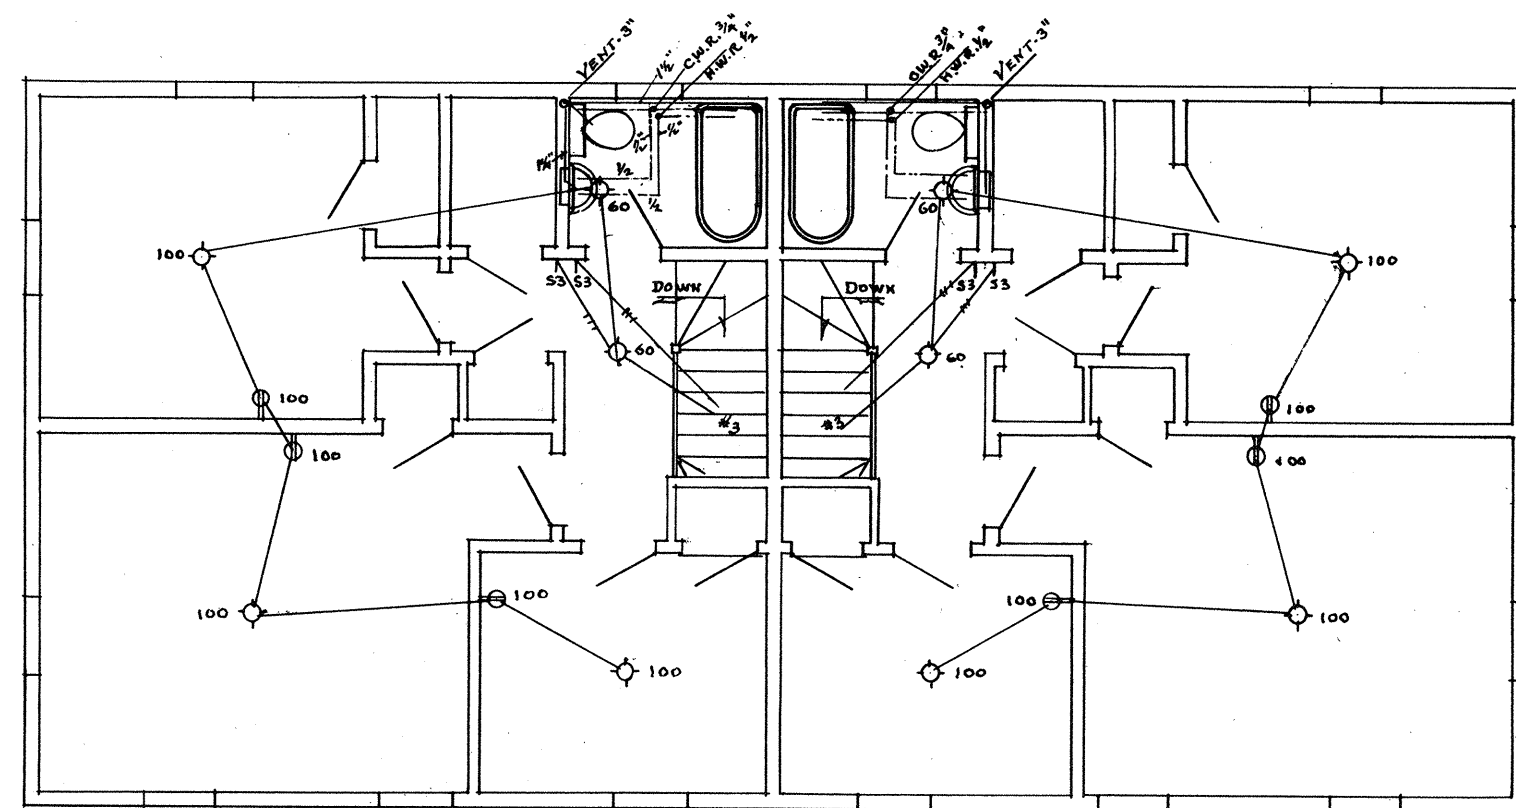


SECOND FLOOR PLAN

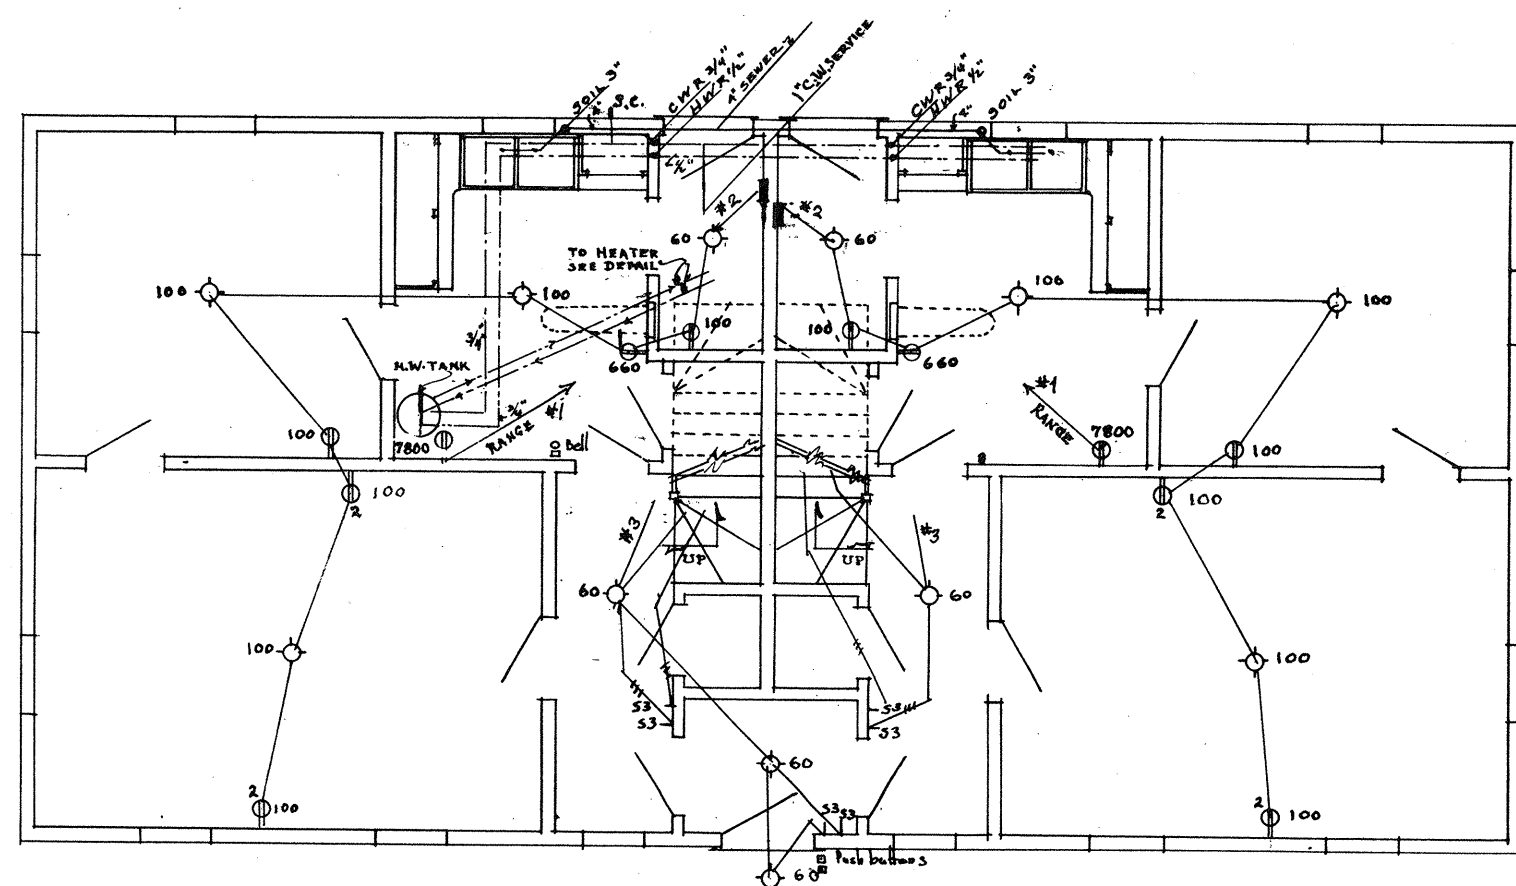

FIRST FLOOR PLAN

PLUMBING SYMBOLS	ELECTRICAL SYMBOLS
SPILL LINES	2-#14 WIRE - BX.
COLD WATER	3-#14 WIRE - BX (UNLESS OTHERWISE NOTED)
ST. WATER	CEILING OUTLET
ST. WATER CIL.	WALL OUTLET
	RECEPTACLE
	DUPLEX RECEPTACLE
	DISTRIBUTION PANEL BX

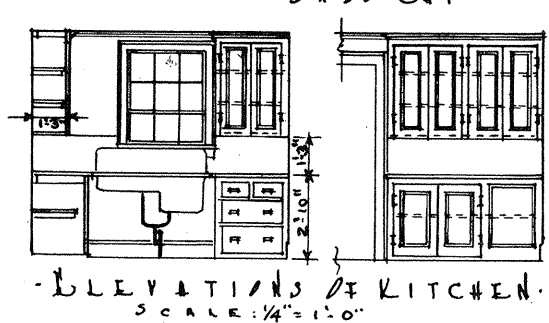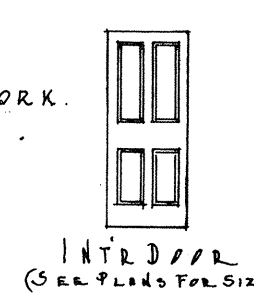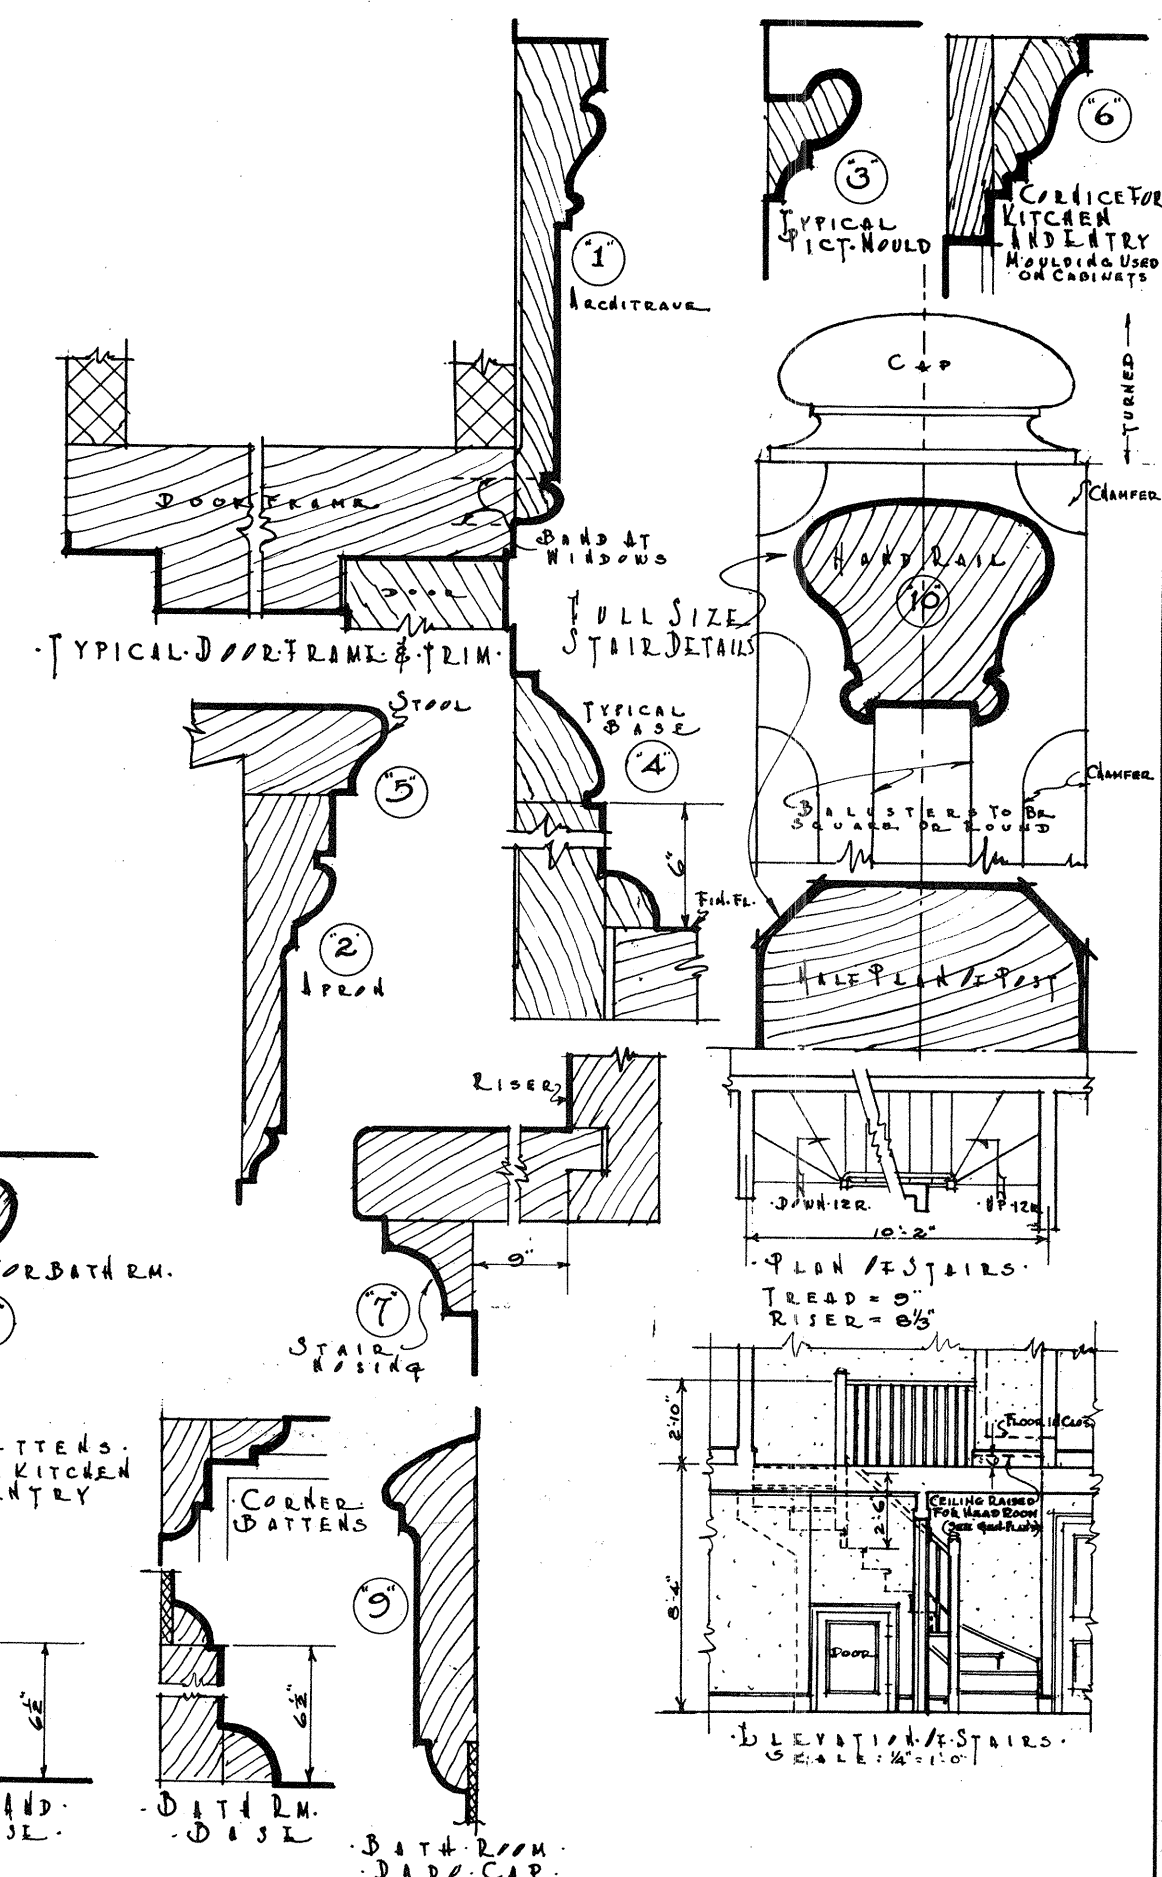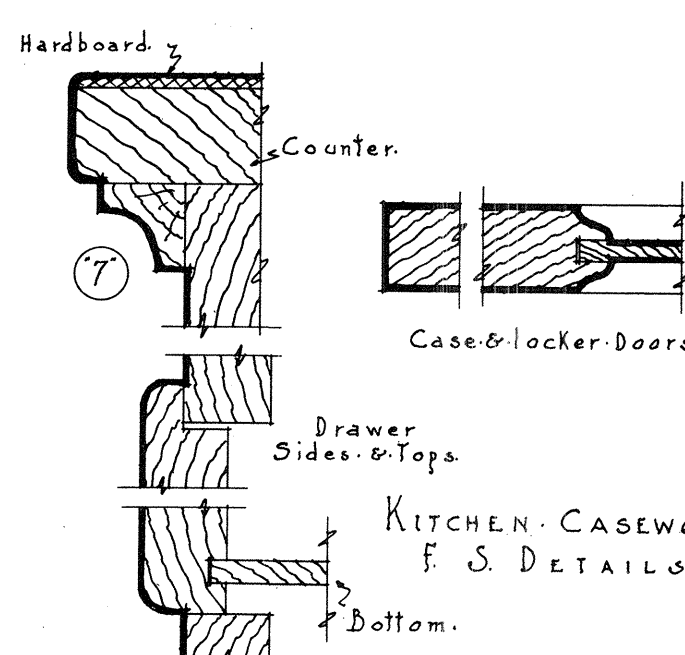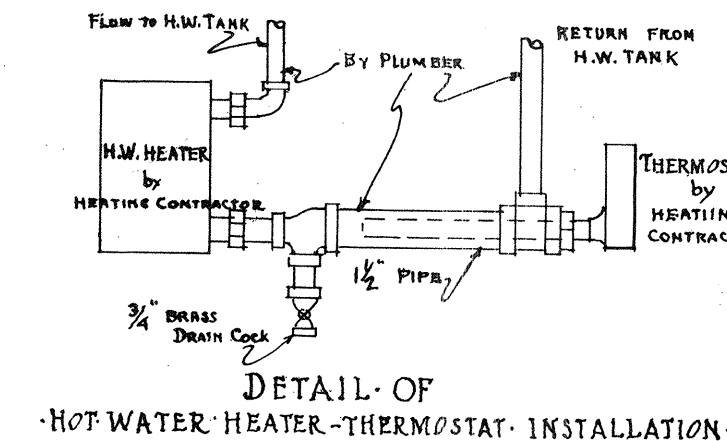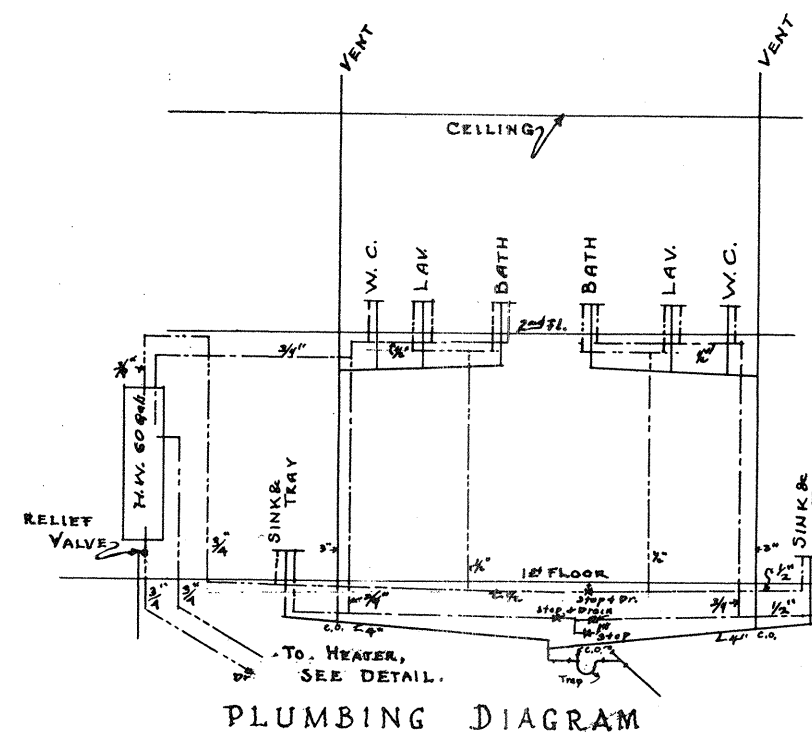

MASSACHUSETTS TIDAL POWER DEVELOPMENT
TEMPORARY BUILDINGS
TYPE "E-E"
Scale: 1/4" = 1'-0"
SHEET 4 OF 5 sheets Date Aug. 1935.
UNITED STATES ENGINEER OFFICE
EASTPORT, MAINE
JOHN P. THOMAS, A.E.C.
ARCHITECT
PORTLAND, MAINE
Submitted by [Signature]
Approved [Signature]
MAJOR C. E. USA
DISTRICT ENGINEER