




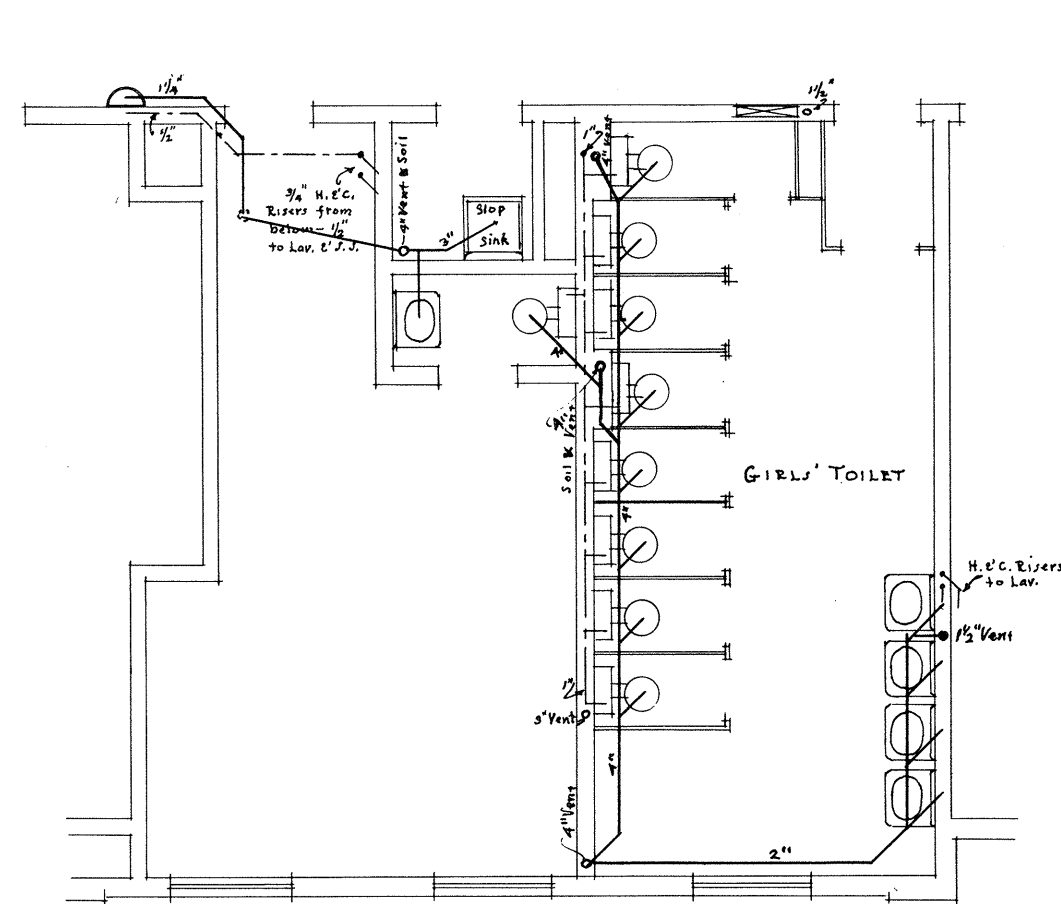


SECOND FLOOR PLAN

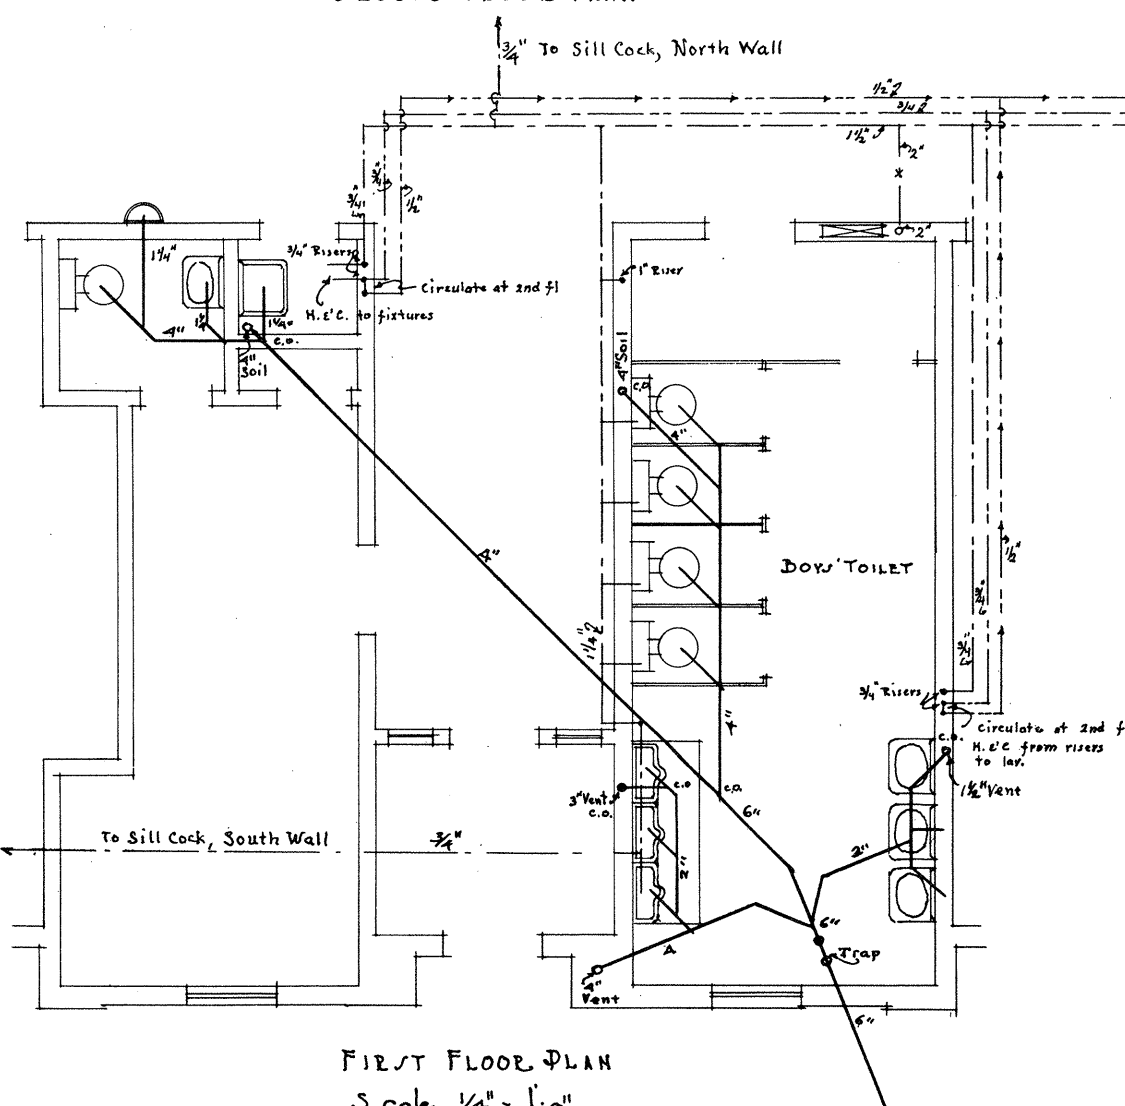

FIRST FLOOR PLAN
Scale 1/4" = 1'-0"

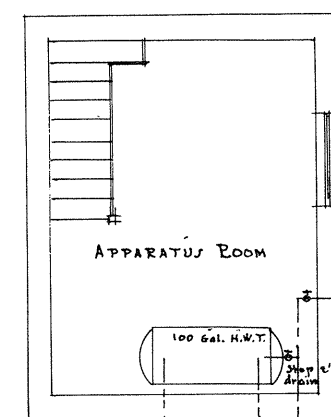

APPARATUS ROOM

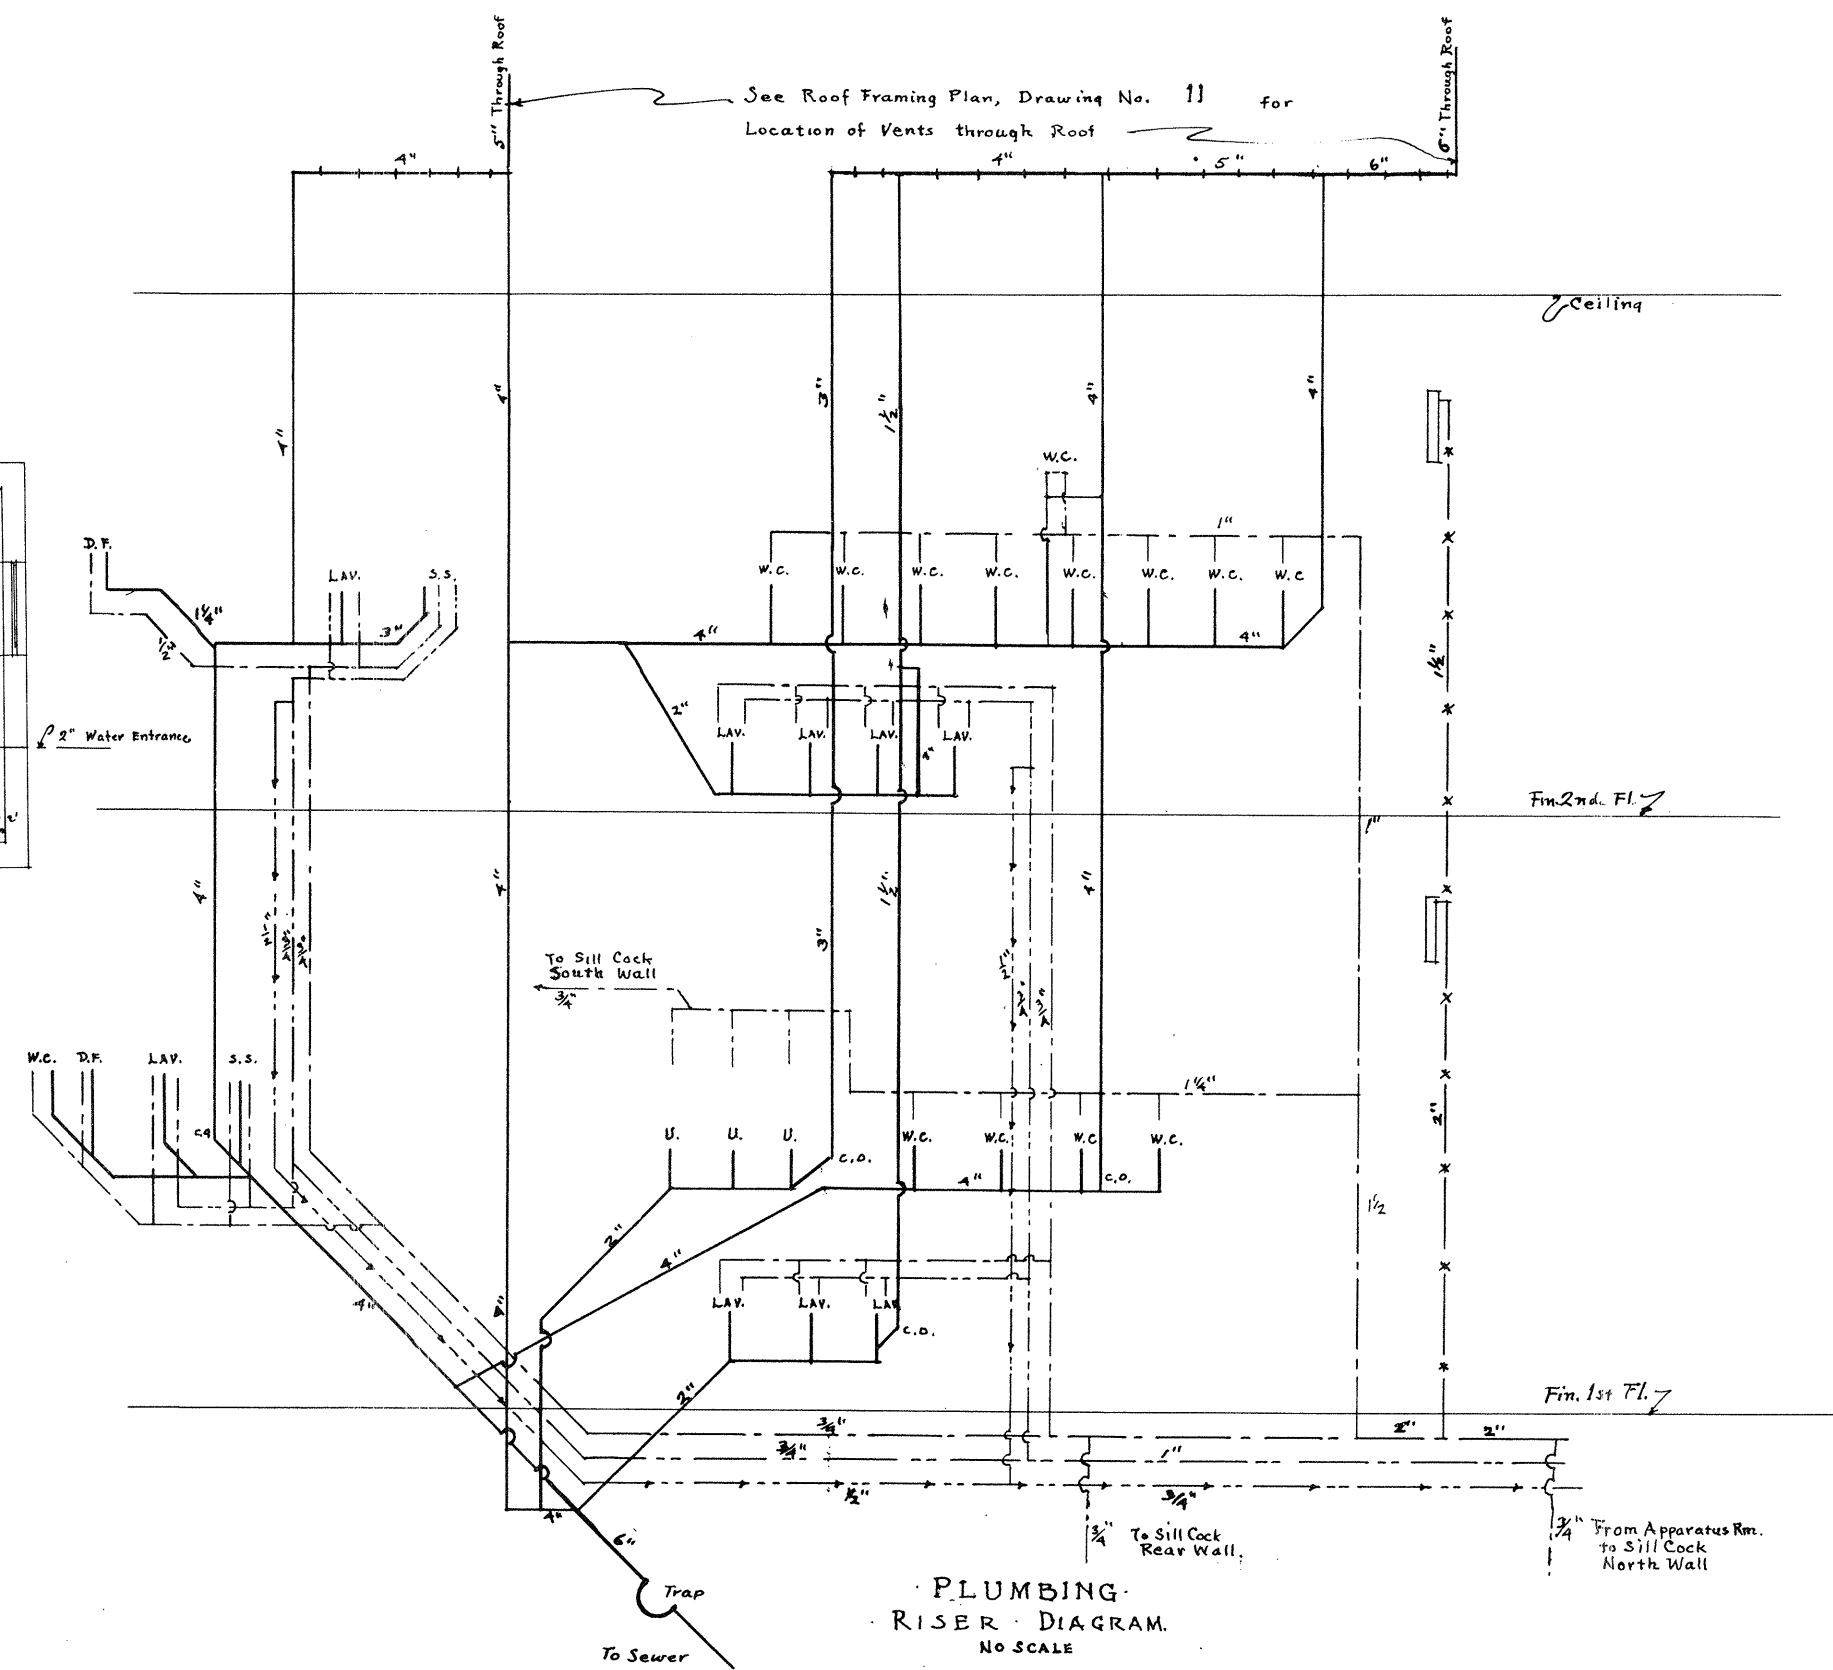

PLUMBING
RISER DIAGRAM
NO SCALE

NOTE: See First Floor Plan, Drawing No. 1 for Location of Sill Cocks.

SCHEDULE OF PLUMBING SYMBOLS

—	Soil Lines
---	Cold Water supply
- - -	Hot Water supply
- - -	Hot Water Return
- - -	Vent Lines in Roof Space
- - -	Fire Lines
- - -	Sink Drains
- - -	Hot & Cold Water Supply
- - -	Sill Cock
- - -	Hose Cabinet

PLUMBING

PASSAMAQUODDY BAY
TIDAL POWER DEVELOPMENT
TEMPORARY BUILDINGS
SCHOOL HOUSE
Sheet # 12 of 15 sheets Date Oct. 4, 36
UNITED STATES ENGINEER OFFICE
EASTPORT, MAINE
JOHN P. THOMAS, A. I. A.
ARCHITECT
PORTLAND, MAINE
Submitted by [Signature]
Approved [Signature]
DISTRICT ENGINEER