


SYMBOL SCHEDULES

PLUMBING


- Soil Lines
- Cold Water supply
- Hot Water Supply
- Hot Water Return
- Sink Drains
- Hot & Cold Water Supply
- H.S.C. Sill Cock
- Vent Lines in Roof Space

ELECTRICAL


- Ceiling Outlet
- Wall Outlet
- Base Receptacle (Duplex)
- Ceiling Outlet for Unit Heater
- Wall Switch, S3, Three-way Switch
- Ceiling Light controlled by Switch
- Switch & Distribution Panel
- Bell Outlet
- Bell Push Button
- Floor Plug
- Power Outlet
- Wall Outlet
- Switch Line
- Circuit Number
- 2 #12 Wire BX
- 3 #12 Wire BX

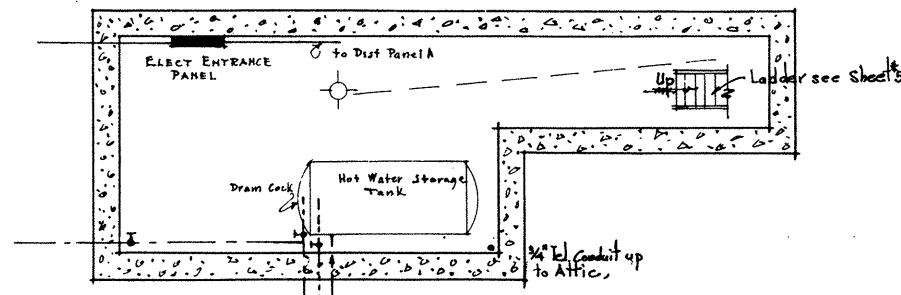


PLAN OF APP. ROOM
Scale 1/4" = 1'-0"

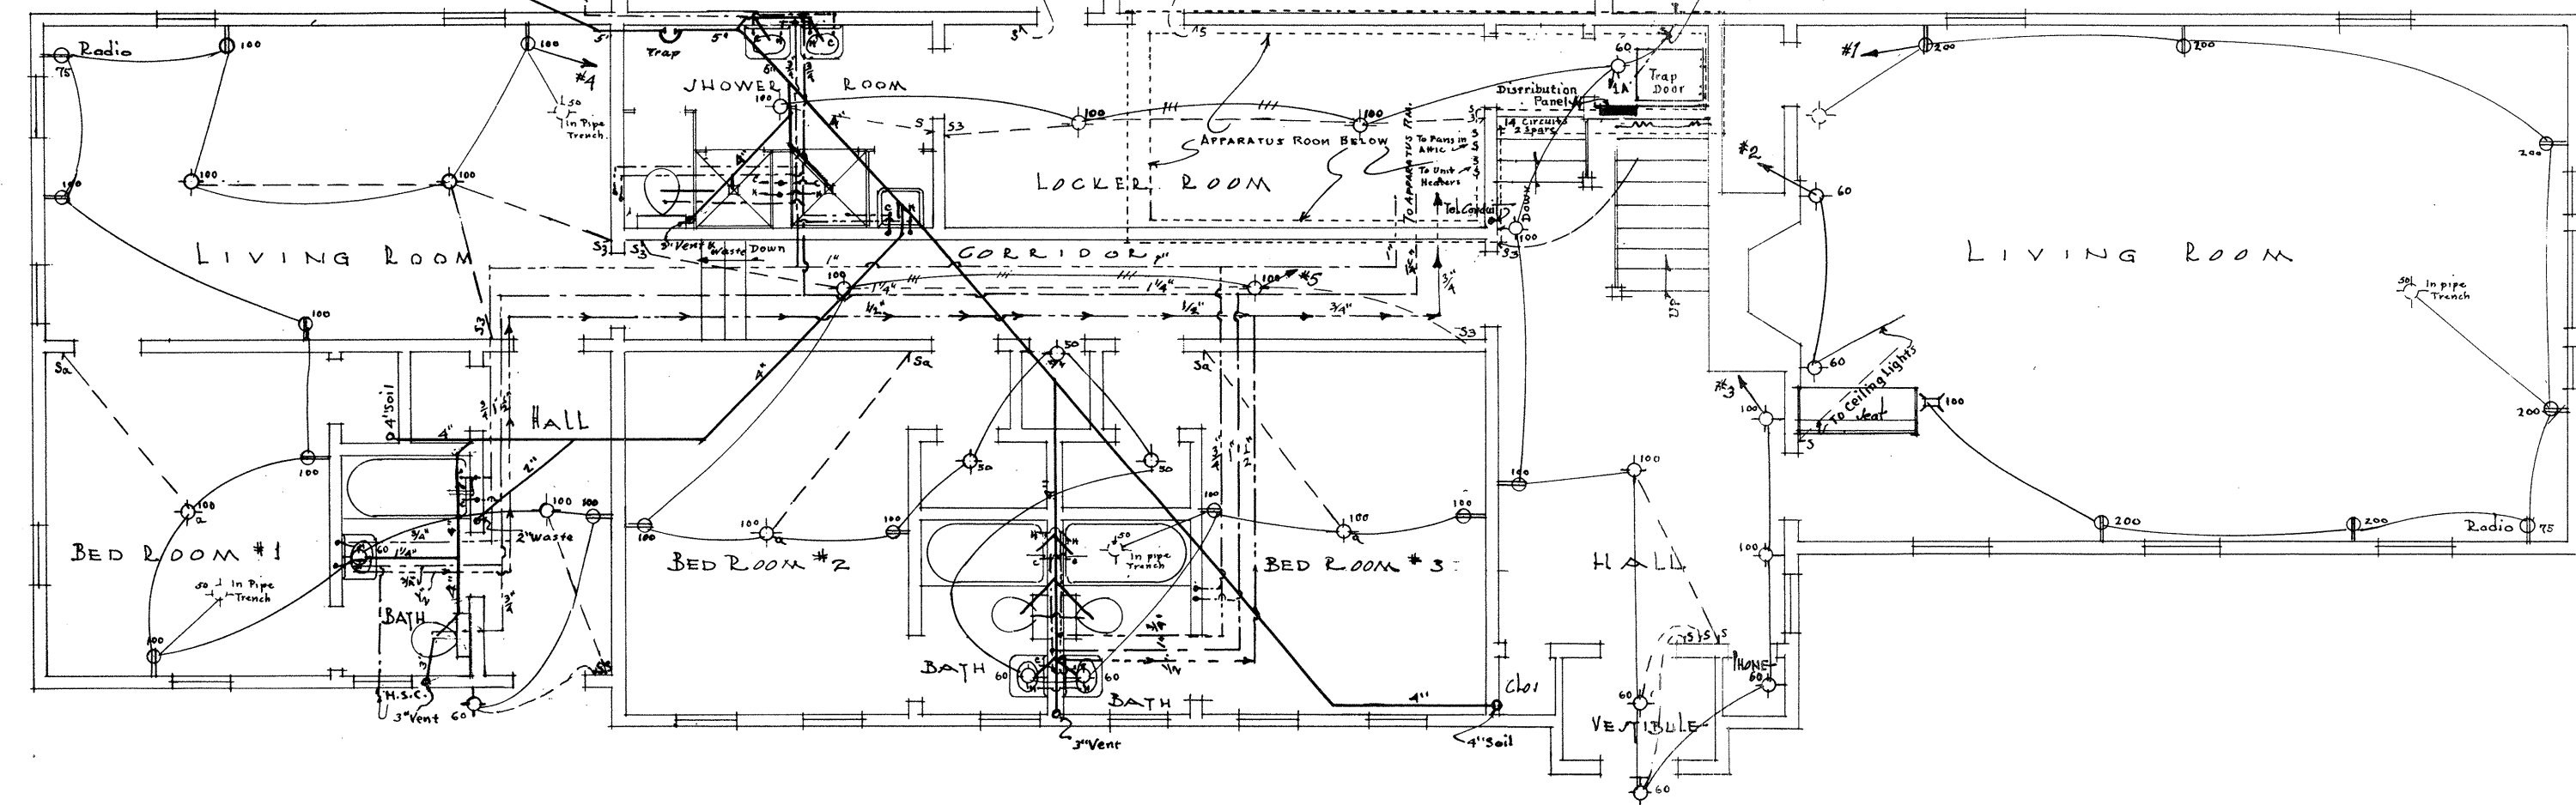

ELECTRICAL & PLUMBING
FIRST FLOOR PLAN
SCALE 1/4" = 1'-0"

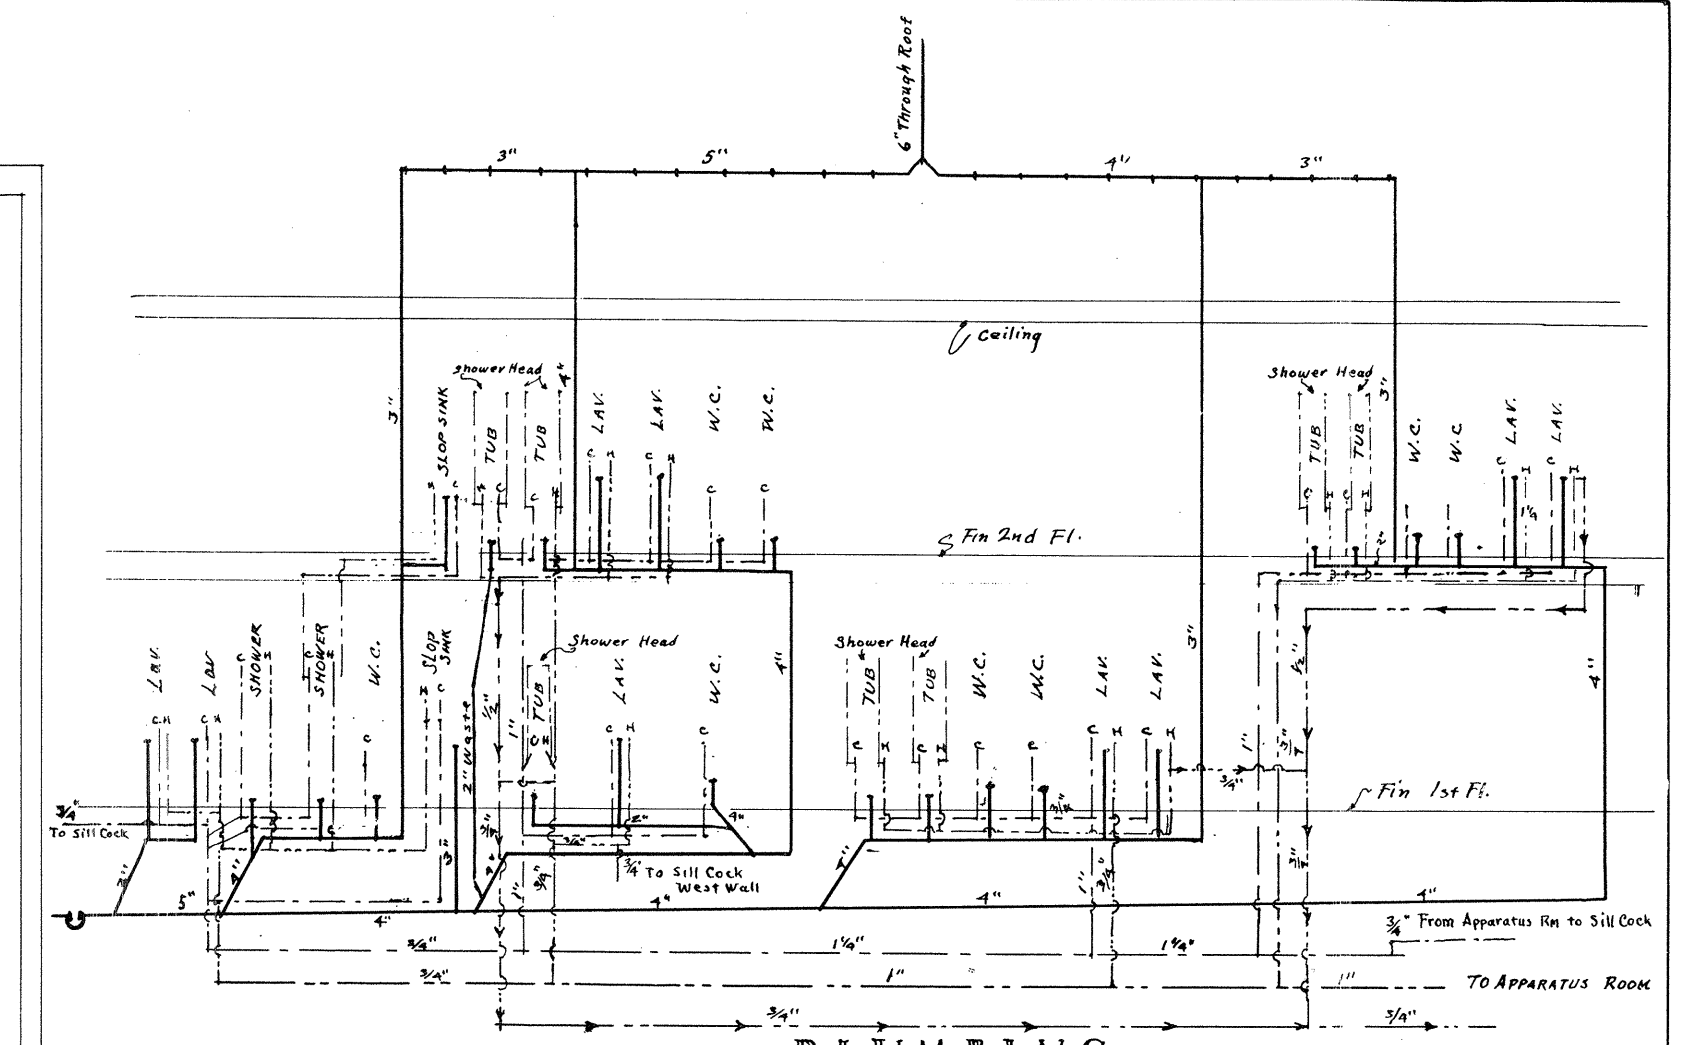

PLUMBING RISER DIAGRAM
NO SCALE

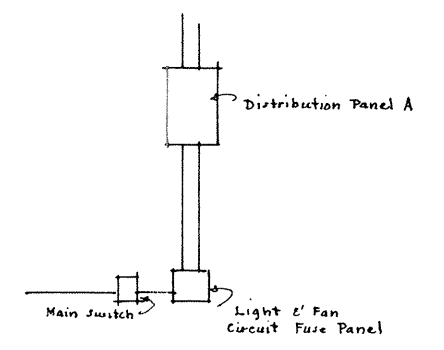

ELECTRICAL RISER DIAGRAM
NO SCALE

PASADENA COUNTY ELY
TIDAL POWER PLANT
TEMPORARY BUILDING
GUEST HOUSE
Sheet 11 of 15
UNLESS OTHERWISE SPECIFIED
JOHN B. ...
Submittal
Approved